




Generator Detail
NO SCALE REF: NA C5

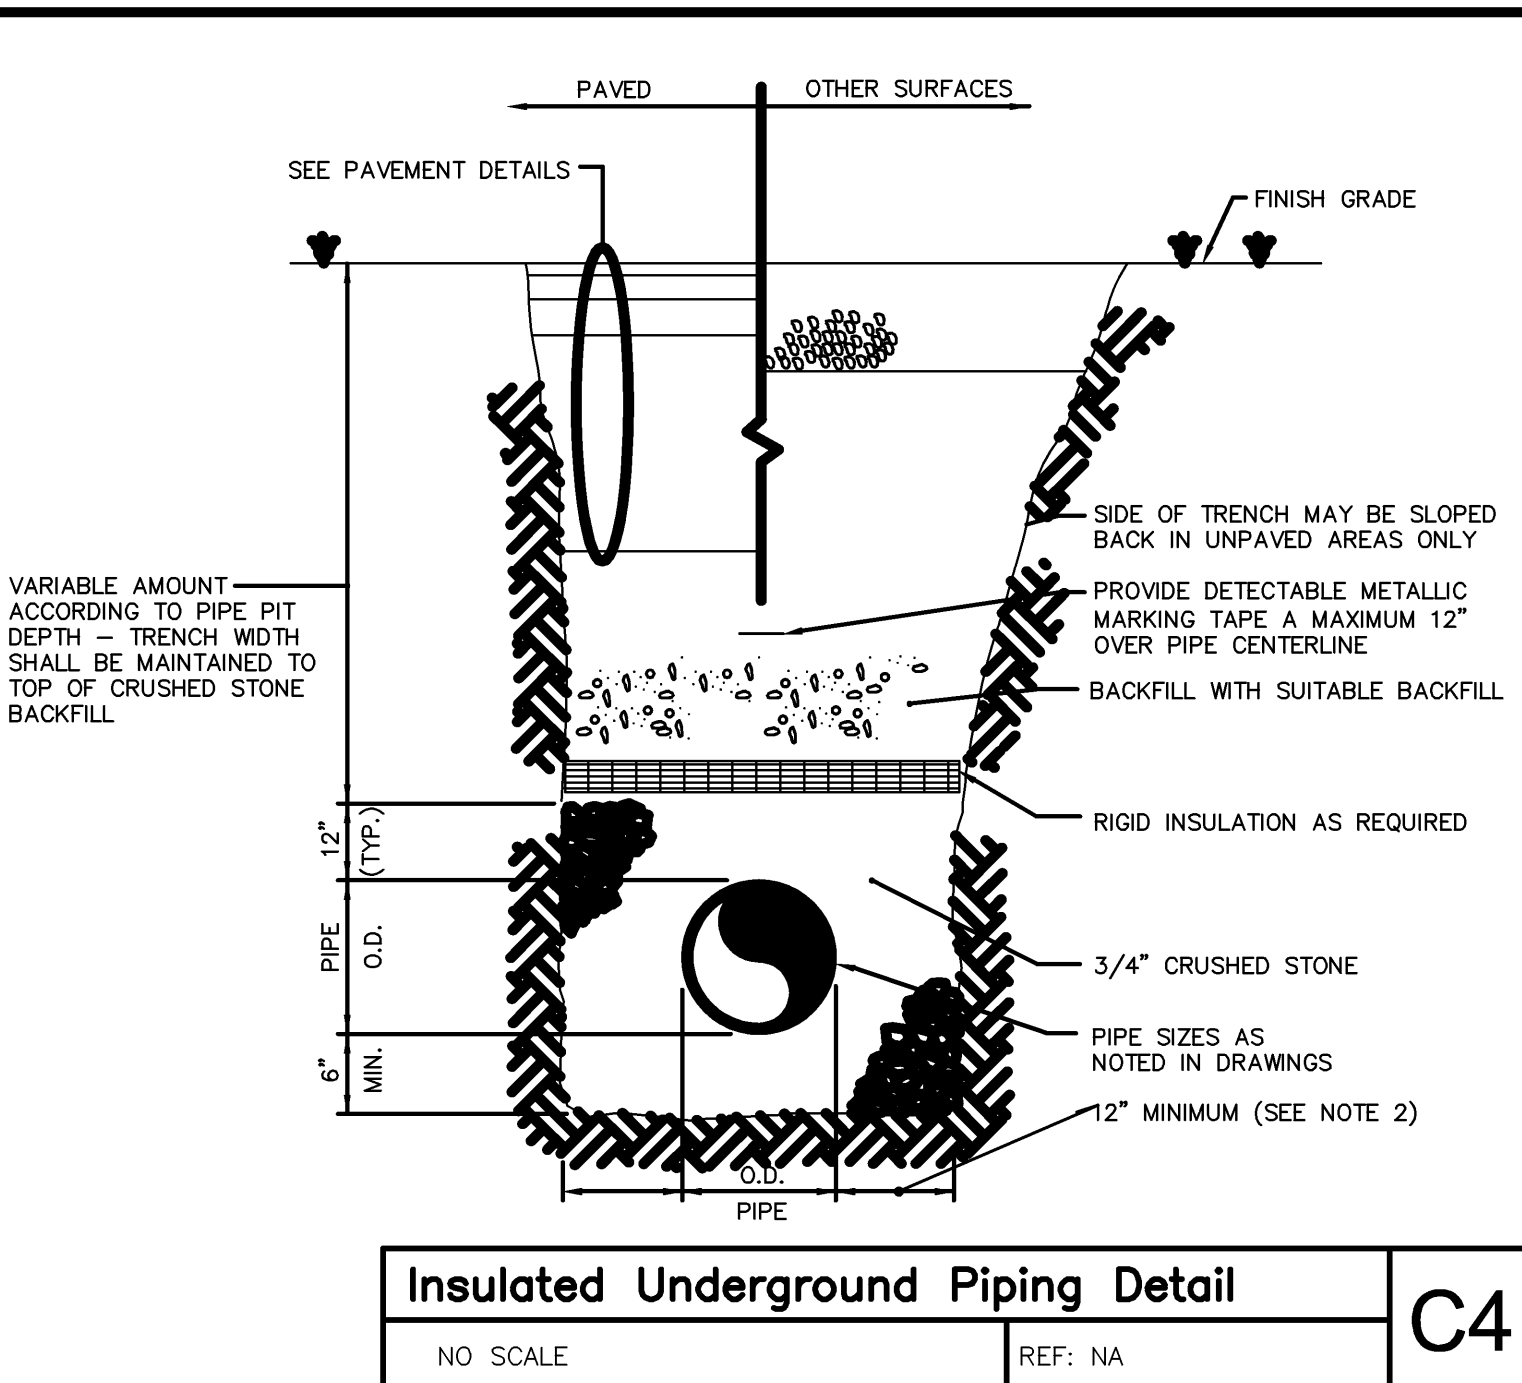


Insulated Underground Piping Detail
NO SCALE REF: NA C4

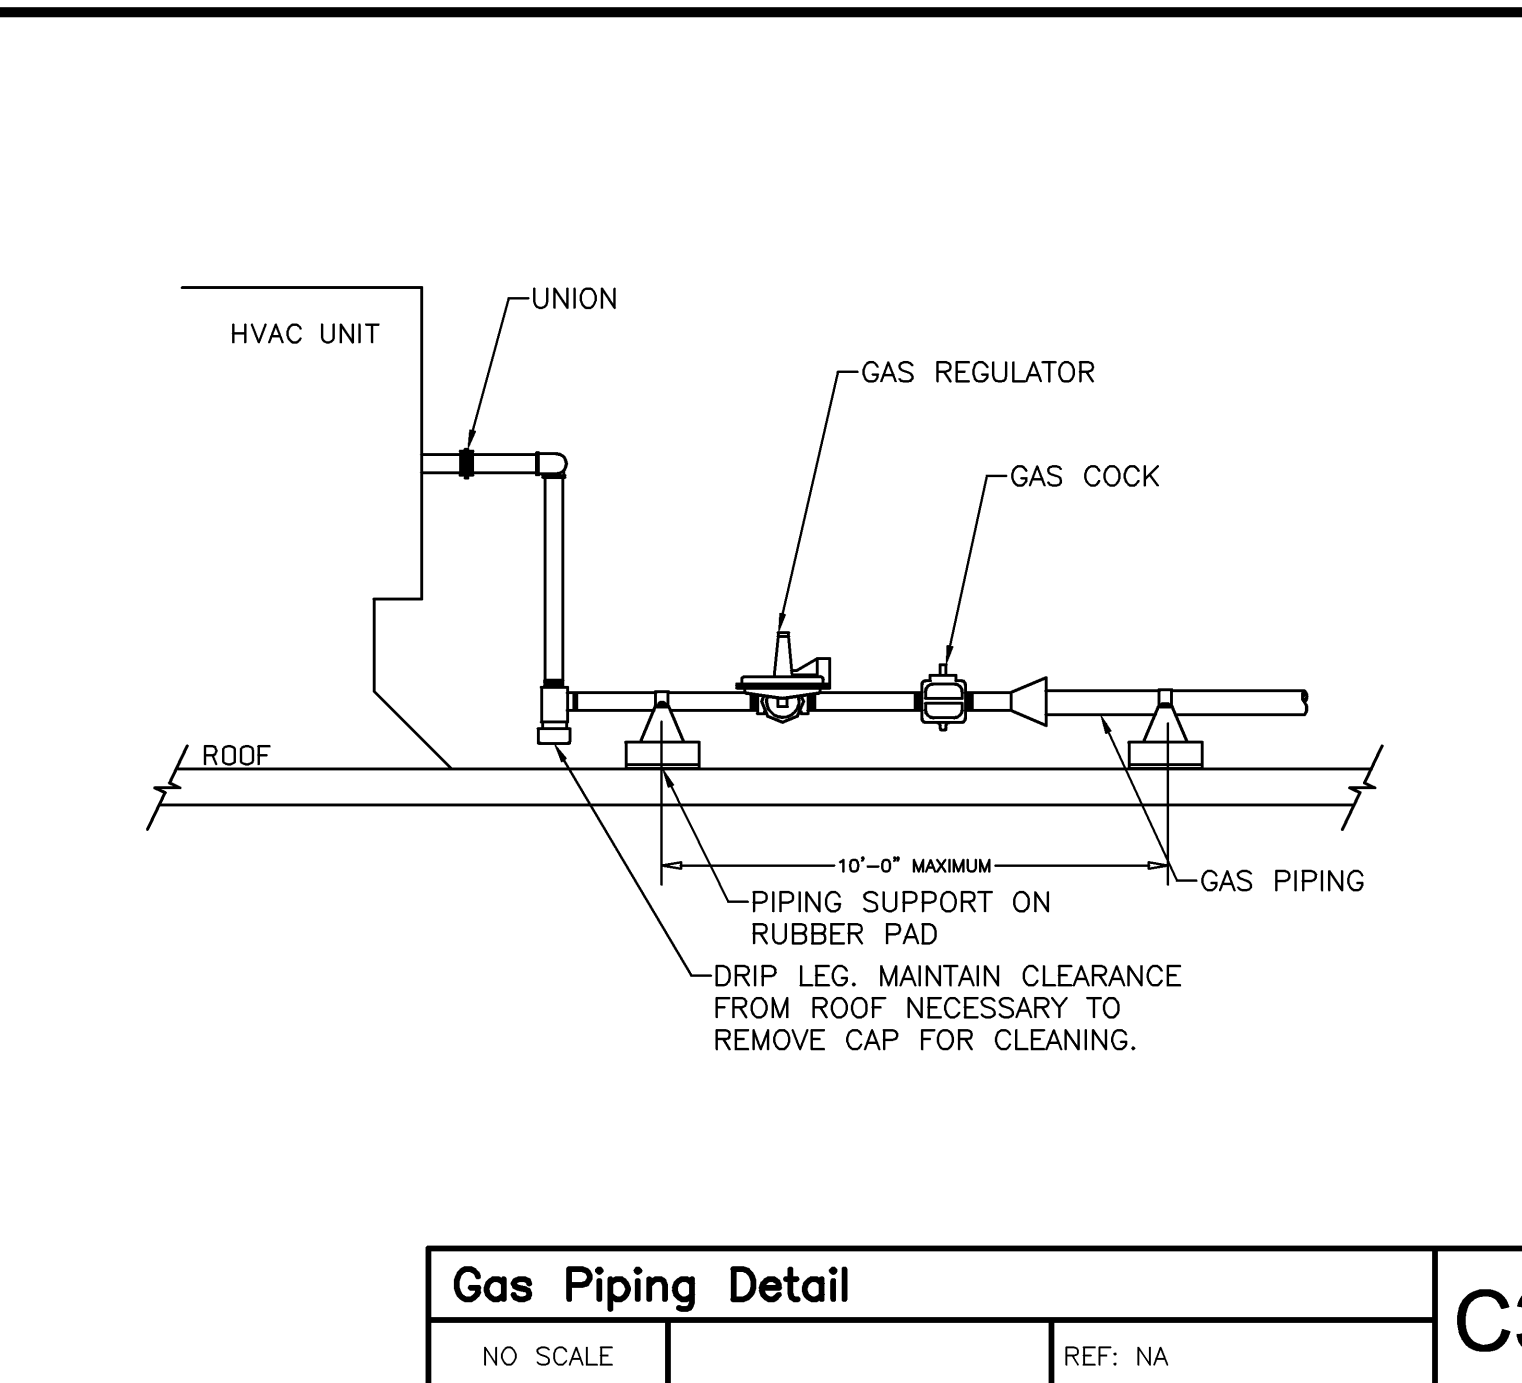


Gas Piping Detail
NO SCALE REF: NA C3

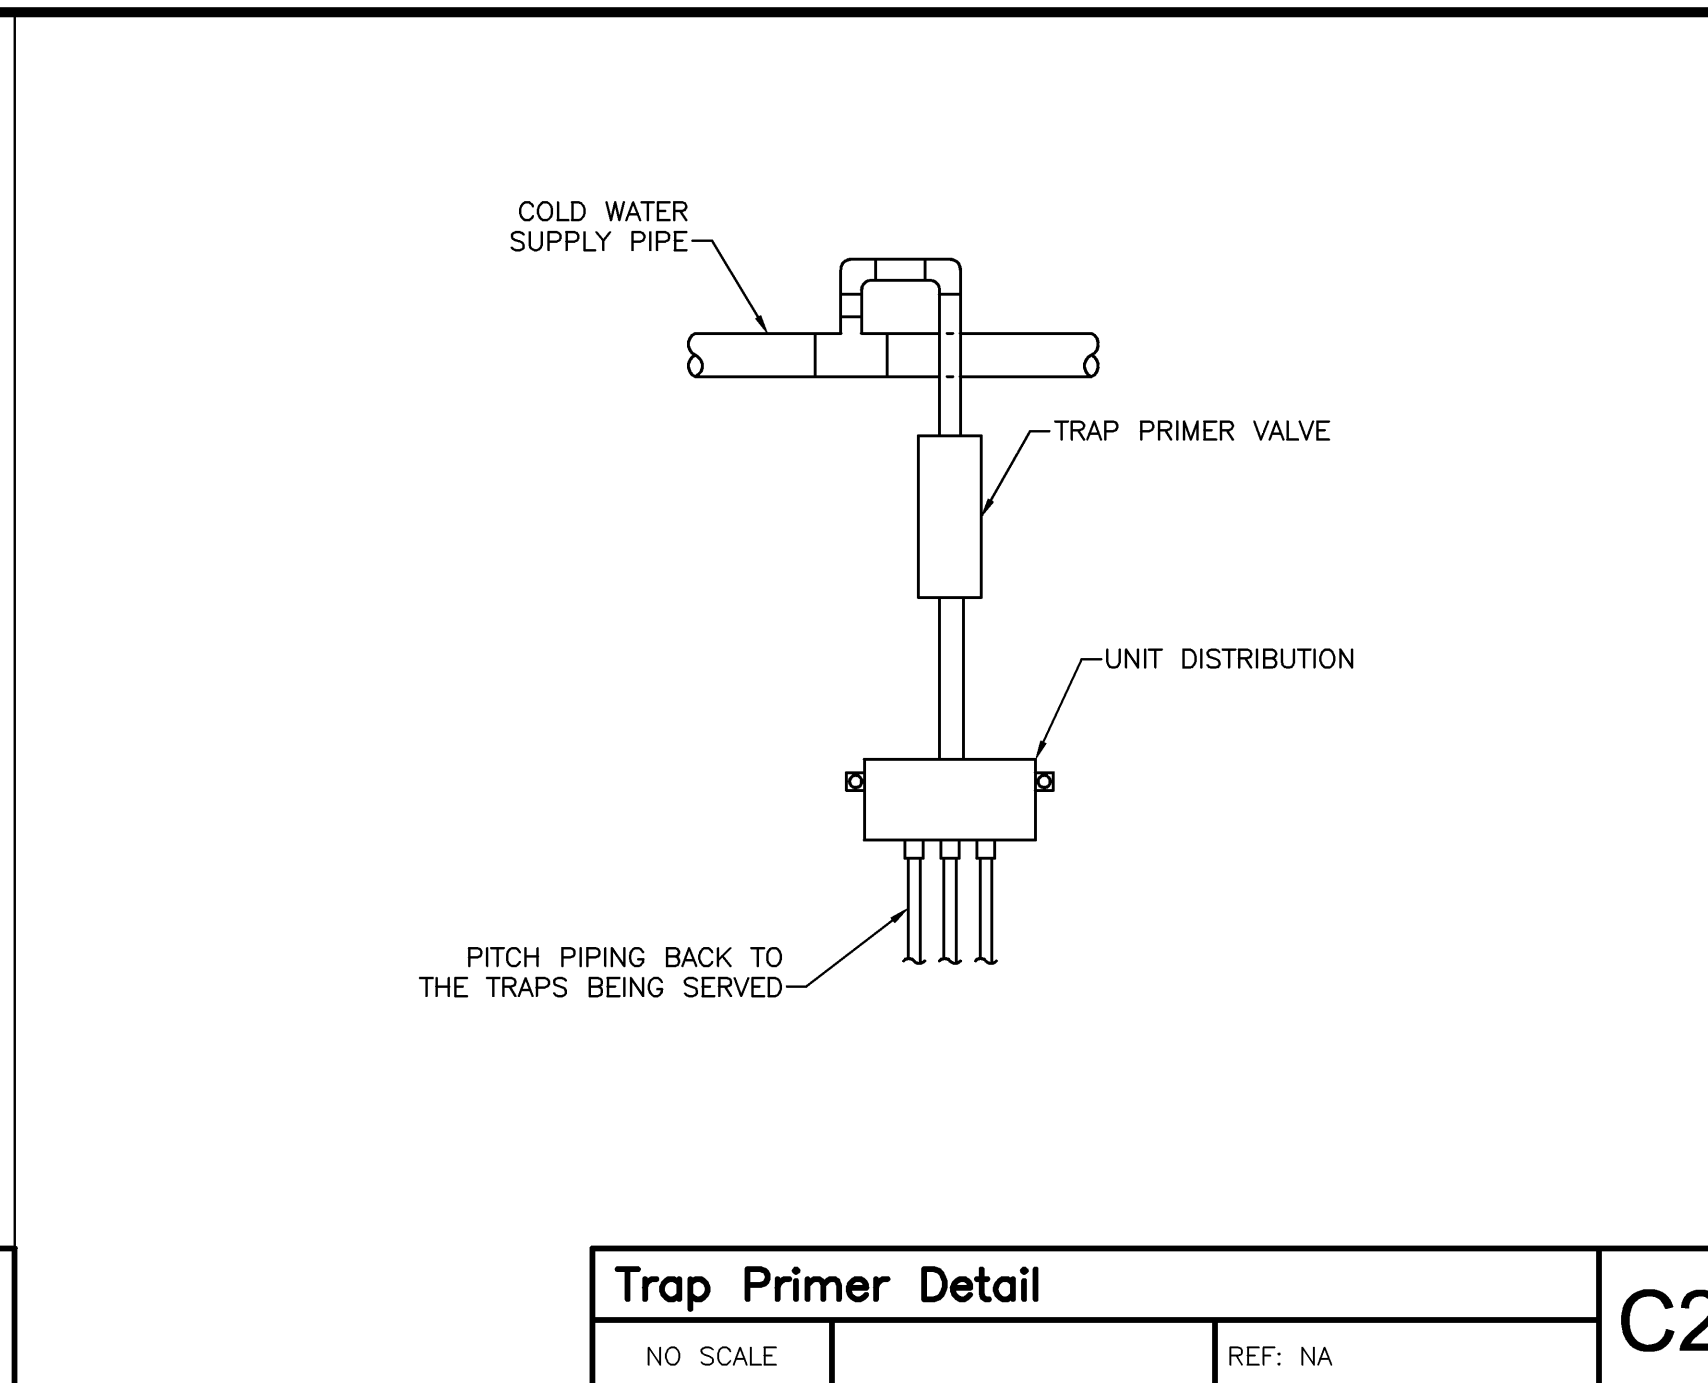


Trap Primer Detail
NO SCALE REF: NA C2

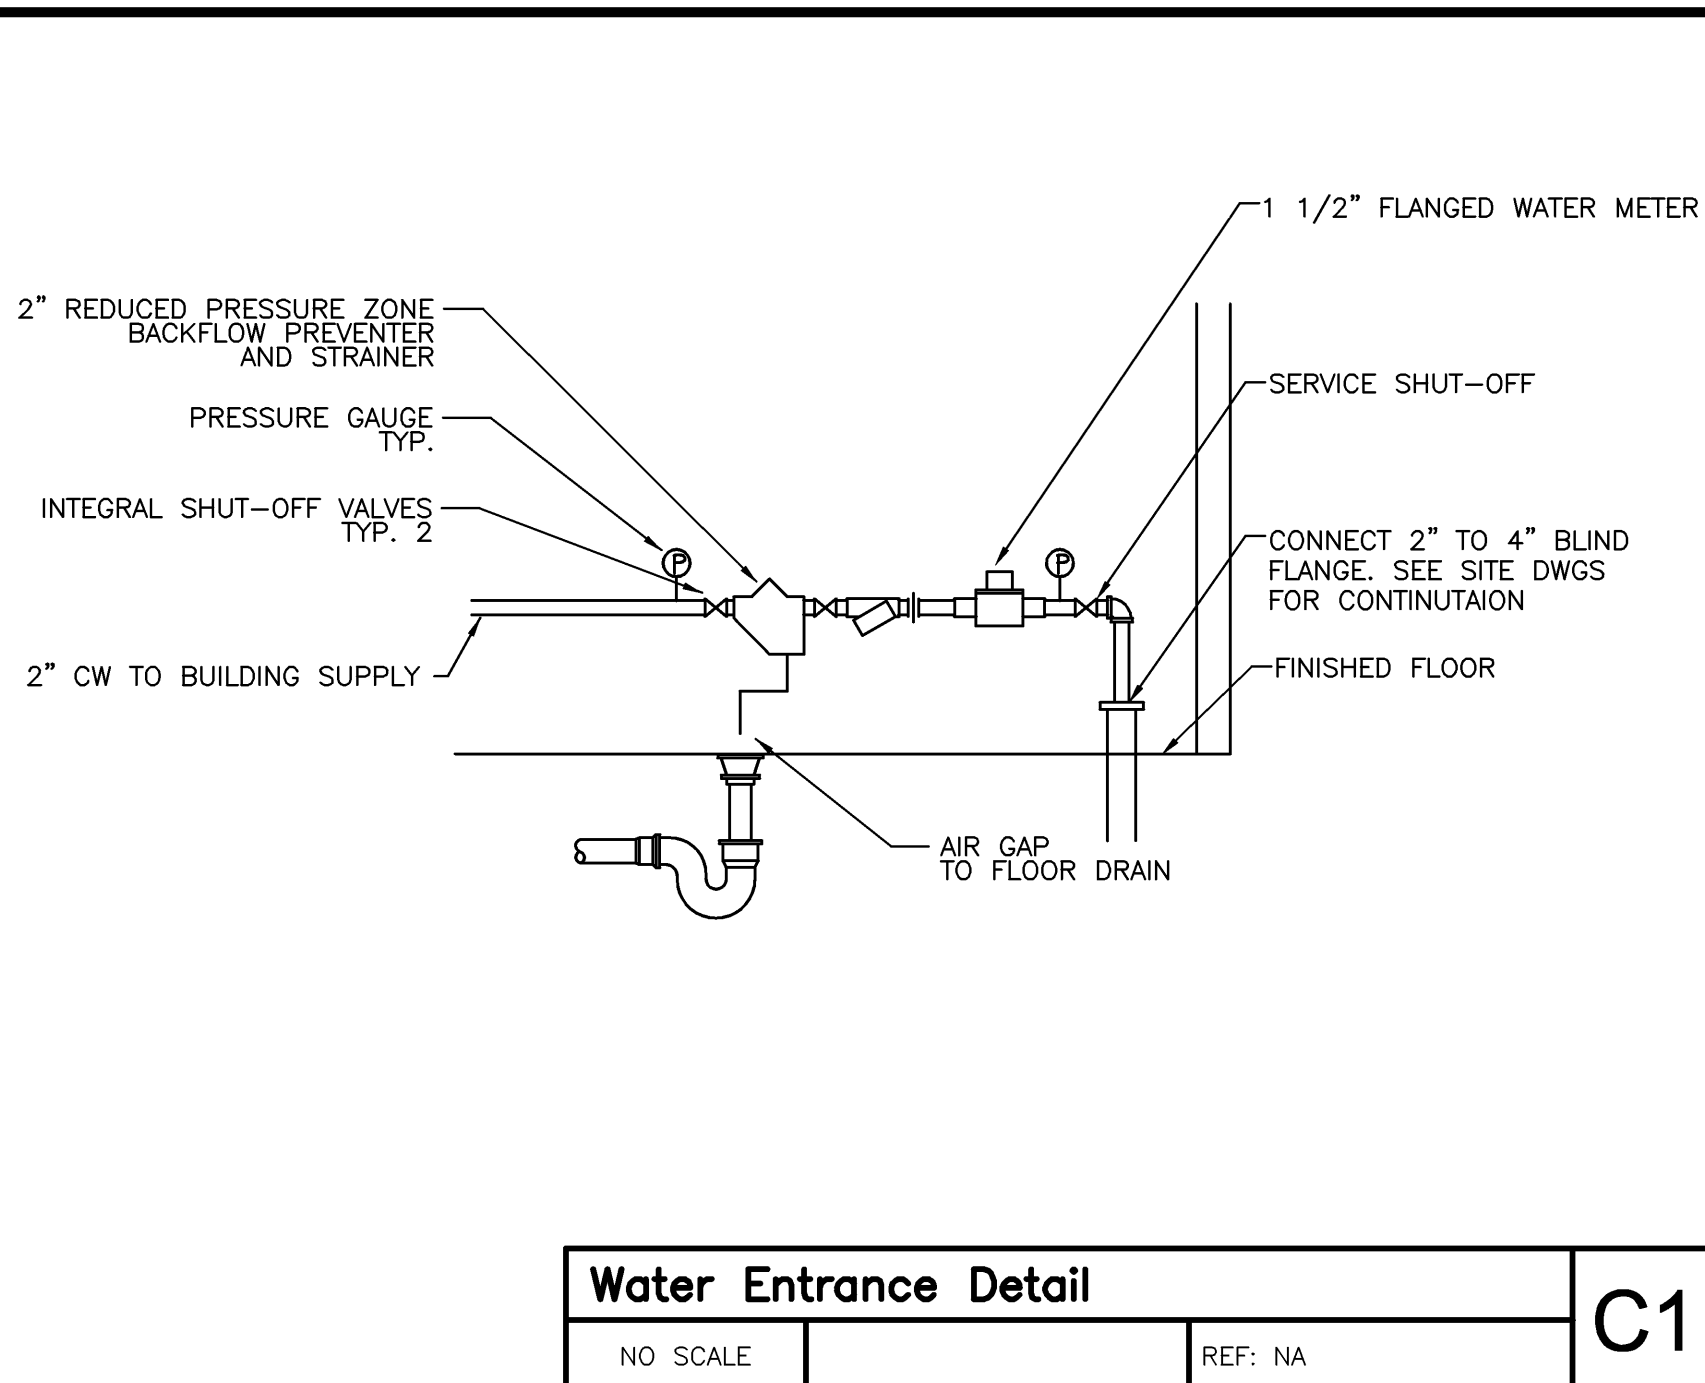


Water Entrance Detail
NO SCALE REF: NA C1

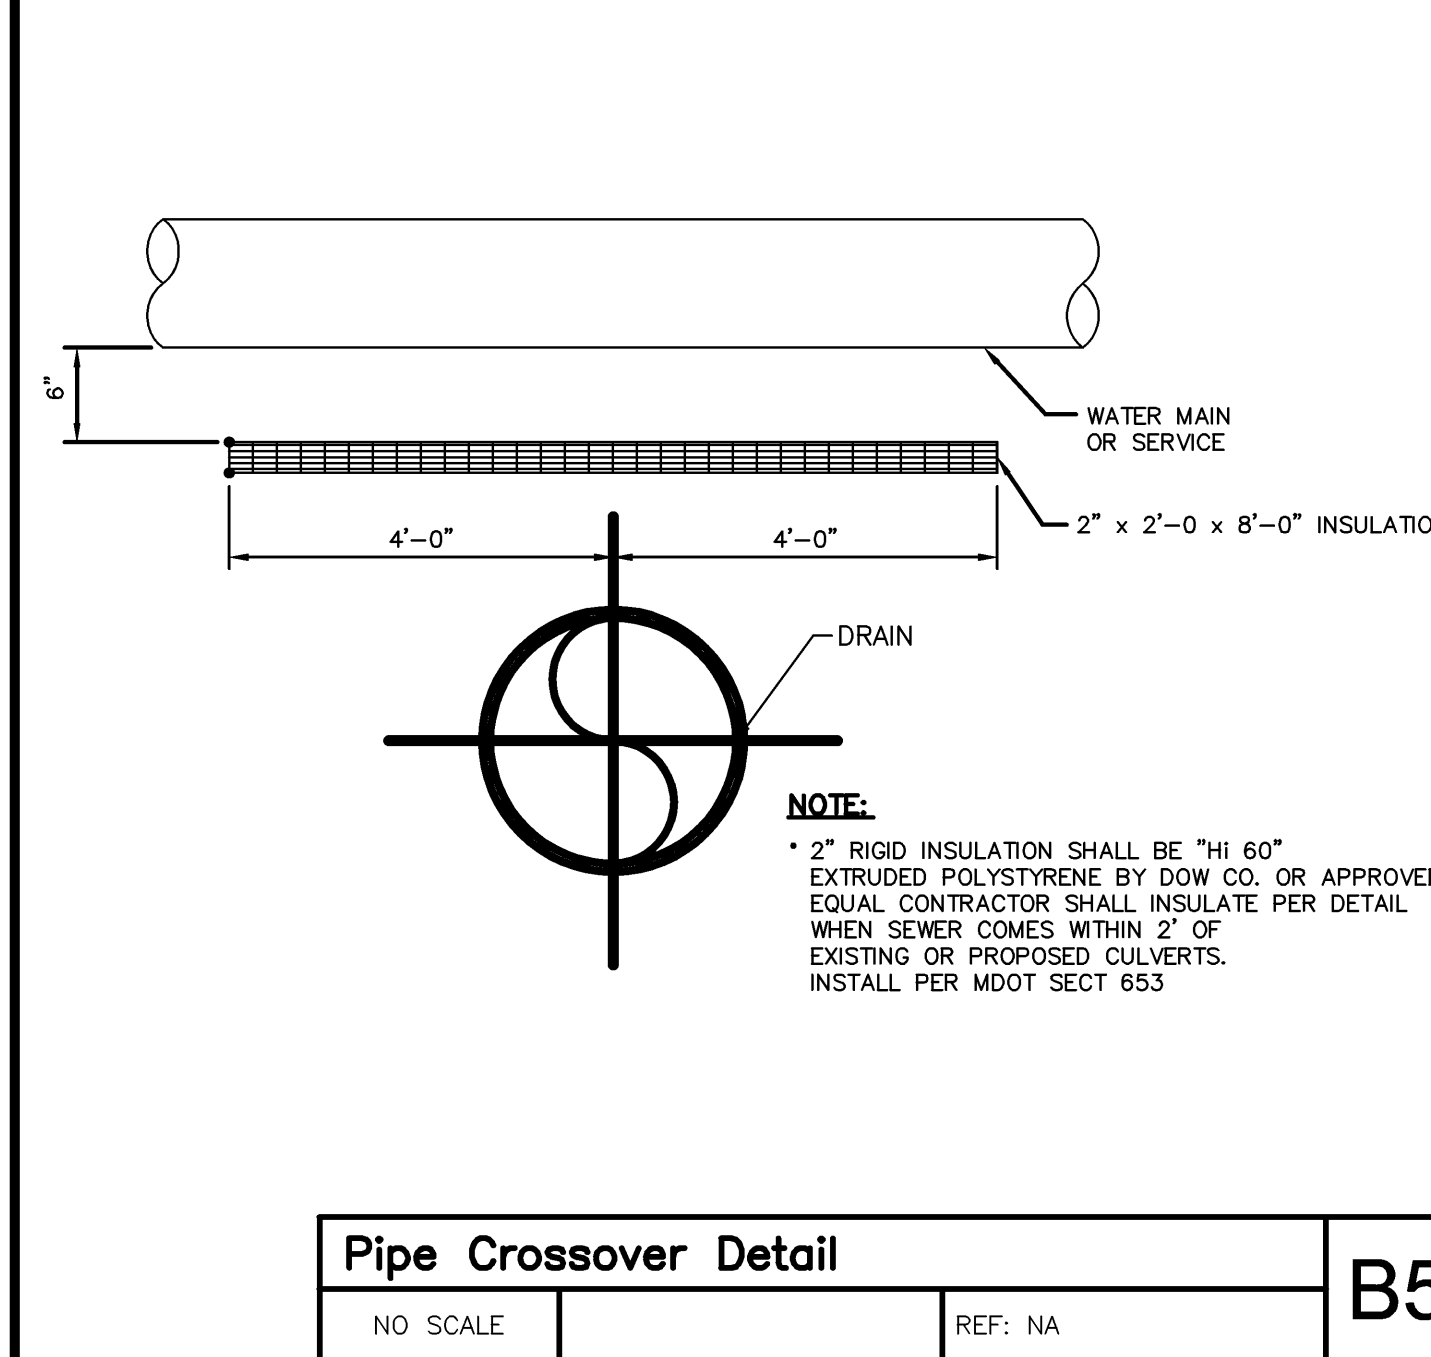


Pipe Crossover Detail
NO SCALE REF: NA B5

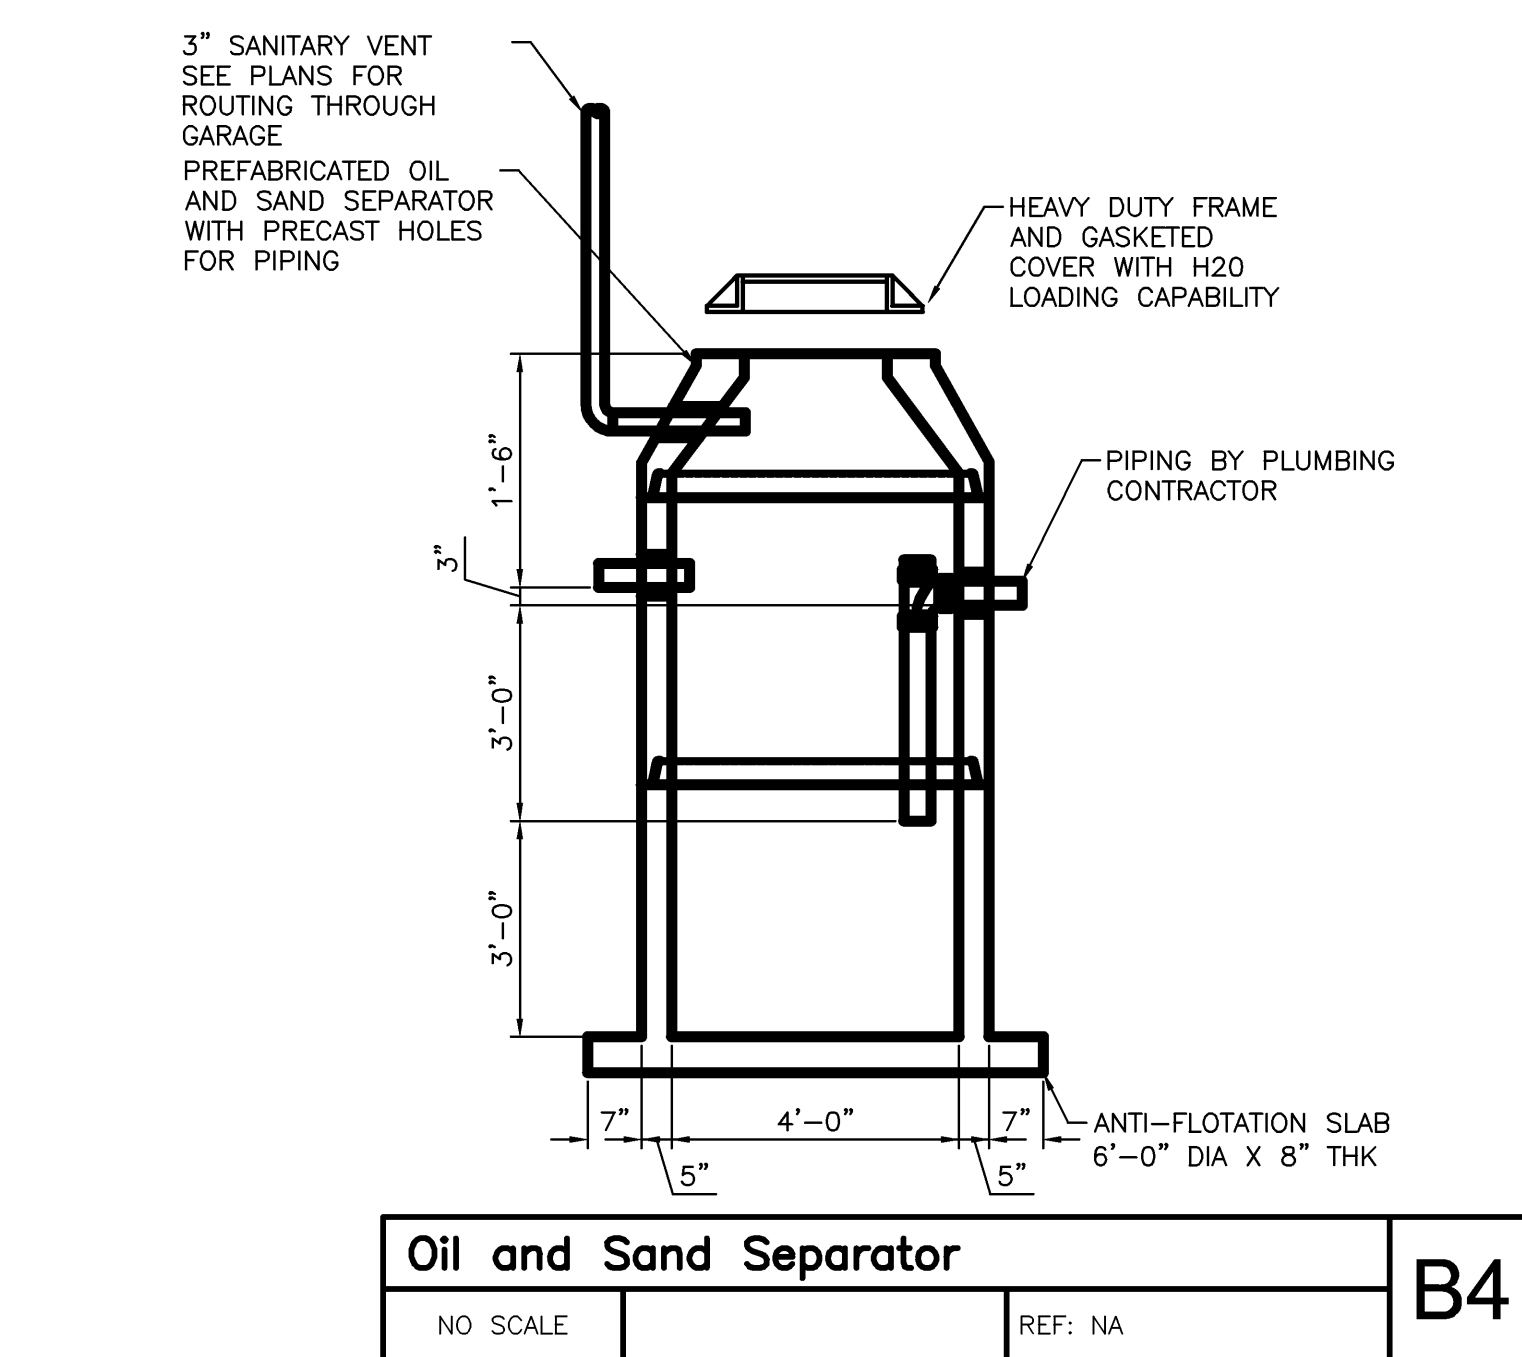


Oil and Sand Separator
NO SCALE REF: NA B4

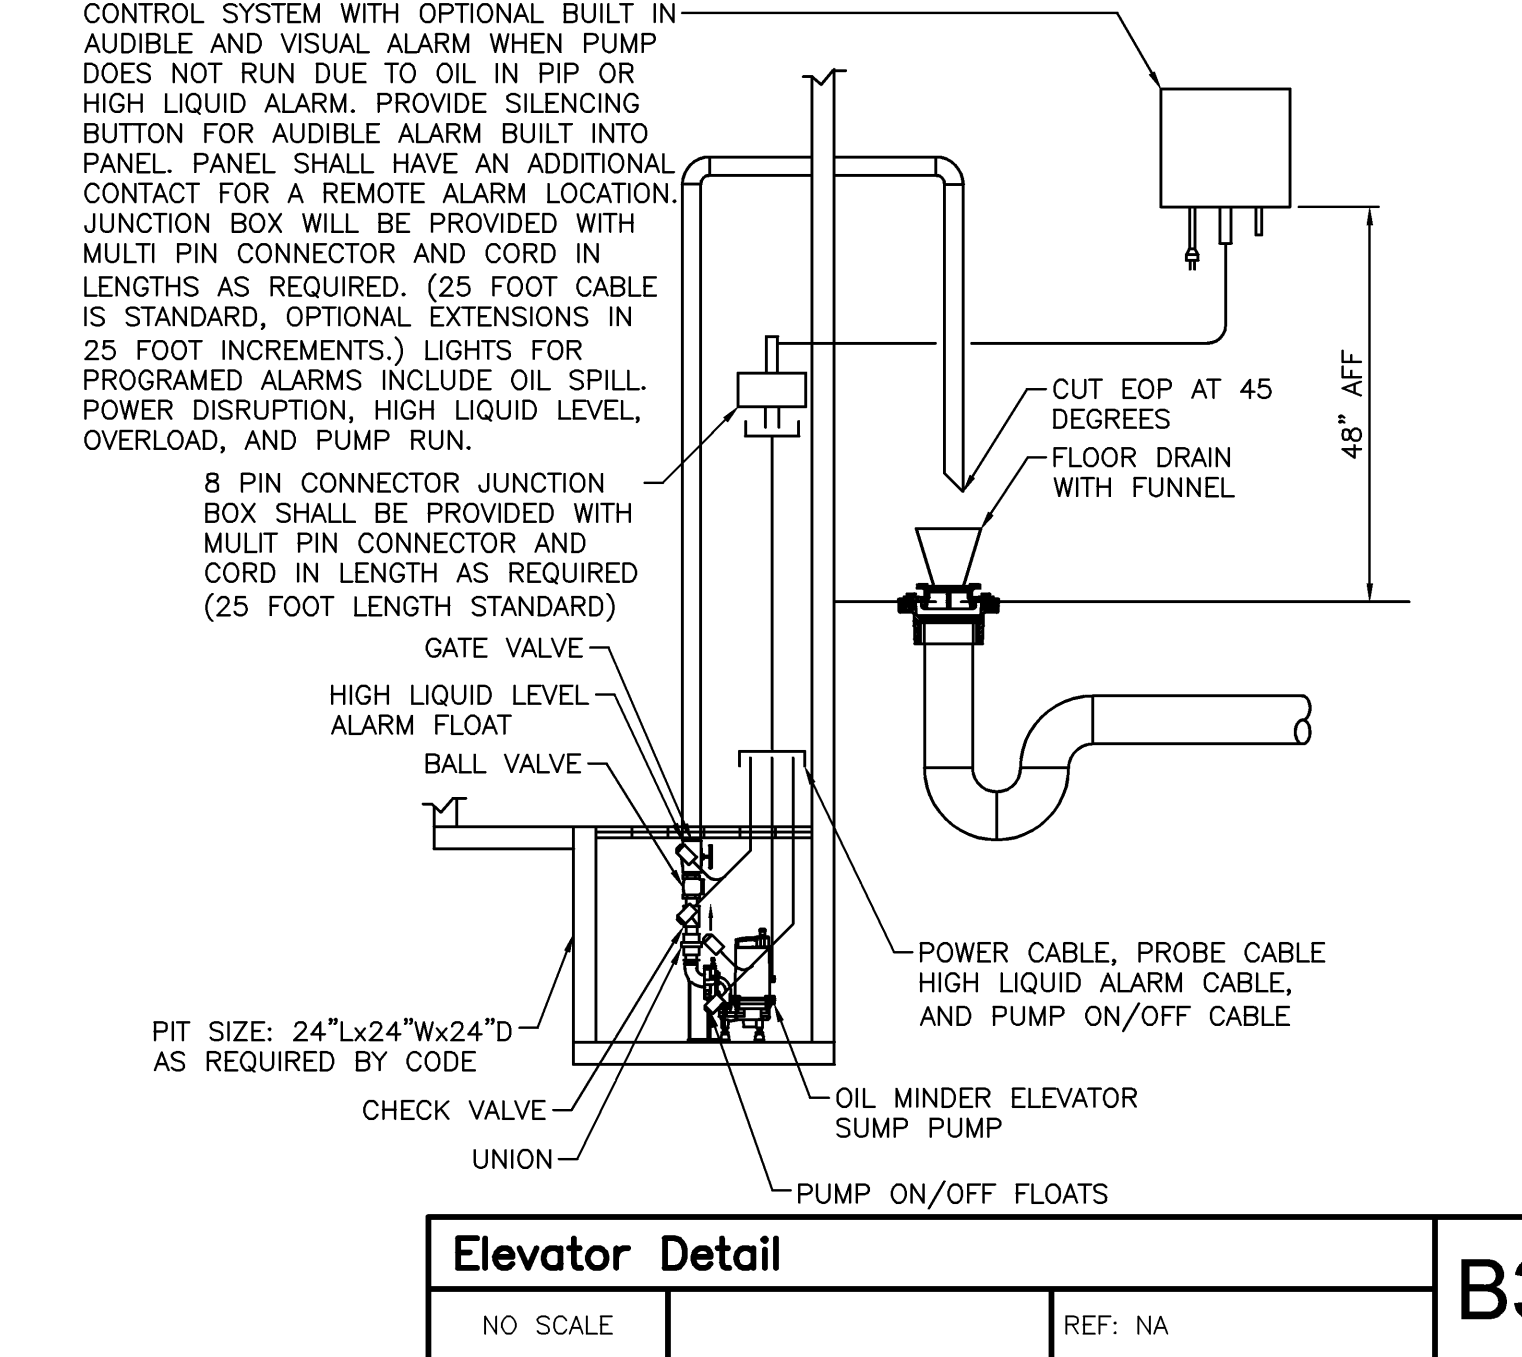


Elevator Detail
NO SCALE REF: NA B3

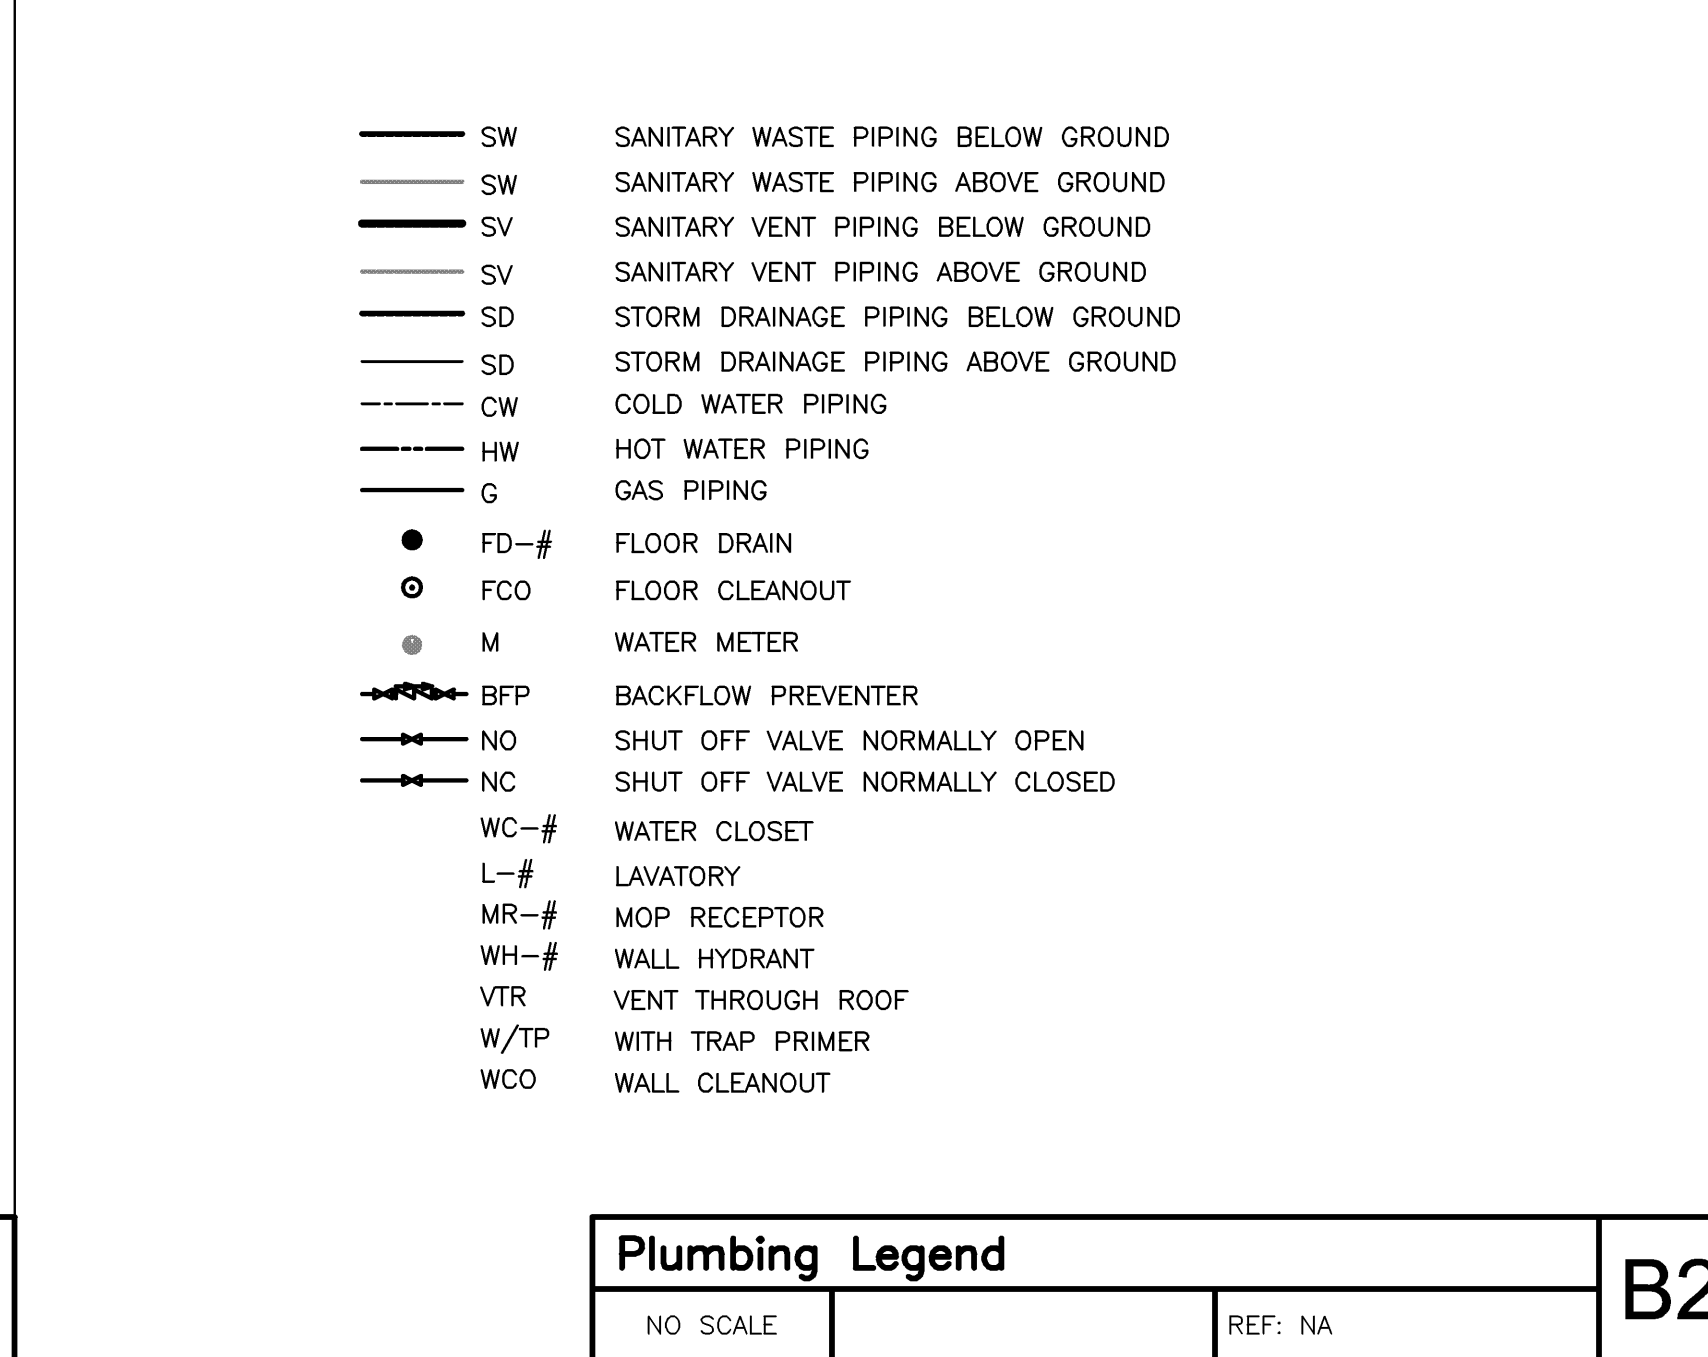


Plumbing Legend
NO SCALE REF: NA B2

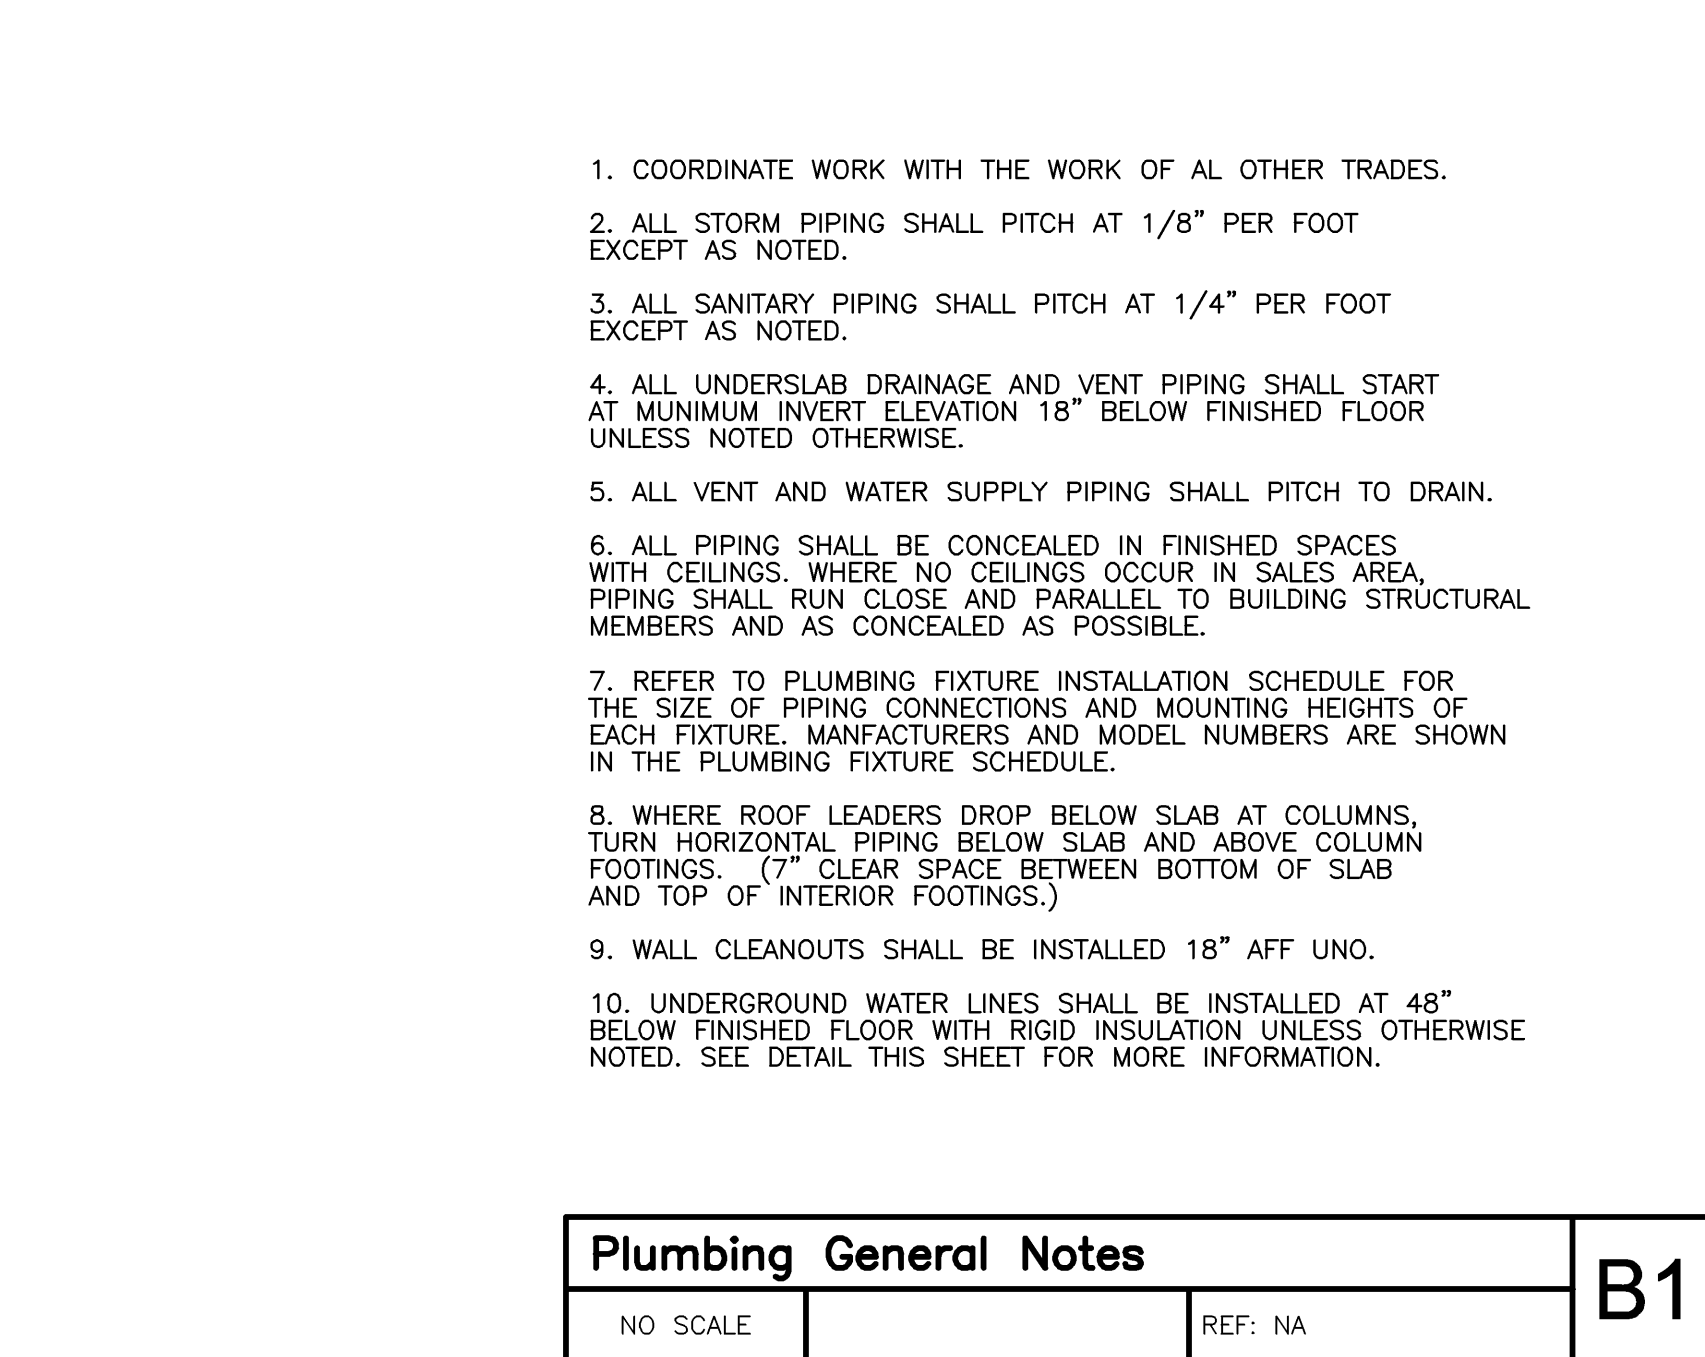

Plumbing General Notes
NO SCALE REF: NA B1

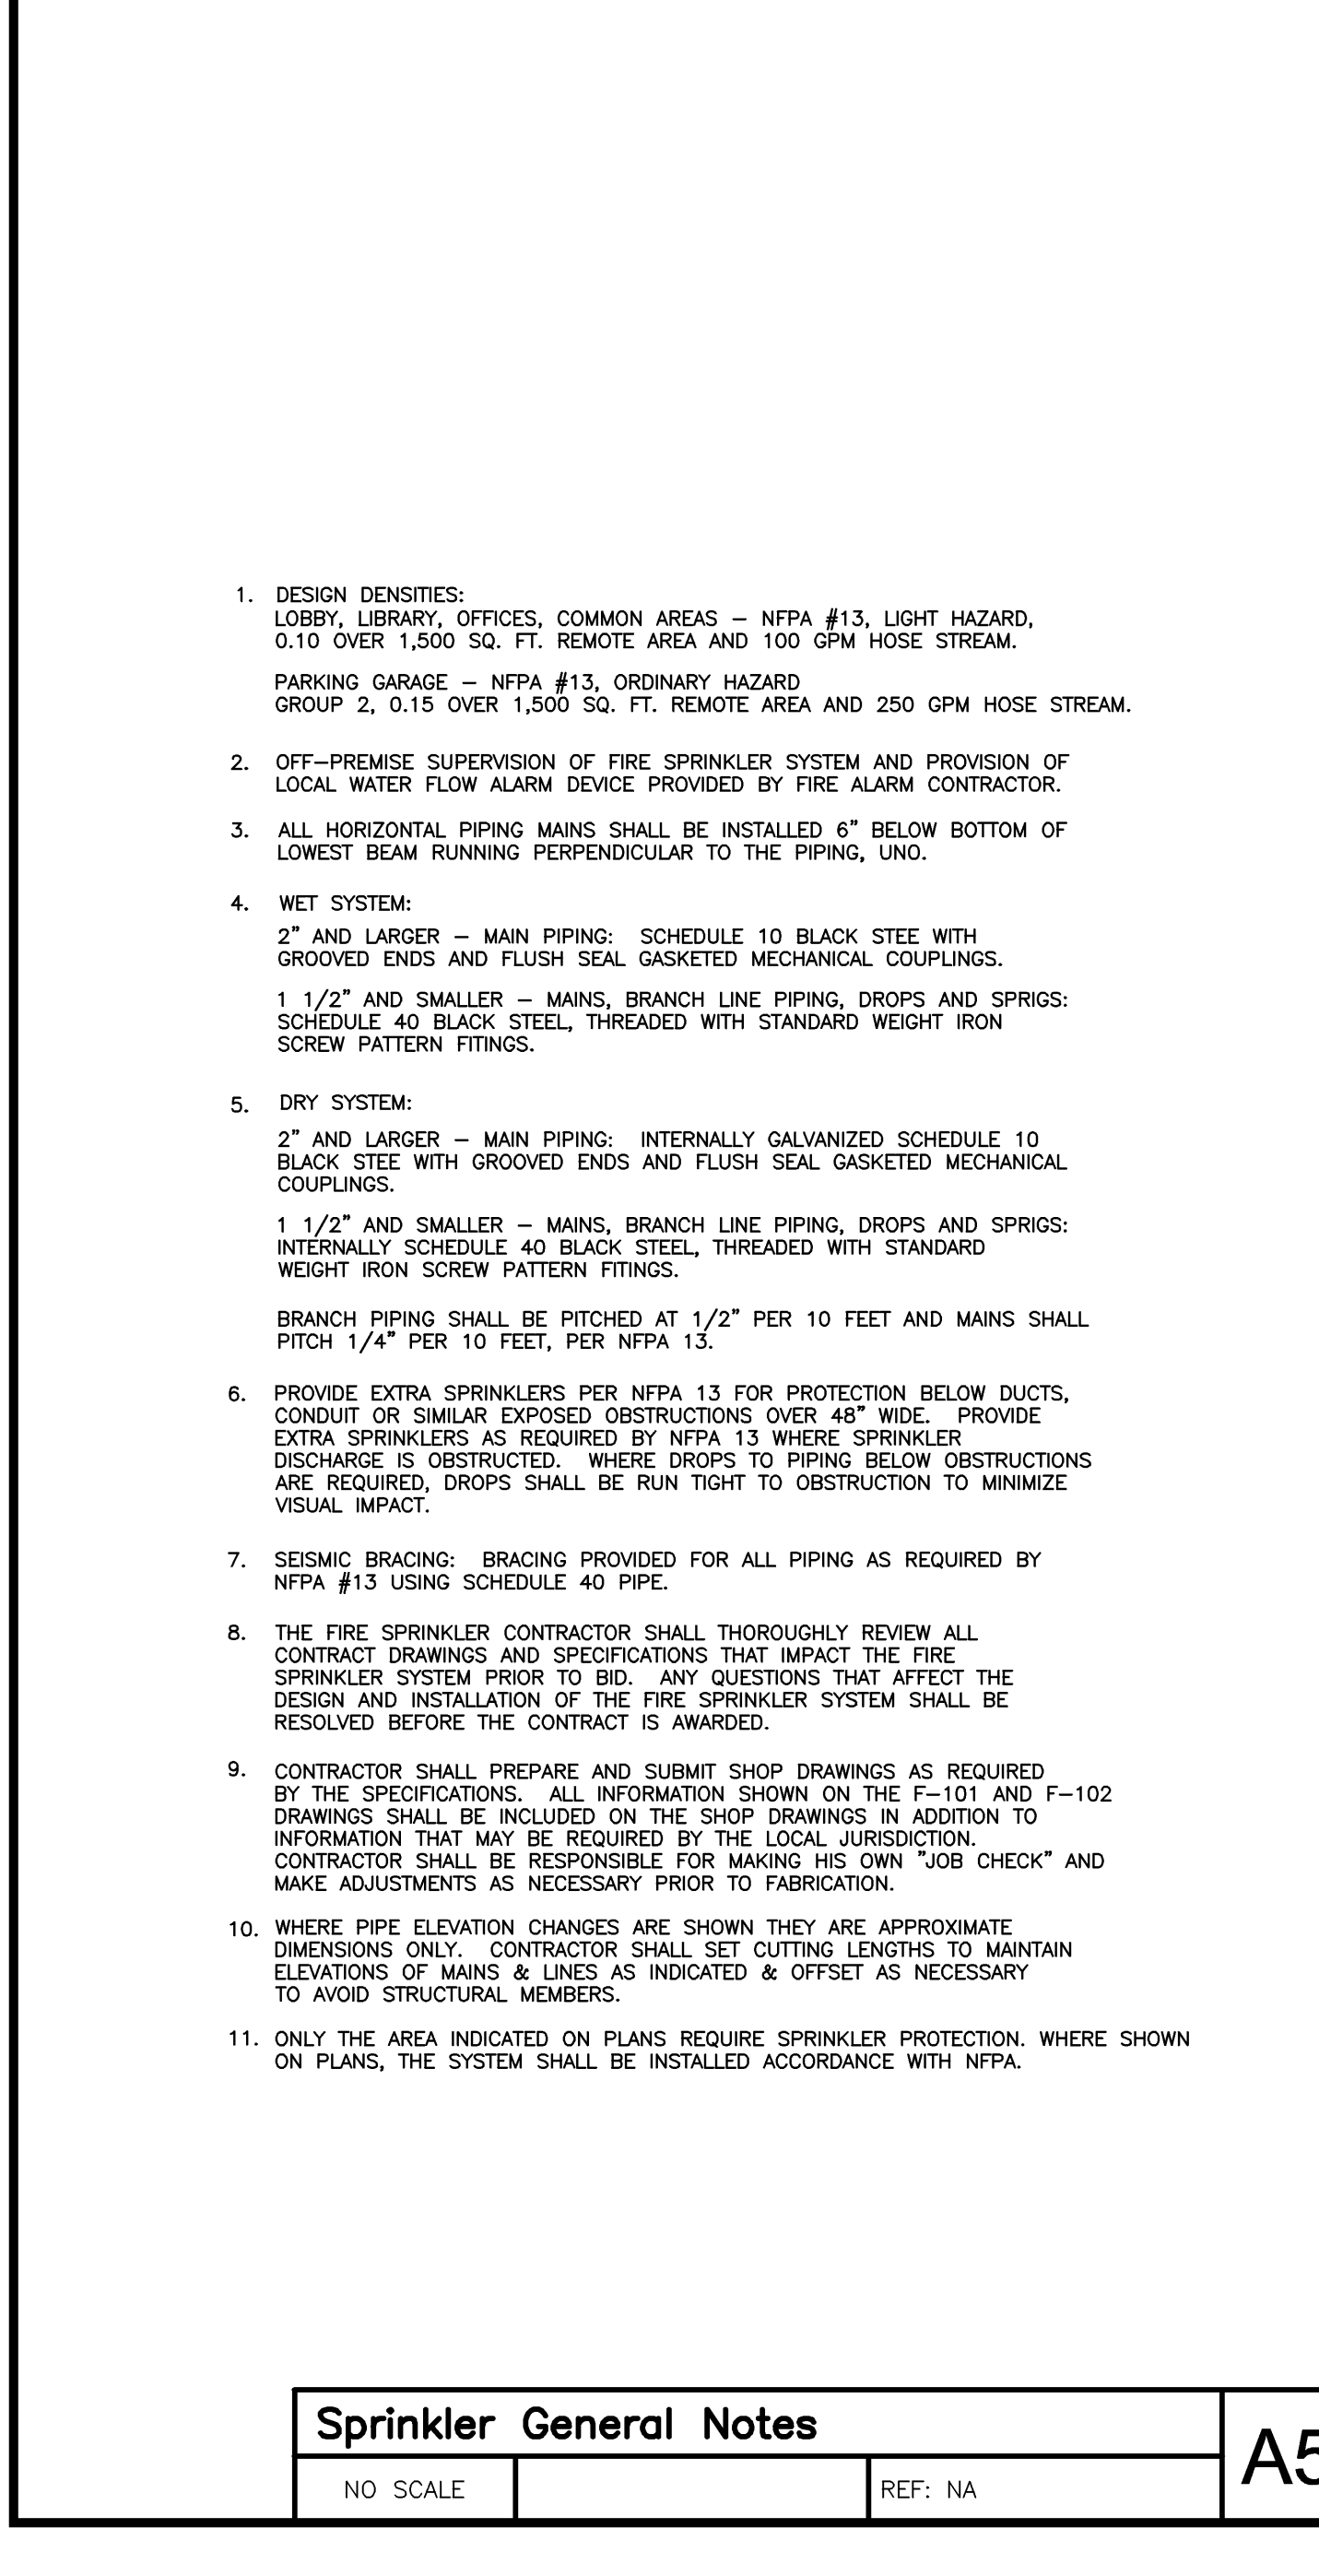

Sprinkler General Notes
NO SCALE REF: NA A5

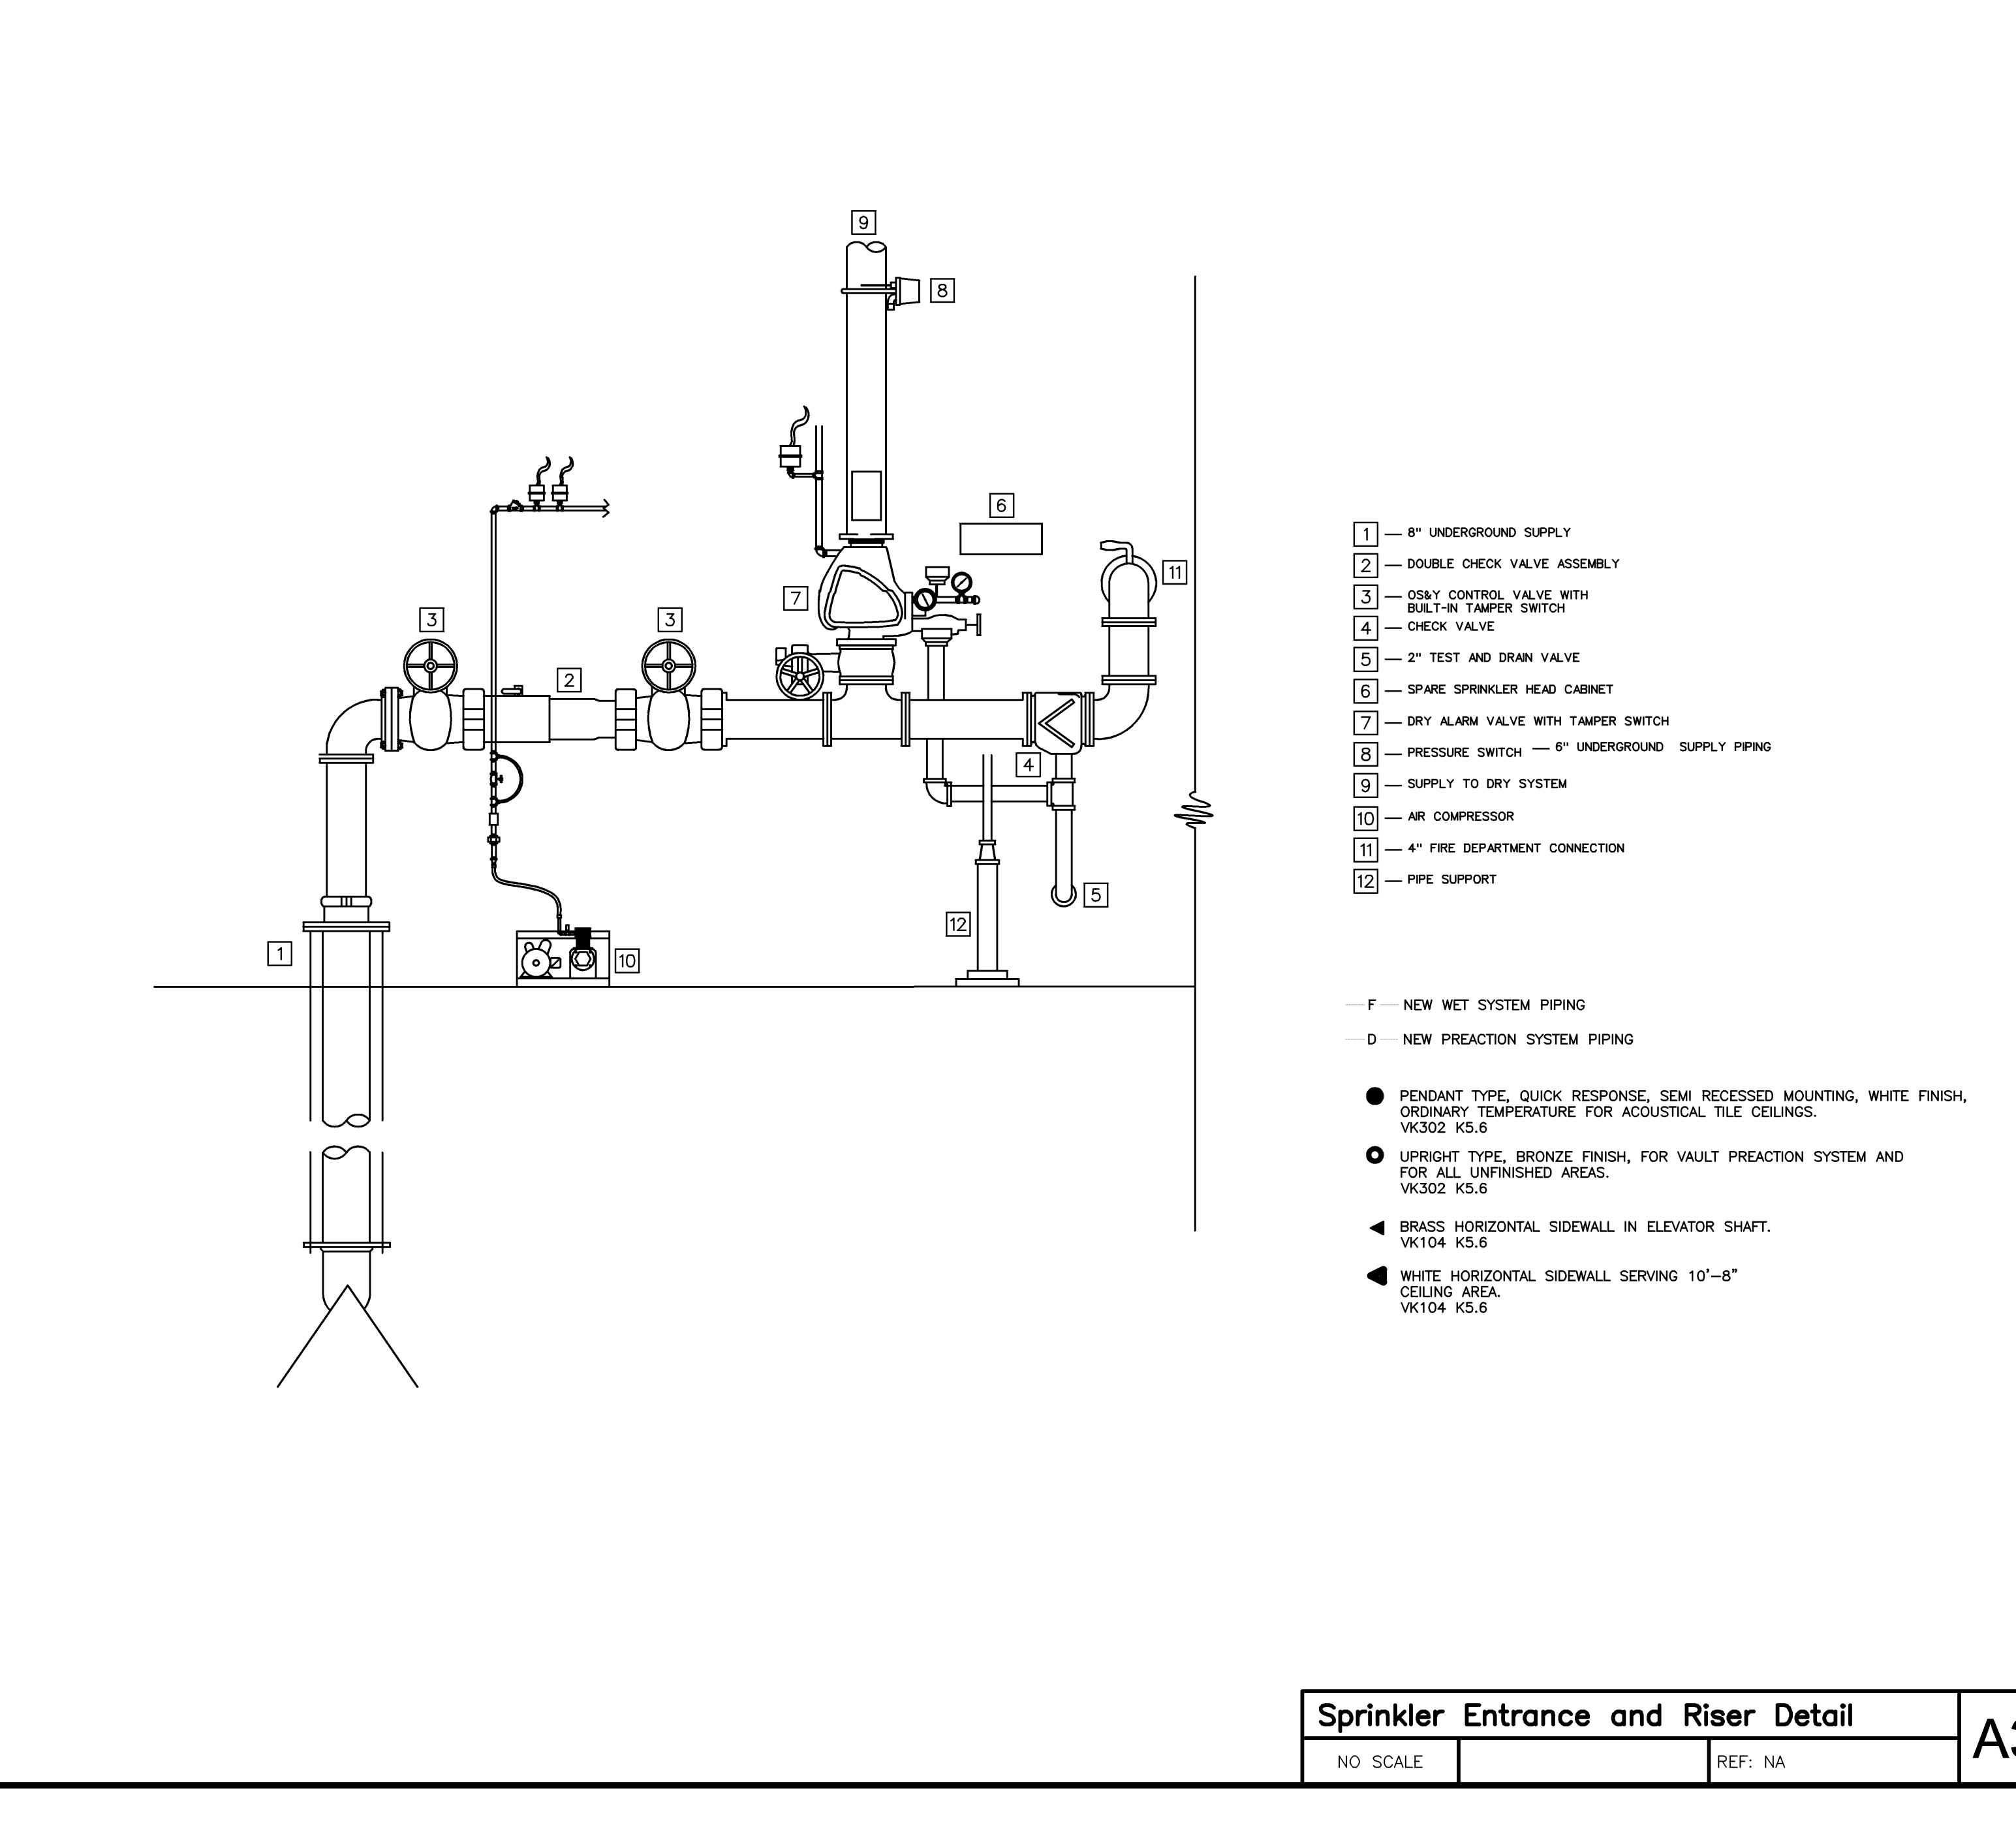

Sprinkler Entrance and Riser Detail
NO SCALE REF: NA A3

PLUMBING FIXTURE INSTALLATION SCHEDULE

LABEL	DESCRIPTION	BRANCH SIZE				REMARKS	MOUNTING HEIGHT TO RIM	MANUFACTURER	MODEL NUMBER
		VENT	WASTE	CW	HW				
WC-1	WATER CLOSET	2"	3"	1"	----	----	17"	ZURN	ZS615.211.00.00.00
L-1	LAVATORY	1 1/2"	2"	1/2"	1/2"	----	34" MAXIMUM	AMERICAN STANDARD	LICERNE 0355.012
MR-1	MOP RECEPTOR	1 1/2"	2"	1/2"	1/2"	----	FLOOR MOUNTED, 12" HIGH	FLORESTONE	80
FD-1	FLOOR DRAIN	2"	3"	1/2"	----	----	----	ZURN	ZN-520-00-P-TS
FD-2	FLOOR DRAIN	2"	3"	1/2"	----	----	----	ZURN	Z-534-VP
FD-3	FLOOR DRAIN	2"	3"	1/2"	----	----	----	ZURN	Z-536-VP
FPWH-1	FROST PROOF WALL HYDRANT	----	----	3/4"	----	----	24" MINIMUM ABOVE GRADE. PIPING SHALL BE ABOVE SLAB.	ZURN	Z1321
WH-1	WATER HEATER	----	----	3/4"	3/4"	3/4"	----	TAKAGI	FLASH T-K3

PLUMBING FIXTURE INSTALLATION SCHEDULE

NO SCALE	REF: NA	A1
----------	---------	----

CONSIGLI
84 Middle Street
Portland, Maine 04101
Phone: 207-773-3000
Fax: 207-773-2800

SSA
75 Oak Street
Portland, Maine 04101
Phone: 207-479-4656
Fax: 207-479-4658

BECKER
75 Oak Street
Portland, Maine 04101
Phone: 207-479-1820
Fax: 207-479-1822

SIT/CAL ENGINEER
41 Middle Street
Portland, Maine 04102
Phone: 800-945-0382
Fax: 207-774-6620

95 Cedar Street Suite 100
Portland, Maine 04103
Phone: 800-945-7887
Fax: 401-773-5987

HARRIMAN
Architects + Engineers

Auburn Business Park
46 Harriman Drive
Auburn, Maine 04210
207.784.5100 ext
207.783.3017 fax

123 Middle Street
Portland, Maine 04101
207.773.0633 ext
207.773.0460 fax

www.harriman.com
© 2008

Project Title
BAYCO LLC.
BAYSIDE DEVELOPMENT
PORTLAND, MAINE

Parking Garage

Project No. **08576**

Key Plan

General Notes or Legends Here

Mark	Date	Description
01-07-09		SITE ENABLING PACKAGE

Issue Dates

Drawing Status
NOT FOR CONSTRUCTION - SITE COORDINATION ONLY

Drawing Title
Plumbing Schedules, Legends and Details

PA / PE:CVG Drawn By:SGH

Drawing Number
GP00.1