



ELECTRICAL SITE PLAN & FIRST FLOOR CONDUIT ROUTING
 1/8" = 1'-0"

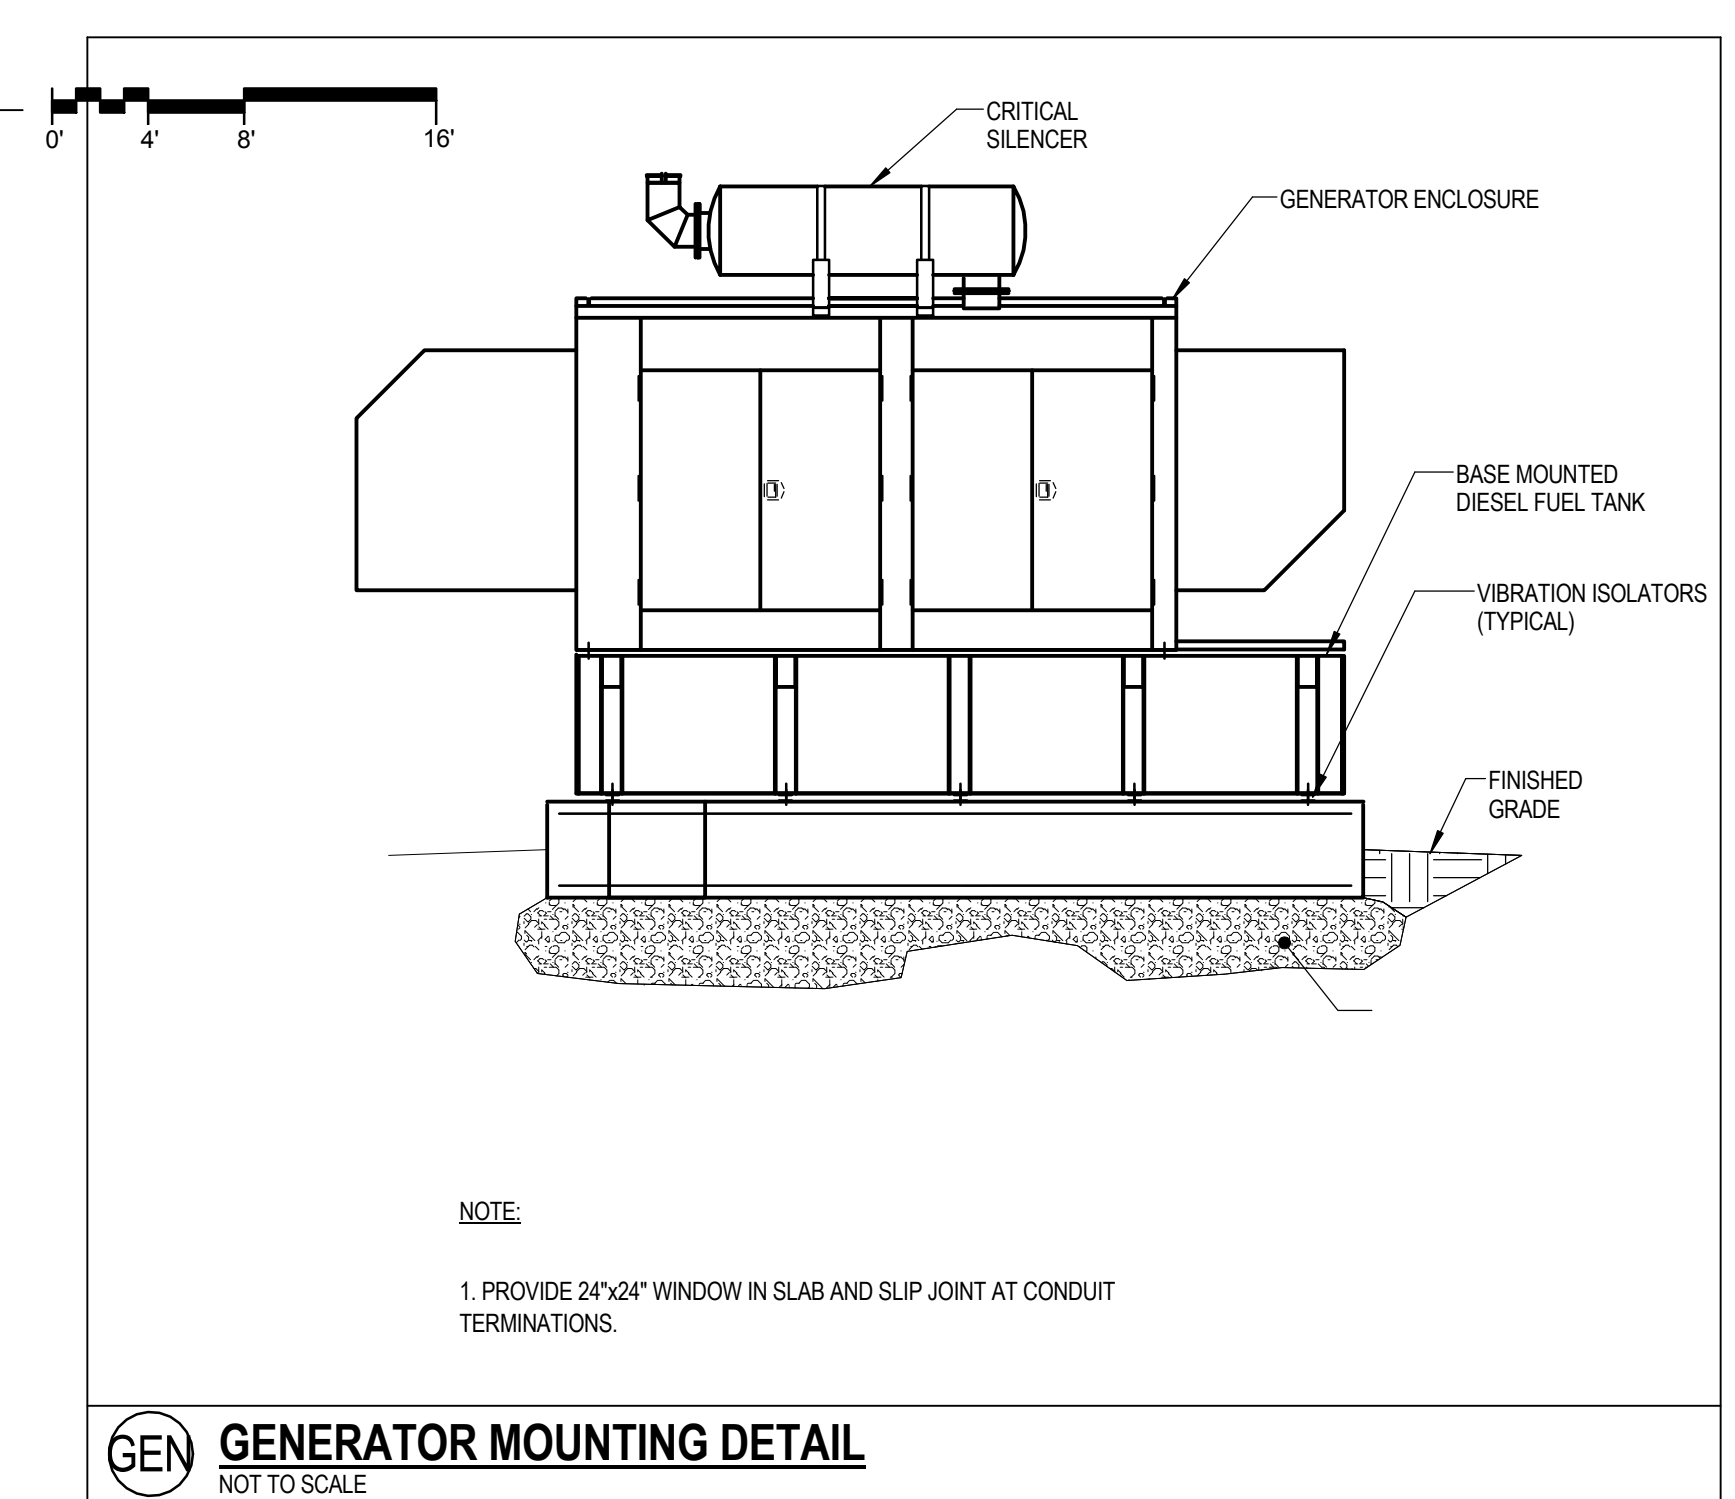

DIG SAFE NOTE:
 UTILITIES ARE PLOTTED FROM FIELD LOCATION AND ANY RECORD INFORMATION AVAILABLE AND SHOULD BE CONSIDERED APPROXIMATE. OTHER UTILITIES MAY EXIST WHICH ARE NOT EVIDENT OR FOR WHICH RECORD INFORMATION WAS NOT AVAILABLE. CONTRACTORS MUST CONTACT ALL UTILITY COMPANIES BEFORE EXCAVATING AND DRILLING. ALSO CALL "DIG SAFE" AT 1 (888)344-7233 (1(888)DIG-SAFE) IN MA, ME, NH, RI AND, VT. DIG-SAFE WEBSITE: WWW.DIGSAFE.COM

No.	Date	Description

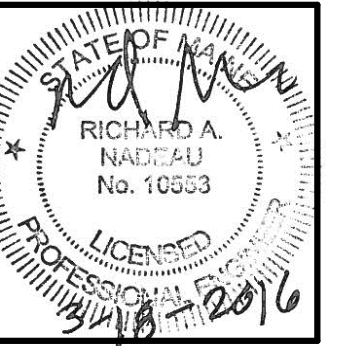

JOB NO.
195210852

DRWN. CHK
Author Checker

SCALE:

ISSUE
PERMIT SET
3/18/2016

TITLE
ELECTRICAL SITE
PLAN AND
DETAILS

SHEET
ES101

