

OWNER
FEDDO DV001
P.O. Box 370008
Miami, Florida 33137
Tel: (305) 974-1454
Attn: Jonathan Cox



ARCHITECT
THA Architects, LLC
105 Willow Brook Avenue
Sheridan, New Hampshire 03885
Tel: (603) 770-2491
Attn: Thomas A. House, AIA

CIVIL ENGINEER
Stantec
482 Payne Road
Scarborough, ME 04074-8929
Tel: (207) 887-3406
Attn: Bo Kennedy, PE

LANDSCAPE ARCHITECT
Mitchell & Associates
The Sipples School
70 Center Street
Portland, ME 04101
Tel: (207) 774-4427
Attn: Robert Metcalf, RLA

STRUCTURAL ENGINEER
Becker Structural Engineers
75 York Street
Portland, ME 04101
Tel: (207) 879-1838
Attn: Todd Neal, PE

MECHANICAL ENGINEER
McCabe Associates
75 Goodhue Road
Derry, New Hampshire 03038
Tel: (603) 437-2002
Attn: Steven Houle, PE


ELECTRICAL ENGINEER
McCabe Associates
75 Goodhue Road
Derry, New Hampshire 03038
Tel: (603) 437-2002
Attn: Steven Houle, PE

A Mixed-Use Retail Parking Garage

City of Portland, Maine

DRAWING LIST

SOUTH ELEVATION - SOMERSET STREET

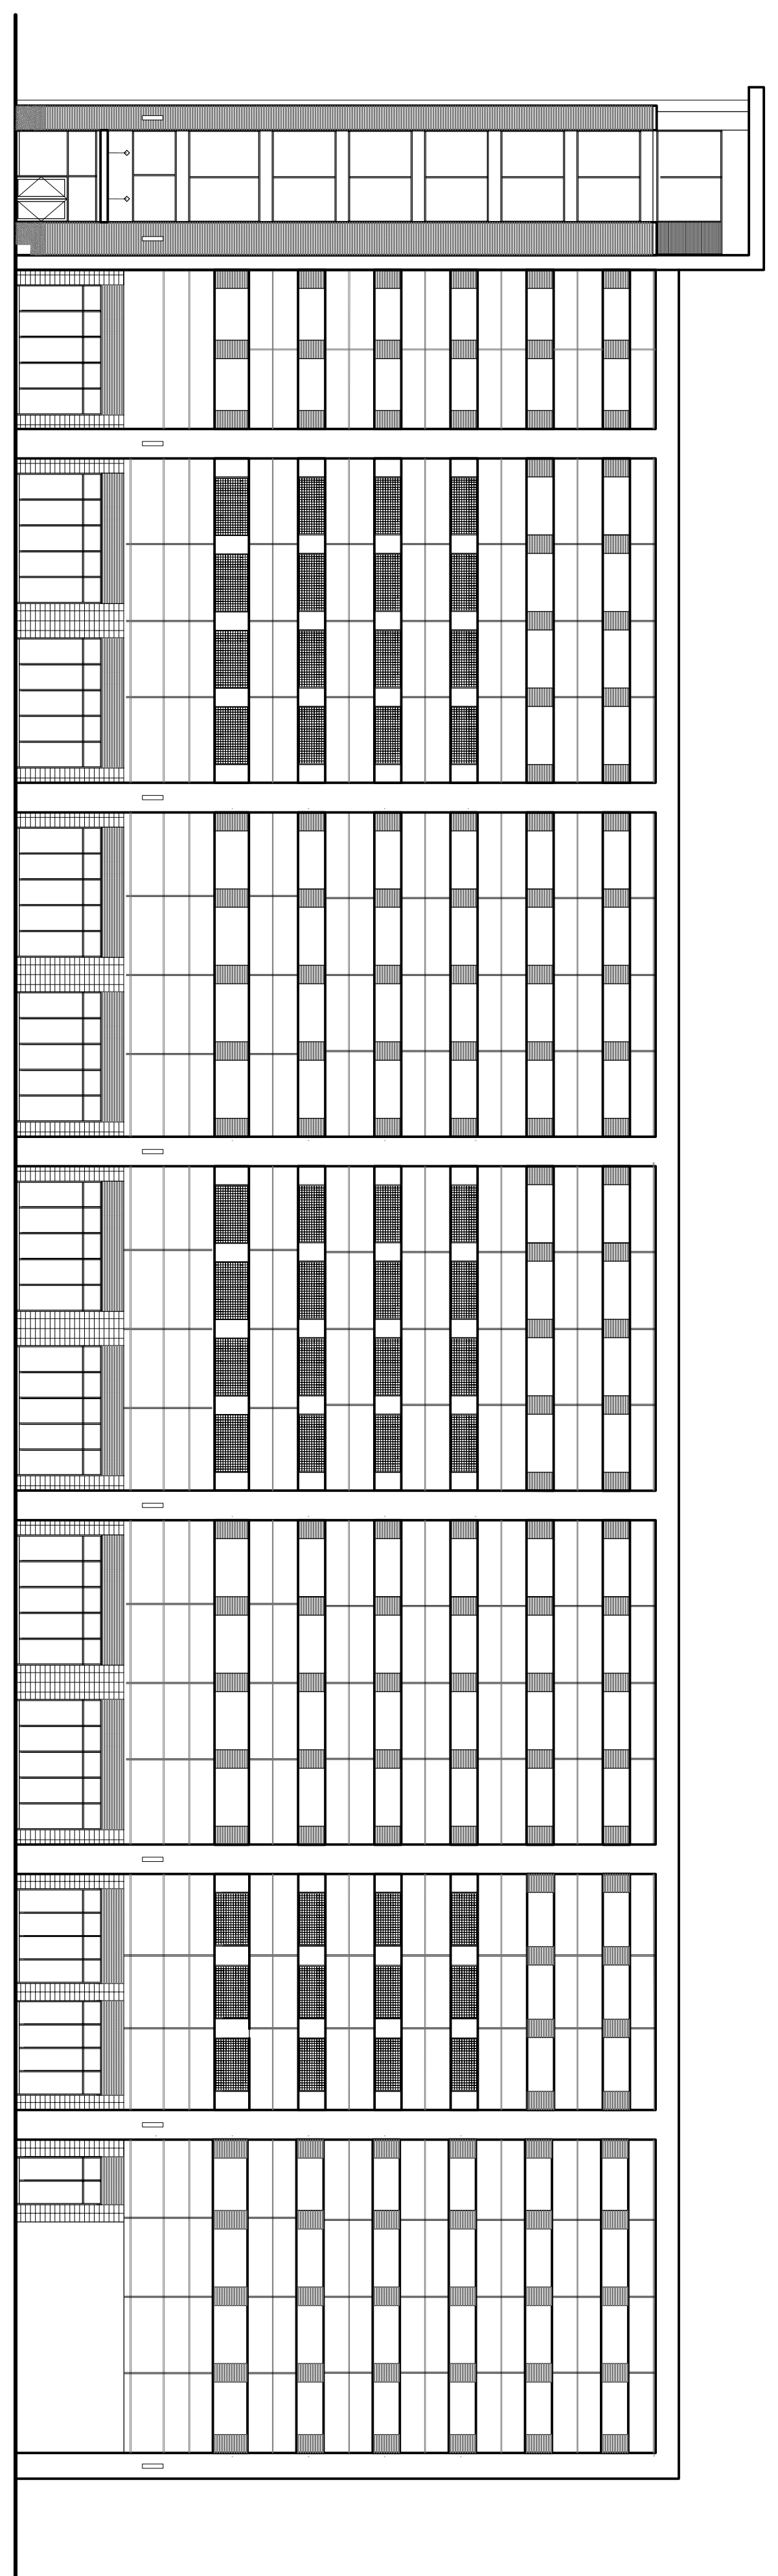

Sheet No.	Scale	Title	Latest Issue Date
A-01	-----	Life Safety & Code Analysis Specifications	15 April 2016
A-02	-----		15 April 2016
A-1.1	1/16"=1'-0"	Level One Rerected Ceiling Plan	15 April 2016
A-1.1RCP	1/16"=1'-0"	Level One Rerected Ceiling Plan	15 April 2016
A-1.2	1/16"=1'-0"	Level Two Rerected Ceiling Plan	15 April 2016
A-1.2RCP	1/16"=1'-0"	Level Two Rerected Ceiling Plan	15 April 2016
A-1.3	1/16"=1'-0"	Level Three Rerected Ceiling Plan	15 April 2016
A-1.3RCP	1/16"=1'-0"	Level Three Rerected Ceiling Plan	15 April 2016
A-1.4	1/16"=1'-0"	Level Four Rerected Ceiling Plan	15 April 2016
A-1.4RCP	1/16"=1'-0"	Level Four Rerected Ceiling Plan	15 April 2016
A-1.5	1/16"=1'-0"	Level Five Rerected Ceiling Plan	15 April 2016
A-1.5RCP	1/16"=1'-0"	Level Five Rerected Ceiling Plan	15 April 2016
A-1.6RCP	1/16"=1'-0"	Level Six Rerected Ceiling Plan	15 April 2016
A-1.7	1/16"=1'-0"	Level Seven Rerected Ceiling Plan	15 April 2016
A-1.7RCP	1/16"=1'-0"	Level Seven Rerected Ceiling Plan	15 April 2016
A-1.8	1/16"=1'-0"	Level Eight Floor Plan/Roof Plan	15 April 2016
A-2.1a	1/4"=1'-0"	Partial Level One Floor Plan	15 April 2016
A-2.1b	1/4"=1'-0"	Partial Level One Floor Plan	15 April 2016
A-2.2	1/4"=1'-0"	Partial Level Two Floor Plan	15 April 2016
A-2.3	1/4"=1'-0"	Partial Level Three Floor Plan	15 April 2016
A-2.4	1/4"=1'-0"	Partial Level Four Floor Plan	15 April 2016
A-2.5	1/4"=1'-0"	Partial Level Five Floor Plan	15 April 2016
A-2.6	1/4"=1'-0"	Partial Level Six Floor Plan	15 April 2016
A-2.7	1/4"=1'-0"	Partial Level Seven Floor Plan	15 April 2016
A-2.8	1/4"=1'-0"	Partial Level Eight Floor/Roof Plan	15 April 2016
A-3.1	1/16"=1'-0"	Exterior Elevations	15 April 2016
A-3.2	1/16"=1'-0"	Exterior Elevations	15 April 2016
A-4.1	Varies	Stair/Elevator Sections/Details	15 April 2016
A-4.2	1/8"=1'-0"	Building Section	15 April 2016
A-5.1	Varies	Details	15 April 2016
A-5.2	Varies	Details	15 April 2016
A-6.1	Varies	Wall/Floor & Roof Ceiling Assemblies/ Door Schedule/ Door & Frame Types/Window Types/ Toilet Plan & Elevations	15 April 2016

Sheet No.	Scale	Title	Latest Issue Date
S-0.0	-----	General Notes	15 April 2016
S-0.1	-----	Typical Details	15 April 2016
S-1.0	1/16"=1'-0"	Foundation Plan	15 April 2016
S-1.0A	1/4"=1'-0"	Stair Foundation Details	15 April 2016
S-1.1	1/16"=1'-0"	Grade Level/ Structural Slab Plan	15 April 2016
S-1.2	1/16"=1'-0"	Level Two Framing Plan	15 April 2016
S-1.3	1/16"=1'-0"	Level Three Framing Plan	15 April 2016
S-1.4	1/16"=1'-0"	Level Four - Seven Framing Plan	15 April 2016
S-1.5	1/16"=1'-0"	Level Four - Seven Framing Plan	15 April 2016
S-1.6	1/4"=1'-0"	Stair Framing Plans	15 April 2016
S-2.0	1/2"=1'-0"	Foundation Sections & Details	15 April 2016
S-2.1	1/2"=1'-0"	Foundation Sections & Details	15 April 2016
S-2.2	1/2"=1'-0"	Pile Cap Details	15 April 2016
S-2.3	1/2"=1'-0"	Pile Cap & Pile Group Details	15 April 2016
S-2.4	1/2"=1'-0"	Pile Cap & Pile Group Details	15 April 2016
S-2.5	-----	Grade Beam Schedule & Details	15 April 2016
S-3.0	1/16"=1'-0"	Building Sections	15 April 2016
S-3.1	1/16"=1'-0"	Structural Elevations	15 April 2016
S-3.2	1/16"=1'-0"	Structural Elevations	15 April 2016
S-4.0	3/4"=1'-0"	Section & Details	15 April 2016
S-4.1	3/4"=1'-0"	Section & Details	15 April 2016
S-4.2	3/4"=1'-0"	Typical Precast Section & Details	15 April 2016
S-4.3	3/4"=1'-0"	Stair Tower Section & Details	15 April 2016

Sheet No.	Scale	Title	Latest Issue Date
FA-0.1	None	Fire Alarm Specifications and Legend	15 April 2016
FA-1.1	1/16"=1'-0"	Level One and 6 th Level Fire Alarm	15 April 2016
FA-1.2	1/16"=1'-0"	Roof & 7 th Fire Alarm Plans	15 April 2016
FA-2.1	1/4"=1'-0"	Large Scale Fire Alarm Plans	15 April 2016
SP-0.1	None	Sprinkler Specifications & Legend	15 April 2016
SP-1.1	1/16"=1'-0"	Level One and 6 th Level Sprinkler Plans	15 April 2016
SP-1.2	1/16"=1'-0"	Roof & 7 th Sprinkler Plans	15 April 2016
SP-2.1	1/4"=1'-0"	Enlarged Water Room Plans	15 April 2016
SP-3.1	None	Sprinkler Riser & Details	15 April 2016
P-0.1	None	Plumbing Legend & Specifications	15 April 2016
P-1.1	1/16"=1'-0"	Level One Sanitary & Storm Plumbing Plans	15 April 2016
P-1.2	1/16"=1'-0"	Roof & 7 th Plumbing Plans	15 April 2016
P-1.3	1/16"=1'-0"	Second Floor Plumbing Details	15 April 2016
P-2.1	1/16"=1'-0"	Large Scale Plumbing Plans	15 April 2016
P-3.1	None	Plumbing Riser Diagrams & Details	15 April 2016
M-0.1	None	HVAC Specifications and Plan	15 April 2016
E-0.1	None	Electrical legend and details	15 April 2016
E-0.2	1/16"=1'-0"	Electrical Specifications	15 April 2016
E-1.1	1/16"=1'-0"	Level One Second Floor Power	15 April 2016
E-1.2	1/16"=1'-0"	Level One Second Floor Lighting	15 April 2016
E-1.3	1/16"=1'-0"	Roof & 7 th Electrical Plans	15 April 2016
E-2.1	1/4"=1'-0"	Large Scale Electrical Plans	15 April 2016
E-3.1	None	One Line Diagrams Panel Schedules	15 April 2016
E-4.1	None	Electrical Grounding	15 April 2016