



Eighth Floor
Scale: 1/16"=1'-0"

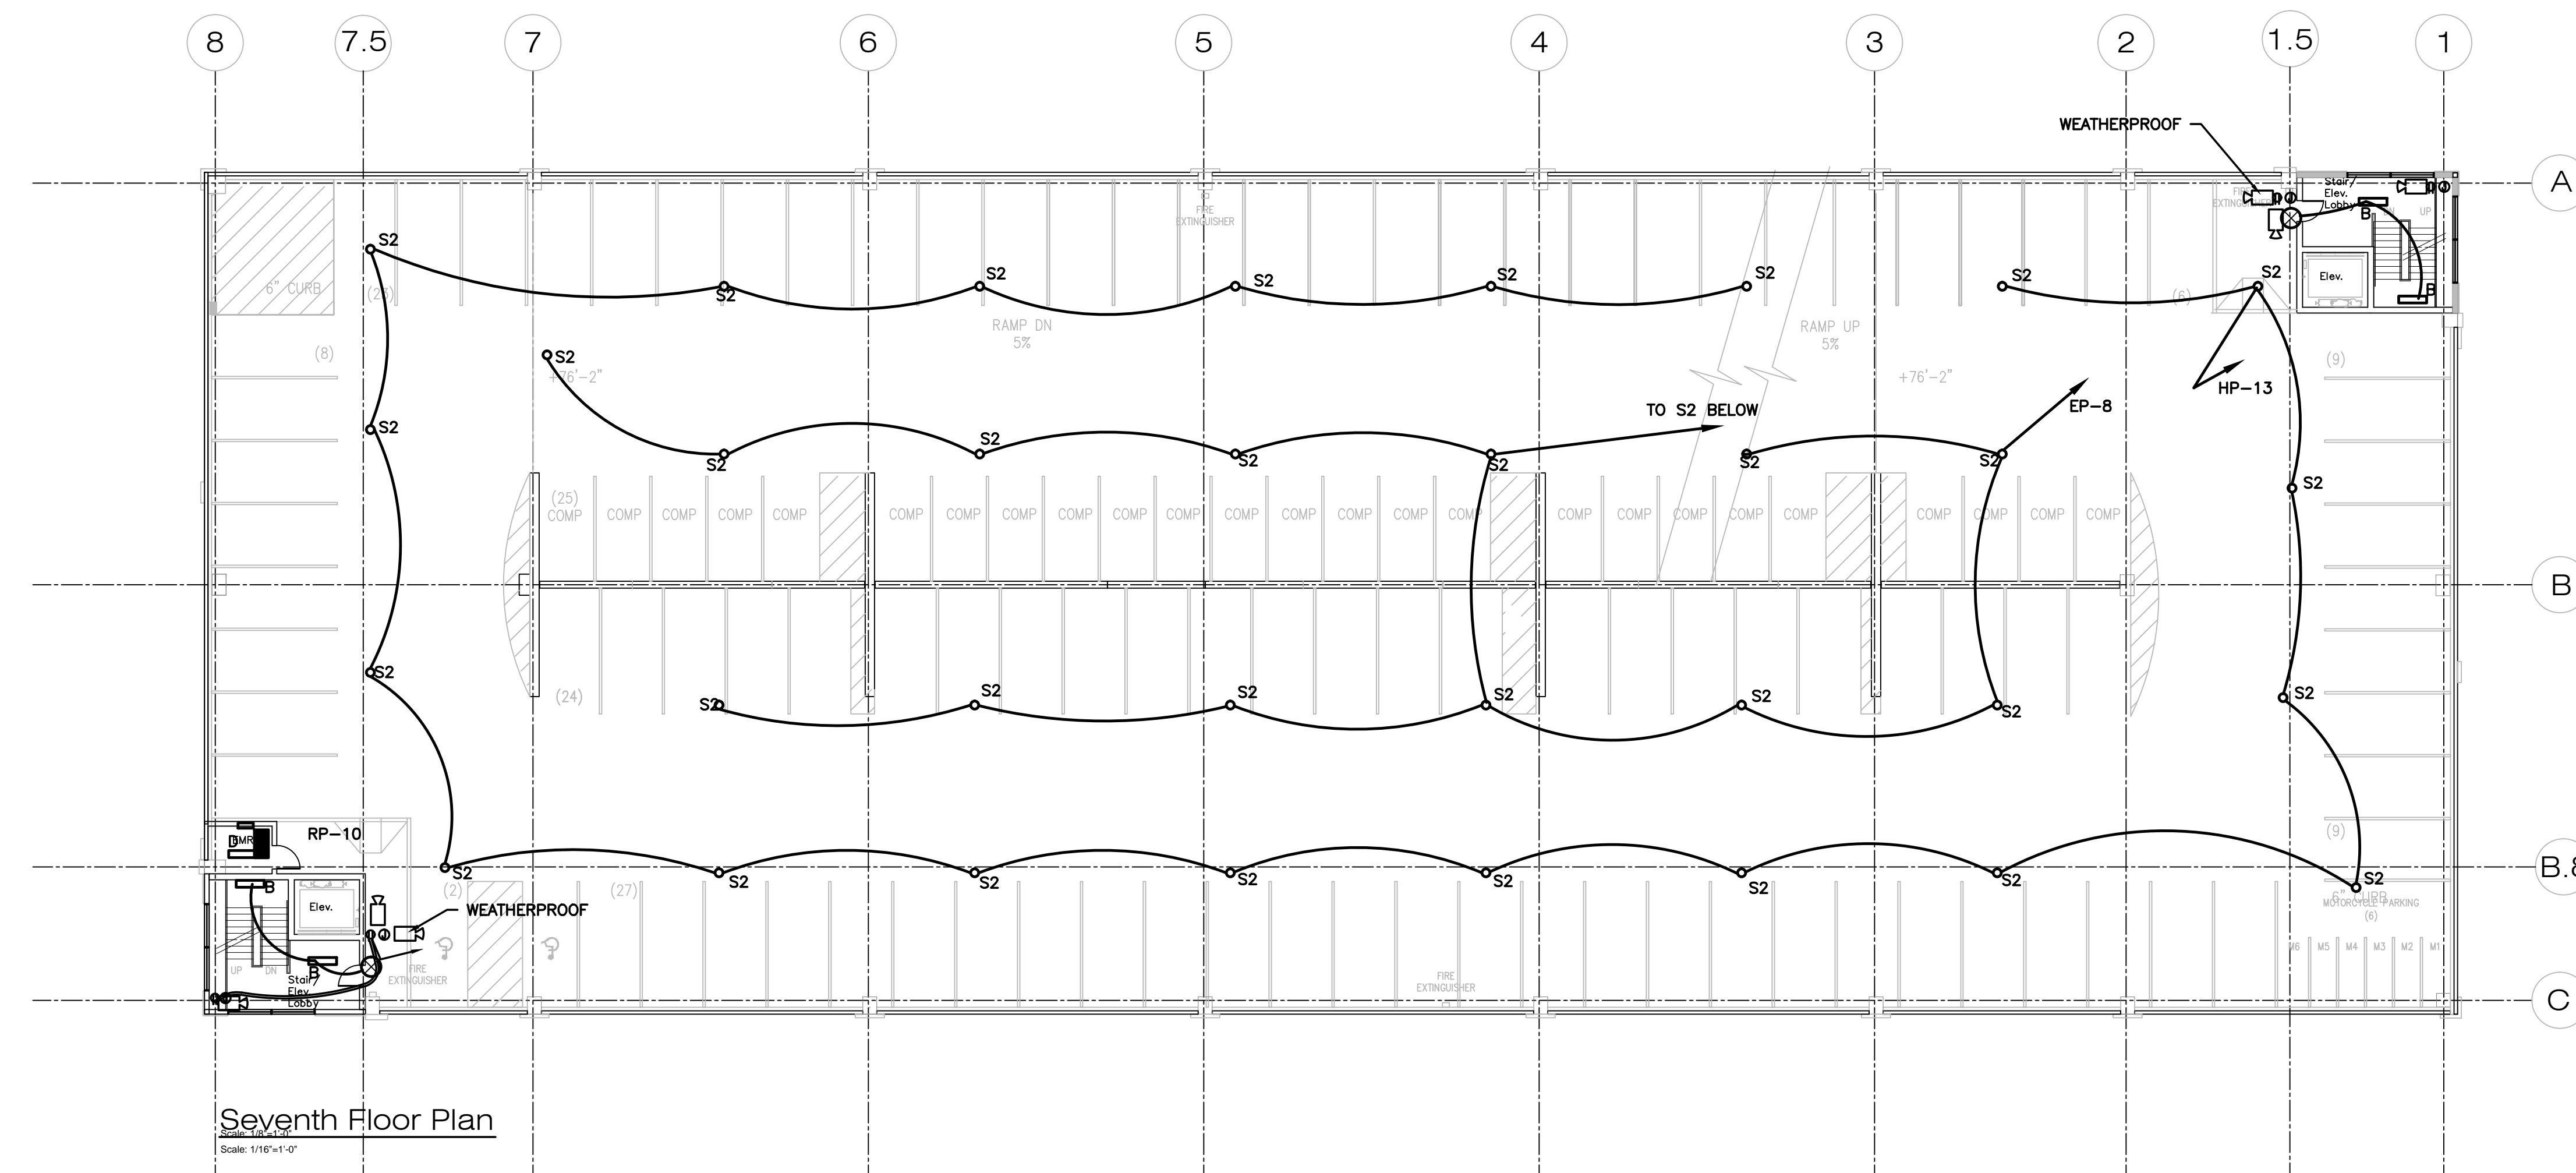


Seventh Floor Plan
Scale: 1/16"=1'-0"

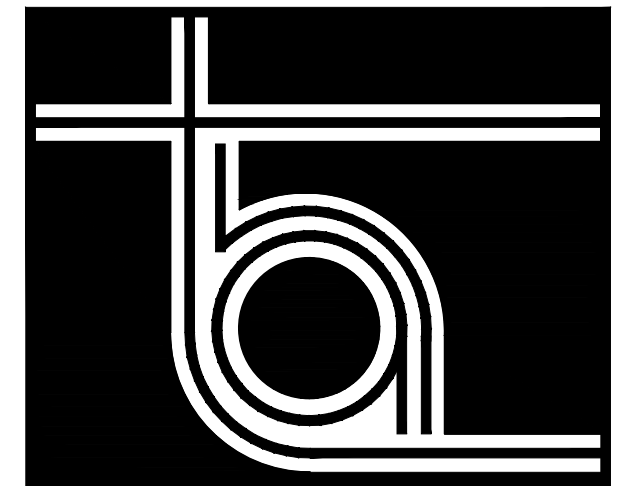

THA ARCHITECTS, LLC

ARCHITECTURE • DESIGN • PLANNING • INTERIOR DESIGN
105 WILLOW BROOK AVENUE
STRATHAM, NEW HAMPSHIRE 03885
Tel: (603) 770-2491 Fax: (603) 773-0238
www.thaarc.com

These drawings and specifications were prepared for use at the location indicated. Publication and use is expressly limited to the identified location. Reuse or reproduction by any method, in whole or in part, is prohibited without the written permission of THA Architects, LLC.
© THA Architects, LLC.

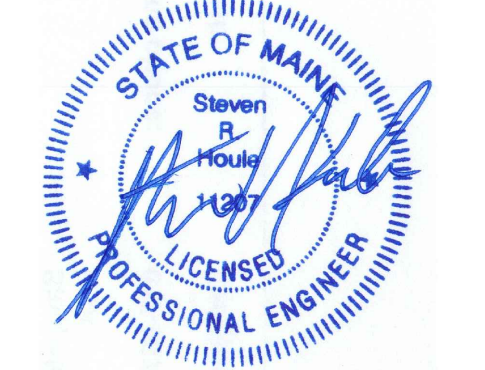

midtown Portland

Somerset Street
Elm Street
Portland, ME

**Building 2
Roof & 7th
ELECTRICAL
PLANS**

Structural Engineer
Becker Engineering
MEP ENGINEER
McCabe Associates
FP Engineer
McCabe Associates

SCALE: 1/16"=1'-0"
ISSUED / DRAWN BY _____
2/8/16
© THA Architects, LLC
REVISED / REVISED BY _____

JOB NO: 15001

SHEET NUMBER
E-1.3

Revised Permit Set April 15, 2016
Permit Set February 8, 2016