

THA
ARCHITECTS, LLC

ARCHITECTURE DESIGN PLANNING INTERIOR DESIGN
105 WILLOW BROOK AVENUE
SFRATHAM, NEW HAMPSHIRE 03885
Tel: (603) 770-2491 Fax: (603) 773-0288
www.thaarc.com

These drawings and specifications were prepared for use at the location indicated. Publication and use in any other location without the written permission of THA Architects, LLC.
© 2016 THA Architects, LLC.



midtown Portland

Somerset Street
Elm Street
Portland, ME


Building 2
Level Six
Reflected
Ceiling Plan

Structural Engineer
Becker Engineering
MEP Engineer
McCabe & Associates
FP Engineer
McCabe & Associates

SCALE:
ISSUED / DRAWN BY
February 8, 2016
© THA Architects, LLC
REVISED / REVISED BY

JOB NO.: 15001
SHEET NUMBER

A-1.6RCP

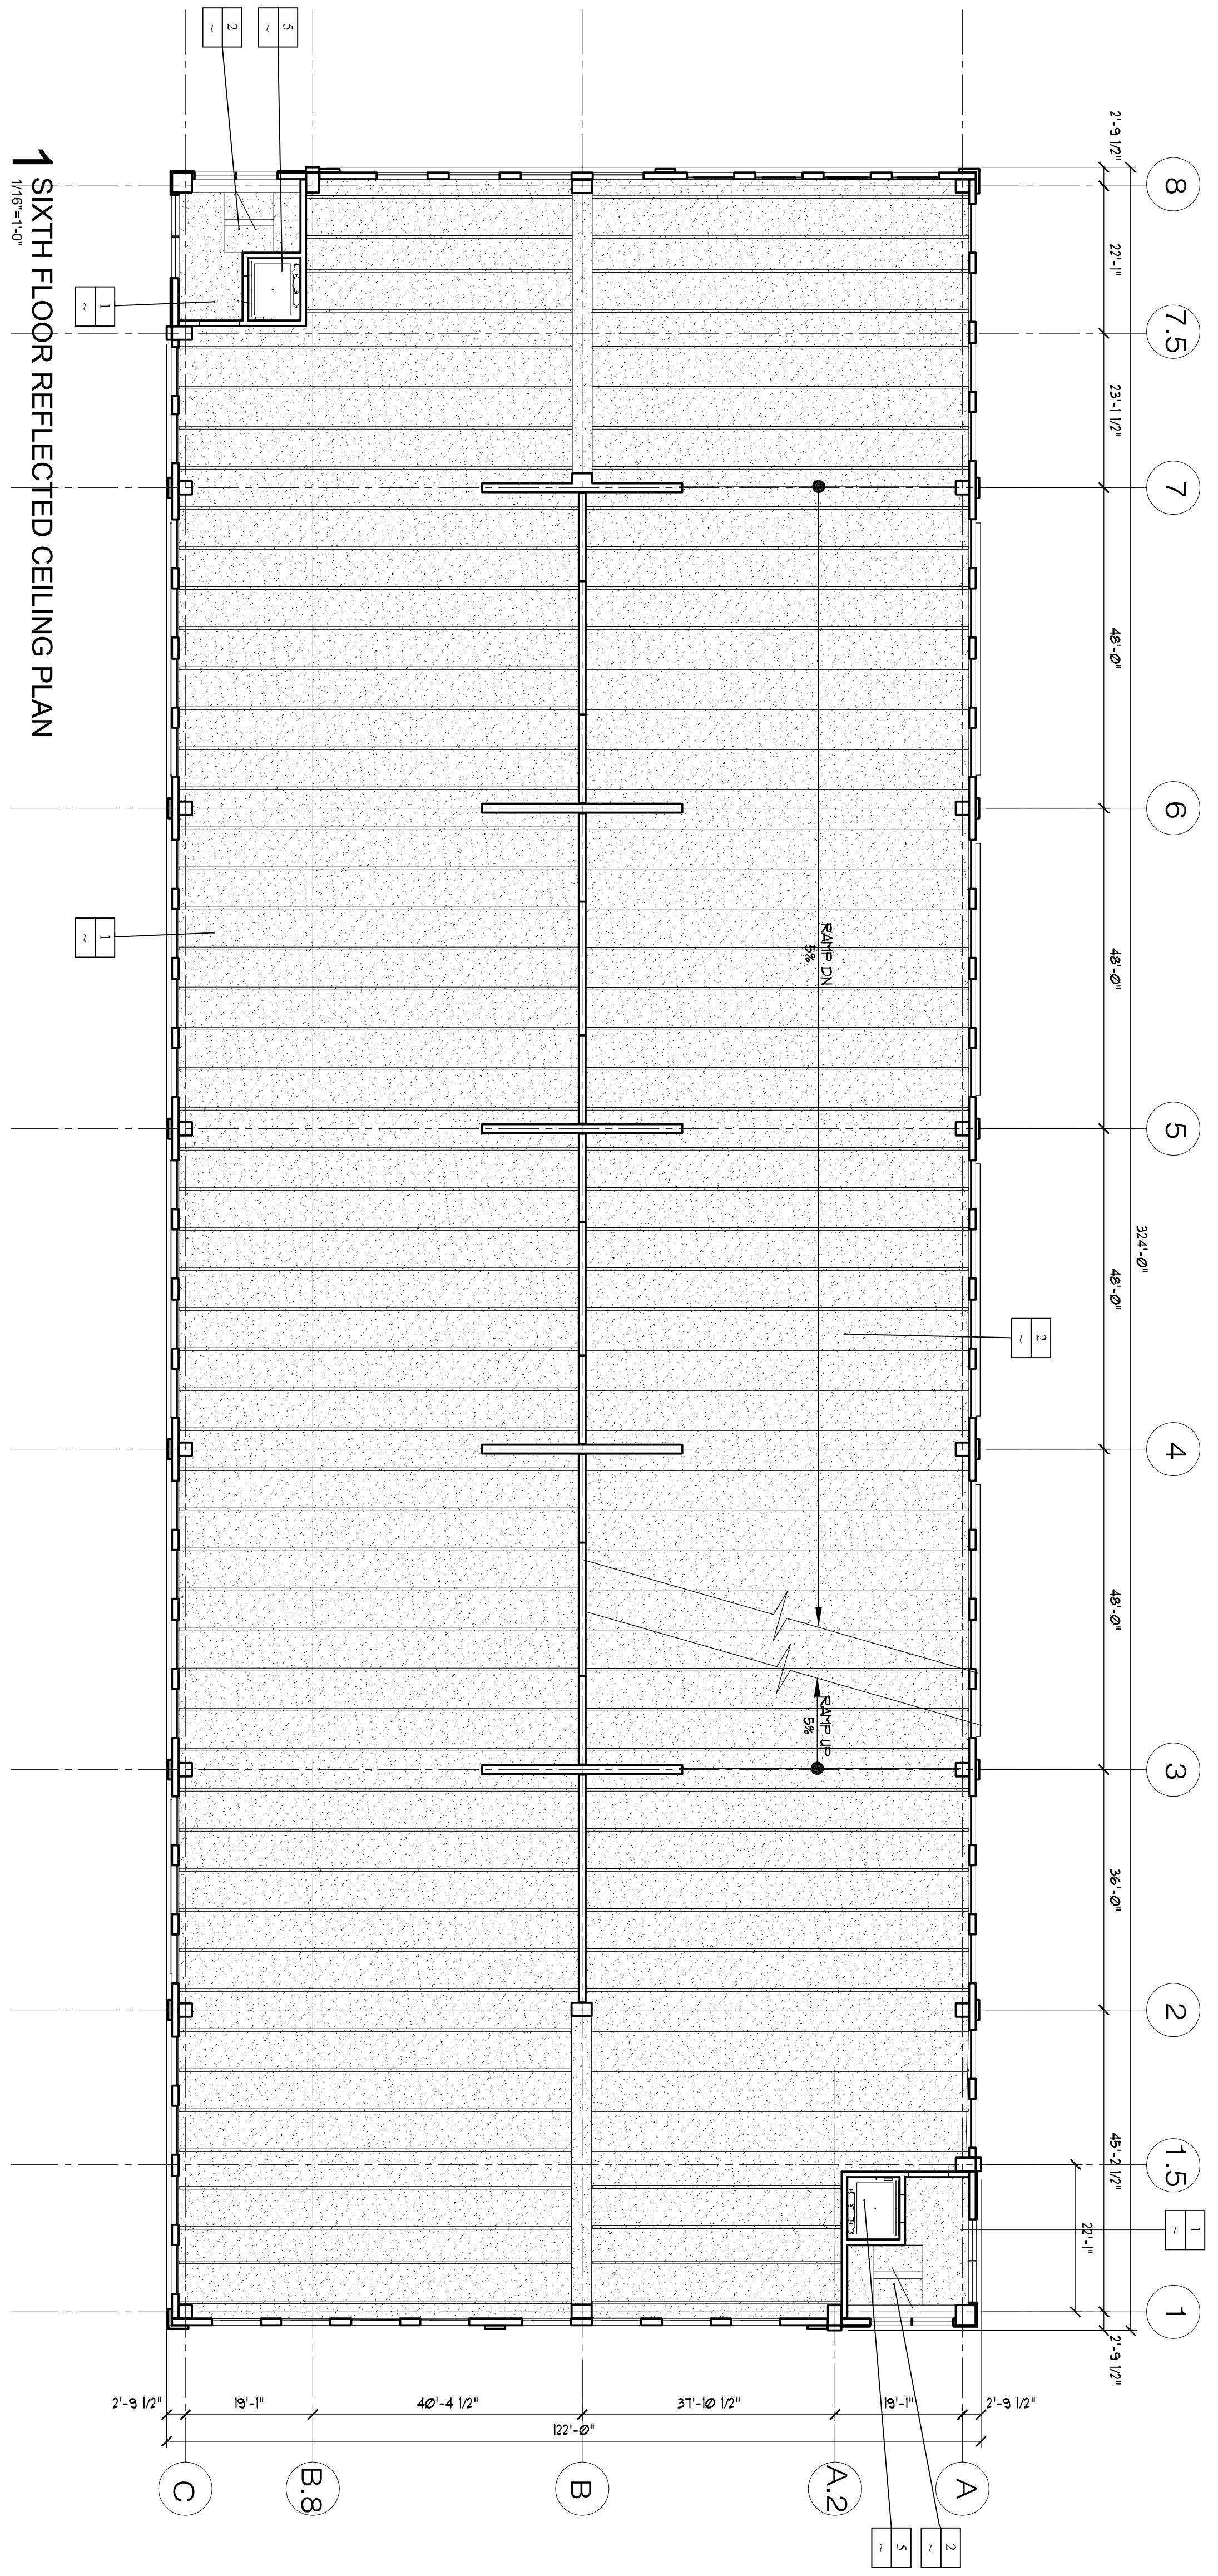

SIXTH FLOOR REFLECTED CEILING PLAN

LEGEND

1	PRECAST CONCRETE UNIT
2	SLOPED PRECAST CONCRETE
3	ACOUSTICAL CEILING TILE
4	ALUMINUM SCOFF SYSTEM
5	OPEN TO ABOVE