


THA
ARCHITECTS, LLC
ARCHITECTURE DESIGN PLANNING INTERIOR DESIGN
105 WILLLOW BROOK AVENUE
STRATHAM, NEW HAMPSHIRE 03885
Tel: (603) 770-2491 Fax: (603) 773-0288
www.thaarc.com

These drawings and specifications were prepared for use at the location indicated. Publication and use in any other location without the written permission of THA Architects, LLC is prohibited without the written permission of THA Architects, LLC.
© 2016 THA Architects, LLC.

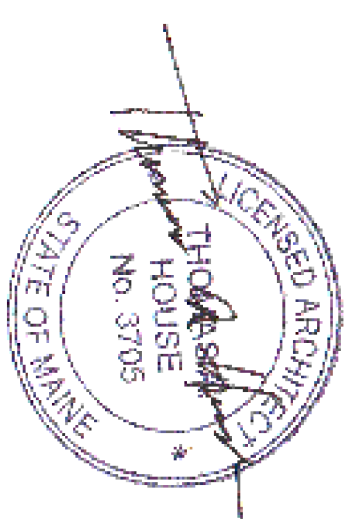

midtown Portland

Somerset Street
Elm Street
Portland, ME


Building 2
Level Eight
Floor Plan

Structural Engineer
Becker Engineering
MEP Engineer
McCabe & Associates
FP Engineer
McCabe & Associates

SCALE:
ISSUED / DRAWN BY
February 8, 2016
REVISED / REVISED BY
April 13, 2016

JOB NO.: 15001
SHEET NUMBER

A-1.8

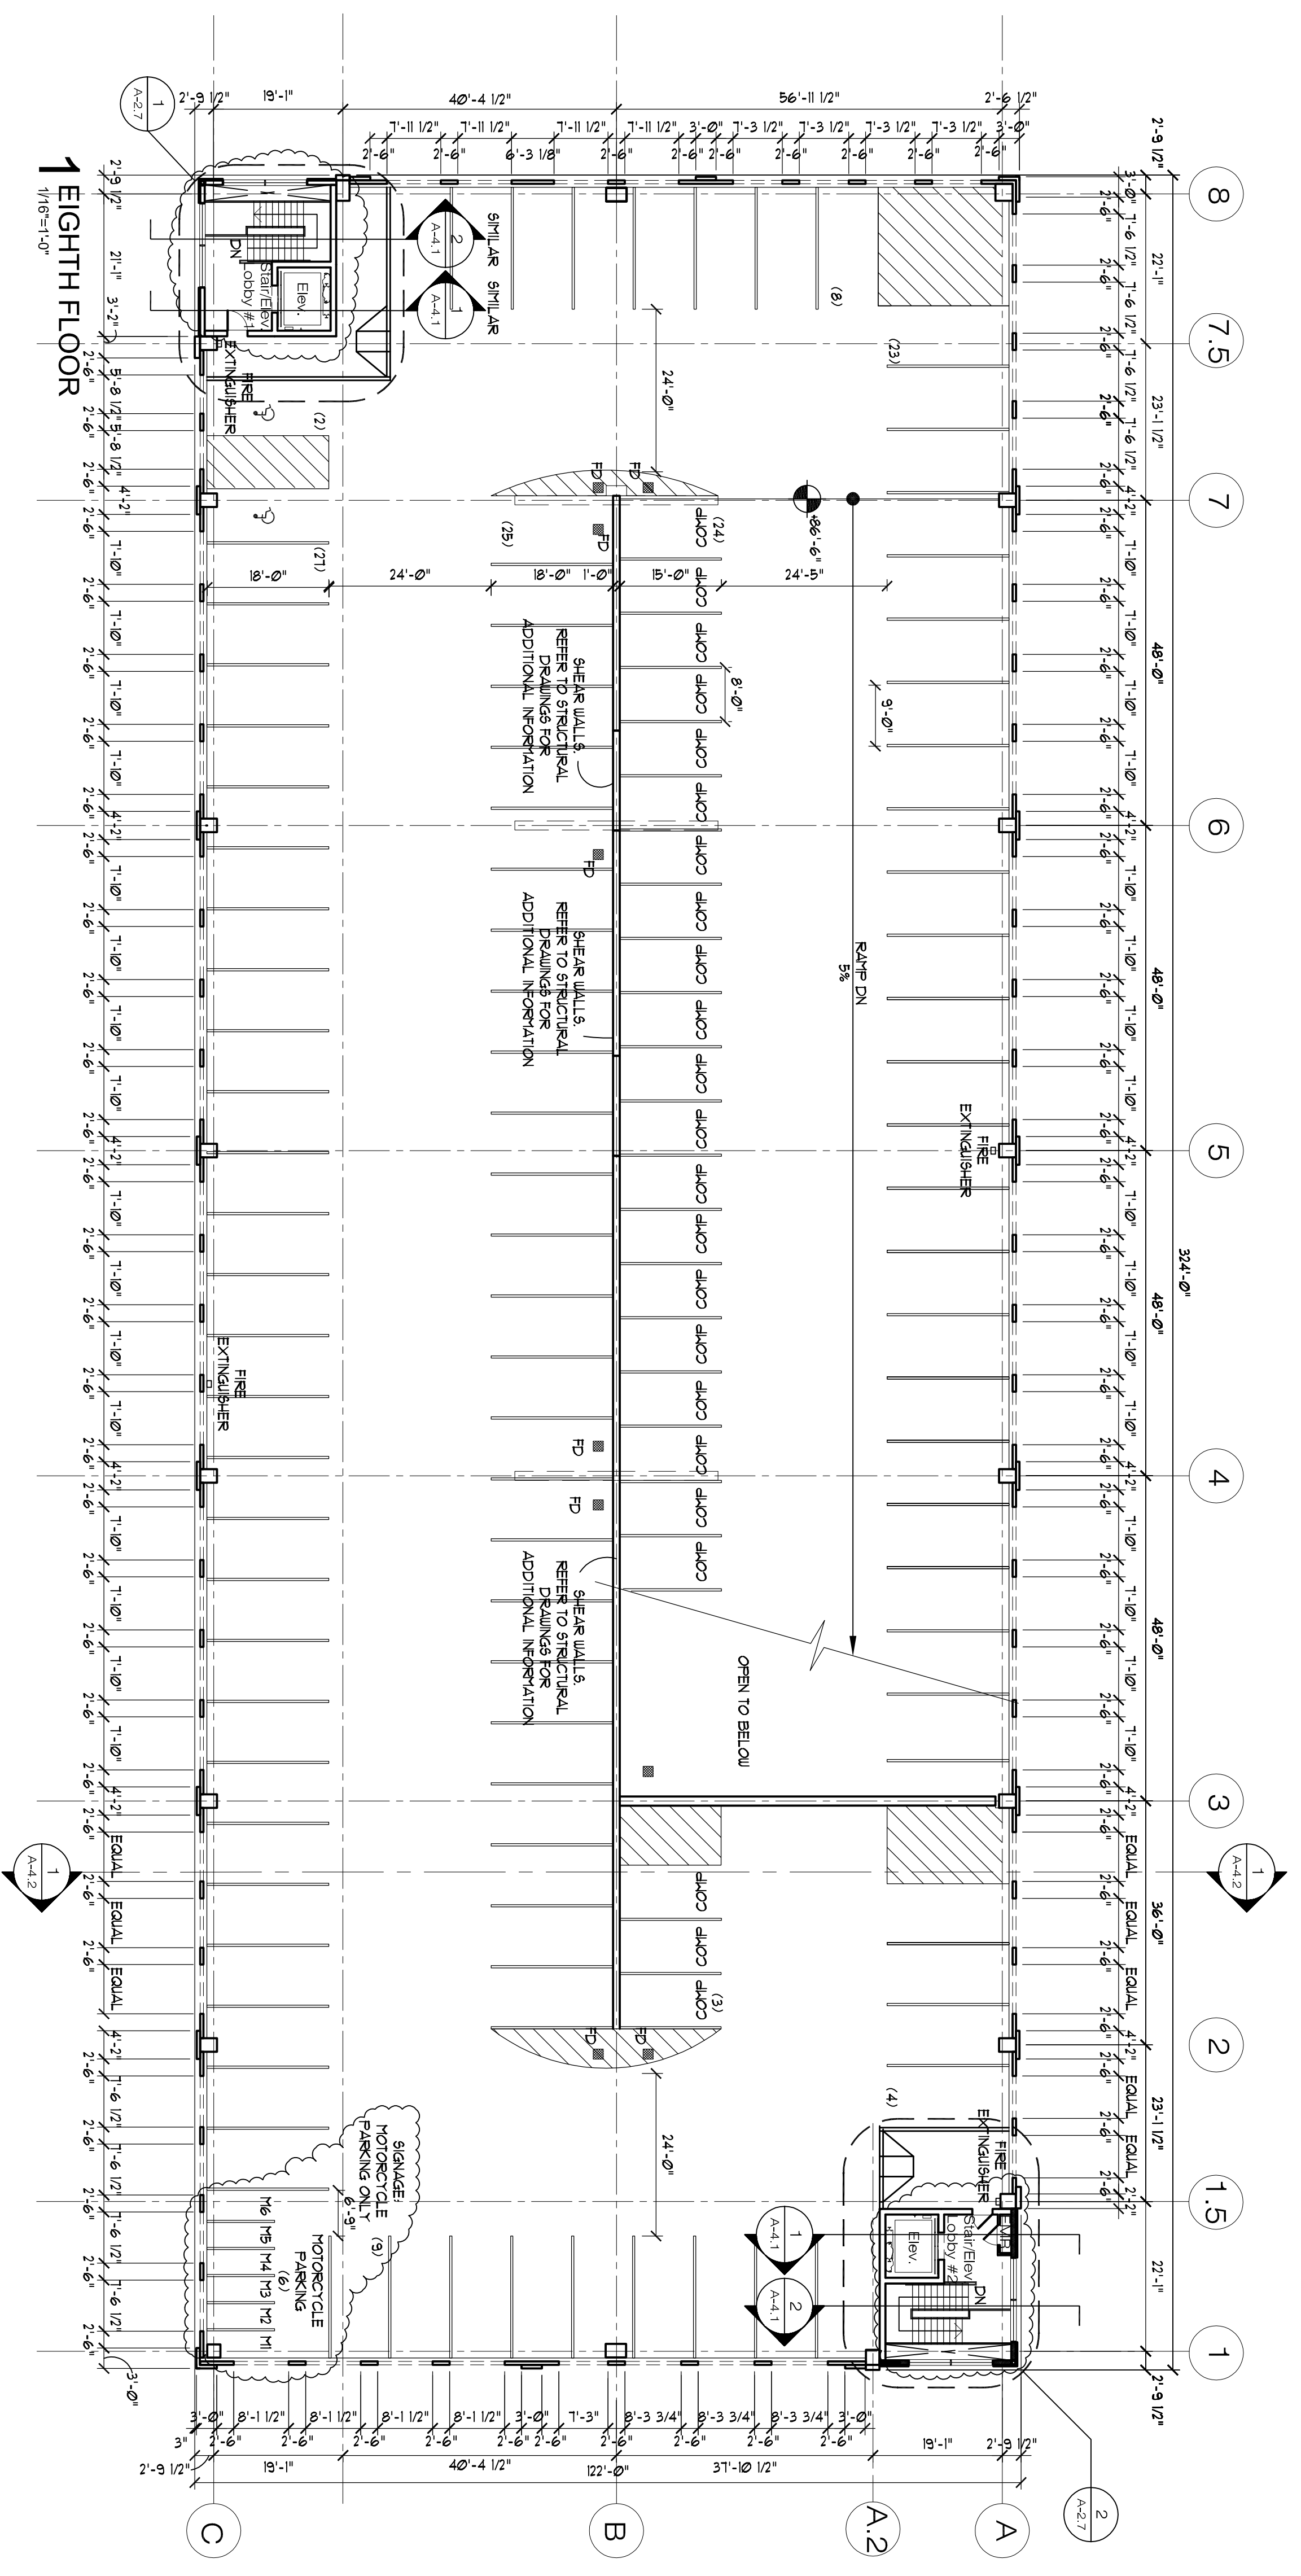

- GENERAL NOTES**
- UNLESS OTHERWISE NOTED ALL DIMENSIONS INDICATED ARE TO THE FACE OR CENTERLINE OF THE WALL STUDS, NOT THE WALL ASSEMBLY.
 - ALL INTERIOR WALLS ARE TO BE U-G WALL TYPE UNLESS OTHERWISE NOTED.
 - ALL EXTERIOR WALLS ARE TO BE U-G UNLESS OTHERWISE NOTED.
 - ALL EXTERIOR WALLS ARE TO BE U-G UNLESS OTHERWISE NOTED.
 - SHIELD DAMP LOCATIONS EXCEPT WHERE BACKER BOARD IS REQUIRED, THE BACKER BOARD IS REQUIRED AT ALL LOCATIONS WHERE TILE IS LOCATED AS DIRECTED BY THE OWNER.
 - REFER TO A-61 FOR FIRE RESISTANCE RATINGS FOR WALLS, FLOORS AND ROOF ASSEMBLIES.
 - REFER TO A-61 FOR FIRE AND SMOKE PENETRATIONS IN RATED WALLS.
 - REFER TO A-61 FOR DOOR TYPES AND DOOR FRAME TYPES.
 - REFER TO A-61 FOR WINDOW TYPES.
 - BLOCKING SHALL BE ADEQUATE TO PROPERLY SUPPORT GYPSUM INSTALLED, UNLESS OTHERWISE NOTED.
 - ALL 2 HR FIRE RATED WALLS SHALL BE CONTIGUOUS IN PLAN AND VERTICAL IN SECTION, ANY ONE HOUR OR NON-RATED ASSEMBLY SHALL NOT PENETRATE THE TWO HOUR ASSEMBLY.
 - ALL PLAYING FIXTURES SHALL BE SEALED TO ADJACENT MATERIALS WITH APPROPRIATE SEALANT.
 - REFER TO A-61 FOR FIRE EXTINGUISHER RATING. A FIRE EXTINGUISHER CABINET, FE/C DENOTES A FIRE EXTINGUISHER VALVE CABINET, FE/C DENOTES A FIRE EXTINGUISHER HOSE CABINET, VZ DENOTES A VALVE CABINET, FHC DENOTES A FIRE HOSE CABINET.
 - CL DENOTES A CONTROL JOINT; REFER TO STRUCTURAL DRAWINGS FOR LOCATION AND DETAILS.
 - CONCRETE SHALL BE CAST IN PLACE OR PRECAST CONCRETE UNIT FACILITY DESIGN/BUILD BY OTHERS. REFER TO STRUCTURAL DRAWINGS FOR ADDITIONAL INFORMATION.
 - REFER TO GEOTECHNICAL REPORT FOR ADDITIONAL SOILS INFORMATION.

Permit Set