




**(A) 4' GRANITE HEADSTONE FOR CATCH BASIN INLET**  
N.T.S.

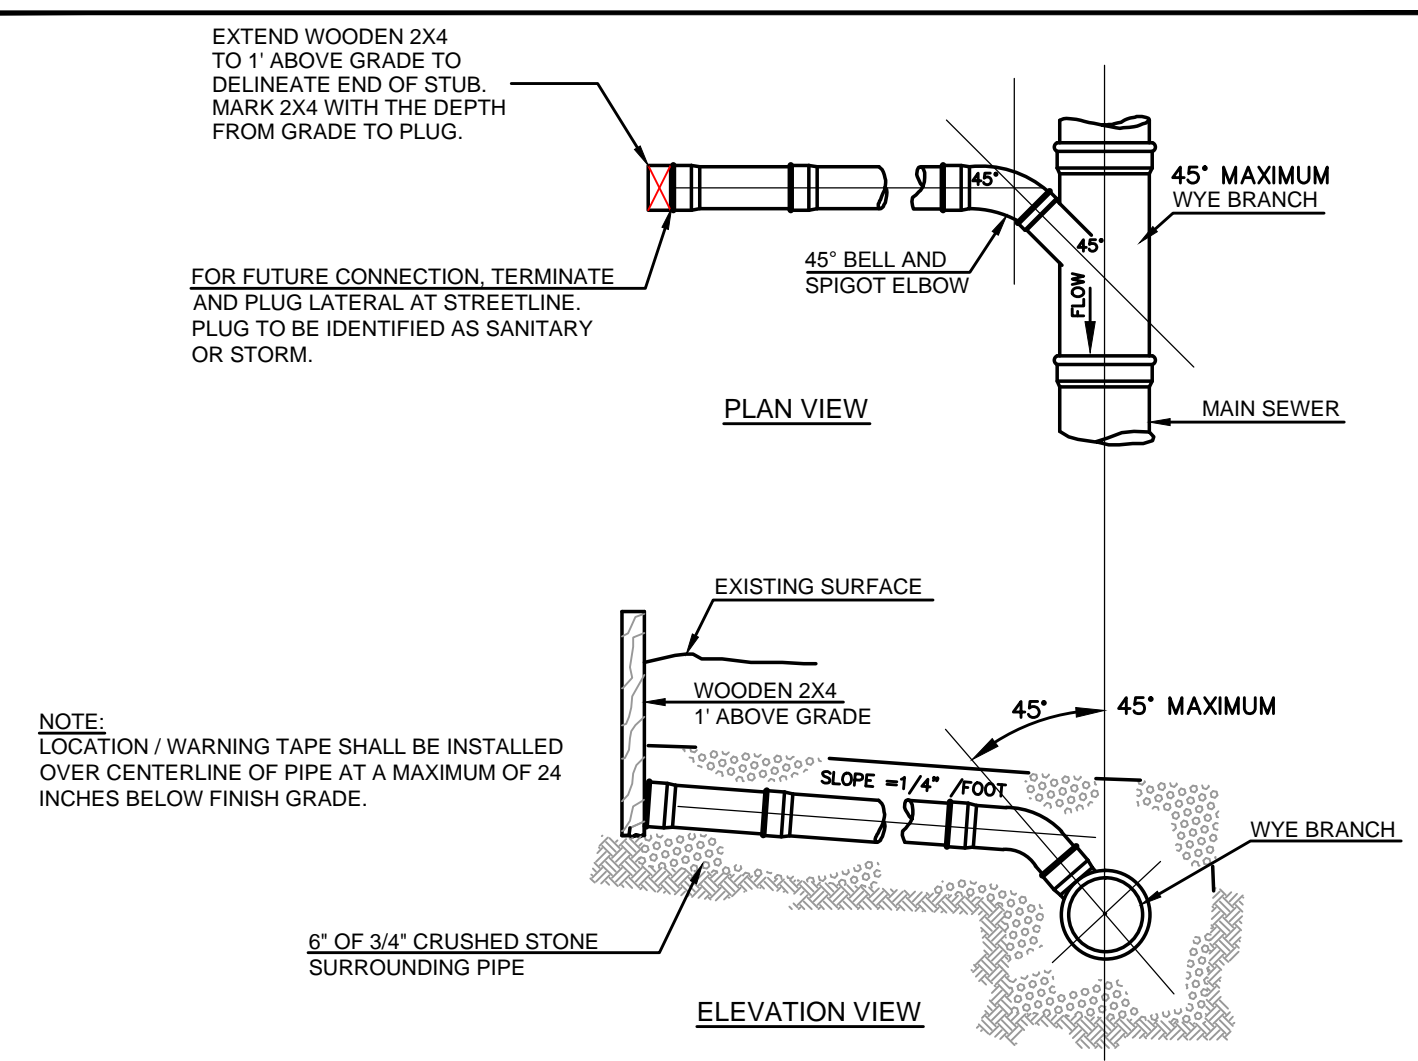


**(D) TYPICAL LATERAL TEE/WYE CONNECTION**  
N.T.S.

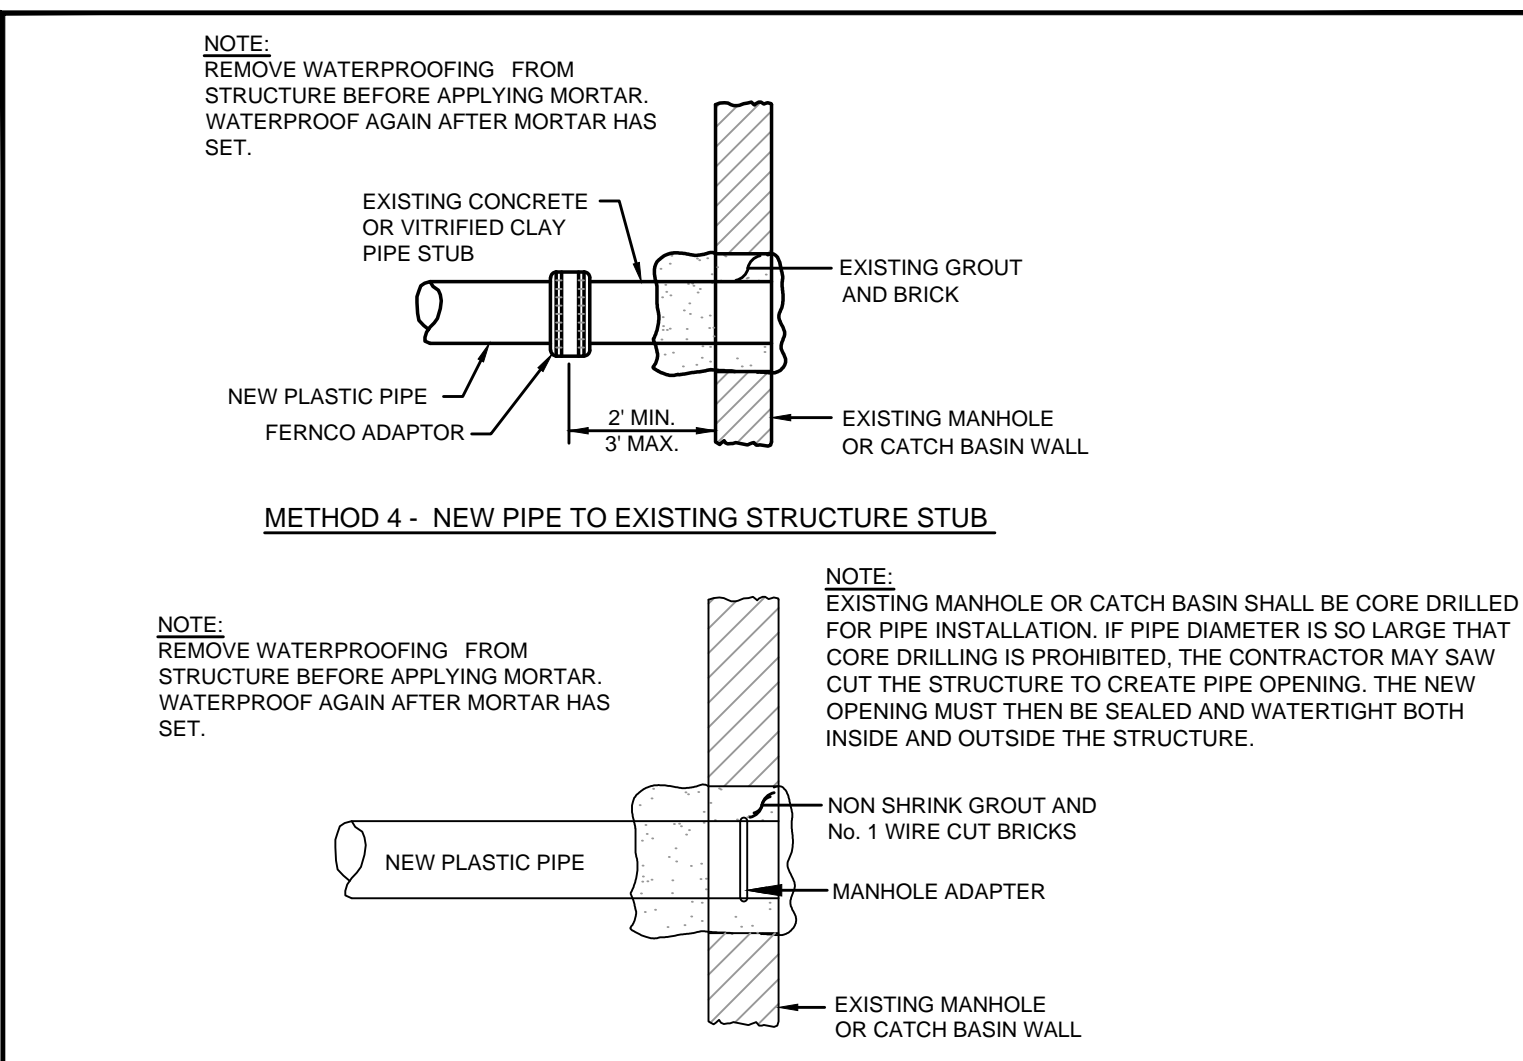


**(G) PLASTIC PIPE CONNECTION METHODS 3 & 4**  
N.T.S.

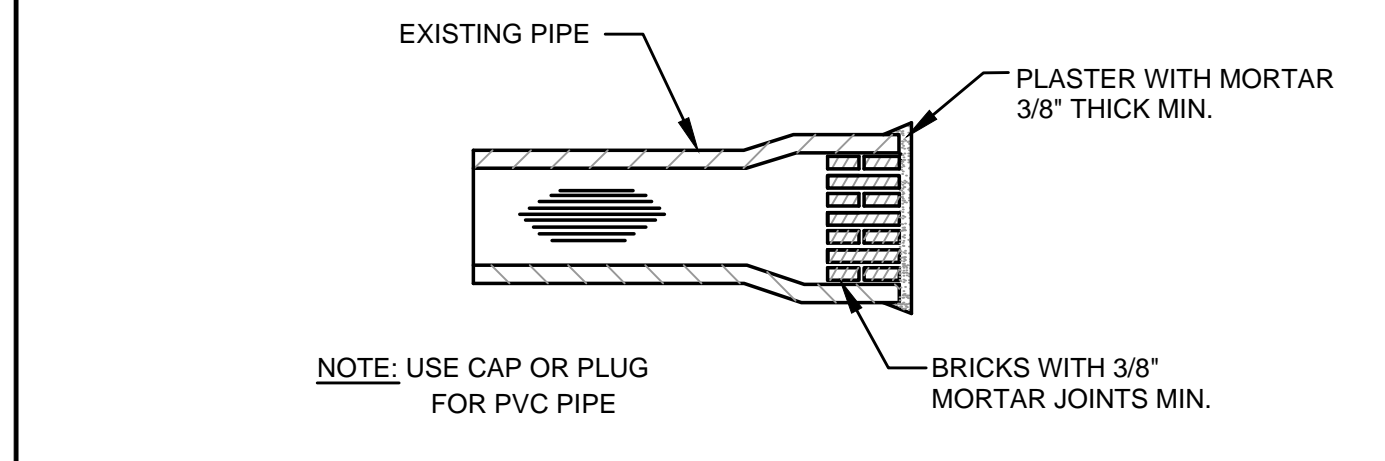



**(I) MASONRY PLUG**  
N.T.S.

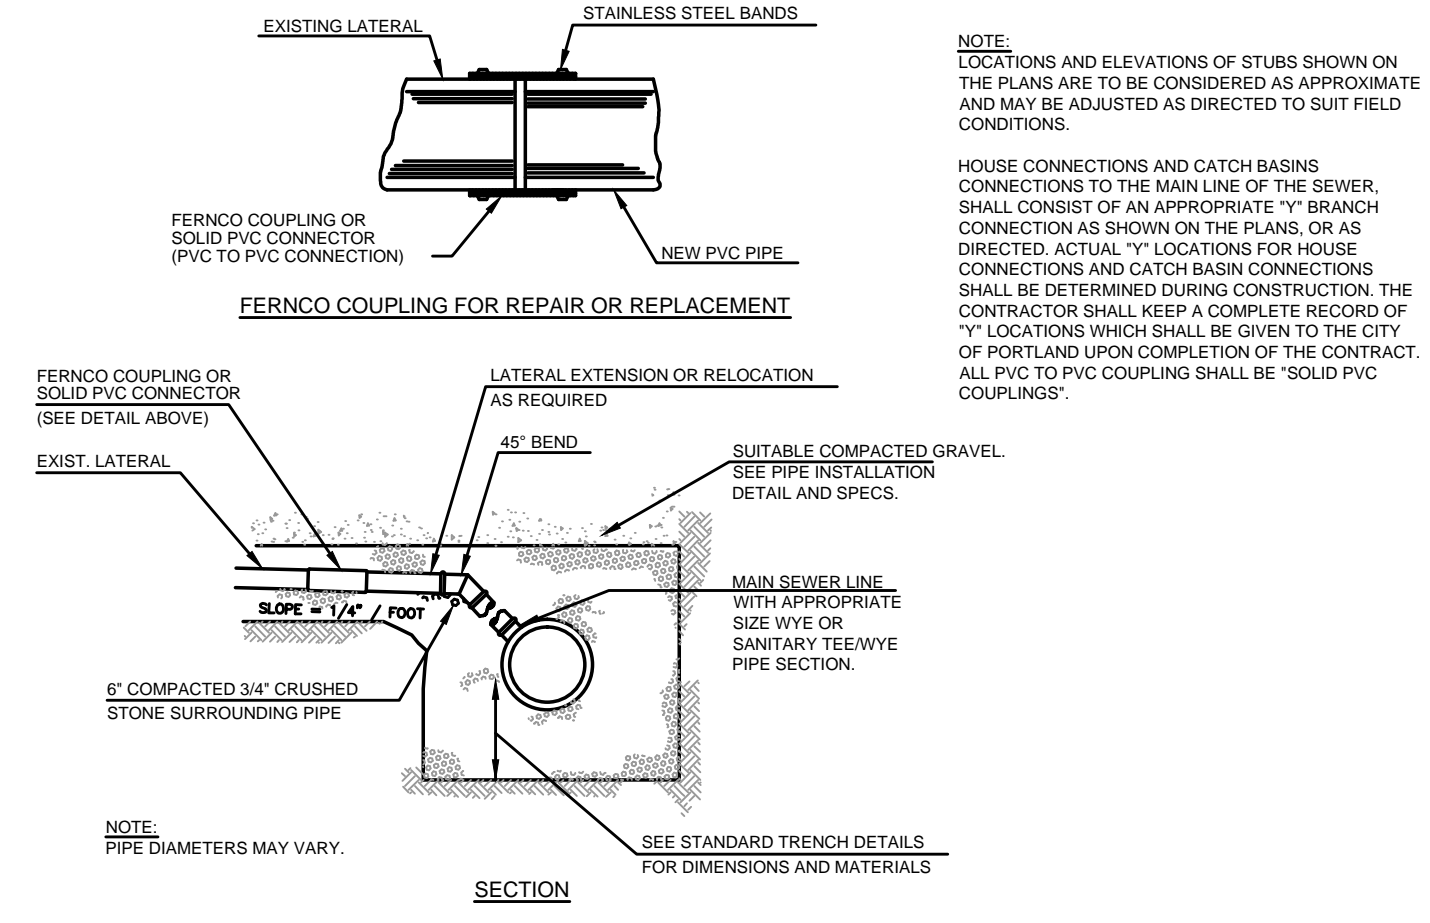


**(B) TYPICAL EXISTING LATERAL CONNECTION**  
N.T.S.

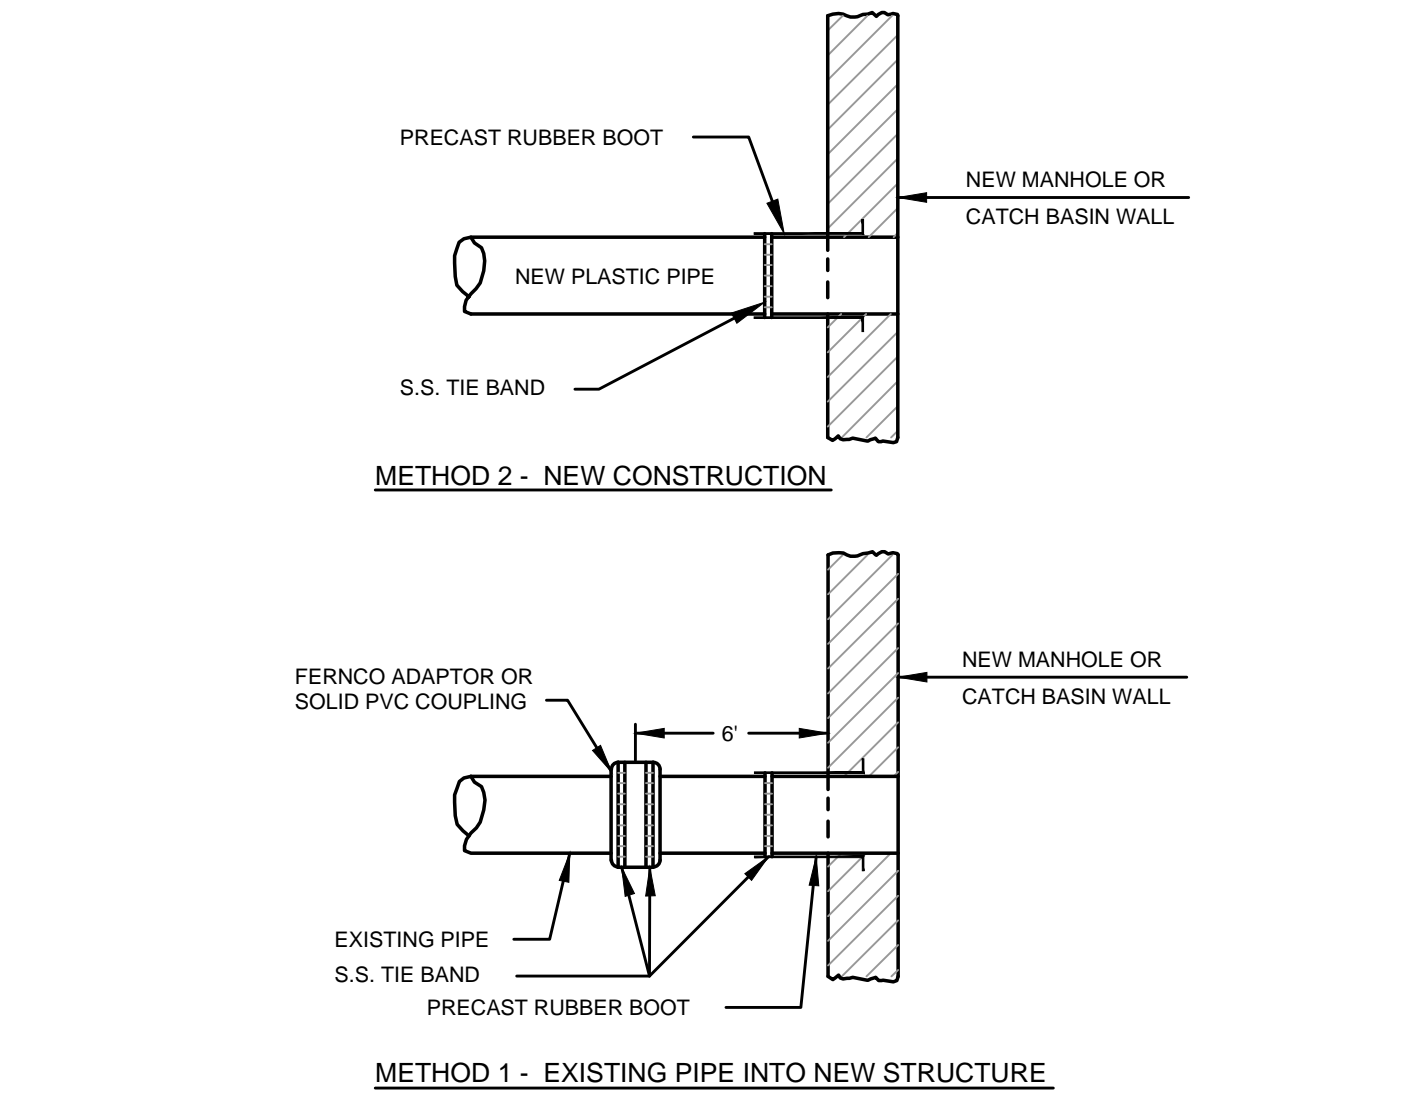


**(E) PLASTIC PIPE CONNECTION METHODS 1 & 2**  
N.T.S.

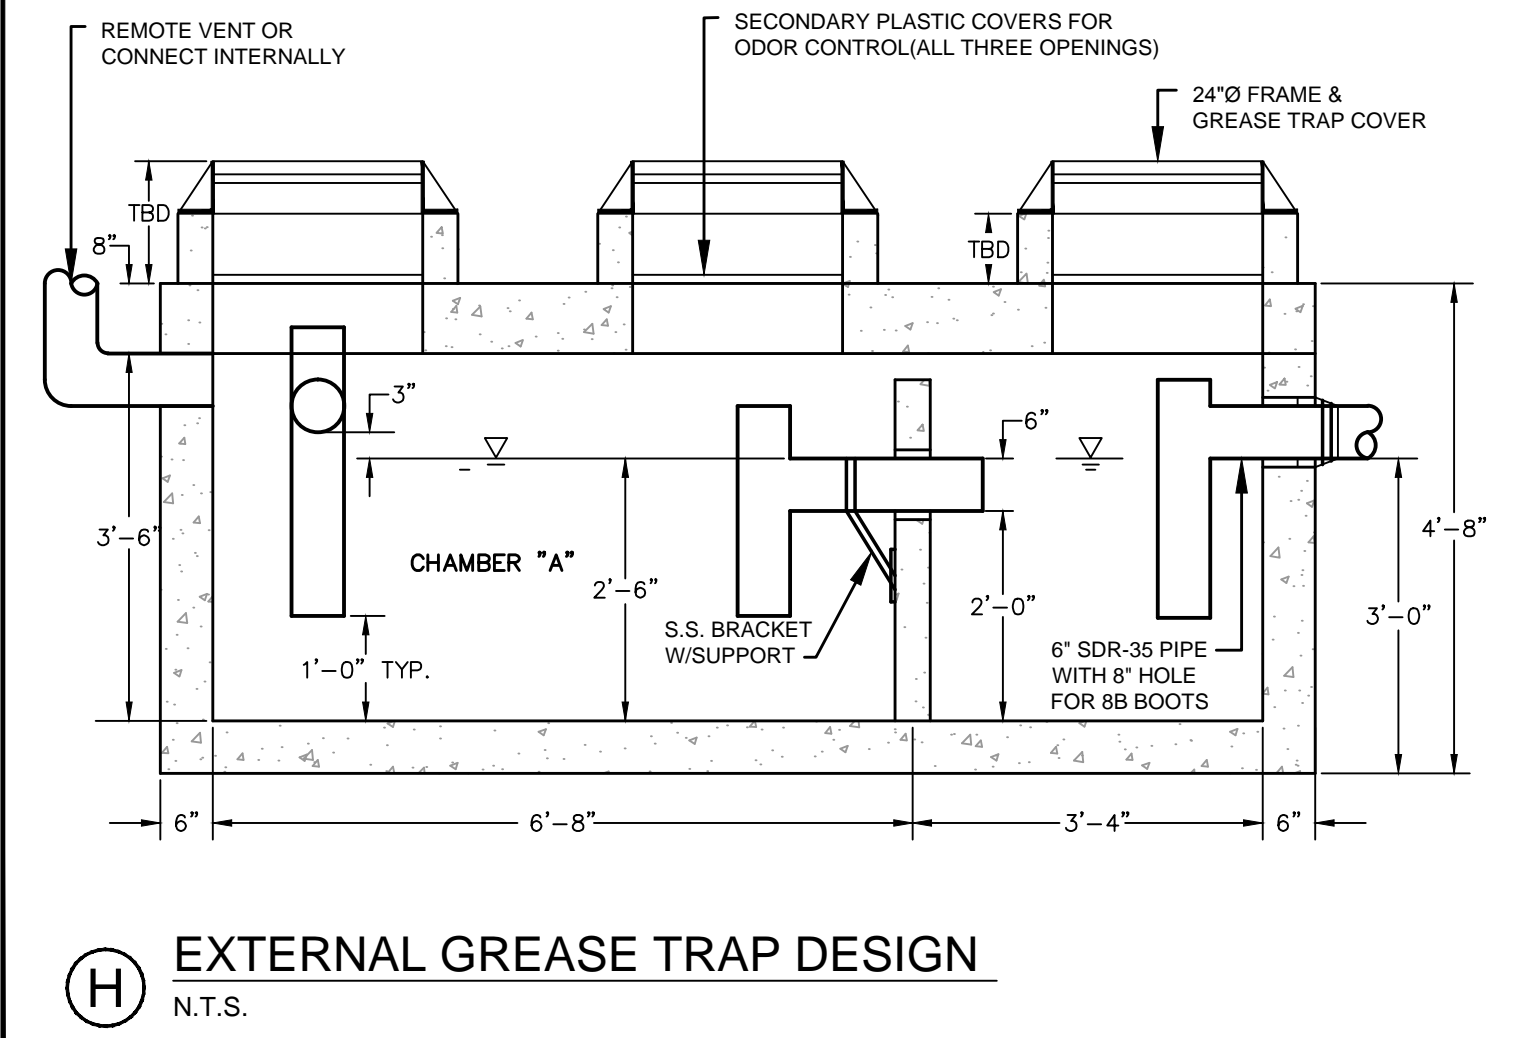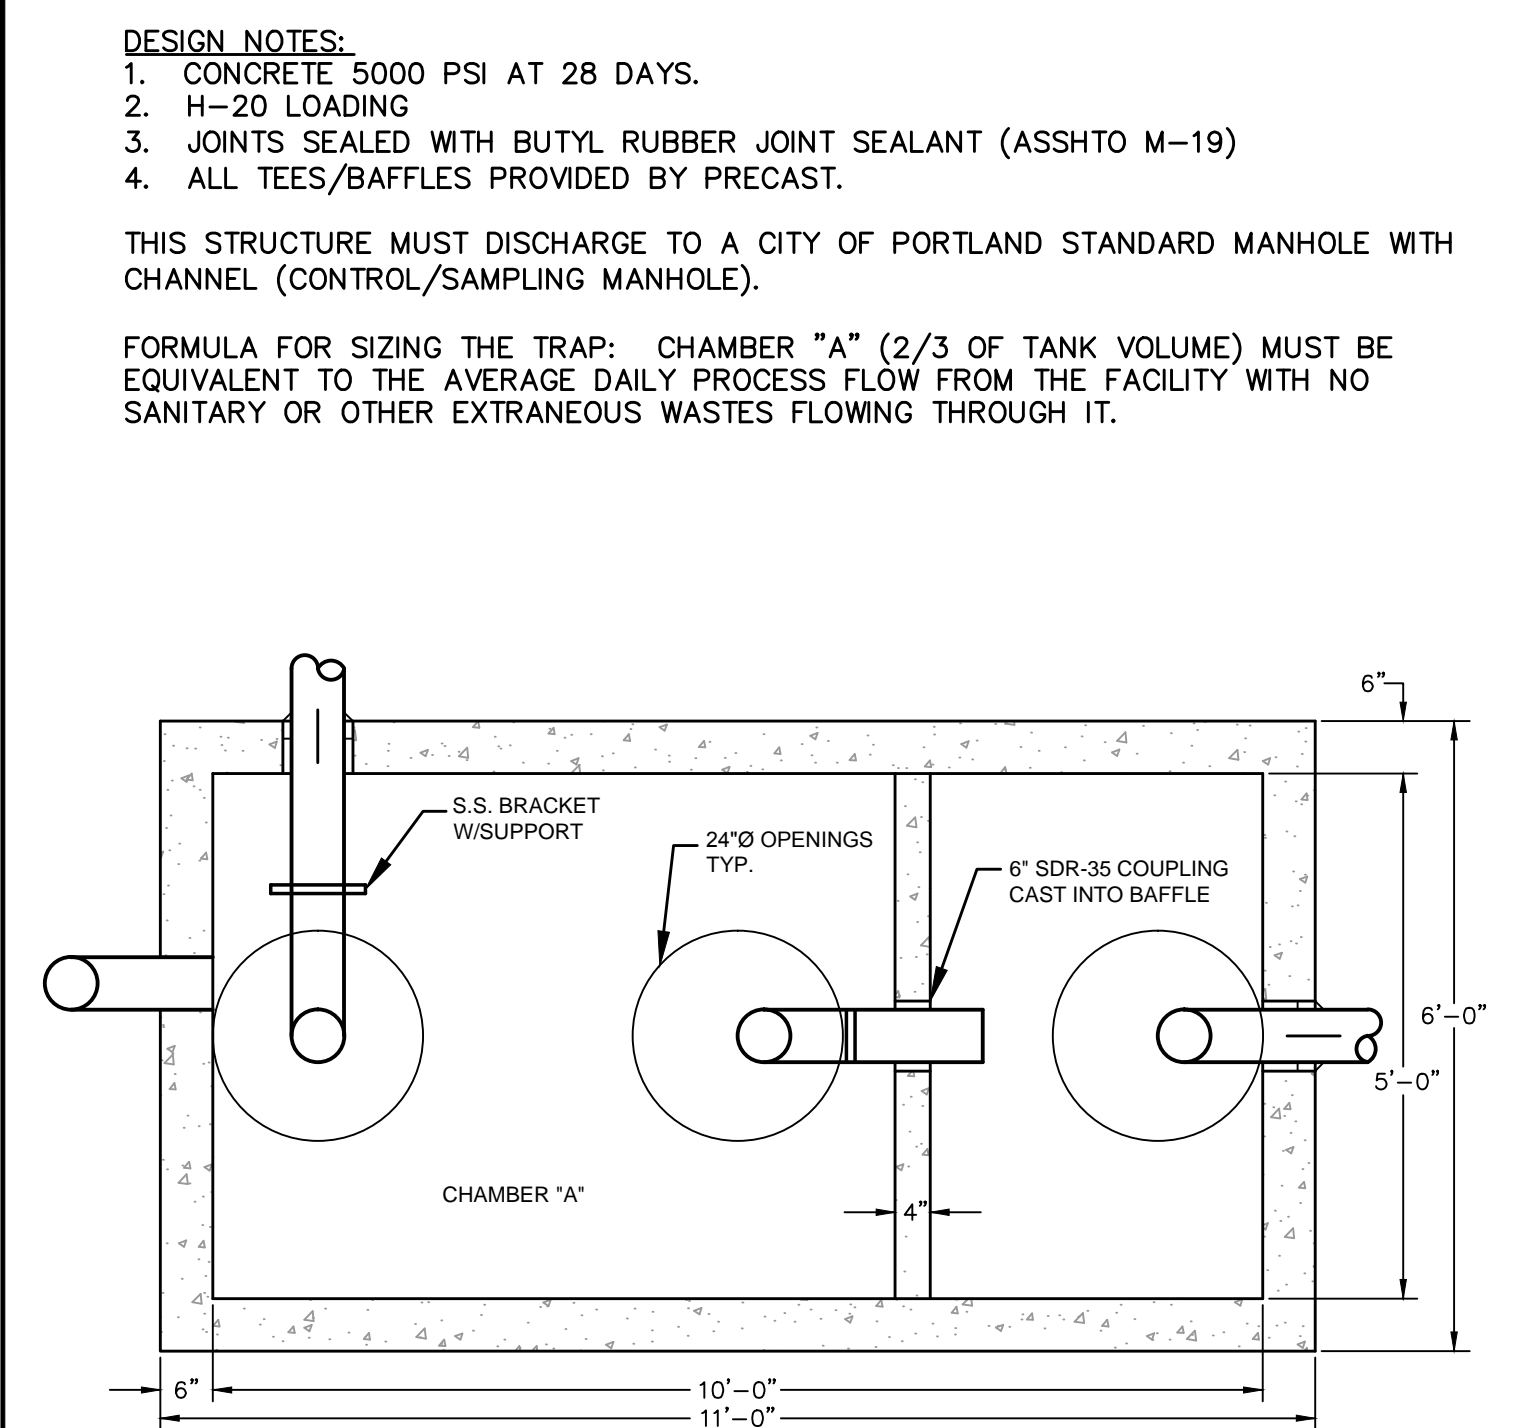

**(H) EXTERNAL GREASE TRAP DESIGN**  
N.T.S.

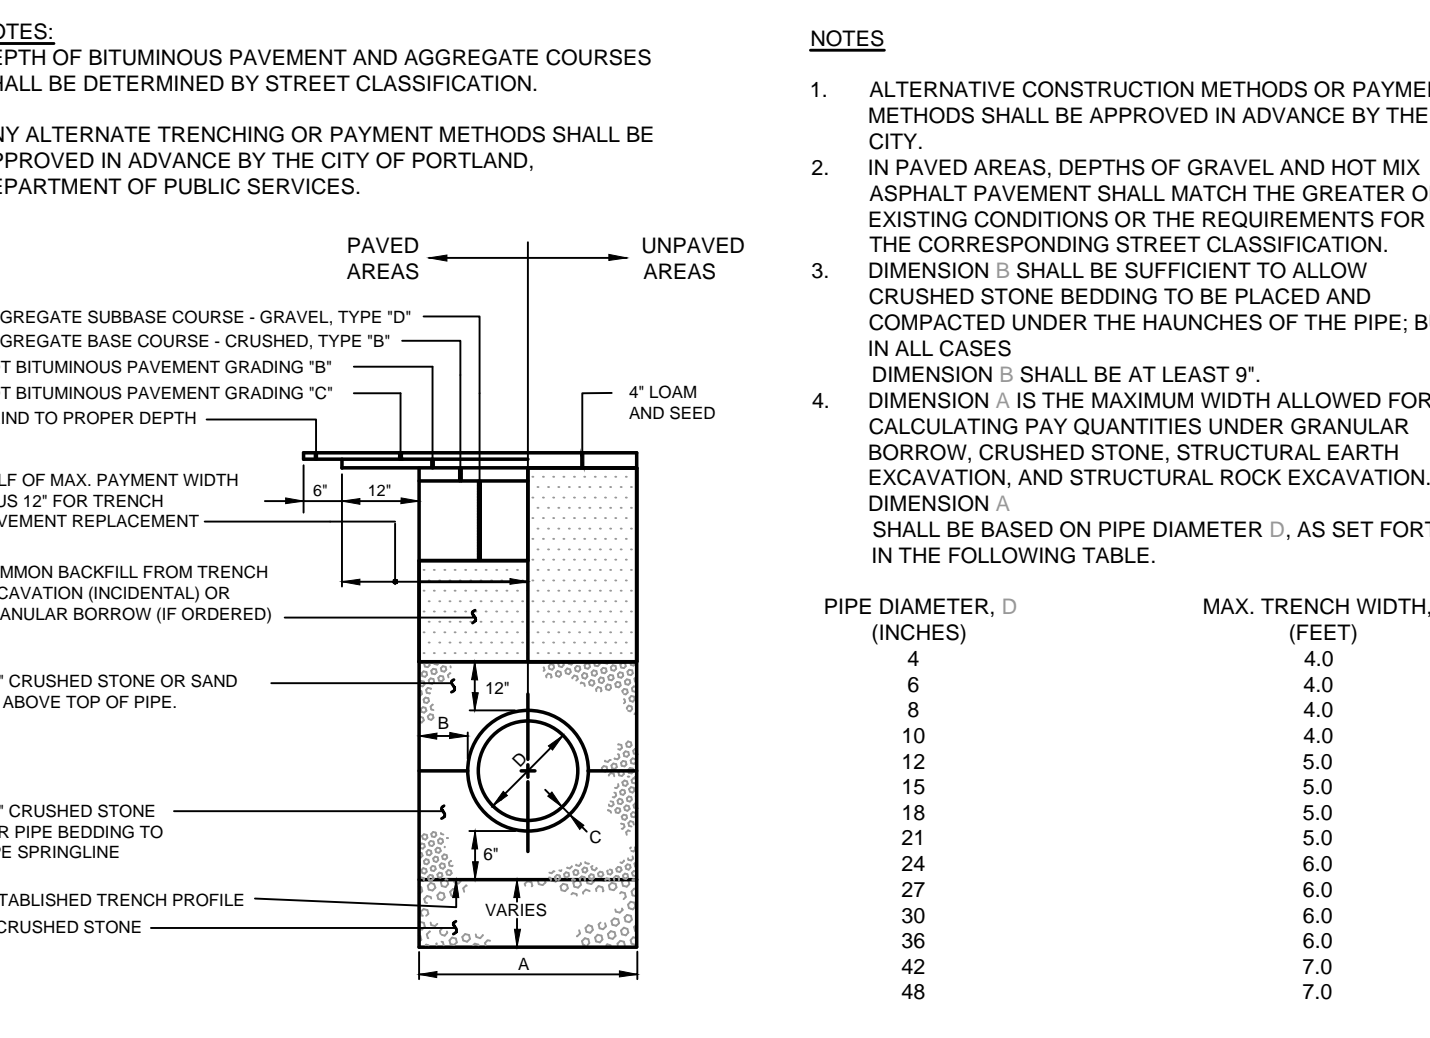


**(C) TYPICAL TRENCH INSTALLATION AND NOTES**  
N.T.S.

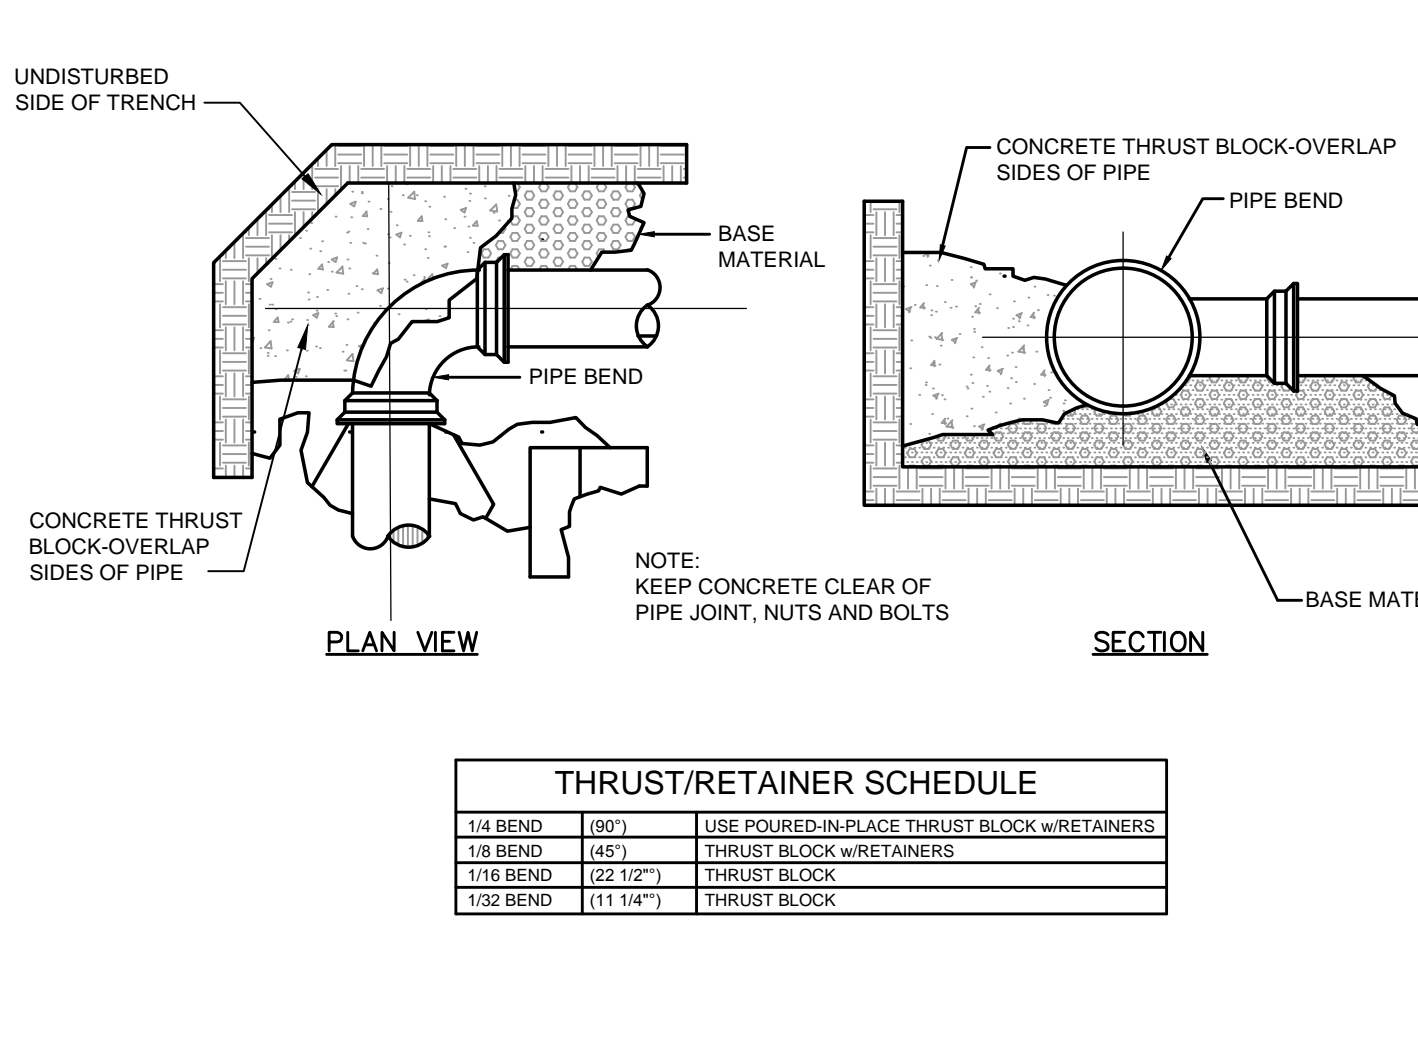

**(F) FORCE MAIN CONCRETE THRUST BLOCK PLACEMENT ON VERTICAL & HORIZONTAL BENDS**  
N.T.S.

PRELIMINARY - NOT FOR CONSTRUCTION

REV	DATE	DESCRIPTION	REVISIONS
3	04.25.16	FINAL SITE PLANS WITH CONDITIONS OF APPROVAL	
2	02.17.16	FINAL SITE PLANS WITH CONDITIONS OF APPROVAL	
1	11.14.14	FINAL LEVEL III SUBMISSION TO CITY OF PORTLAND	

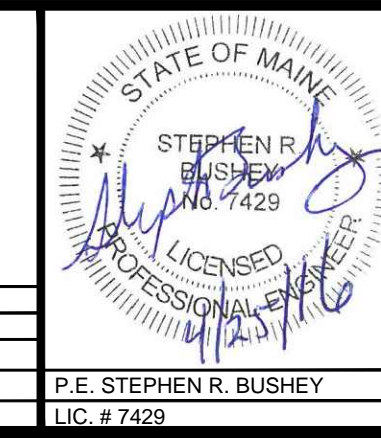

PROJECT	midtown PORTLAND, MAINE
SHEET TITLE	SANITARY SEWER AND STORM DRAIN DETAILS
CLIENT	FEDEQ DV001, LLC

<b>FST</b> 100 YEARS	<b>FAY, SPOFFORD &amp; THORNDIKE</b> ENGINEERS • PLANNERS • SCIENTISTS 778 MAIN ST., SUITE 8, SOUTH PORTLAND, ME 04106 FORMERLY DELUCA-HOFFMAN ASSOCIATES
DRAWN: DED	DATE: OCTOBER 2014
DESIGNED: BEK	SCALE: NTS
CHECKED: SRB	JOB NO. 195350127
FILE NAME: 3062-DETAIL SHEETS	
SHEET	C-7.4