



Eighth Floor
Scale: 1/16"=1'-0"

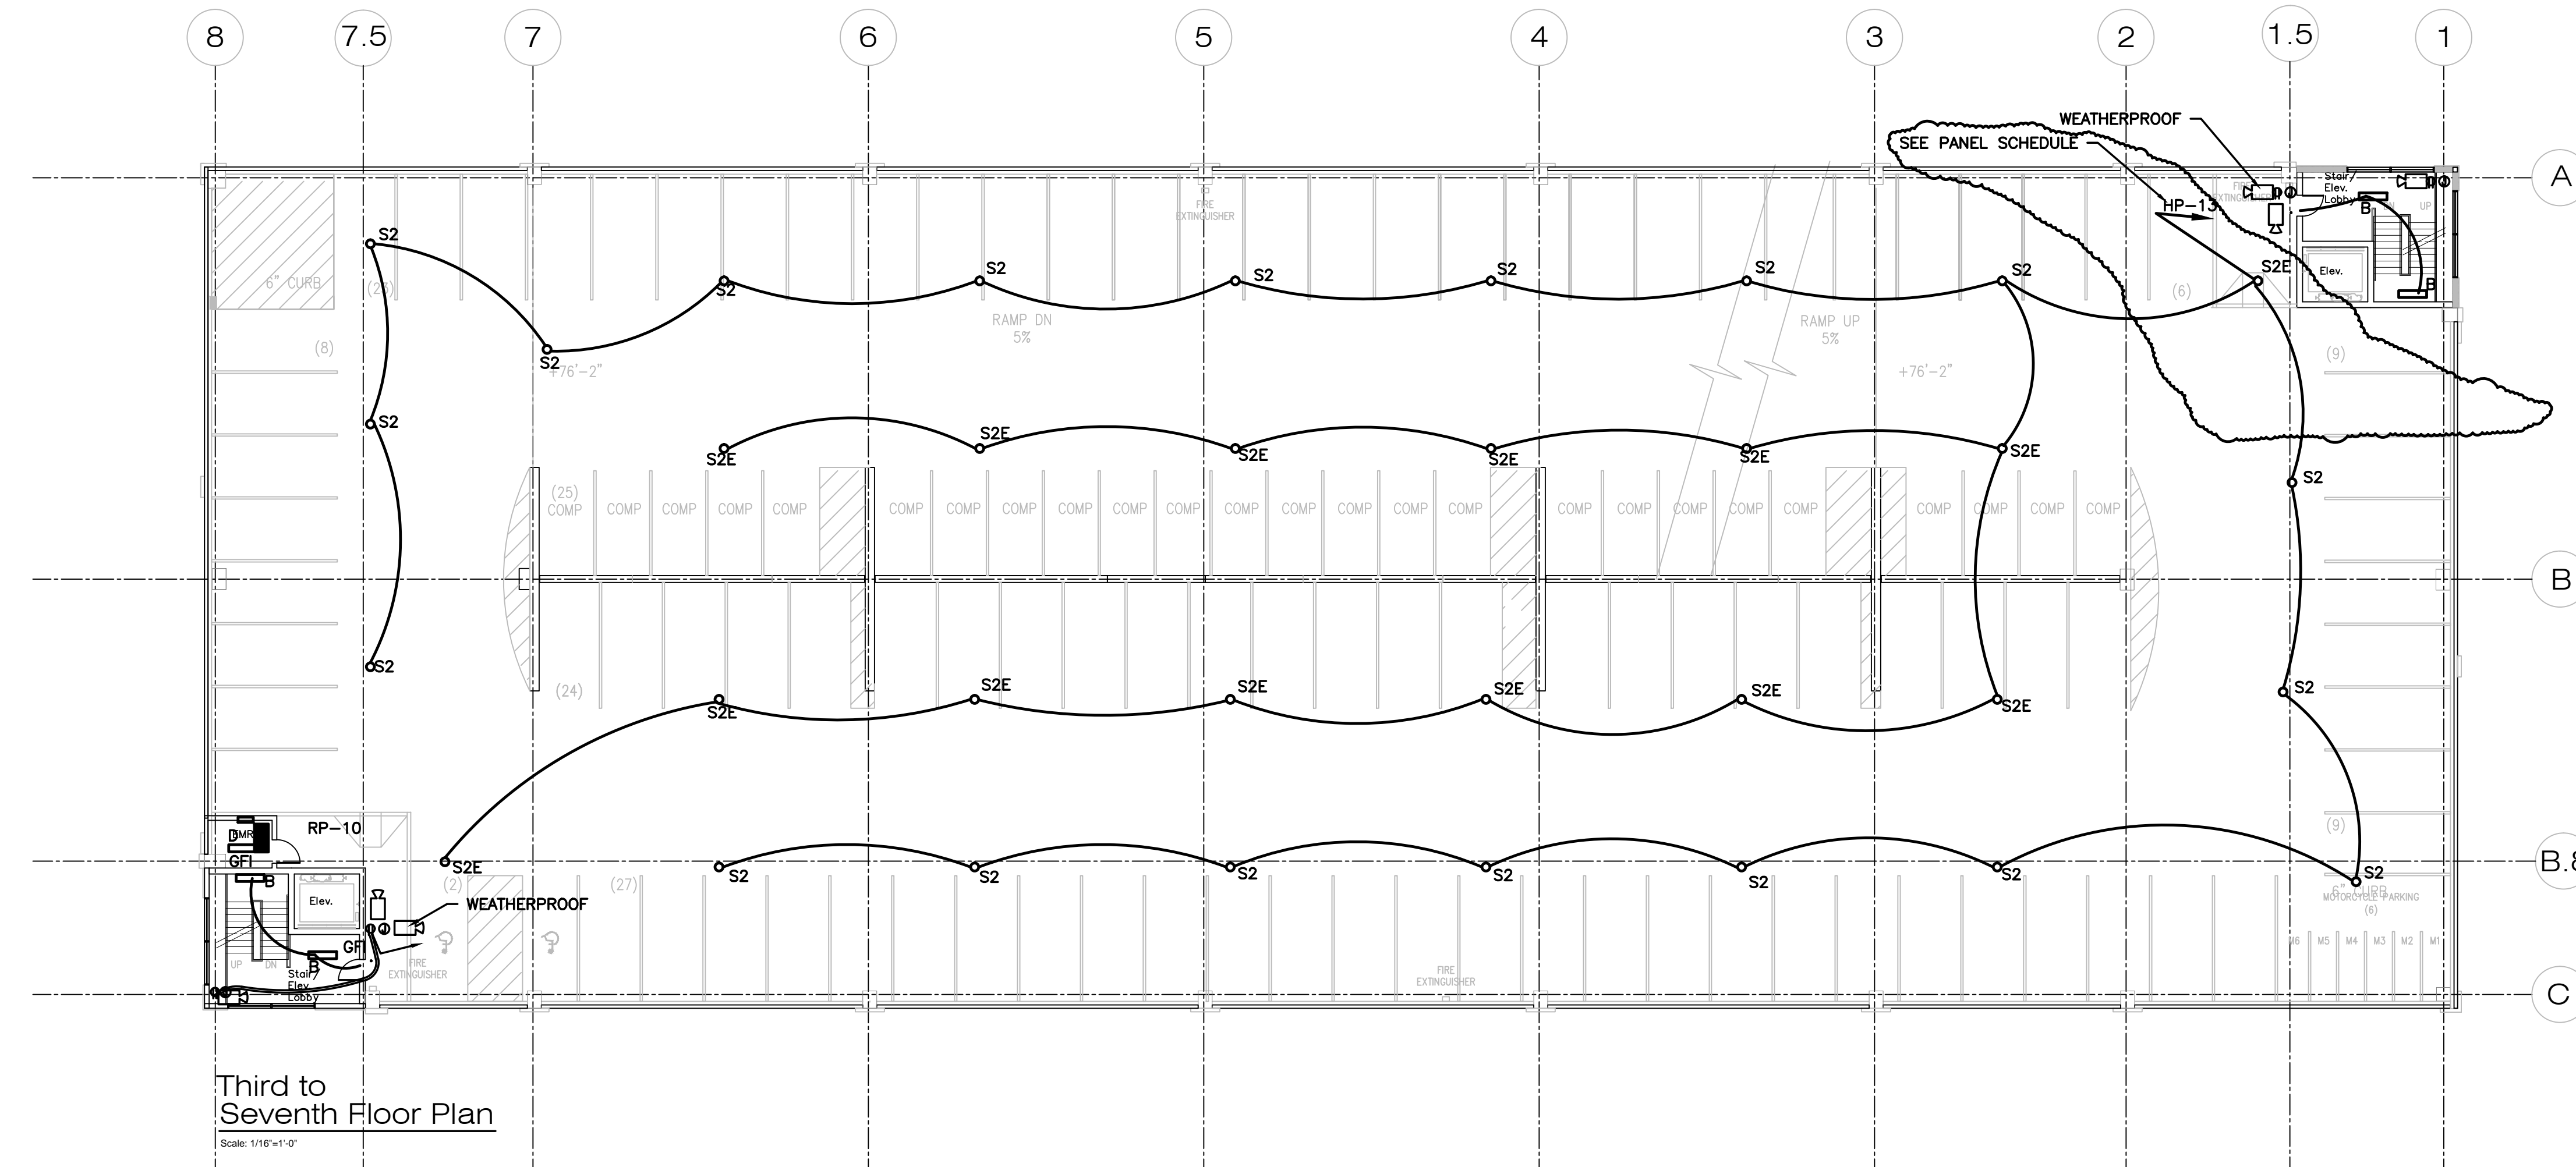

Third to Seventh Floor Plan
Scale: 1/16"=1'-0"

Revised Permit Set March 8, 2018
 Revised Permit Set April 15, 2016
 Permit Set February 8, 2016

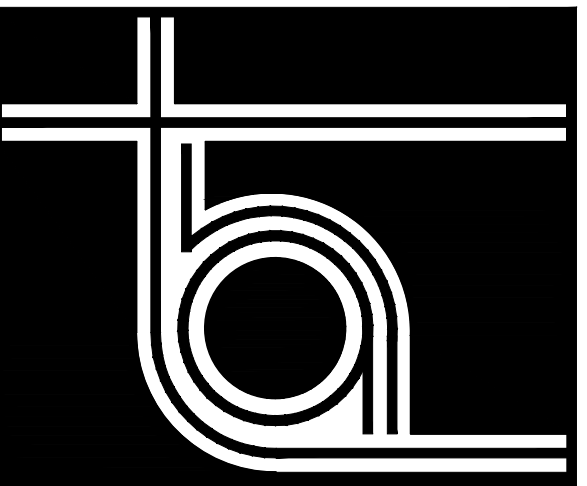

THA ARCHITECTS, LLC

ARCHITECTURE • DESIGN • PLANNING • INTERIOR DESIGN
 105 WILLOW BROOK AVENUE
 STRATHAM, NEW HAMPSHIRE 03885
 Tel: (603) 770-2491 Fax: (603) 773-0238
 www.thaarc.com

These drawings and specifications were prepared for use at the location indicated. Publication and use is expressly limited to the identified location. Reuse or reproduction by any method, in whole or in part, is prohibited without the written permission of THA Architects, LLC.
 © THA Architects, LLC.



midtown Portland

Somerset Street
 Elm Street
 Portland, ME

**Building 2
 Roof & 7th
 ELECTRICAL
 PLANS**

Structural Engineer
 Becker Engineering
 MEP ENGINEER
 McCabe Associates
 FP Engineer
 McCabe Associates

SCALE: 1/16"=1'-0"
 ISSUED / DRAWN BY _____
 2/8/16
 © THA Architects, LLC
 REVISED / REVISED BY _____

JOB NO: 15001

SHEET NUMBER
E-1.3