

THA ARCHITECTS, LLC

ARCHITECTURE • DESIGN • PLANNING • INTERIOR DESIGN  
105 WILLOW BROOK AVENUE  
STRATHAM, NEW HAMPSHIRE 03885  
Tel: (603) 770-2491 Fax: (603) 773-0238  
www.thaarc.com

These drawings and specifications were prepared for use at the location indicated. Publication and use is expressly limited to the identified location. Reuse or reproduction by any method, in whole or in part, is prohibited without the written permission of THA Architects, LLC.  
© THA Architects, LLC.



midtown Portland

Somerset Street  
Elm Street  
Portland, ME

Building 2  
ROOF & 7TH  
SPRINKLER  
PLAN & DETAILS

Structural Engineer  
Becker Engineering  
MEP ENGINEER  
McCabe Associates  
FP Engineer  
McCabe Associates


SCALE: 1/16"=1'-0"

ISSUED / DRAWN BY  
2/8/16


REVISOR / REVISED BY

JOB NO: 15001

SHEET NUMBER  
SP-1.2

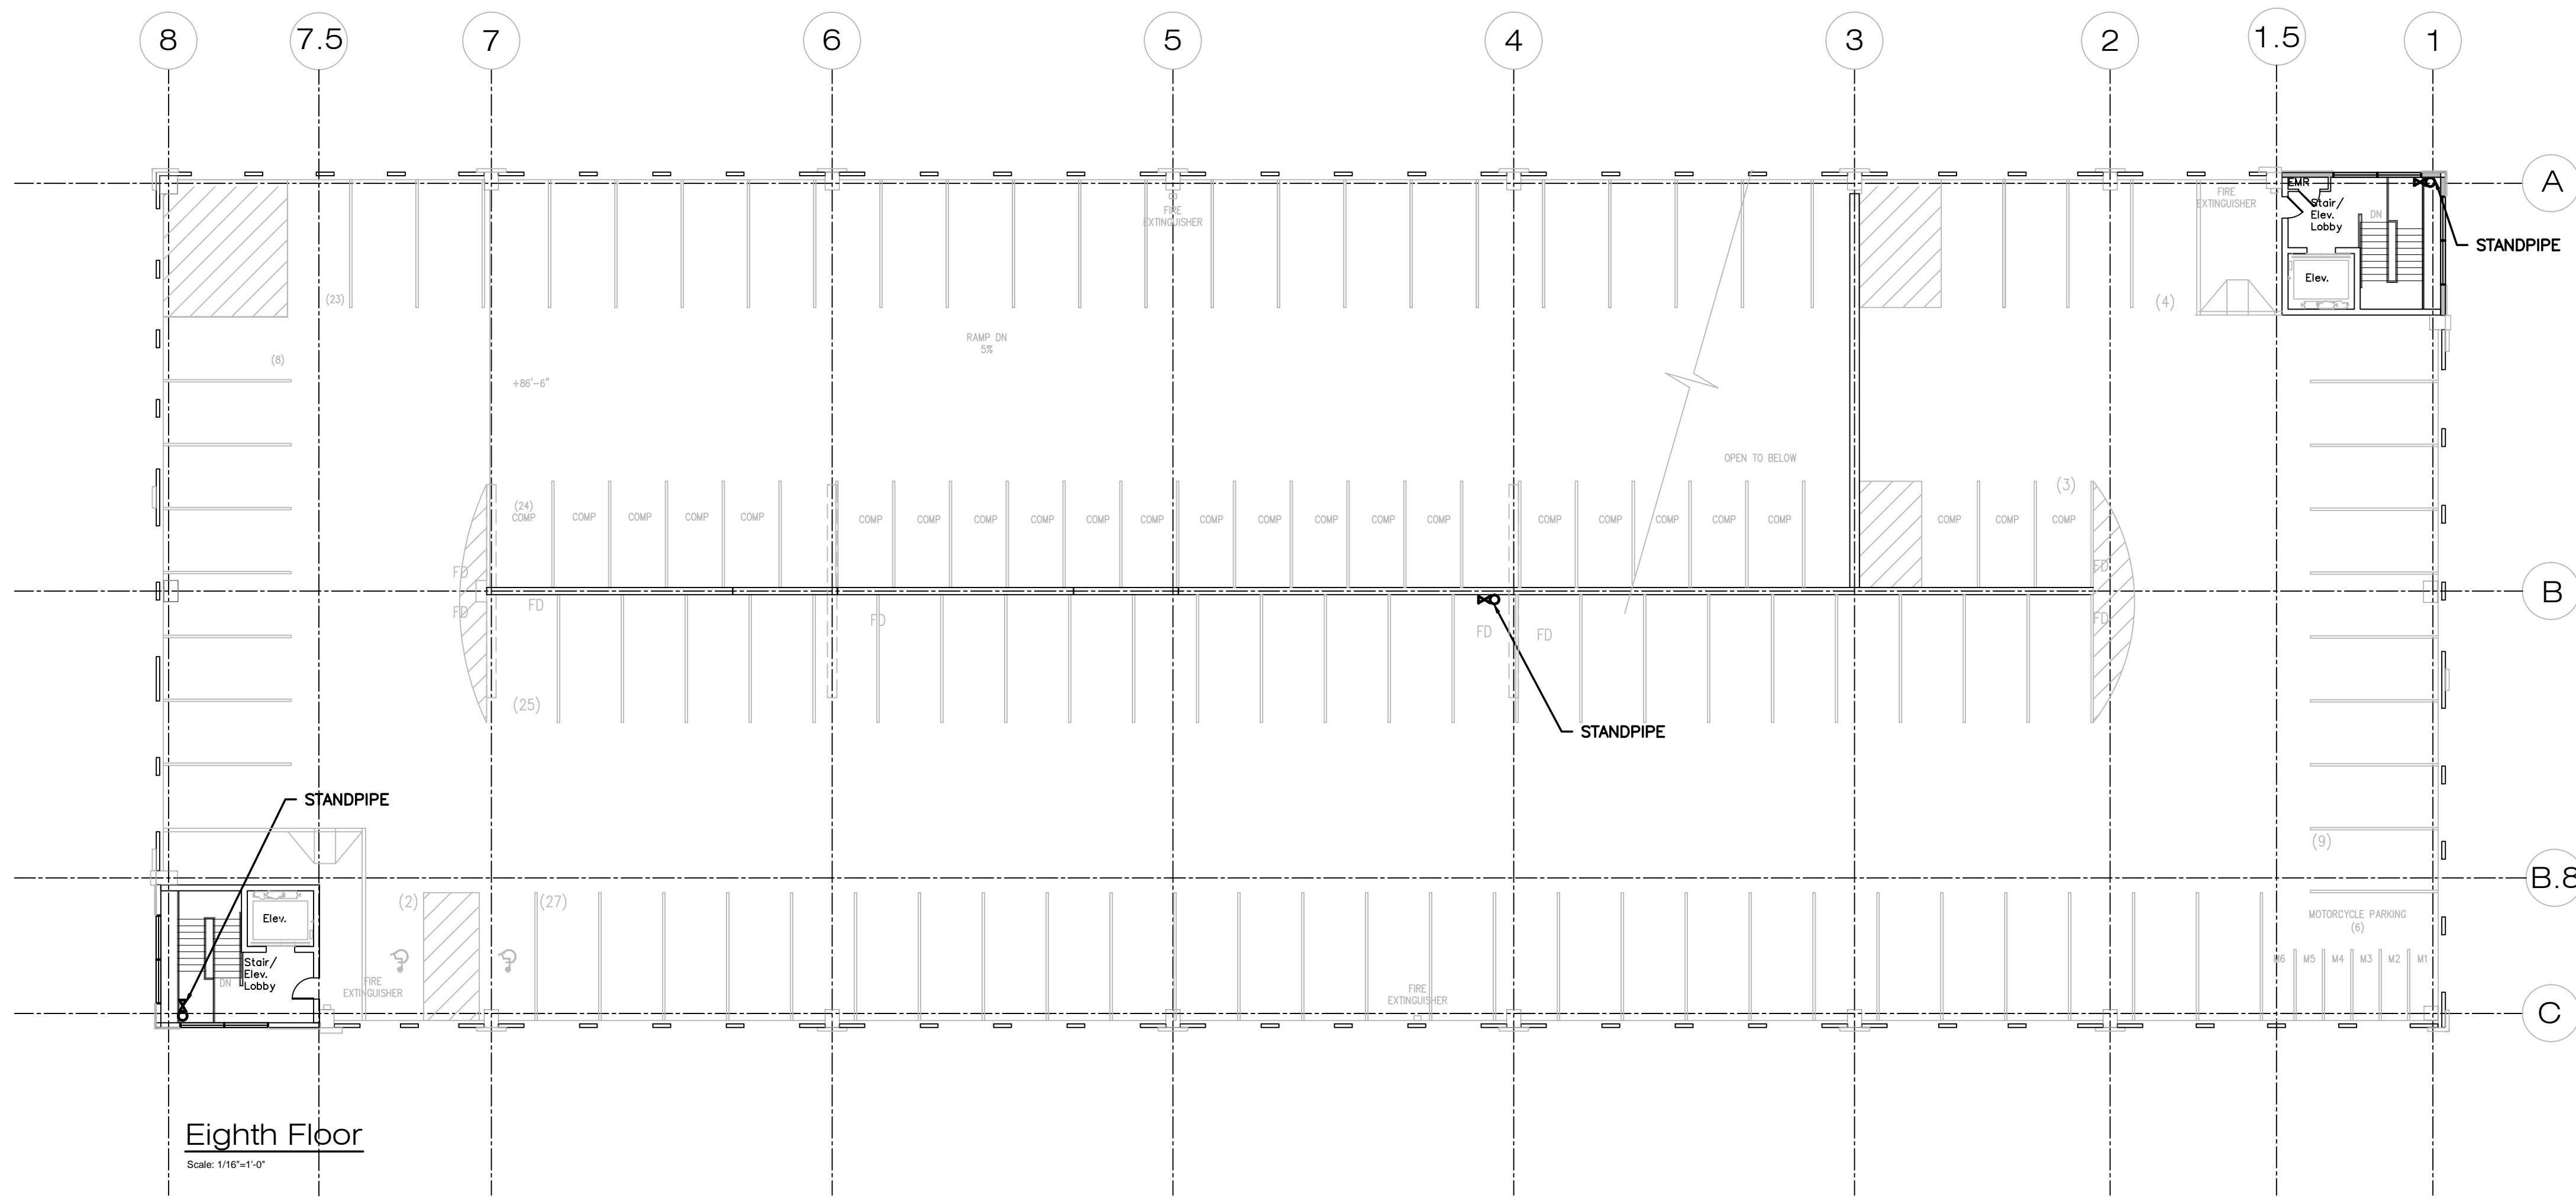

Eighth Floor  
Scale: 1/16"=1'-0"

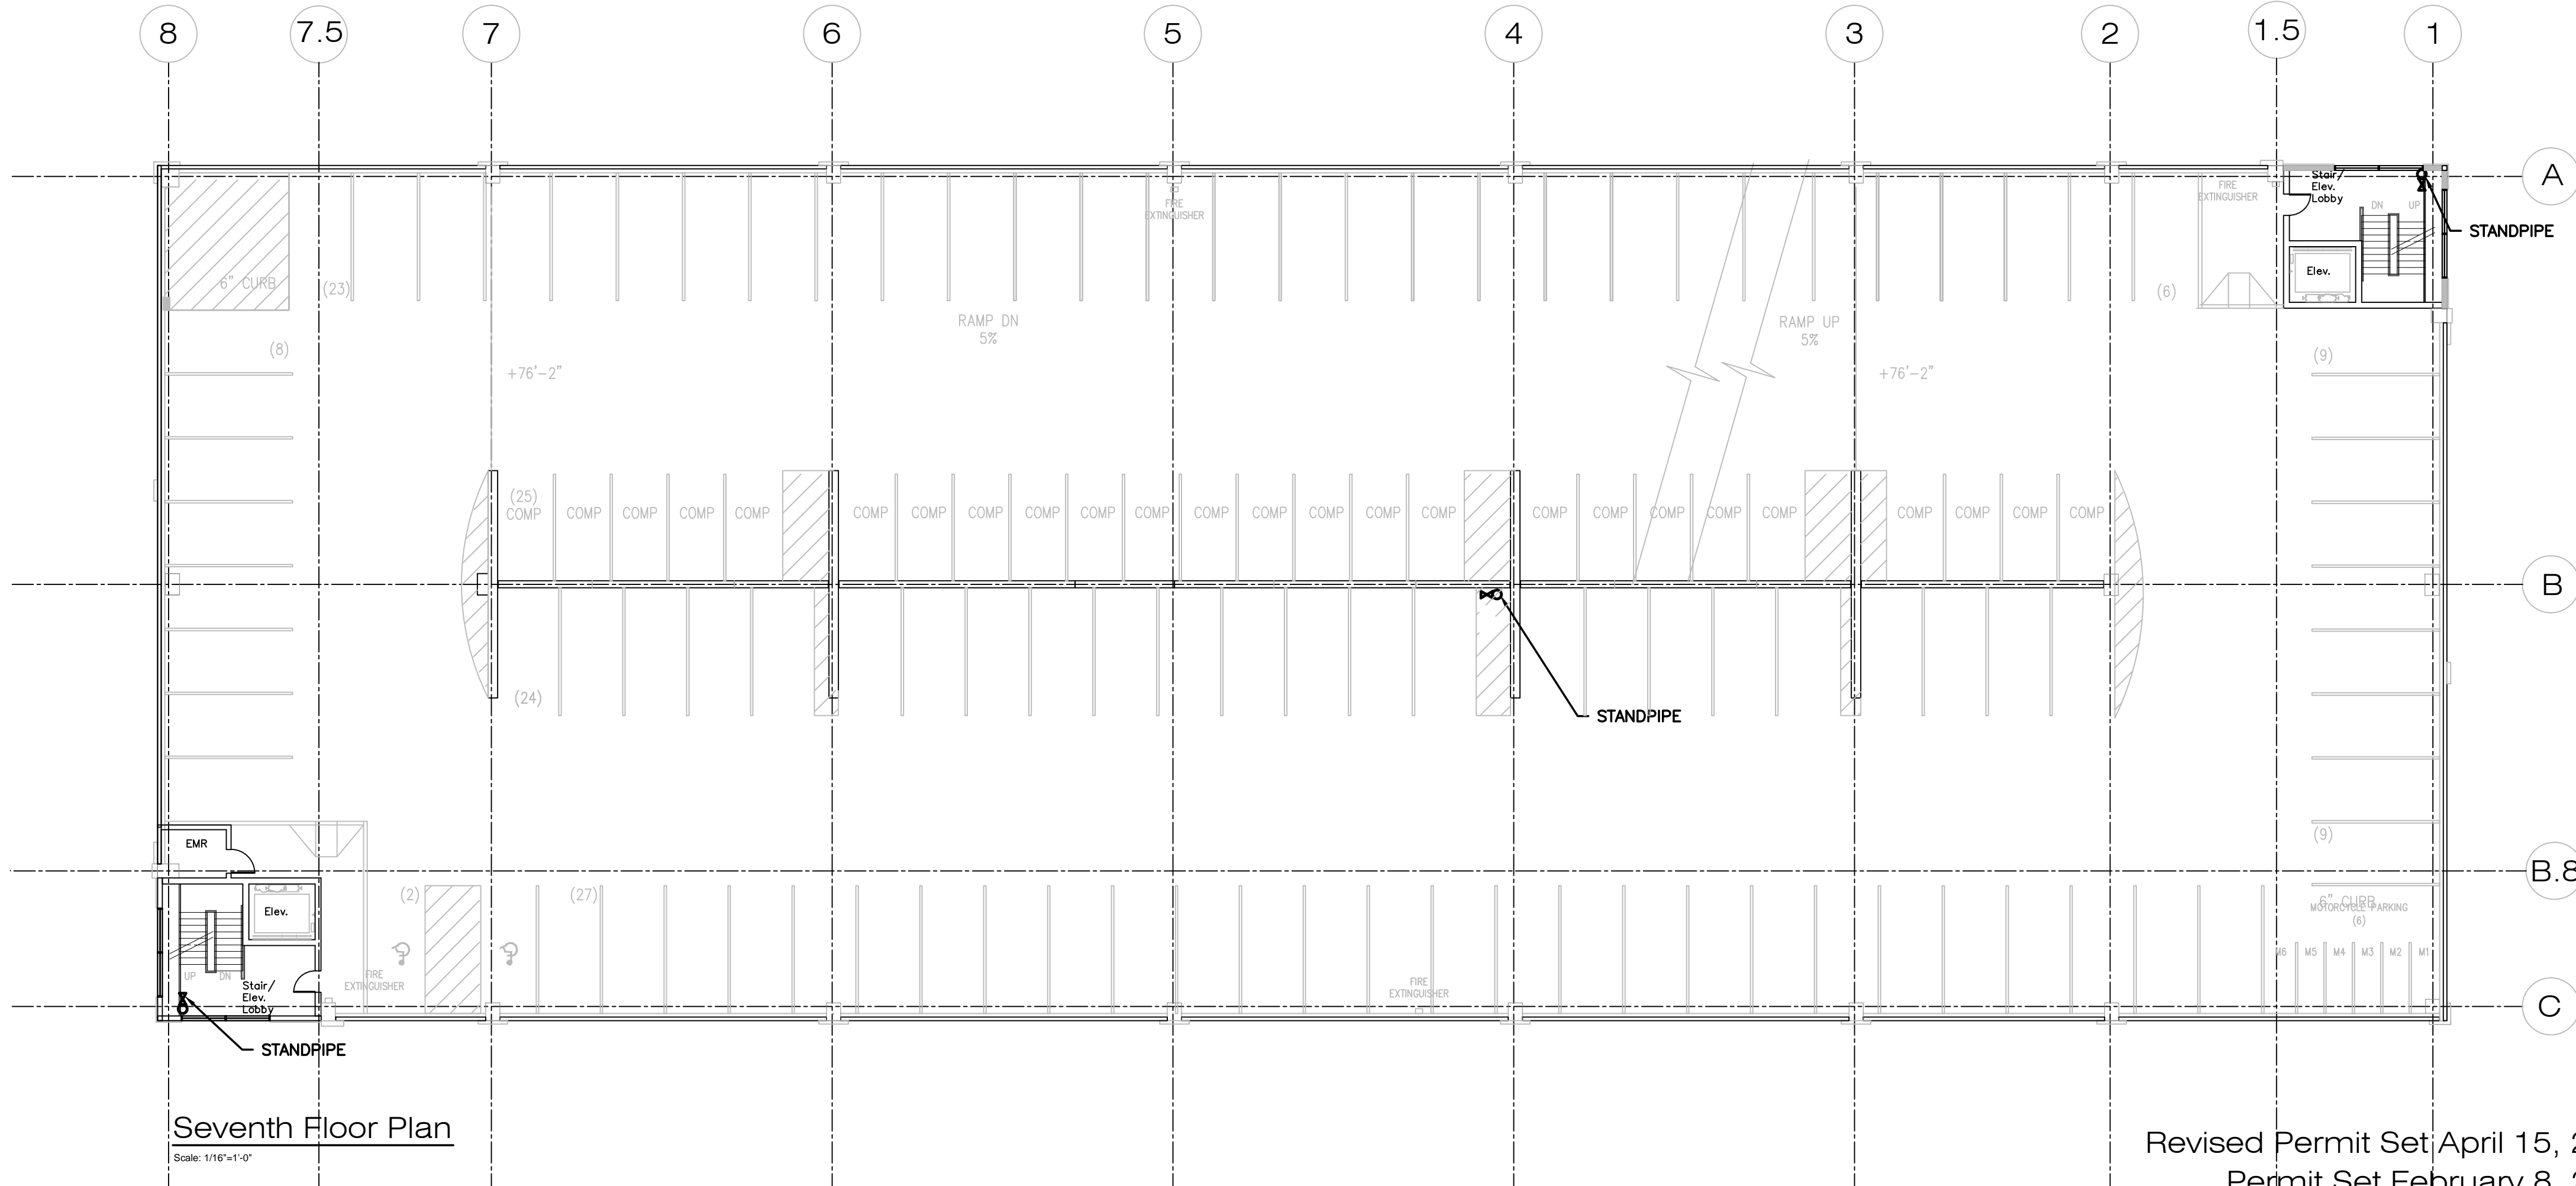

Seventh Floor Plan  
Scale: 1/16"=1'-0"

Revised Permit Set, April 15, 2016  
Permit Set February 8, 2016