



RETAIL/RESTAURANT SANITARY AND GREASE WASTE PIPING

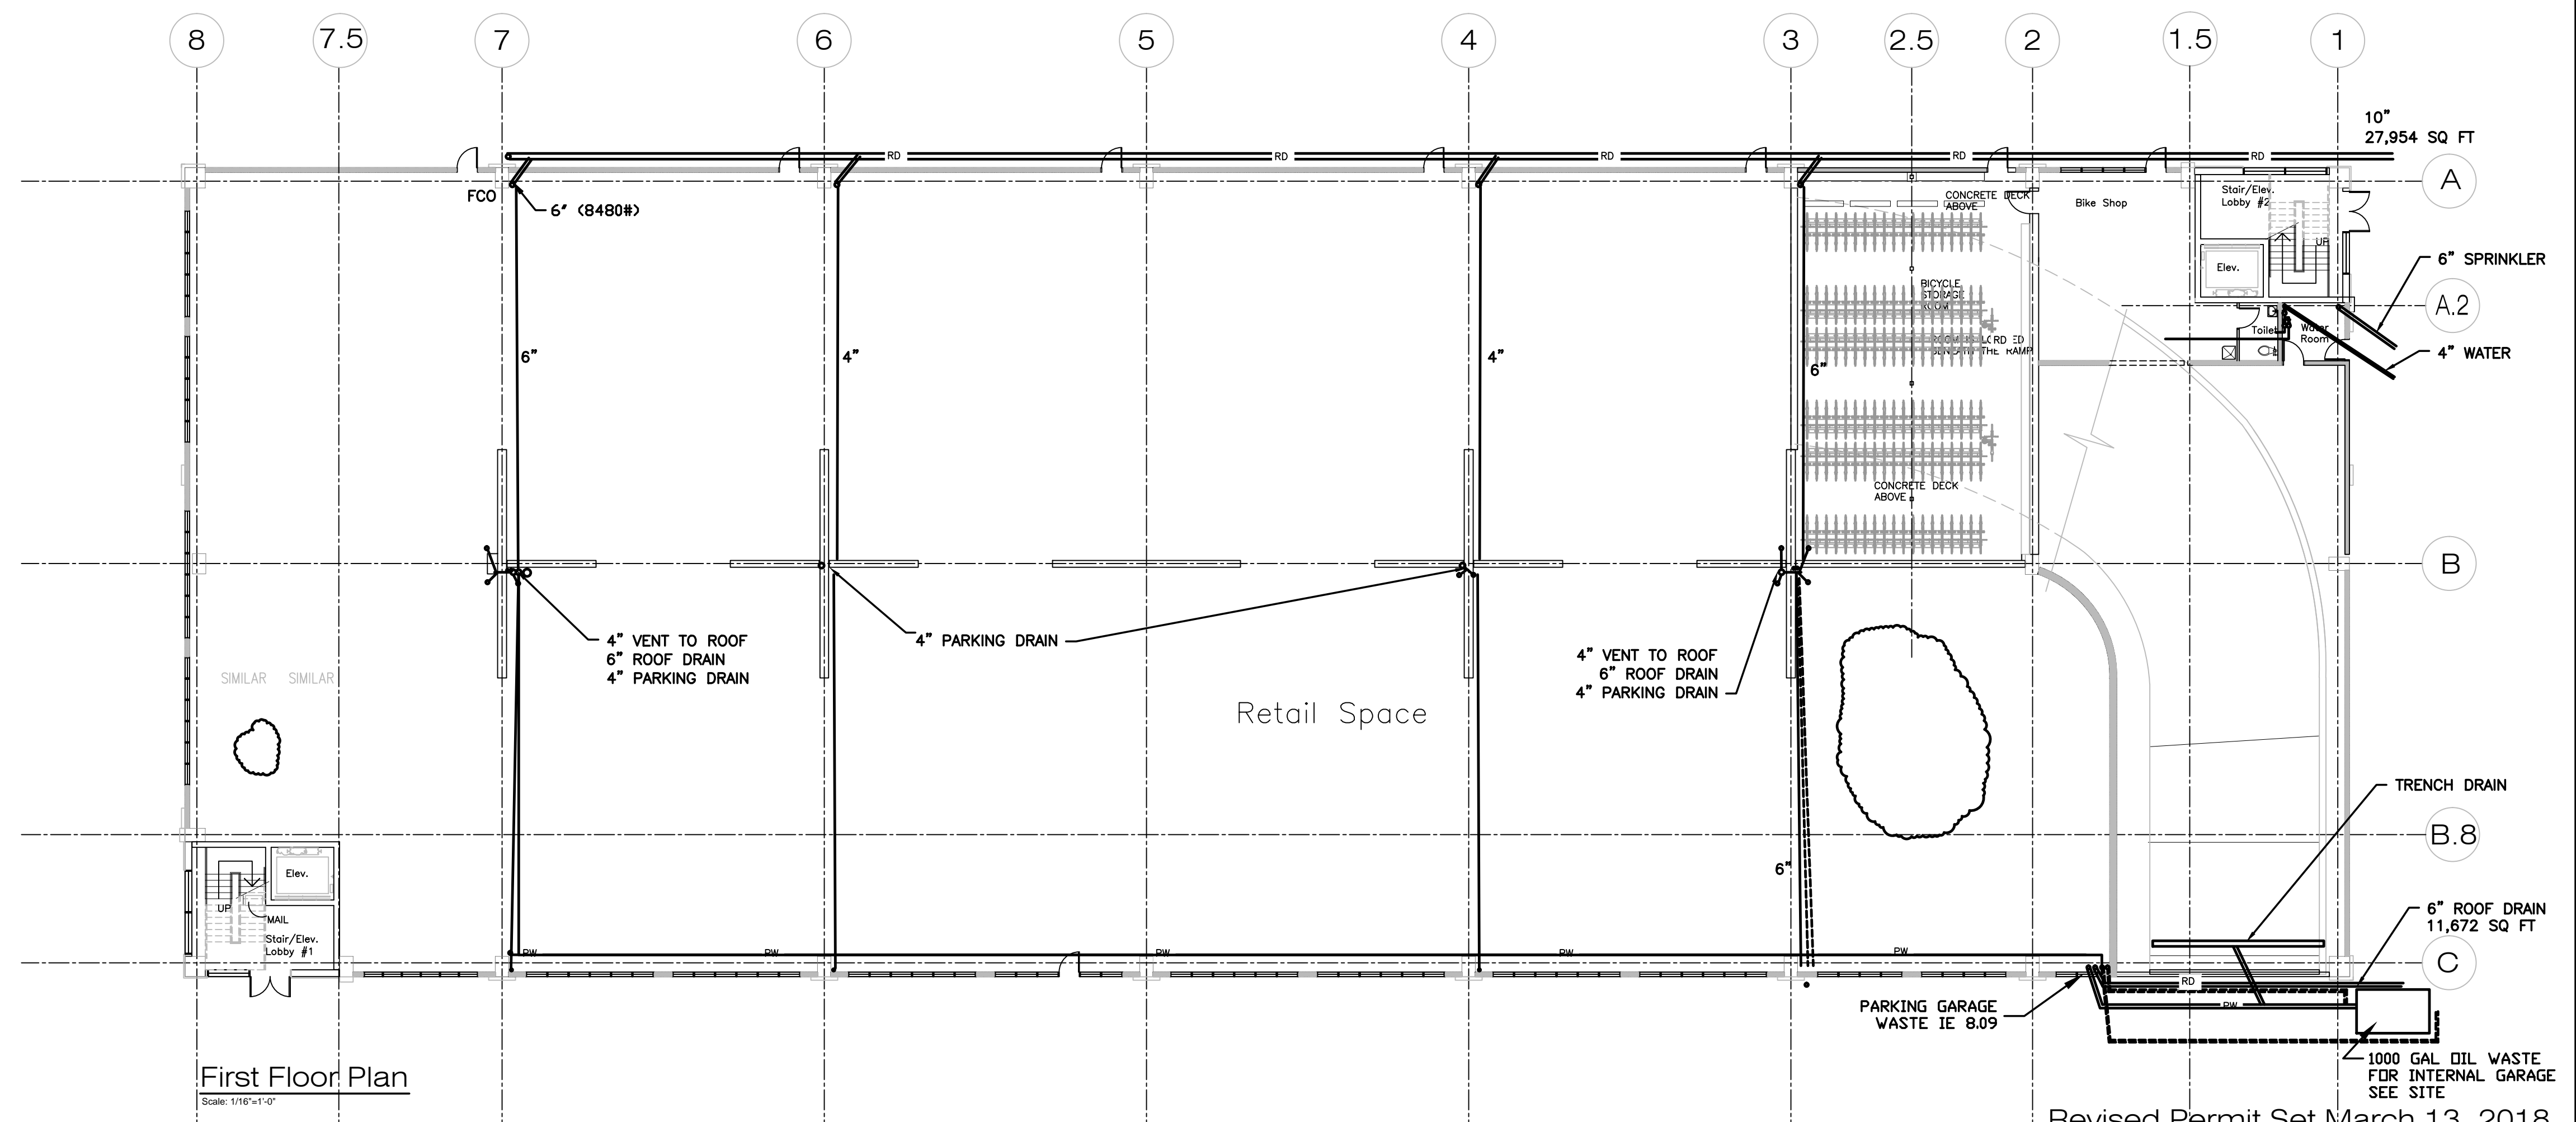

PARKING GARAGE ROOF AND FLOOR DRAIN PIPING

Revised Permit Set March 13, 2018
 Revised Permit Set April 15, 2016
 Permit Set February 8, 2016

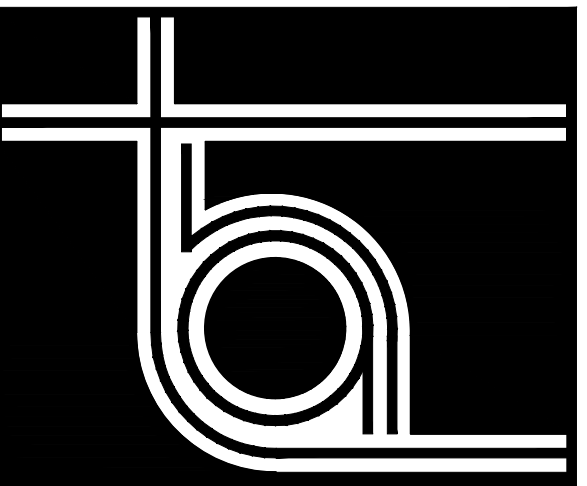

THA ARCHITECTS, LLC

ARCHITECTURE DESIGN PLANNING INTERIOR DESIGN

105 WILLOW BROOK AVENUE
 STRATHAM, NEW HAMPSHIRE 03885

Tel: (603) 770-2491 Fax: (603) 773-0238
 www.thaarc.com

These drawings and specifications were prepared for use at the location indicated. Publication and use is expressly limited to the identified location. Reuse or reproduction by any method, in whole or in part, is prohibited without the written permission of THA Architects, LLC.
 © THA Architects, LLC.



midtown Portland

Somerset Street
 Elm Street
 Portland, ME

Building 2
 First floor
 SECOND FLOOR
 PLUMBING PLANS

Structural Engineer
 Becker Engineering
 MEP ENGINEER
 McCabe Associates
 FP Engineer
 McCabe Associates

SCALE: 1/16"=1'-0"

ISSUED / DRAWN BY

2/8/16

© THA Architects, LLC

REVISED / REVISED BY

JOB NO: 15001

SHEET NUMBER

P-1.1