


NOTE: SEWERS TO BE SDR 35 WITH WATERTIGHT JOINTS

**THIS DRAWING IS INTENDED TO BE PLOTTED AND VIEWED IN COLOR.**  
BLACK AND WHITE PLAN NOT SUITABLE FOR REVIEW

PRELIMINARY - NOT FOR CONSTRUCTION

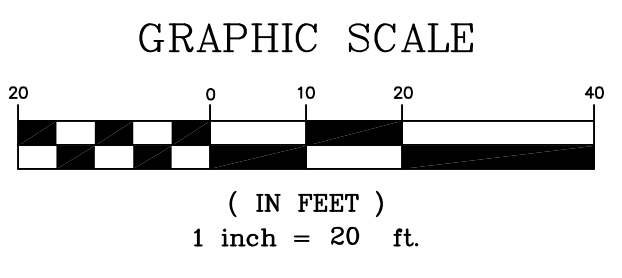

PROJECT <b>midtown</b> PORTLAND, MAINE			DRAWN: KEW/DED DESIGNED: WGH/BEK CHECKED: WGH/SRB FILE NAME: 3062-UTIL								
SHEET TITLE <b>UTILITY PLAN - midtownFour</b>				DATE: OCTOBER 2014 SCALE: 1" = 20' JOB NO. SP-M037B							
CLIENT <b>THE FEDERATED COMPANIES</b>		P.E. WILLIAM R. MOORE LIC. # 13547	SHEET <b>C-4.3</b>								
<table border="1"> <thead> <tr> <th>REV</th> <th>DATE</th> <th>DESCRIPTION</th> <th>REVISIONS</th> </tr> </thead> <tbody> <tr> <td>1</td> <td>11.14.14</td> <td>FINAL LEVEL III SUBMISSION TO CITY OF PORTLAND</td> <td></td> </tr> </tbody> </table>				REV	DATE	DESCRIPTION	REVISIONS	1	11.14.14	FINAL LEVEL III SUBMISSION TO CITY OF PORTLAND	
REV	DATE	DESCRIPTION	REVISIONS								
1	11.14.14	FINAL LEVEL III SUBMISSION TO CITY OF PORTLAND									