



NOTE: SEWERS TO BE SDR 35 WITH WATERTIGHT JOINTS

THIS DRAWING IS INTENDED TO BE PLOTTED AND VIEWED IN COLOR.
BLACK AND WHITE PLAN NOT SUITABLE FOR REVIEW

PRELIMINARY - NOT FOR CONSTRUCTION

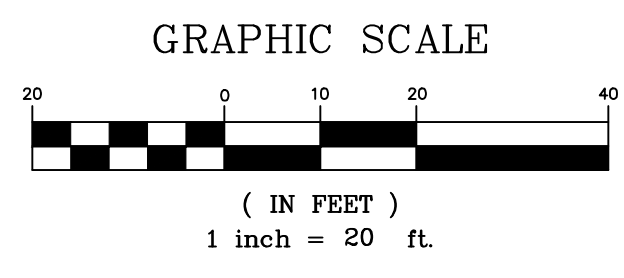

REV	DATE	DESCRIPTION	REVISIONS
2	01.21.15	REVISED PER PWD/CMP COMMENTS, SUBMITTED TO CITY	
1	11.14.14	FINAL LEVEL III SUBMISSION TO CITY OF PORTLAND	

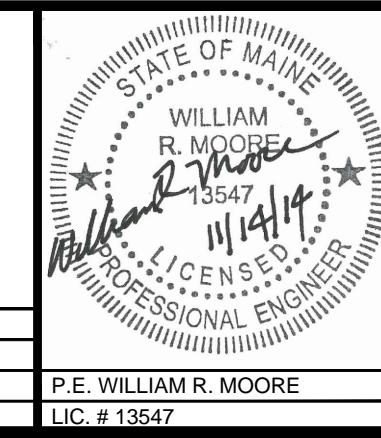

PROJECT	midtown PORTLAND, MAINE
SHEET TITLE	UTILITY PLAN - midtownFour
CLIENT	FEDQ DV001, LLC

FAY, SPOFFORD & THORNDIKE ENGINEERS • PLANNERS • SCIENTISTS 778 MAIN ST., SUITE 8, SOUTH PORTLAND, ME 04106 FORMERLY DELUCA-HOFFMAN ASSOCIATES	DRAWN: KEW/DED DESIGNED: WGH/BEK CHECKED: WGH/SRB FILE NAME: 3062-UTIL SHEET: C-4.3	DATE: OCTOBER 2014 SCALE: 1" = 20' JOB NO.: SP-M037B
--	---	--