


FIRST FLOOR - DUCTWORK
 SCALE: 1/8"=1'-0"

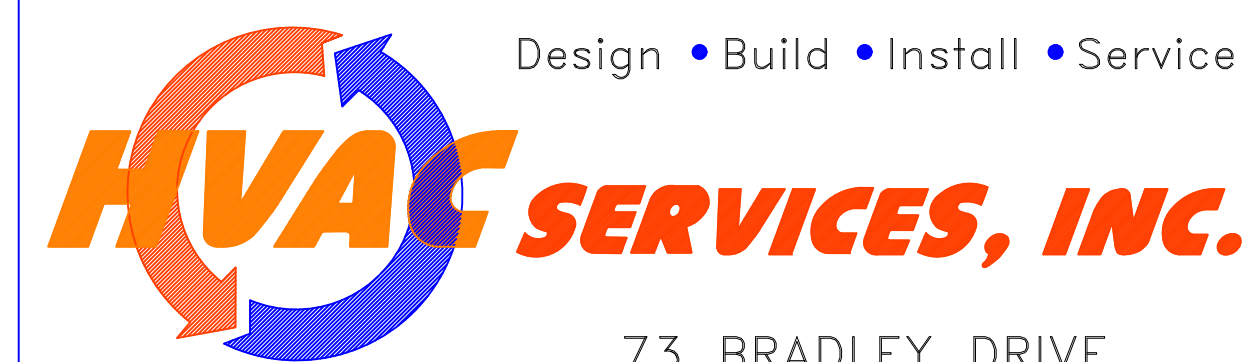

Design • Build • Install • Service

73 BRADLEY DRIVE
 WESTBROOK, MAINE 04092
 (207) 854-HVAC (4822)

REVISIONS NO. NOTES		BAXTER ACADEMY PROJECT:	
		FIRST FLOOR DUCTWORK PLANS	
SHEET TITLE:		DATE: 4-24-2017	
SCALE: 1/8"=1'-0"		SHEET No.	
DRAWN BY: TJF		M-1	
CHECKED BY:			
PRINT TO SCALE: 36x24			