



FLOOR PLAN (1)
SCALE: 1/2" = 1'-0" (M1)

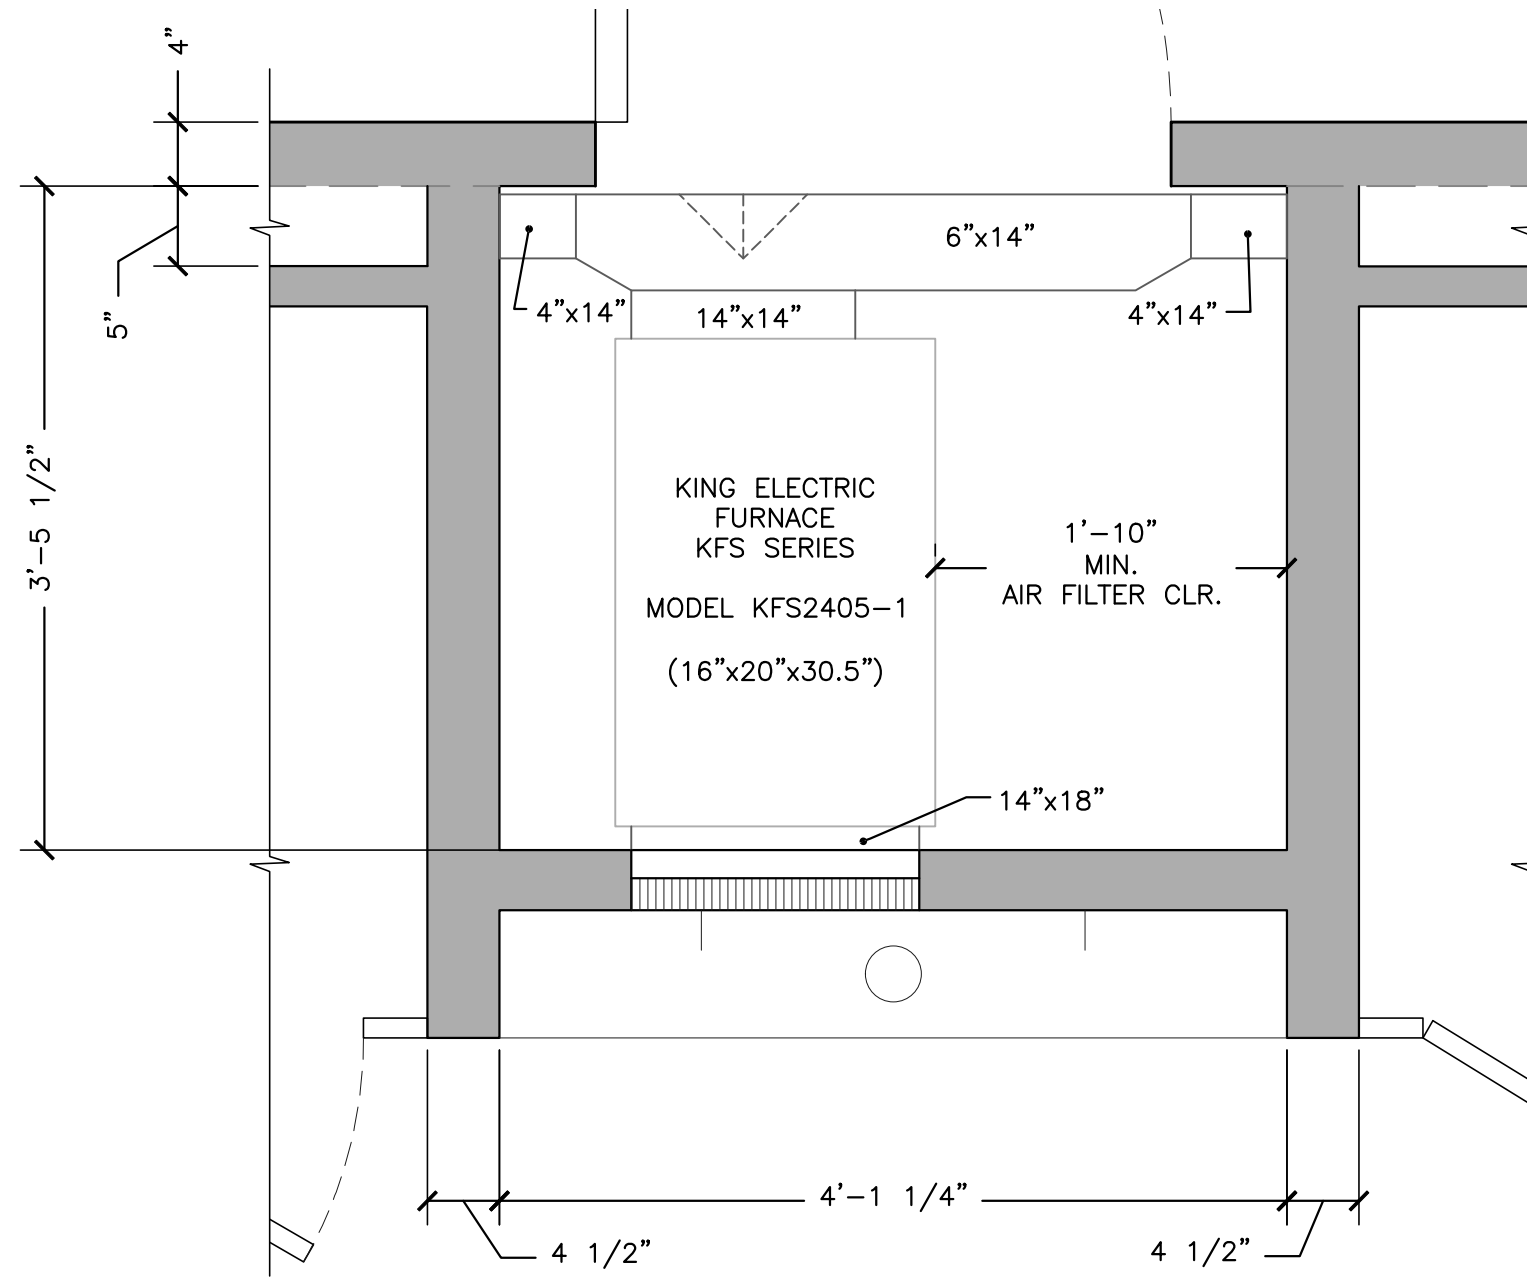

MECHANICAL ROOM (2)
SCALE: 1" = 1'-0" (M1)

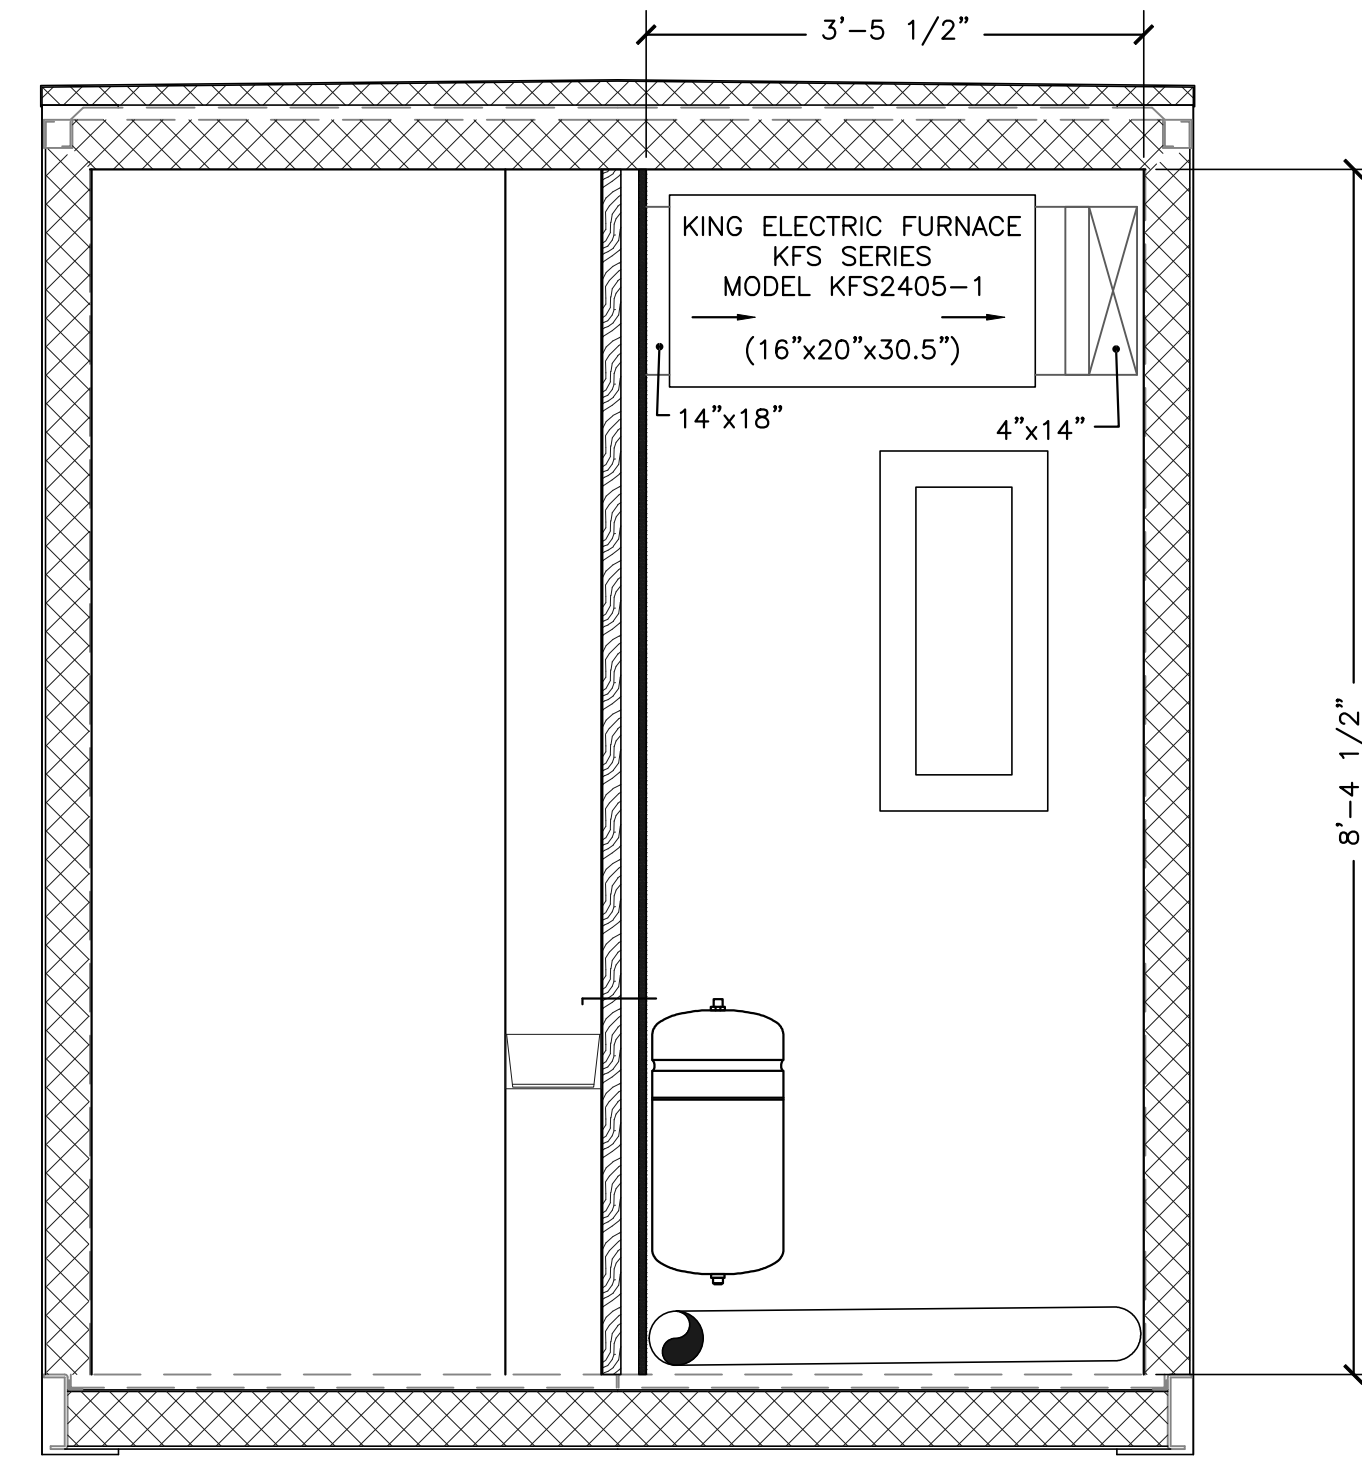

MECHANICAL ROOM (3)
SCALE: 3/4" = 1'-0" (M1)

NO.	DATE	DESCRIPTION	REVISIONS

PROJECT NAME: OXFORD ST. SHELTER BATHROOM
 PORTLAND MAINE
 SHEET NAME: MECHANICAL

PROJECT NO. 17289
 DRAWING NO. 17289A
 FIELD NO.
 SCALE:
 DATE ISSUED: NOV. 30, 2017
 CLIENT: SHANESPACE SOLUTIONS
 55 BAKER BLVD
 BREWER, MAINE 04412

Plymouth Engineering, Inc.
 P.O. Box 46 - 30 Lower Detroit Road
 Plymouth, Maine 04989
 Tel: (207) 257-2071 Fax: (207) 257-2130
 info@plymouthengineering.com
 www.plymouthengineering.com

PRELIMINARY

DRAWINGS NOT SEALED ARE FOR PLANNING PURPOSES ONLY AND ARE NOT INTENDED FOR PERMITTING, BIDDING OR CONSTRUCTION.