


CHESTNUT STREET

Window Key
31X52 —
16X52 ✓

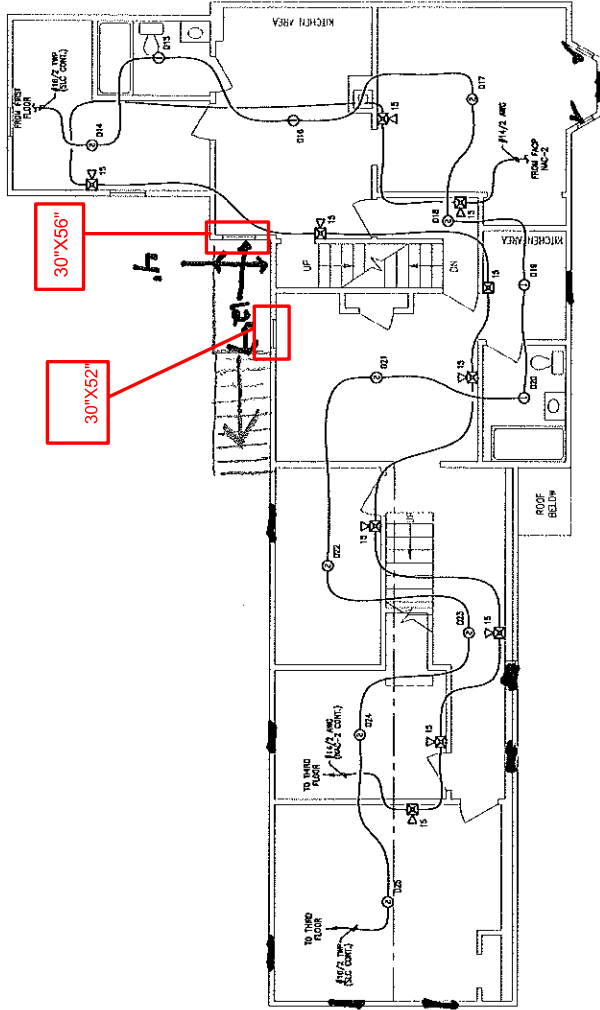

SECOND FLOOR FIRE ALARM PLAN
SCALE: 1/4"=1'-0"

RESERVED FOR CITY STAMP



FA-4

SCALE: 1/4"=1'-0"

REVISION: 0

DATE: 1/7/2011

DESIGNED: MCF # 0005

DRAWN: DRG 0000 JOB #17028

PORTLAND, MAINE 04101
SECOND FLOOR FIRE ALARM PLAN

58 CHESTNUT STREET

CUNNINGHAM

Security Systems

10 Princes Point Road, Yarmouth, Maine 04096
Office: 207.846.3350 • Fax: 207.846.6080

REVISION

DESCRIPTION

DATE

1/7/2011

0

0

0

0

0

0

0