

REVISION	0	ISSUED FOR REVIEW & APPROVAL	1/9/2017
DESCRIPTION			
DATE			


CUNNINGHAM
Security Systems
 10 Princes Point Road, Yarmouth, Maine 04096
 Office: 207.846.3350 • Fax: 207.846.6080

58 CHESTNUT STREET
PORTLAND, MAINE 04101
BASEMENT FIRE ALARM PLAN

DRAWN	JPB	UNICAD JOB #17008
CHECKED	WAYNE B. HAWES	NCET # 90496
DATE	1/9/2017	
REVISION	0	
SCALE	1/4"=1'-0"	

FA-2

UNICAD Inc.
 Fire Alarm Design & Drafting Services
 575 W. 40th St.
 Portland, ME 04102
 Phone: 603.865.6410
 www.unicad.net

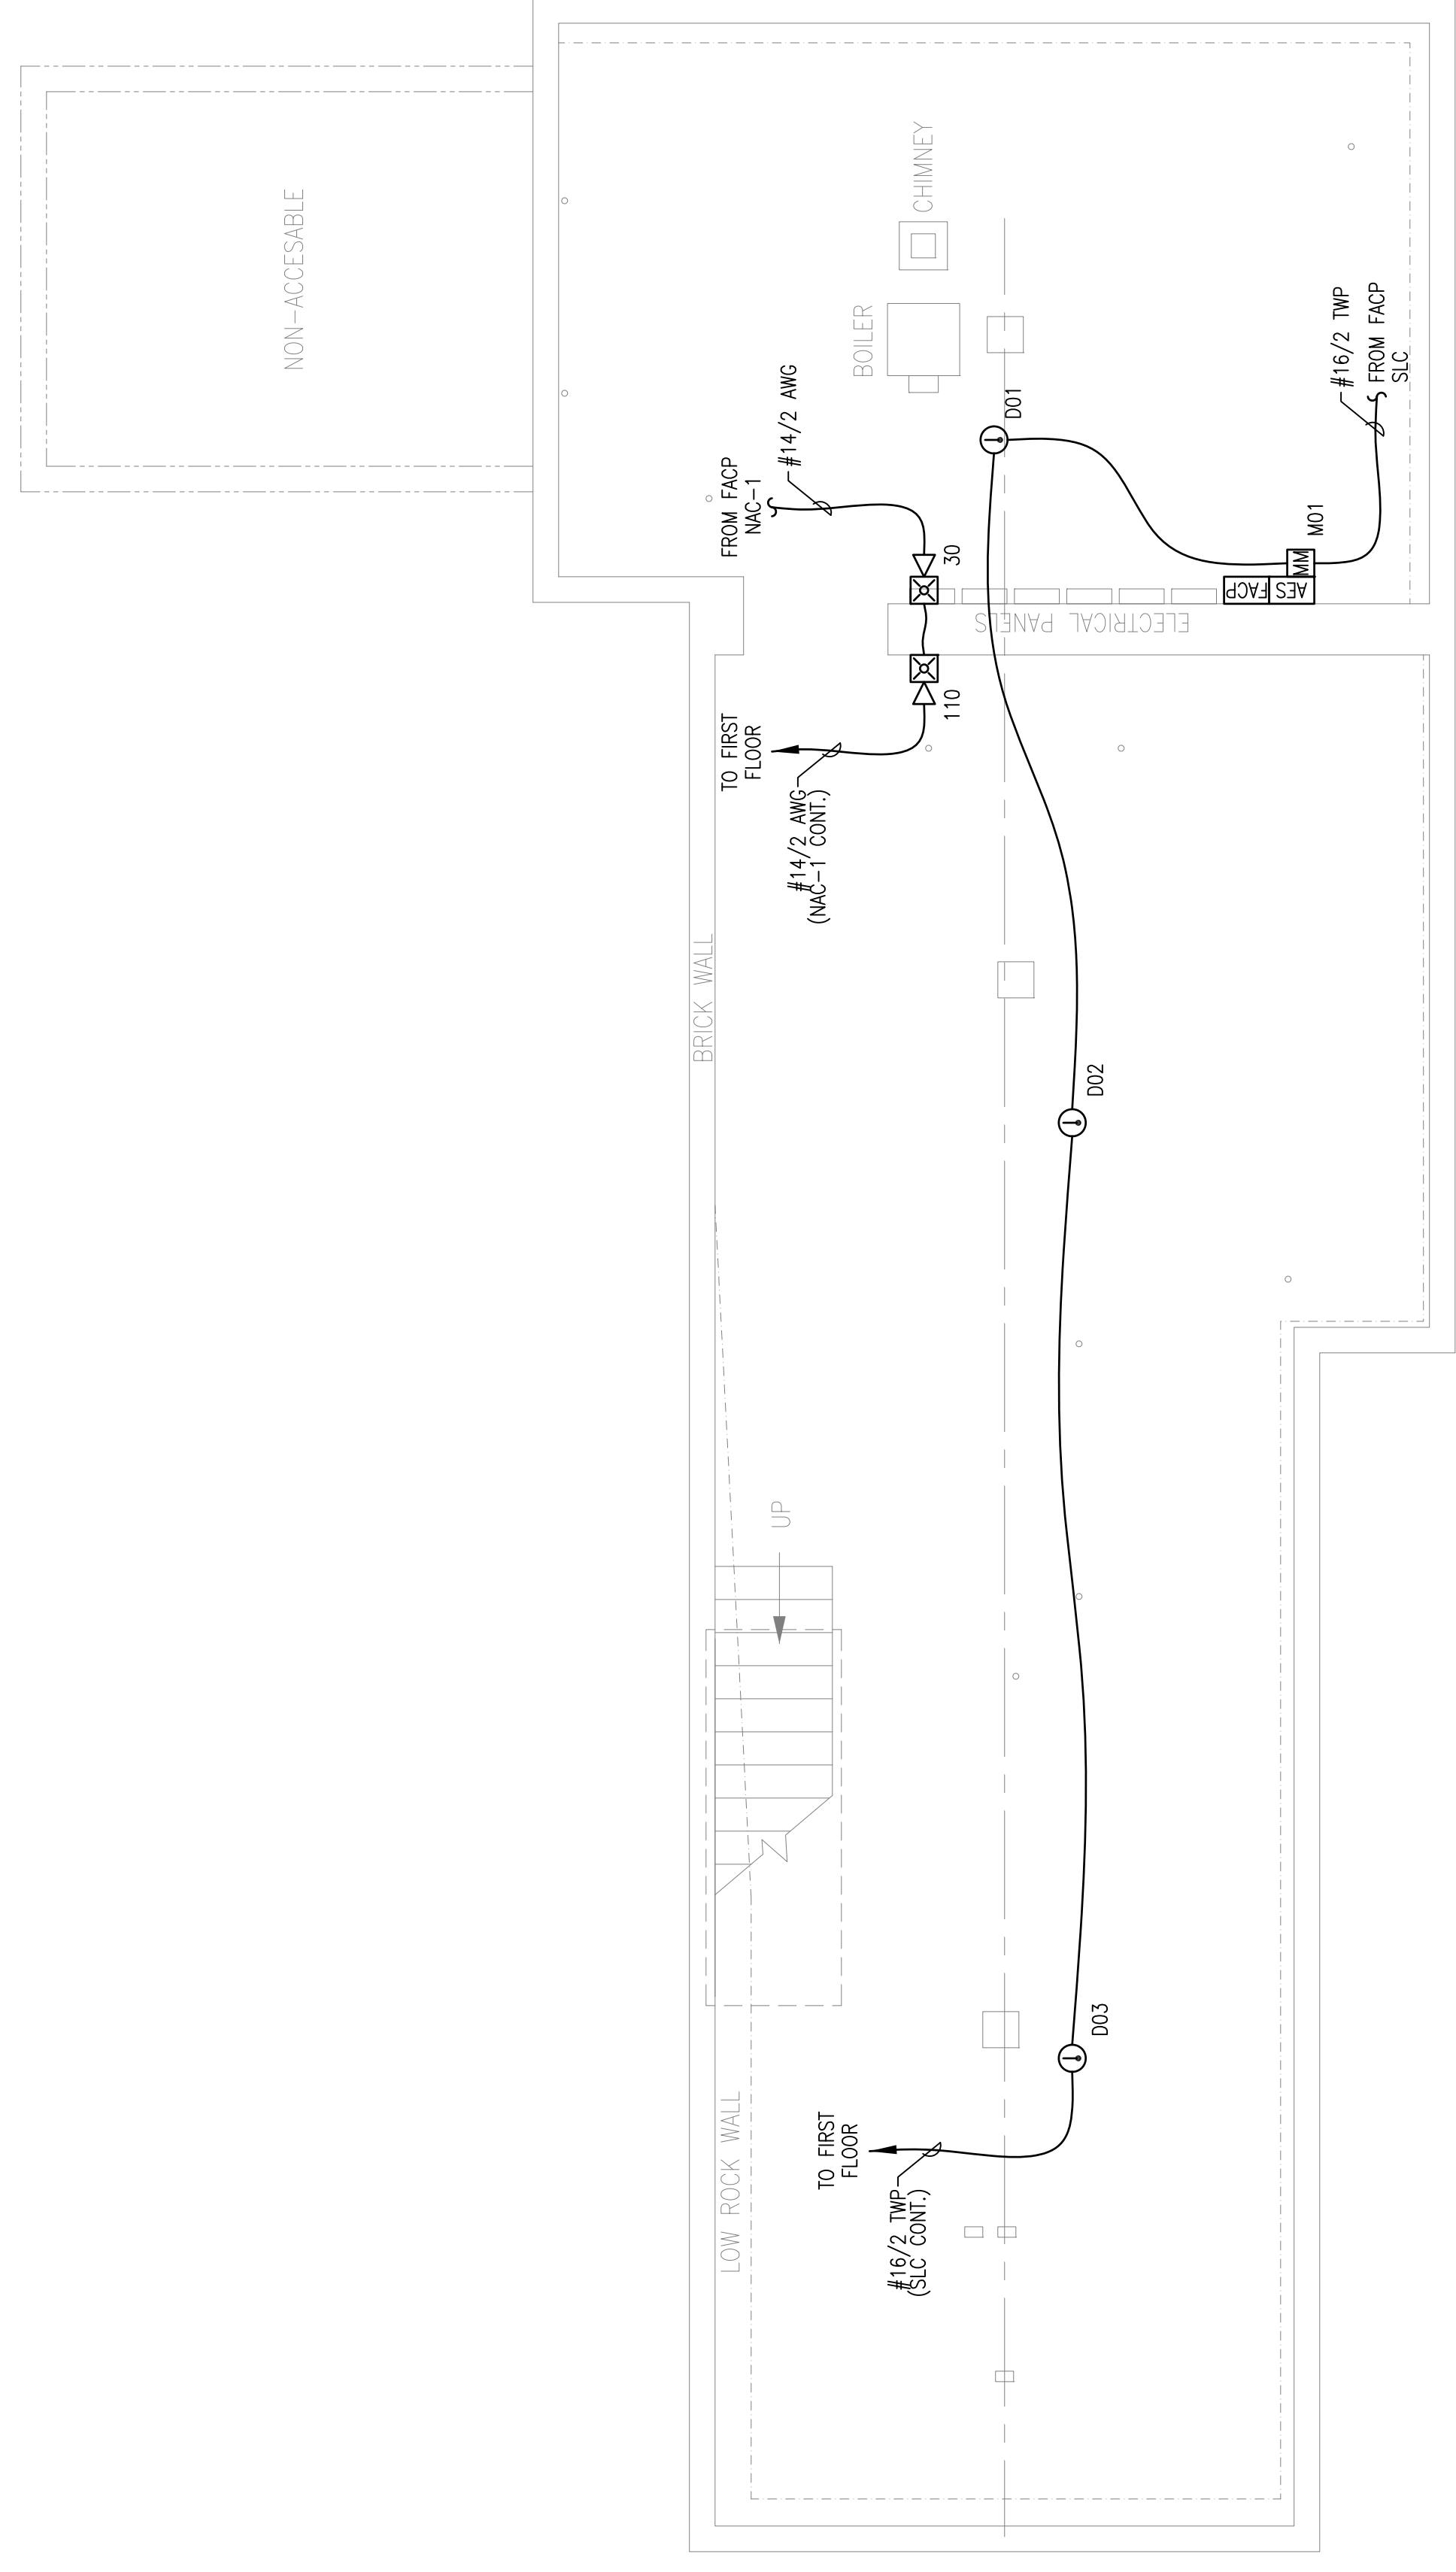

BASEMENT FIRE ALARM PLAN
 SCALE: 1/4"=1'-0"

RESERVED FOR CITY STAMP

CHESTNUT STREET