

REVISION	DESCRIPTION	DATE
0	ISSUED FOR REVIEW & APPROVAL	1/9/2017

**CUNNINGHAM**  
Security Systems


10 Princes Point Road, Yarmouth, Maine 04096  
Office: 207.846.3350 • Fax: 207.846.6080

**58 CHESTNUT STREET**  
**PORTLAND, MAINE 04101**  
**FIRST FLOOR FIRE ALARM PLAN**

DRAWN	JPB UNICAD JOB #17008
CHECKED	WAYNE B. HAWES NGEET N° 90496
DATE	1/9/2017
REVISION	0
SCALE	1/4"=1'-0"

**FA-3**

**UNICAD** Inc.  
www.unicad.net  
579A W. 400th St.  
Portland, ME 04106  
Office: 601.865.6410

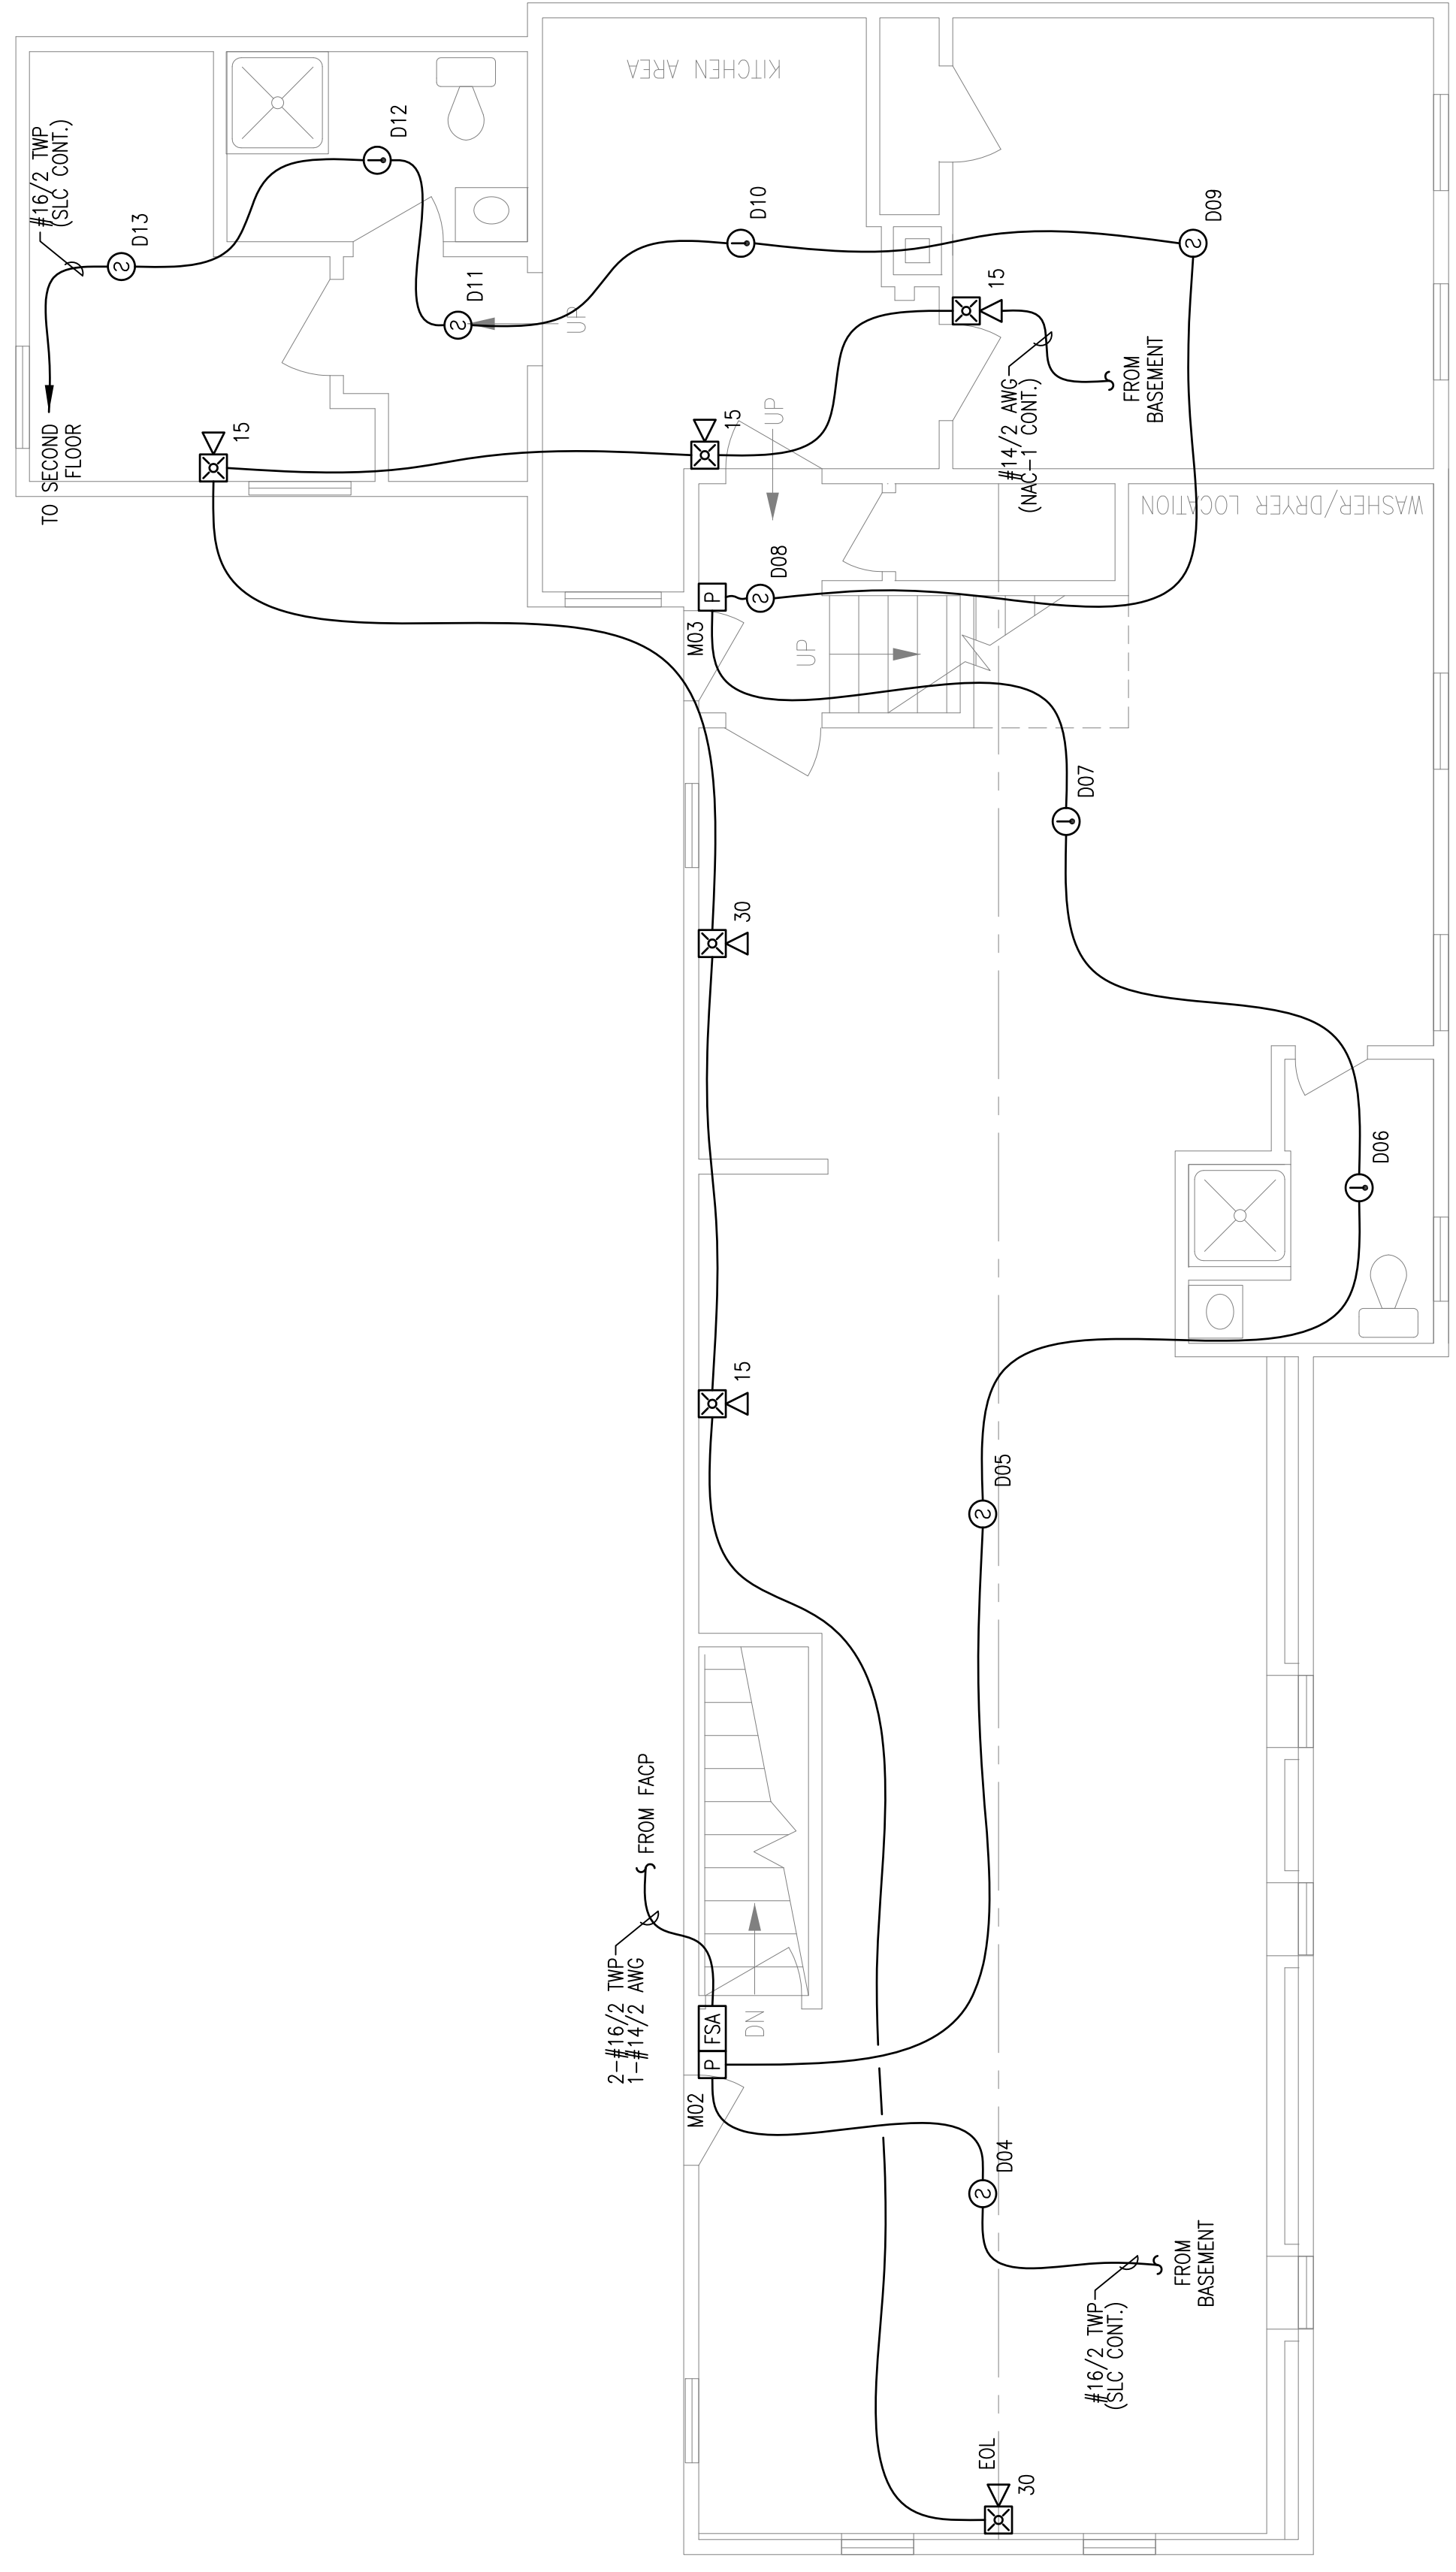

**FIRST FLOOR FIRE ALARM PLAN**  
SCALE: 1/4"=1'-0"

RESERVED FOR CITY STAMP

CHESTNUT STREET