


DRAWN	JPB UNICAD JOB #17008
CHECKED	WAYNE B. HAWES NCET # 90496
DATE	1/9/2017
REVISION	0
SCALE	1/4"=1'-0"

58 CHESTNUT STREET
 PORTLAND, MAINE 04101
 SECOND FLOOR FIRE ALARM PLAN

CUNNINGHAM
 Security Systems
 10 Princes Point Road, Yarmouth, Maine 04096
 Office: 207.846.3350 • Fax: 207.846.6080

REVISION	DESCRIPTION	DATE
0	ISSUED FOR REVIEW & APPROVAL	1/9/2017

RESERVED FOR CITY STAMP

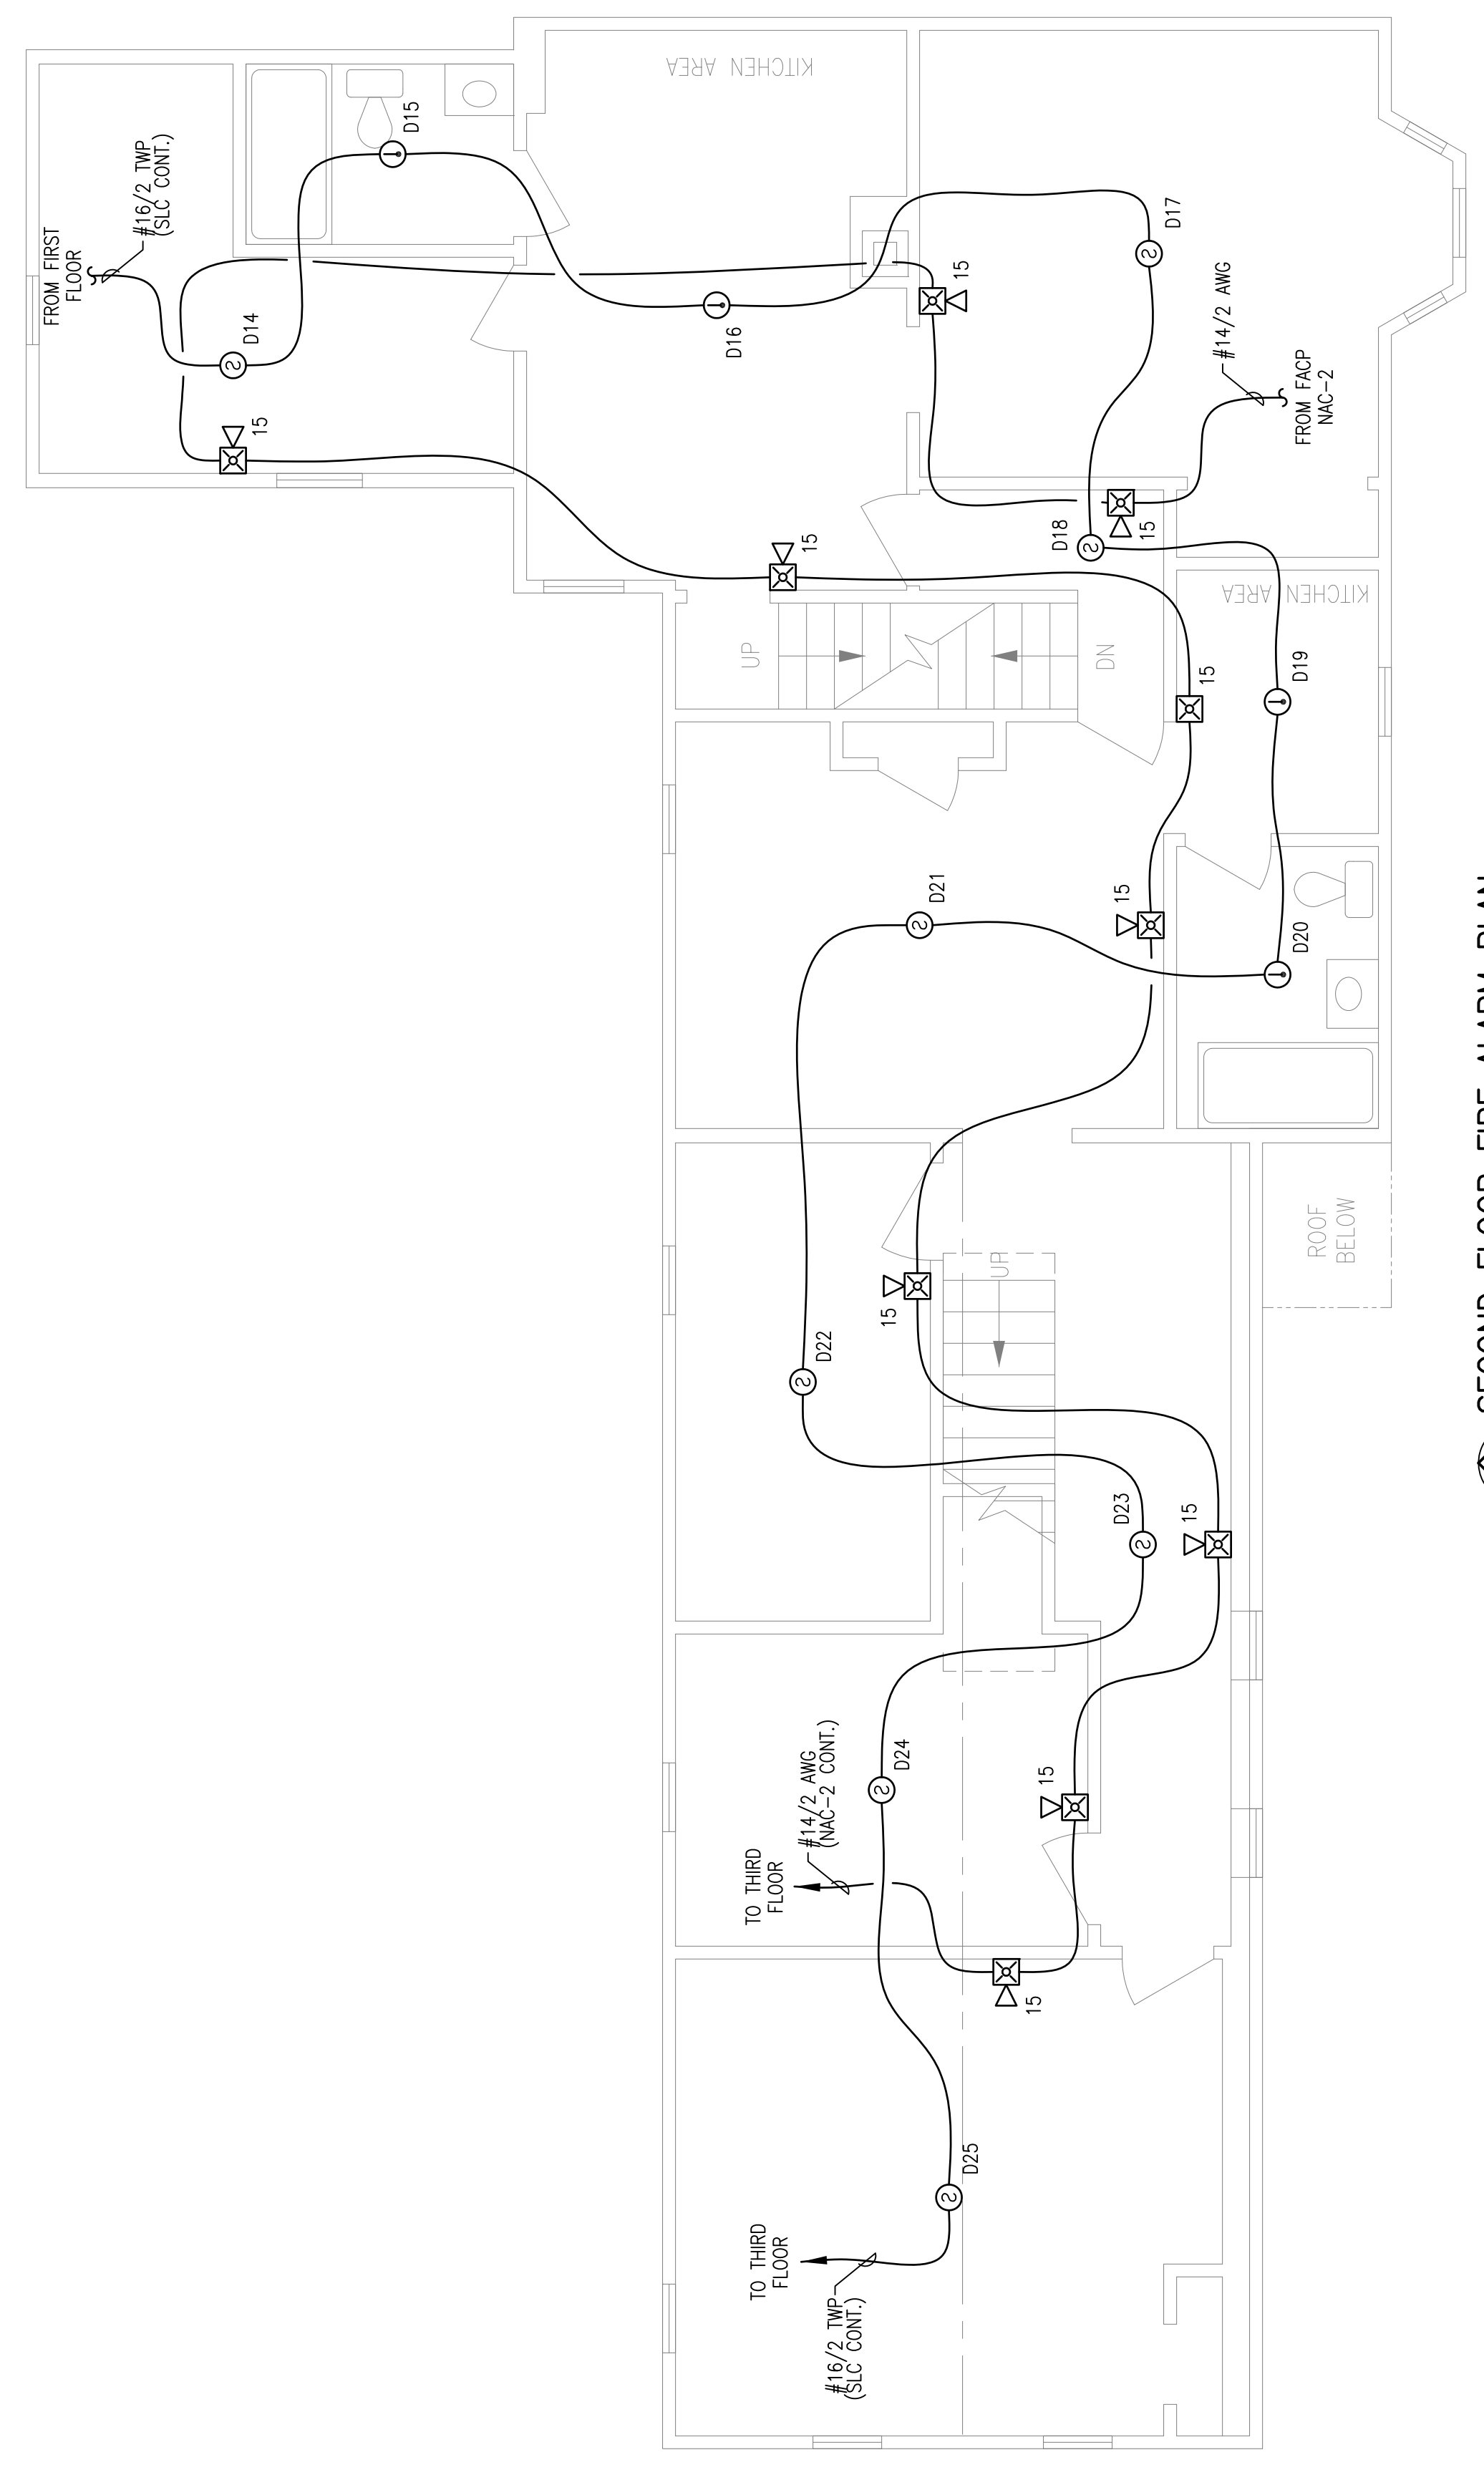

CHESTNUT STREET

SECOND FLOOR FIRE ALARM PLAN
 SCALE: 1/4"=1'-0"