

REVISION	DESCRIPTION	DATE
0	ISSUED FOR REVIEW & APPROVAL	1/9/2017

RESERVED FOR CITY STAMP


CUNNINGHAM
Security Systems
 10 Princes Point Road, Yarmouth, Maine 04096
 Office: 207.846.3350 • Fax: 207.846.6080

58 CHESTNUT STREET
PORTLAND, MAINE 04101
THIRD FLOOR FIRE ALARM PLAN

DRAWN	JPB UNICAD JOB #17008
CHECKED	WAYNE B. HAWES NCET # 90496
DATE	1/9/2017
REVISION	0
SCALE	1/4"=1'-0"

FA-5

UNICAD Inc.
 575 W. 40th St.
 Portland, ME 04102
 www.unicad.net

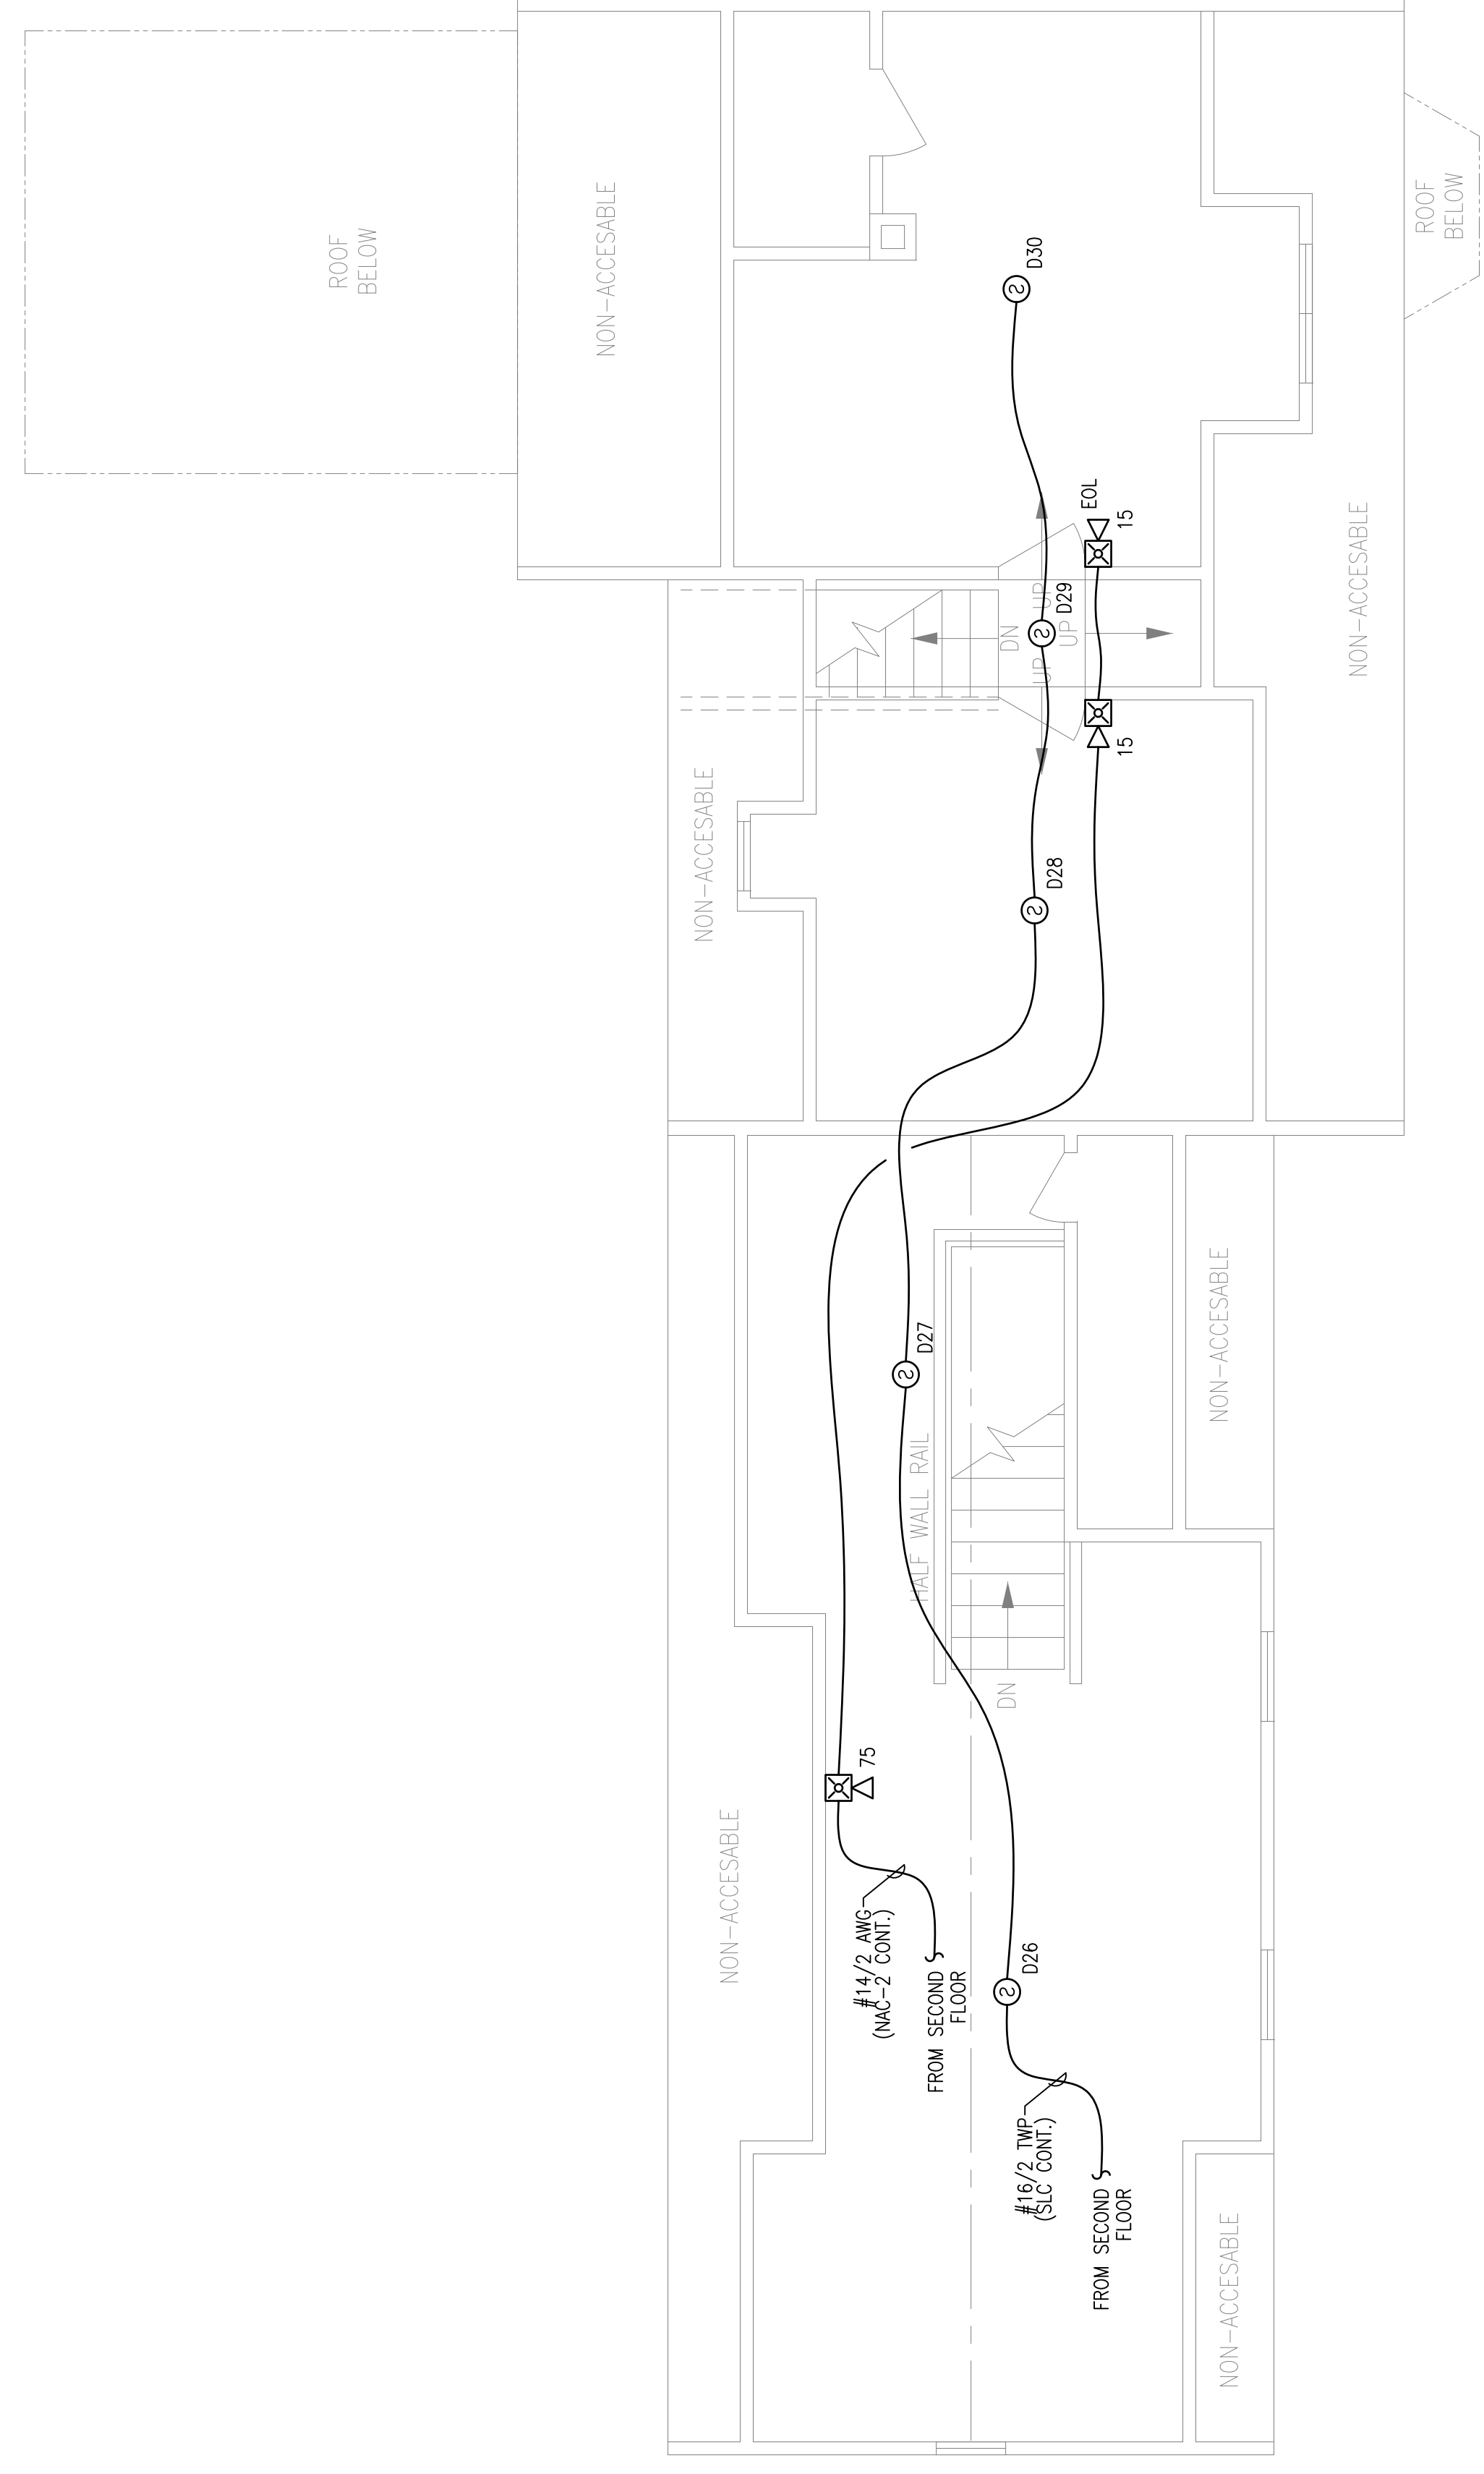

THIRD FLOOR FIRE ALARM PLAN
 SCALE: 1/4"=1'-0"

CHESTNUT STREET