


1 Proposed Reflected Ceiling Plan
SCALE: 1/4" = 1'-0"

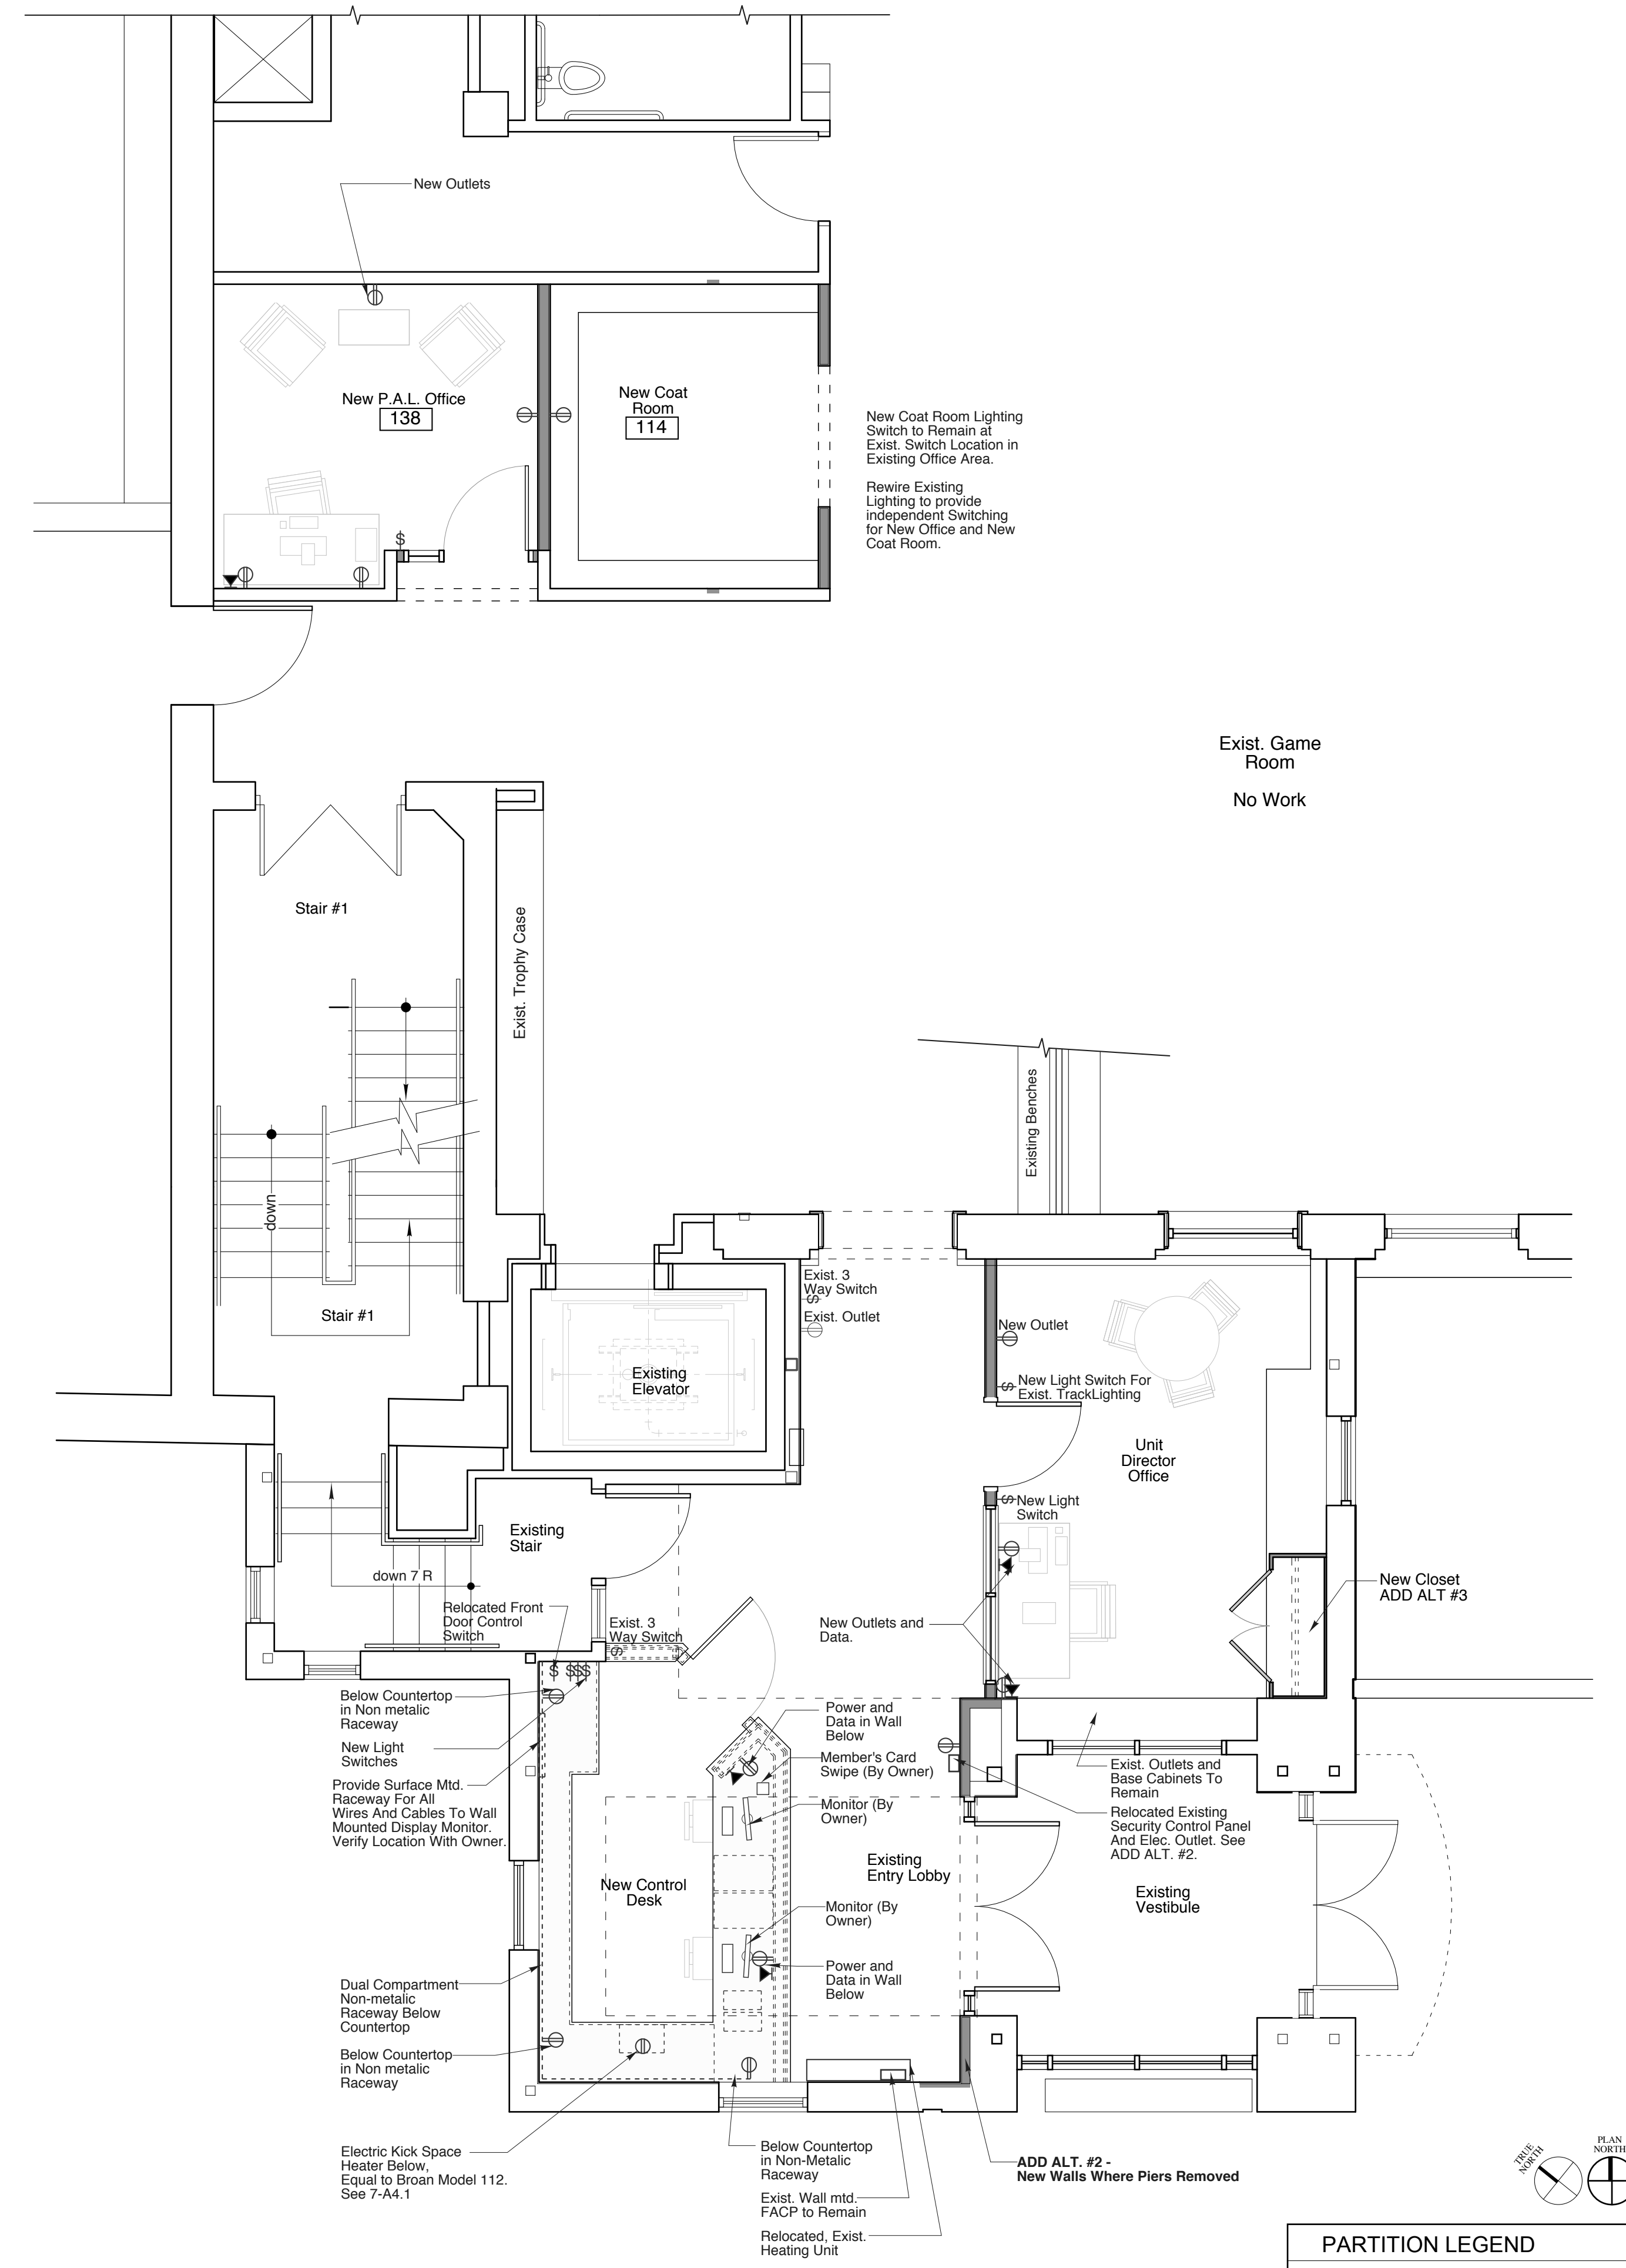


2 Proposed Electrical Plan
SCALE: 1/4" = 1'-0"

PARTITION LEGEND

	new construction
	existing construction to remain
	existing construction to be removed

Richard Renner/Architects
98 Pleasant Street
Portland, ME 04101
207.773.9699
207.773.9599 fax

133 South Main Street
Sherborn, MA 01770
508.651.2385
508.651.0911 fax

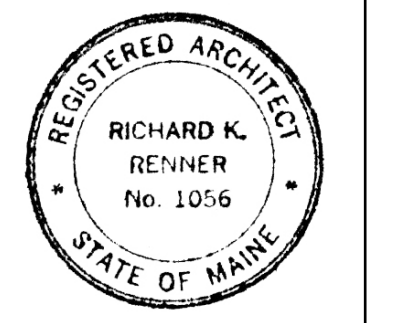

Issued For Bidding
03-15-2012

Boys & Girls Clubs of Southern Maine
Portland Clubhouse Lobby Renovations
Portland, Maine

Electrical Floor Plan and Reflected Ceiling Plan
Drawn by: RRA
Scale: As Shown
Date: 03/15/12
File Name: A1.2.RCP & Electrical Plans
Project No. 2010-07-00
Revised:

Boys & Girls Club - Portland, ME
A1.2