



1 BUILDING SECTION
1/8" = 1'-0"

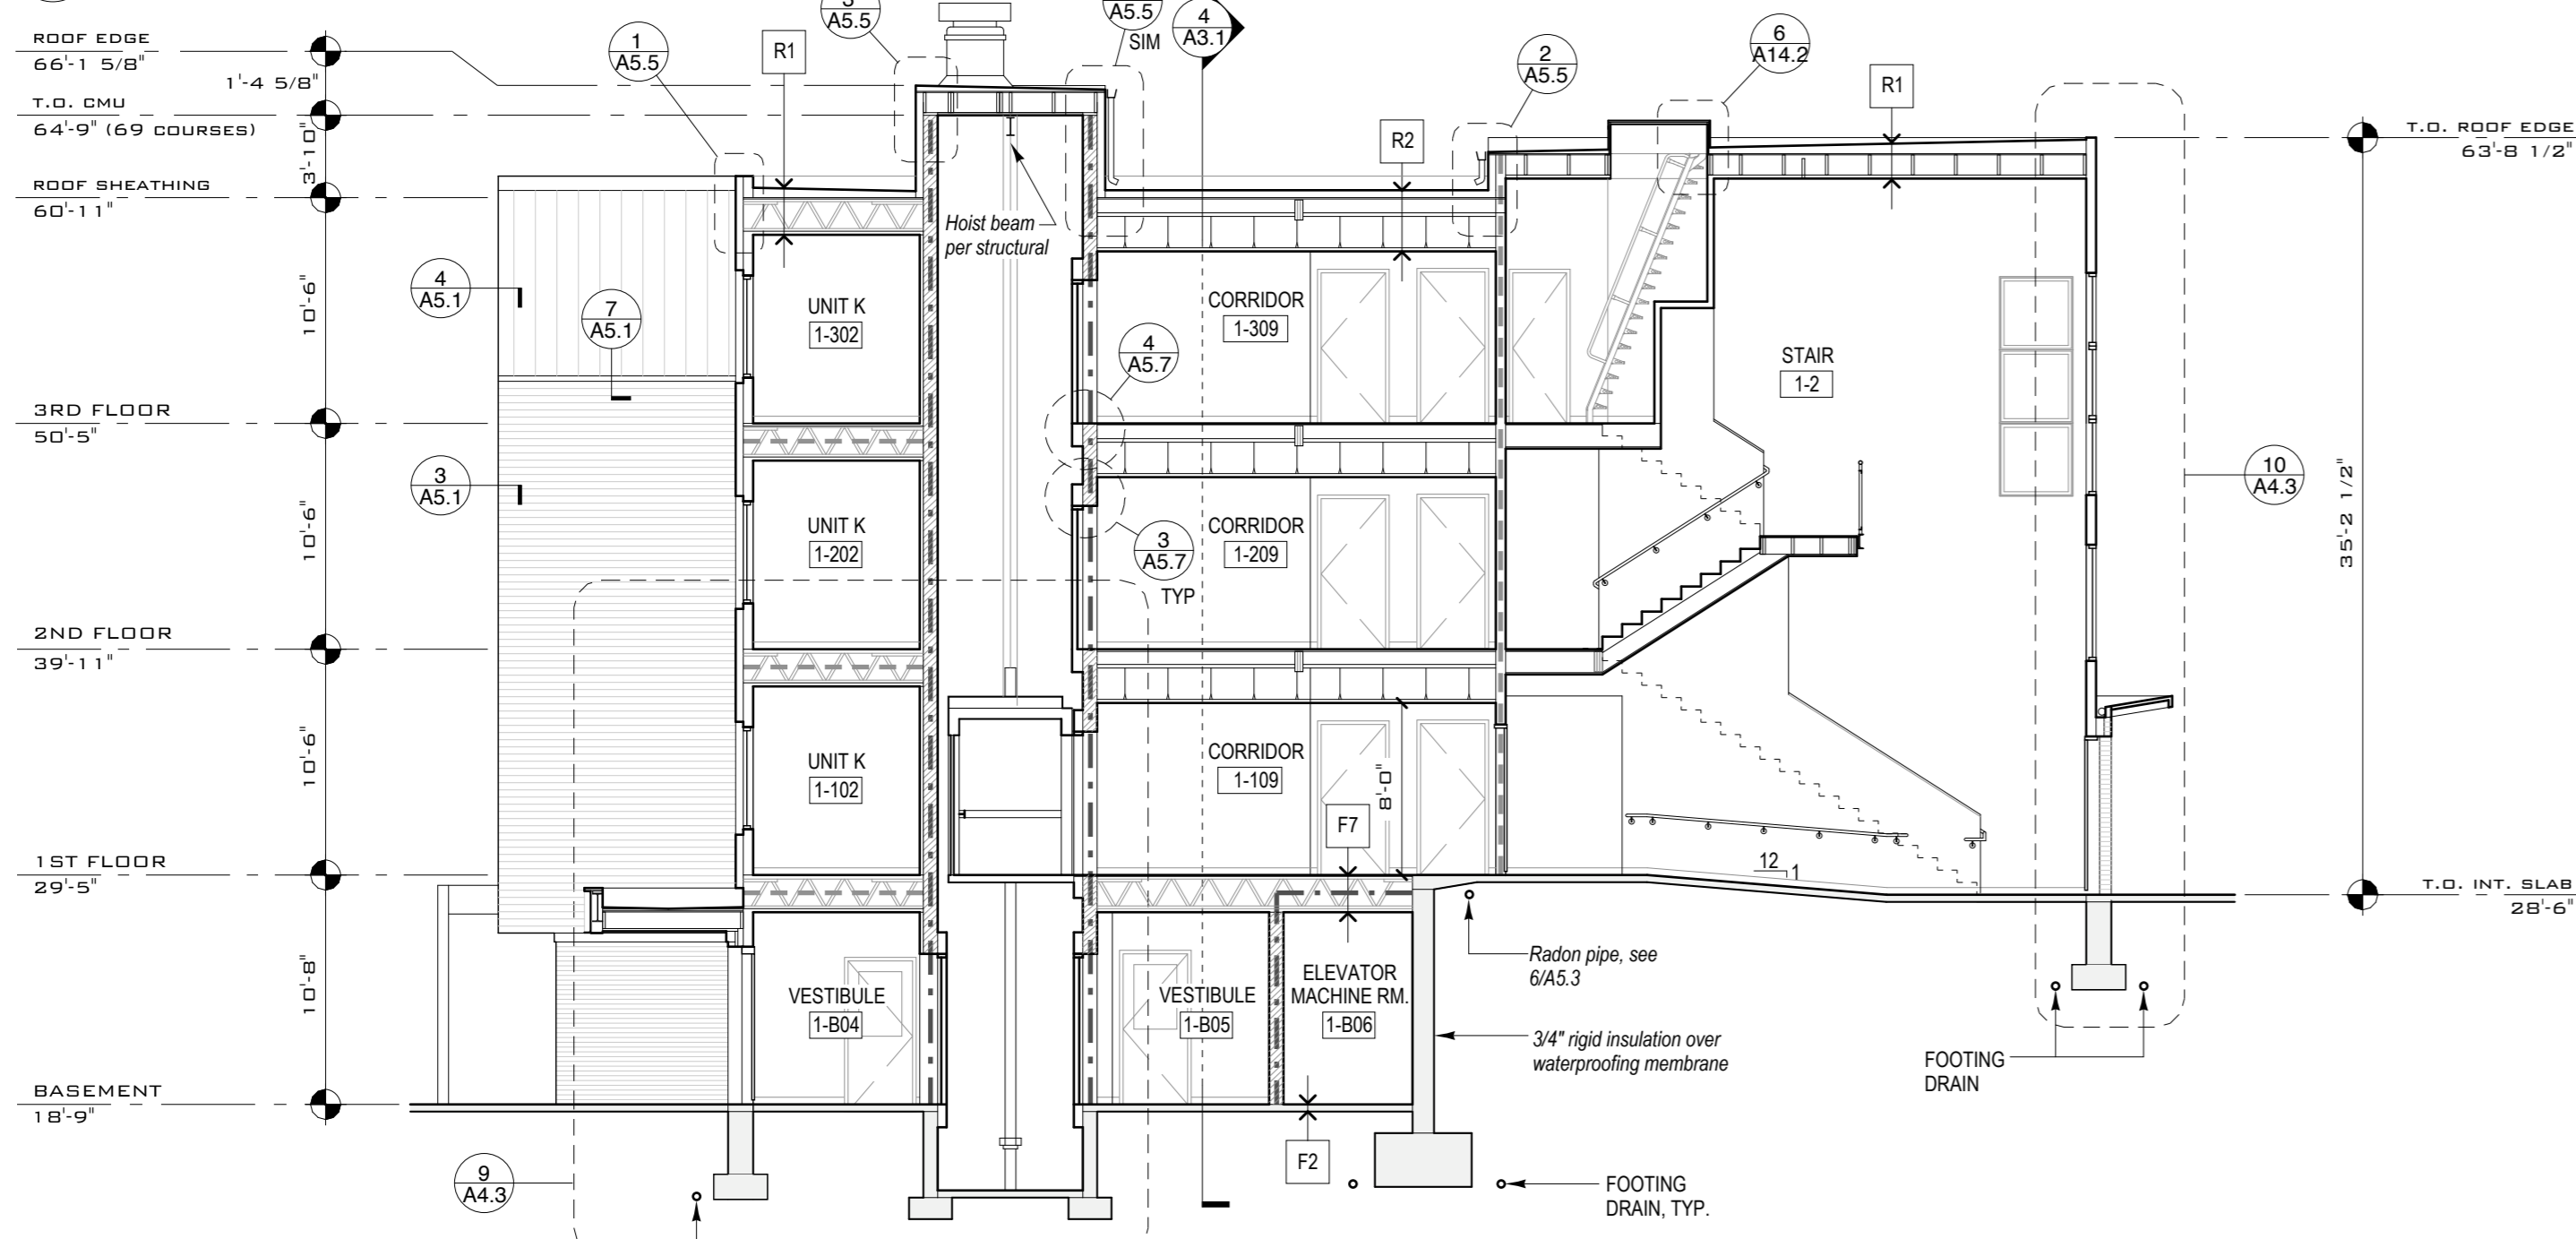


2 BUILDING SECTION
1/8" = 1'-0"

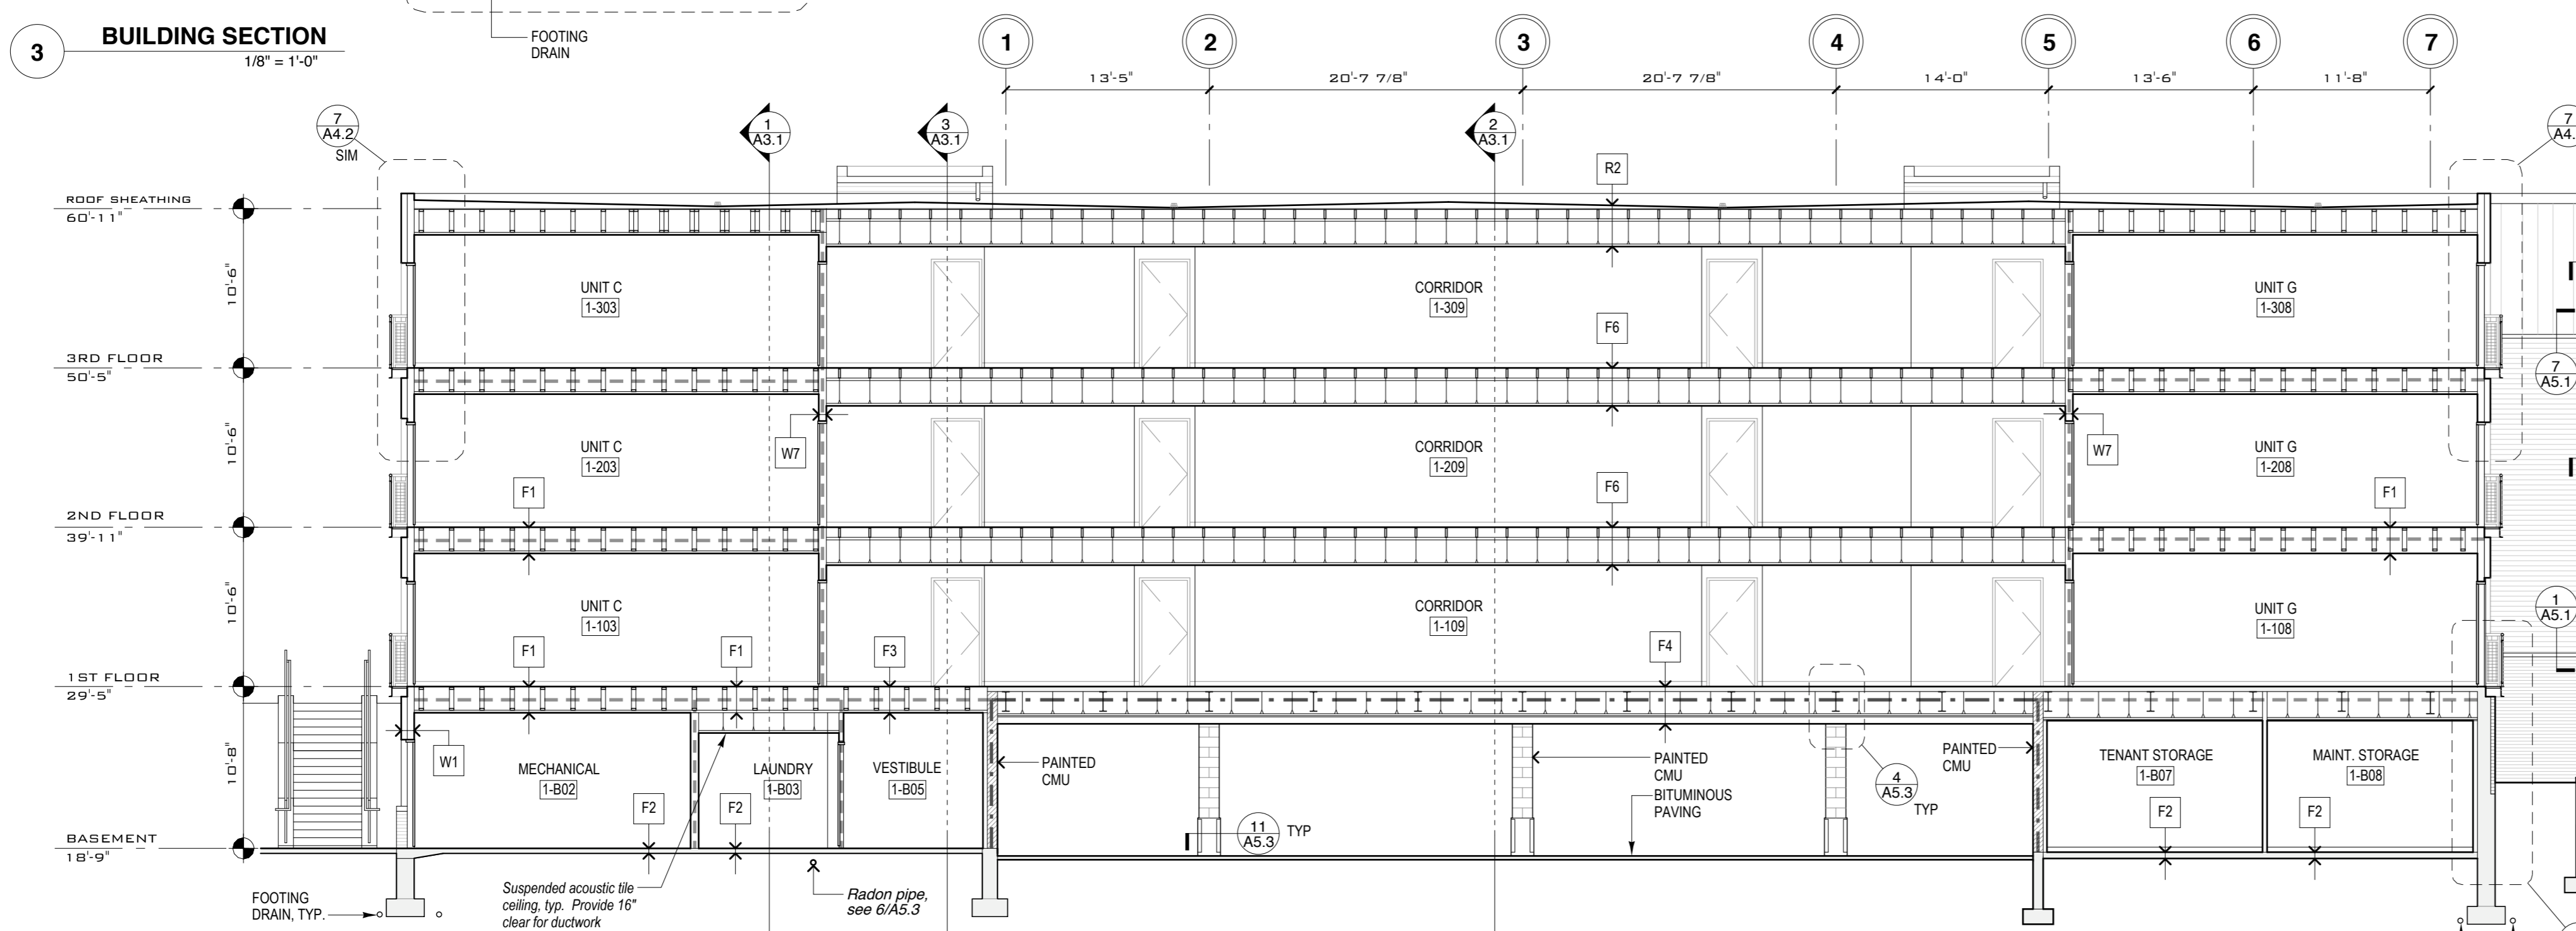

3 BUILDING SECTION
1/8" = 1'-0"



4 BUILDING SECTION
1/8" = 1'-0"

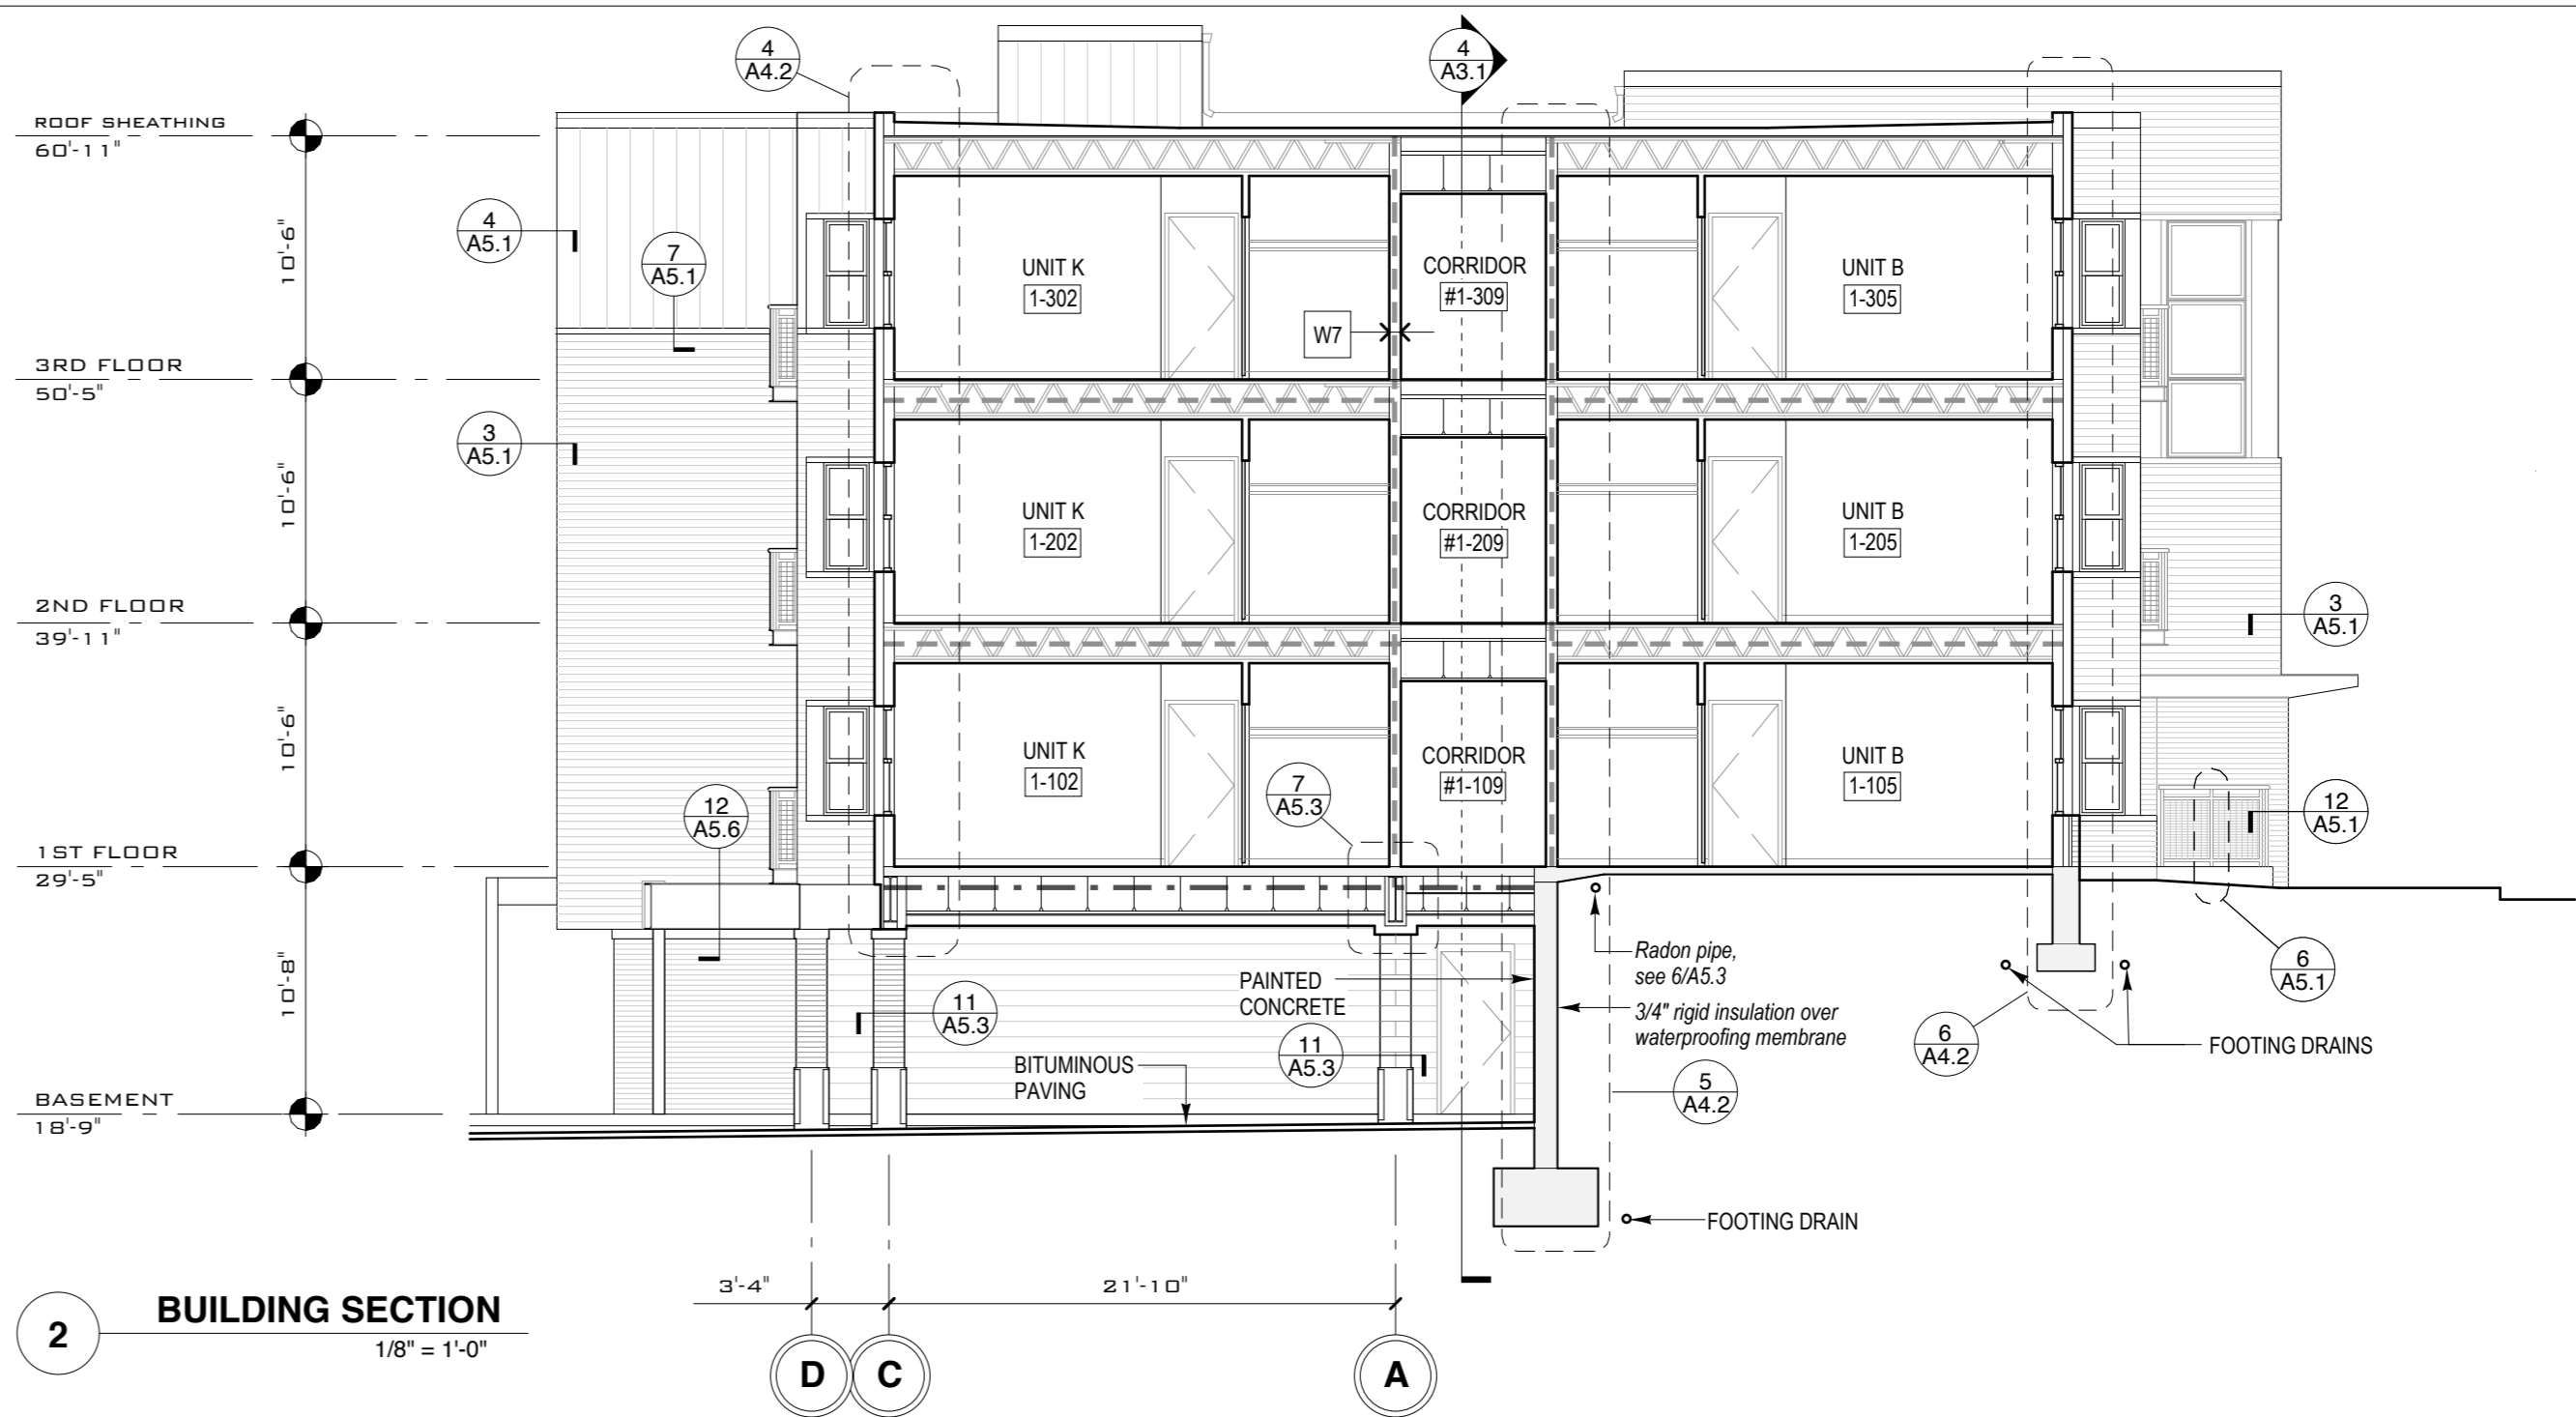

GENERAL NOTES

A STRUCTURAL COMPONENTS SHOWN, INCLUDING TRUSSES, JOISTS, FOUNDATION WORK, ETC. ARE FOR GENERAL REFERENCE ONLY. REFER TO STRUCTURAL DRAWINGS FOR SIZING & OTHER SPECIFIC INFORMATION.

B INTERIOR CABINETS, PLUMBING FIXTURES, AND OTHER INTERIOR COMPONENTS ARE SHOWN FOR GENERAL REFERENCE ONLY. SEE FLOOR PLANS AND INTERIOR ELEVATIONS FOR SPECIFIC INFORMATION.

LEGEND

X DENOTES CONSTRUCTION ASSEMBLY. SEE WALL SECTIONS FOR ASSEMBLY DESCRIPTIONS.

--- DENOTES 1-HR FIRE RATED CONSTRUCTION ASSEMBLY (DOES NOT INCLUDE DOOR OR WINDOW RATINGS, SEE SCHEDULES FOR OPENING RATINGS).

--- DENOTES 2-HR FIRE RATED CONSTRUCTION ASSEMBLY (DOES NOT INCLUDE DOOR OR WINDOW RATINGS, SEE SCHEDULES FOR OPENING RATINGS).

Pearl Place Building 1 & 2

Portland Maine

Developer
Avesta Pearl
Street One, L.P.

Architect
Winton Scott Architects

Landscape Architect
Carroll Associates

BUILDING SECTIONS
BUILDING # 1

A3.1

Scale: 1/8" = 1'-0"

SEPTEMBER 1, 2006