

5 BUILDING SECTION
1/8" = 1'-0"

5A BUILDING SECTION
1/8" = 1'-0"



6 BUILDING SECTION
1/8" = 1'-0"

BUILDING 2 STAIR TOWER EXTERIOR WALL ASSEMBLY

EXT. WALLS PARALLEL TO PEARL STREET (NON-RATED ASSEMBLY)	EXT. SIDEWALLS (PERP. TO PEARL STREET) (2-HR FIRE RATED ASSEMBLY, ESR 1365) (90 MIN. FIRE RATED GLAZING)
<ul style="list-style-type: none"> PRE-FIN. MTL. SIDING OVER 7/8" MTL. HAT CHANNELS OR BRICK VENEER & AIR SPACE AIR INFILTRATION BARRIER WALL SHEATHING PER STRUCTURAL 2X6 FIRE-TREATED WOOD STUDS 5 1/2" DENSE PACK CELLULOSE INSULATION 1/2" RESILIENT CHANNELS VAPOR BARRIER 5/8" PTD. GWB 	<ul style="list-style-type: none"> PRE-FIN. MTL. SIDING OVER 7/8" MTL. HAT CHANNELS OR BRICK VENEER & AIR SPACE AIR INFILTRATION BARRIER 1/2" BLAZEGUARD PLYWD. SHEATHING 2X6 FIRE-TREATED WOOD STUDS 5 1/2" DENSE PACK CELLULOSE INSULATION 1/2" RESILIENT CHANNELS VAPOR BARRIER (2) LAYERS FC TYPE X GWB, PAINTED

- GENERAL NOTES**
- A STRUCTURAL COMPONENTS SHOWN, INCLUDING TRUSSES, JOISTS, FOUNDATION WORK, ETC. ARE FOR GENERAL REFERENCE ONLY. REFER TO STRUCTURAL DRAWINGS FOR SIZING & OTHER SPECIFIC INFORMATION.
 - B INTERIOR CABINETRY, PLUMBING FIXTURES, AND OTHER INTERIOR COMPONENTS ARE SHOWN FOR GENERAL REFERENCE ONLY. SEE FLOOR PLANS AND INTERIOR ELEVATIONS FOR SPECIFIC INFORMATION.

- LEGEND**
- X DENOTES CONSTRUCTION ASSEMBLY. SEE WALL SECTIONS FOR ASSEMBLY DESCRIPTIONS.
 - - - DENOTES 1-HR FIRE RATED CONSTRUCTION ASSEMBLY (DOES NOT INCLUDE DOOR OR WINDOW RATINGS, SEE SCHEDULES FOR OPENING RATINGS).
 - - - DENOTES 2-HR FIRE RATED CONSTRUCTION ASSEMBLY (DOES NOT INCLUDE DOOR OR WINDOW RATINGS, SEE SCHEDULES FOR OPENING RATINGS).

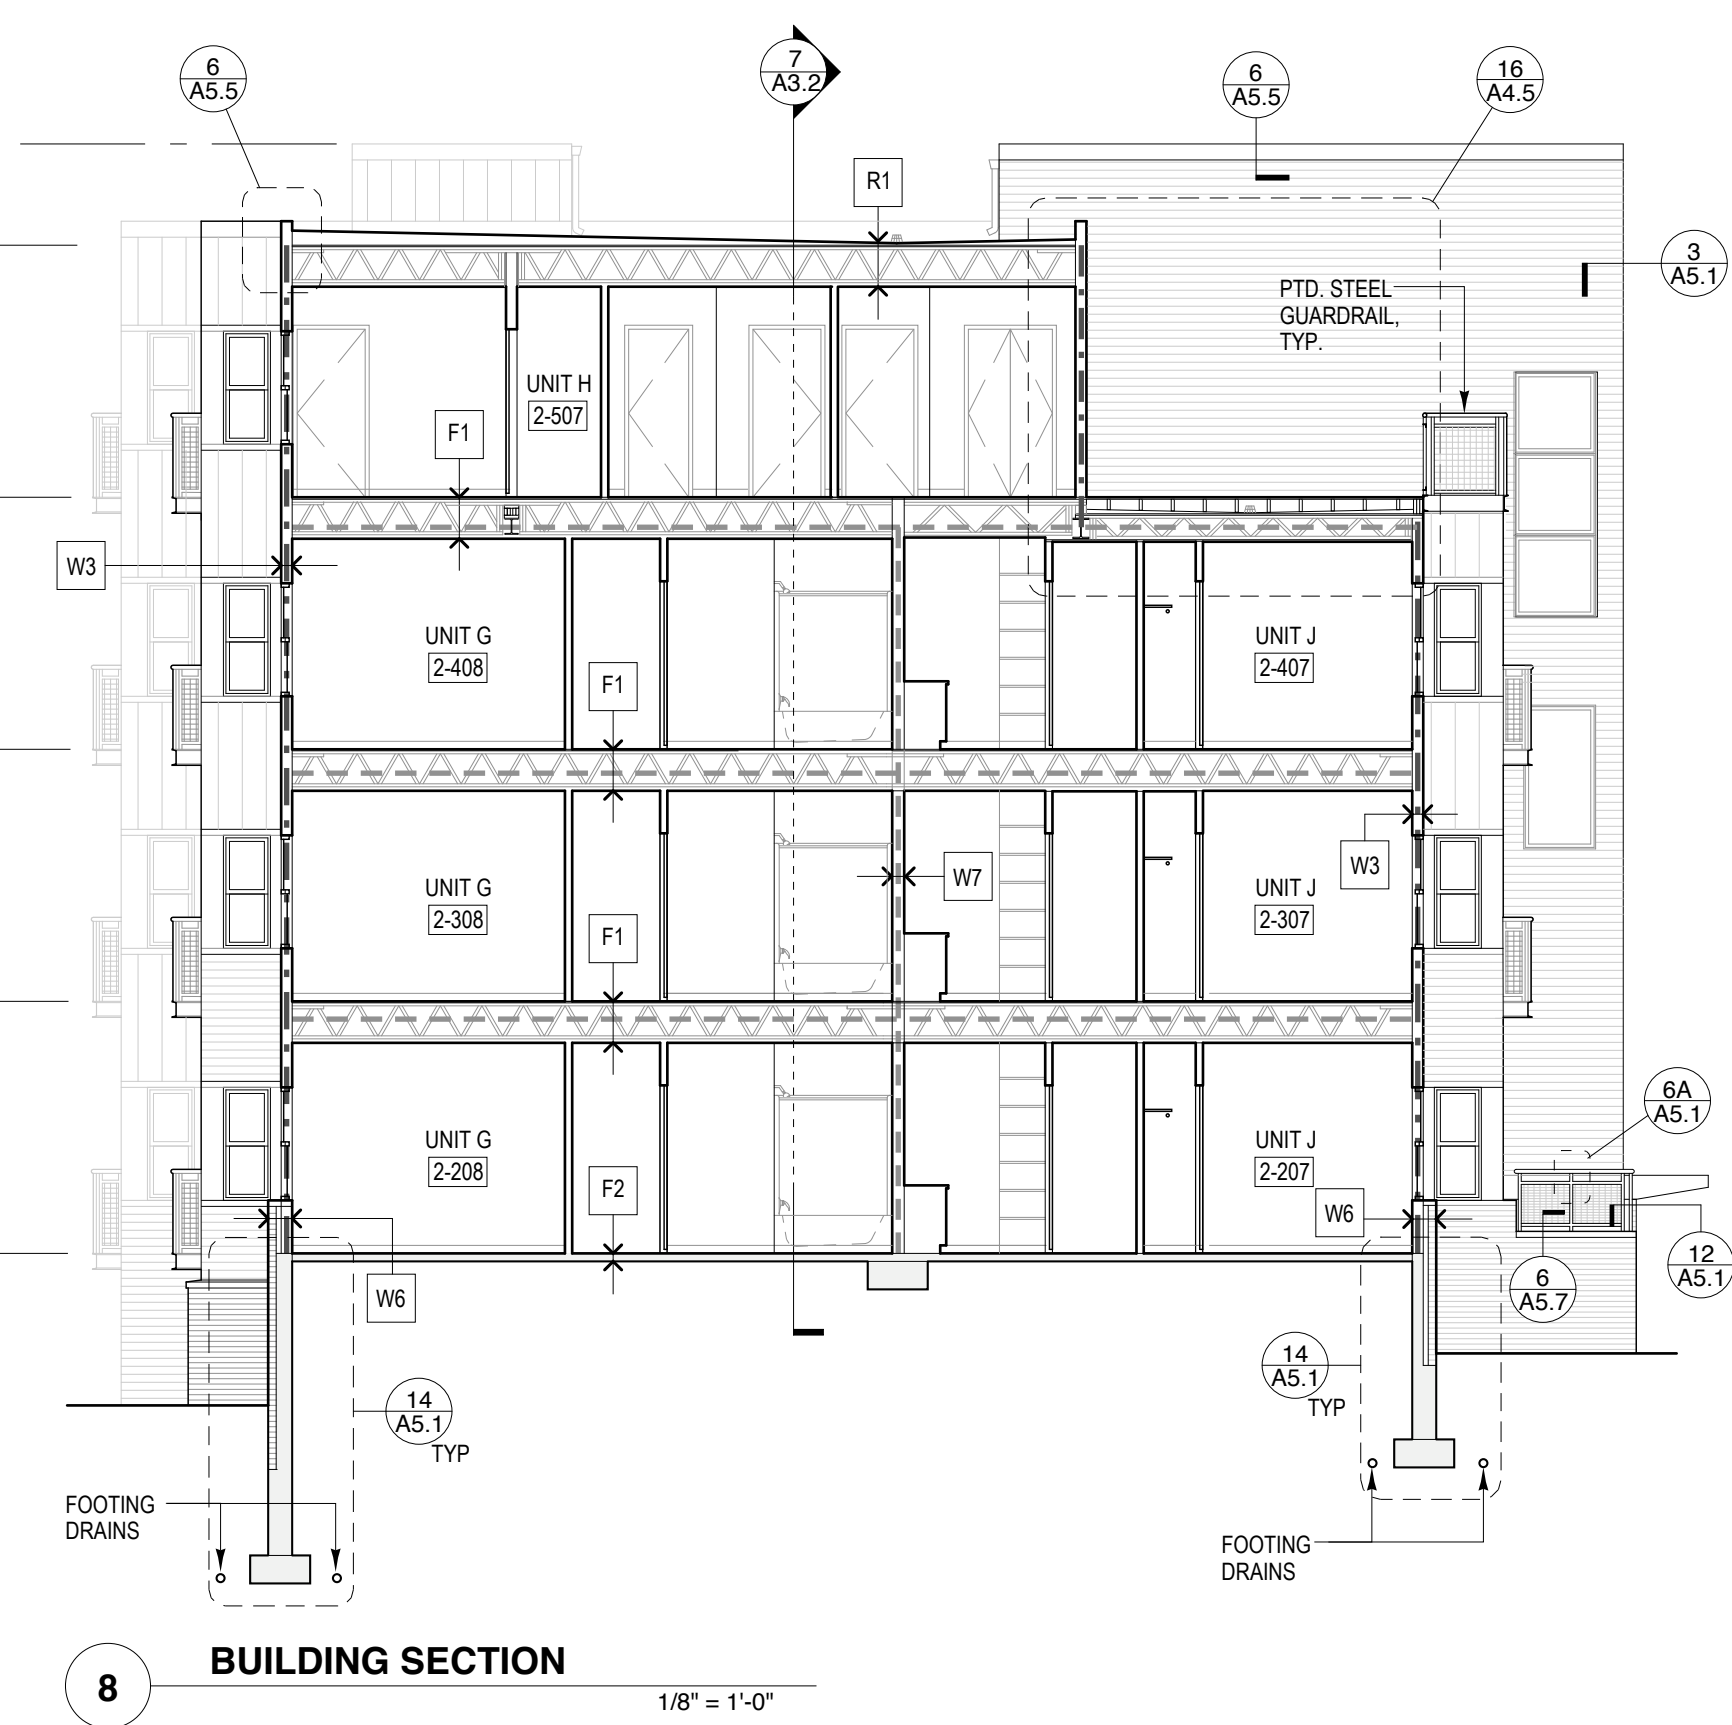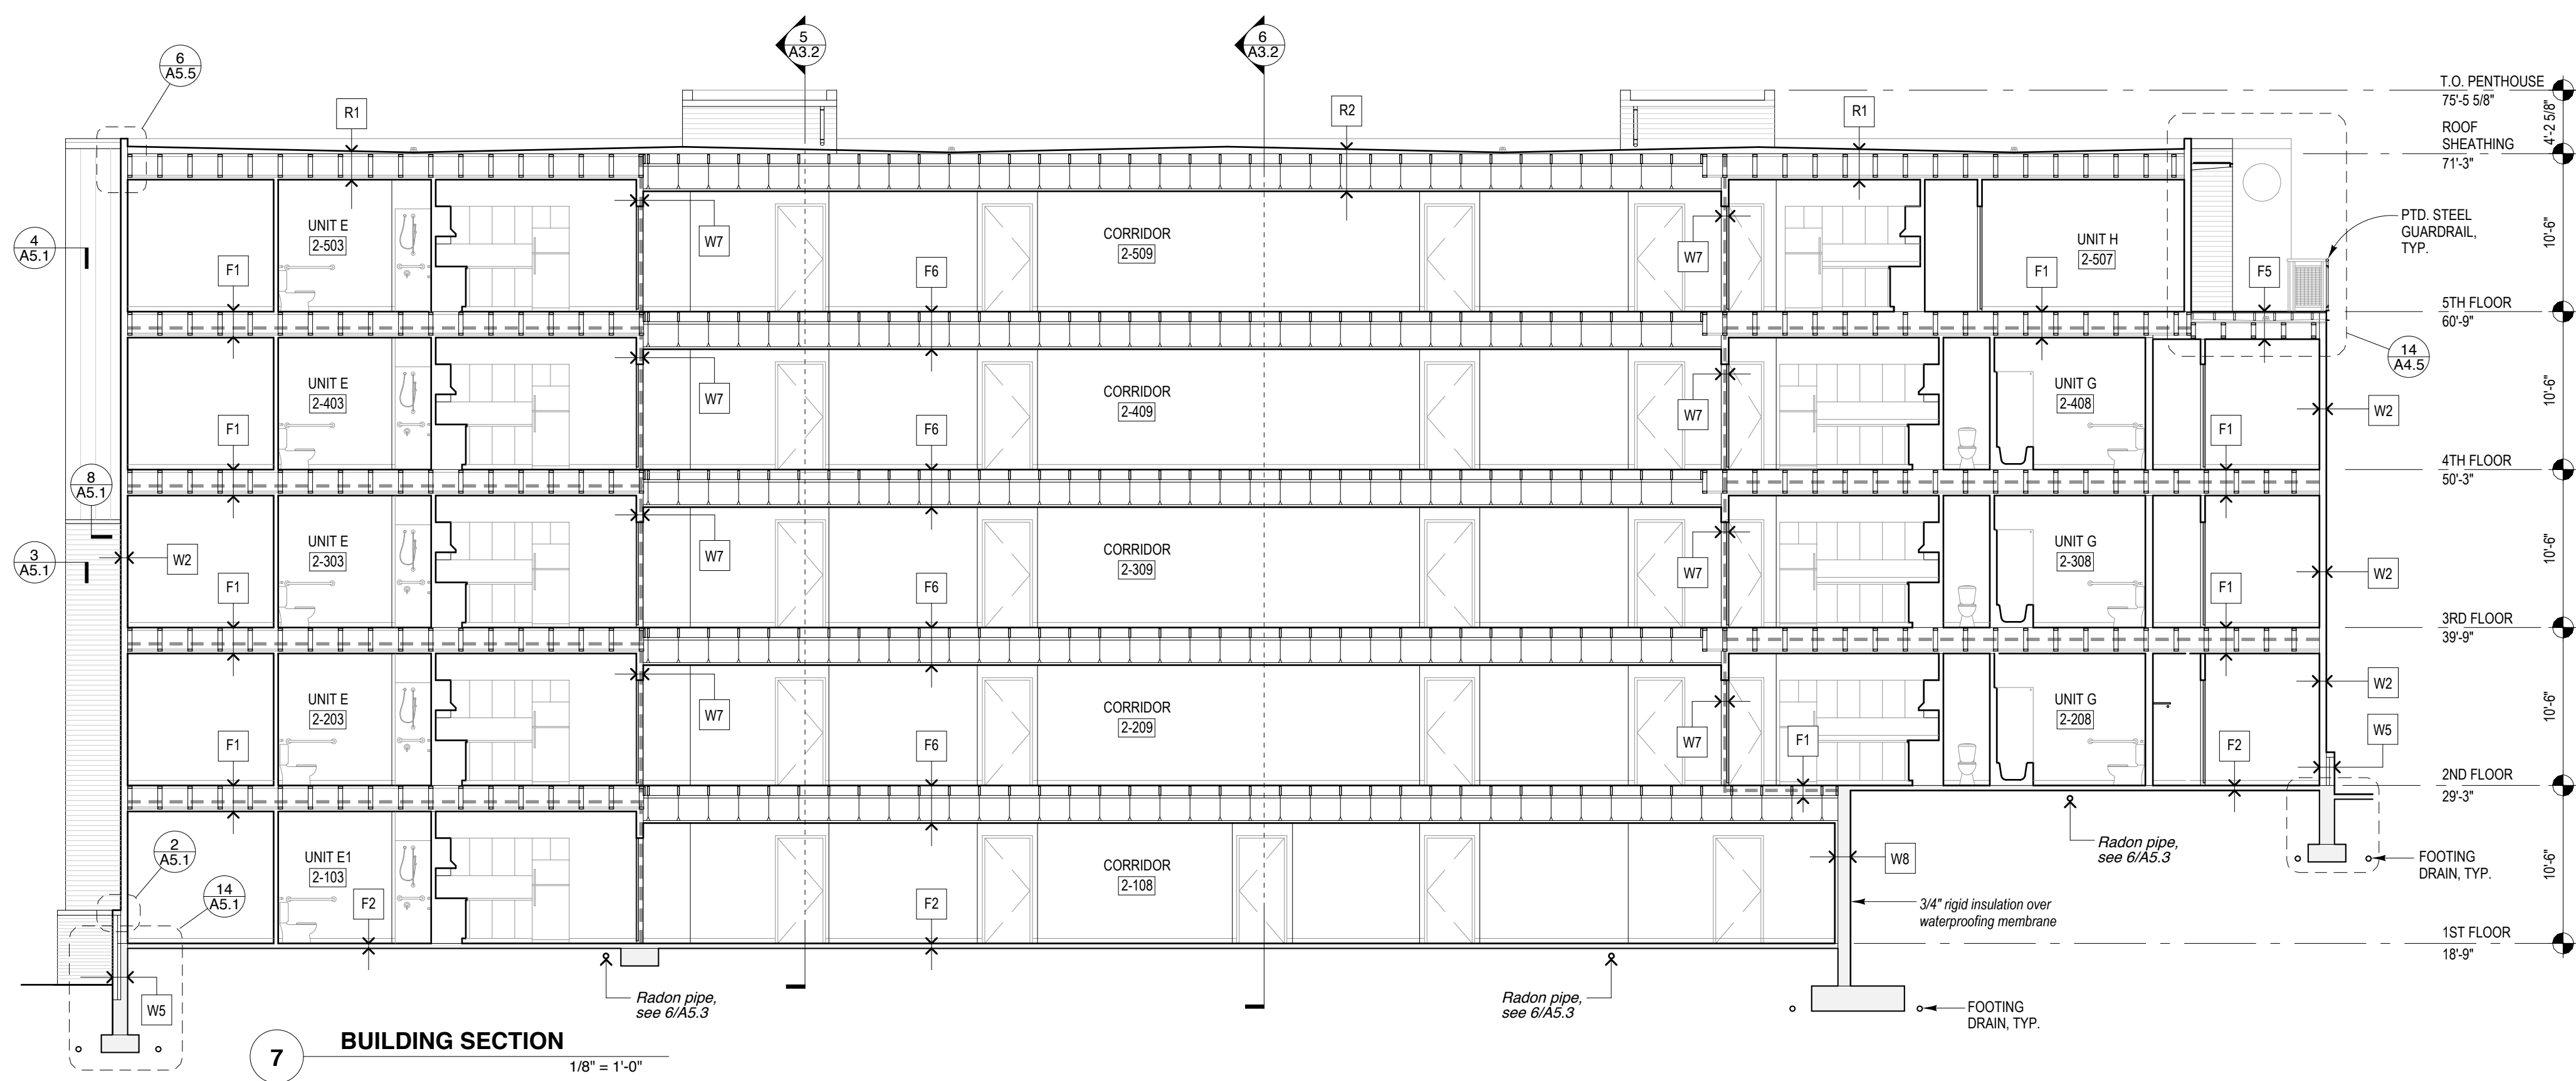

7 BUILDING SECTION
1/8" = 1'-0"

8 BUILDING SECTION
1/8" = 1'-0"

Pearl Place Building 1 & 2

Portland Maine

Developer
Avesta Pearl
Street One, L.P.

Architect
Winton Scott Architects

Landscape Architect
Carroll Associates

BUILDING SECTIONS
BUILDING # 2

A3.2

Scale: 1/8" = 1'-0"

SEPTEMBER 1, 2006