

JOB NO.
10-020

DRWN. CHK.
TWG WSBJR


SCALE:
1/8" = 1'-0"

ISSUE:
August 3, 2011
For Bid

TITLE
FIRST FLOOR
ELECTRICAL
PLAN

SHEET

E1.2

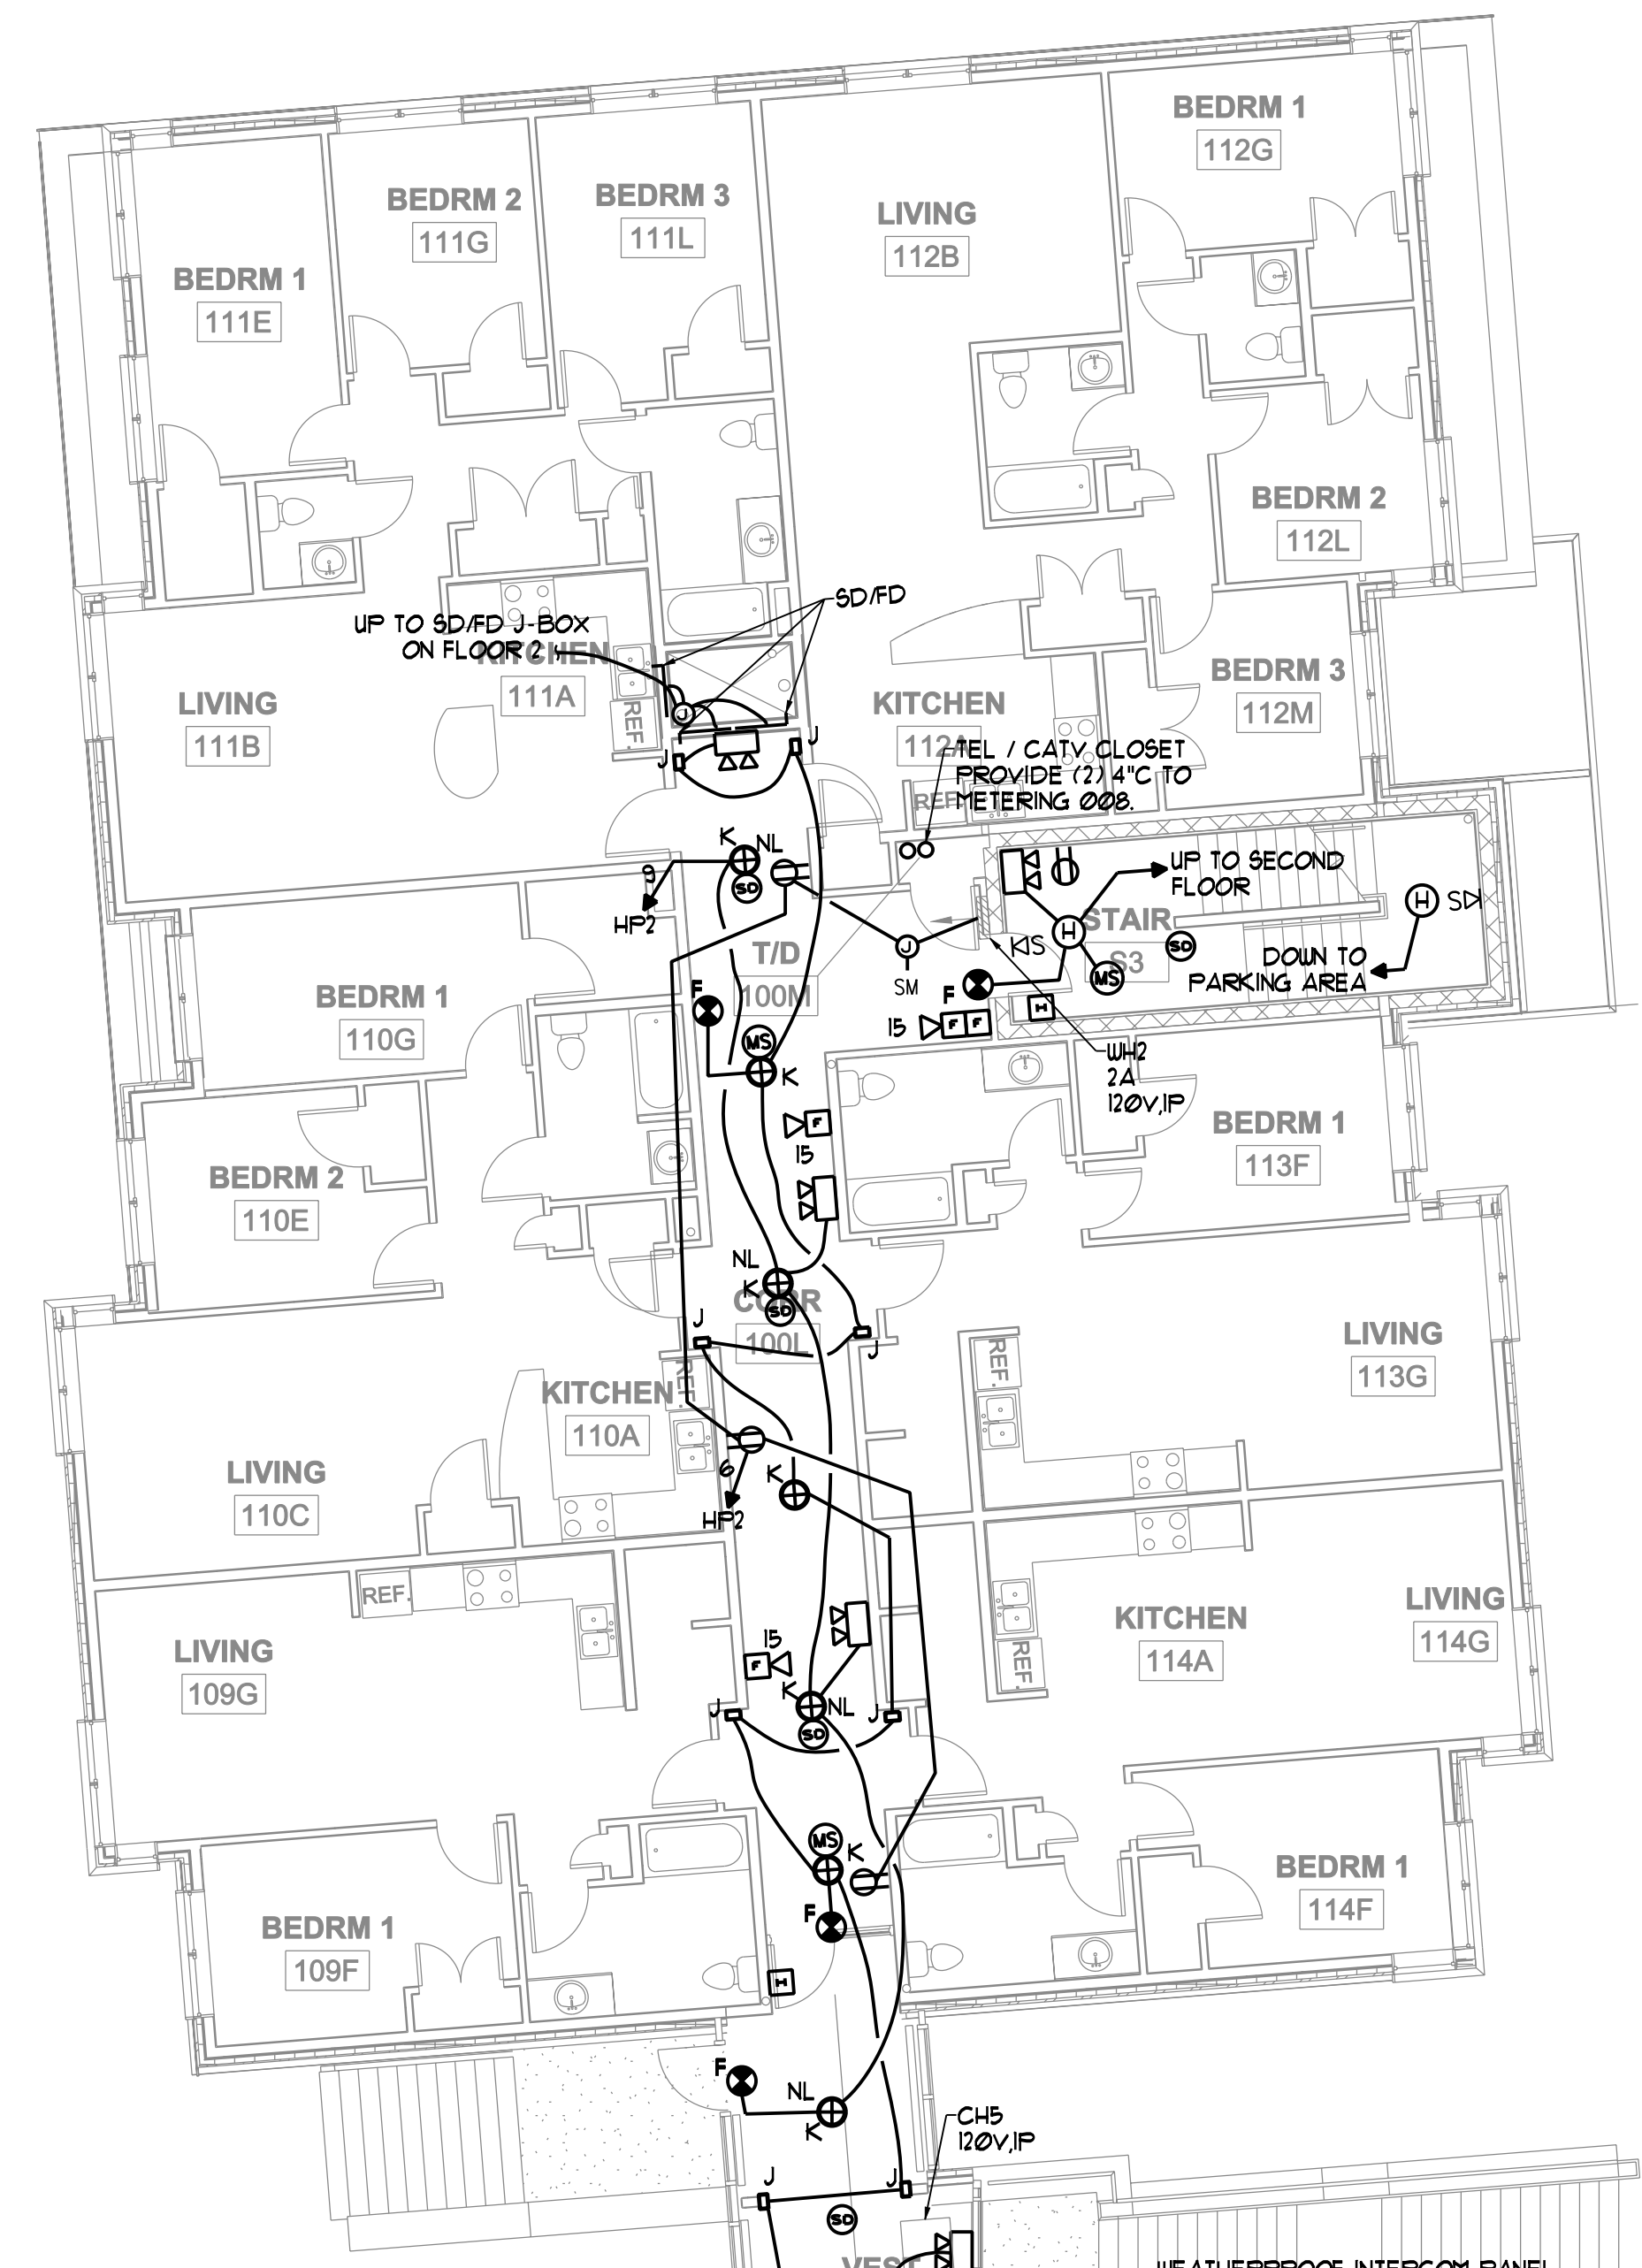

NOTE
 SEE NOTE ON DWG E1.1

FIRST FLOOR ELECTRICAL PLAN
 SCALE: 1/8" = 1'-0"

