

JOB NO.
10-020

DRWN: CHK
TWG WSBJR


SCALE:
1/8" = 1'-0"

ISSUE:
August 3, 2011
For Bid

TITLE
SECOND FLOOR
ELECTRICAL
PLAN

SHEET

E1.3

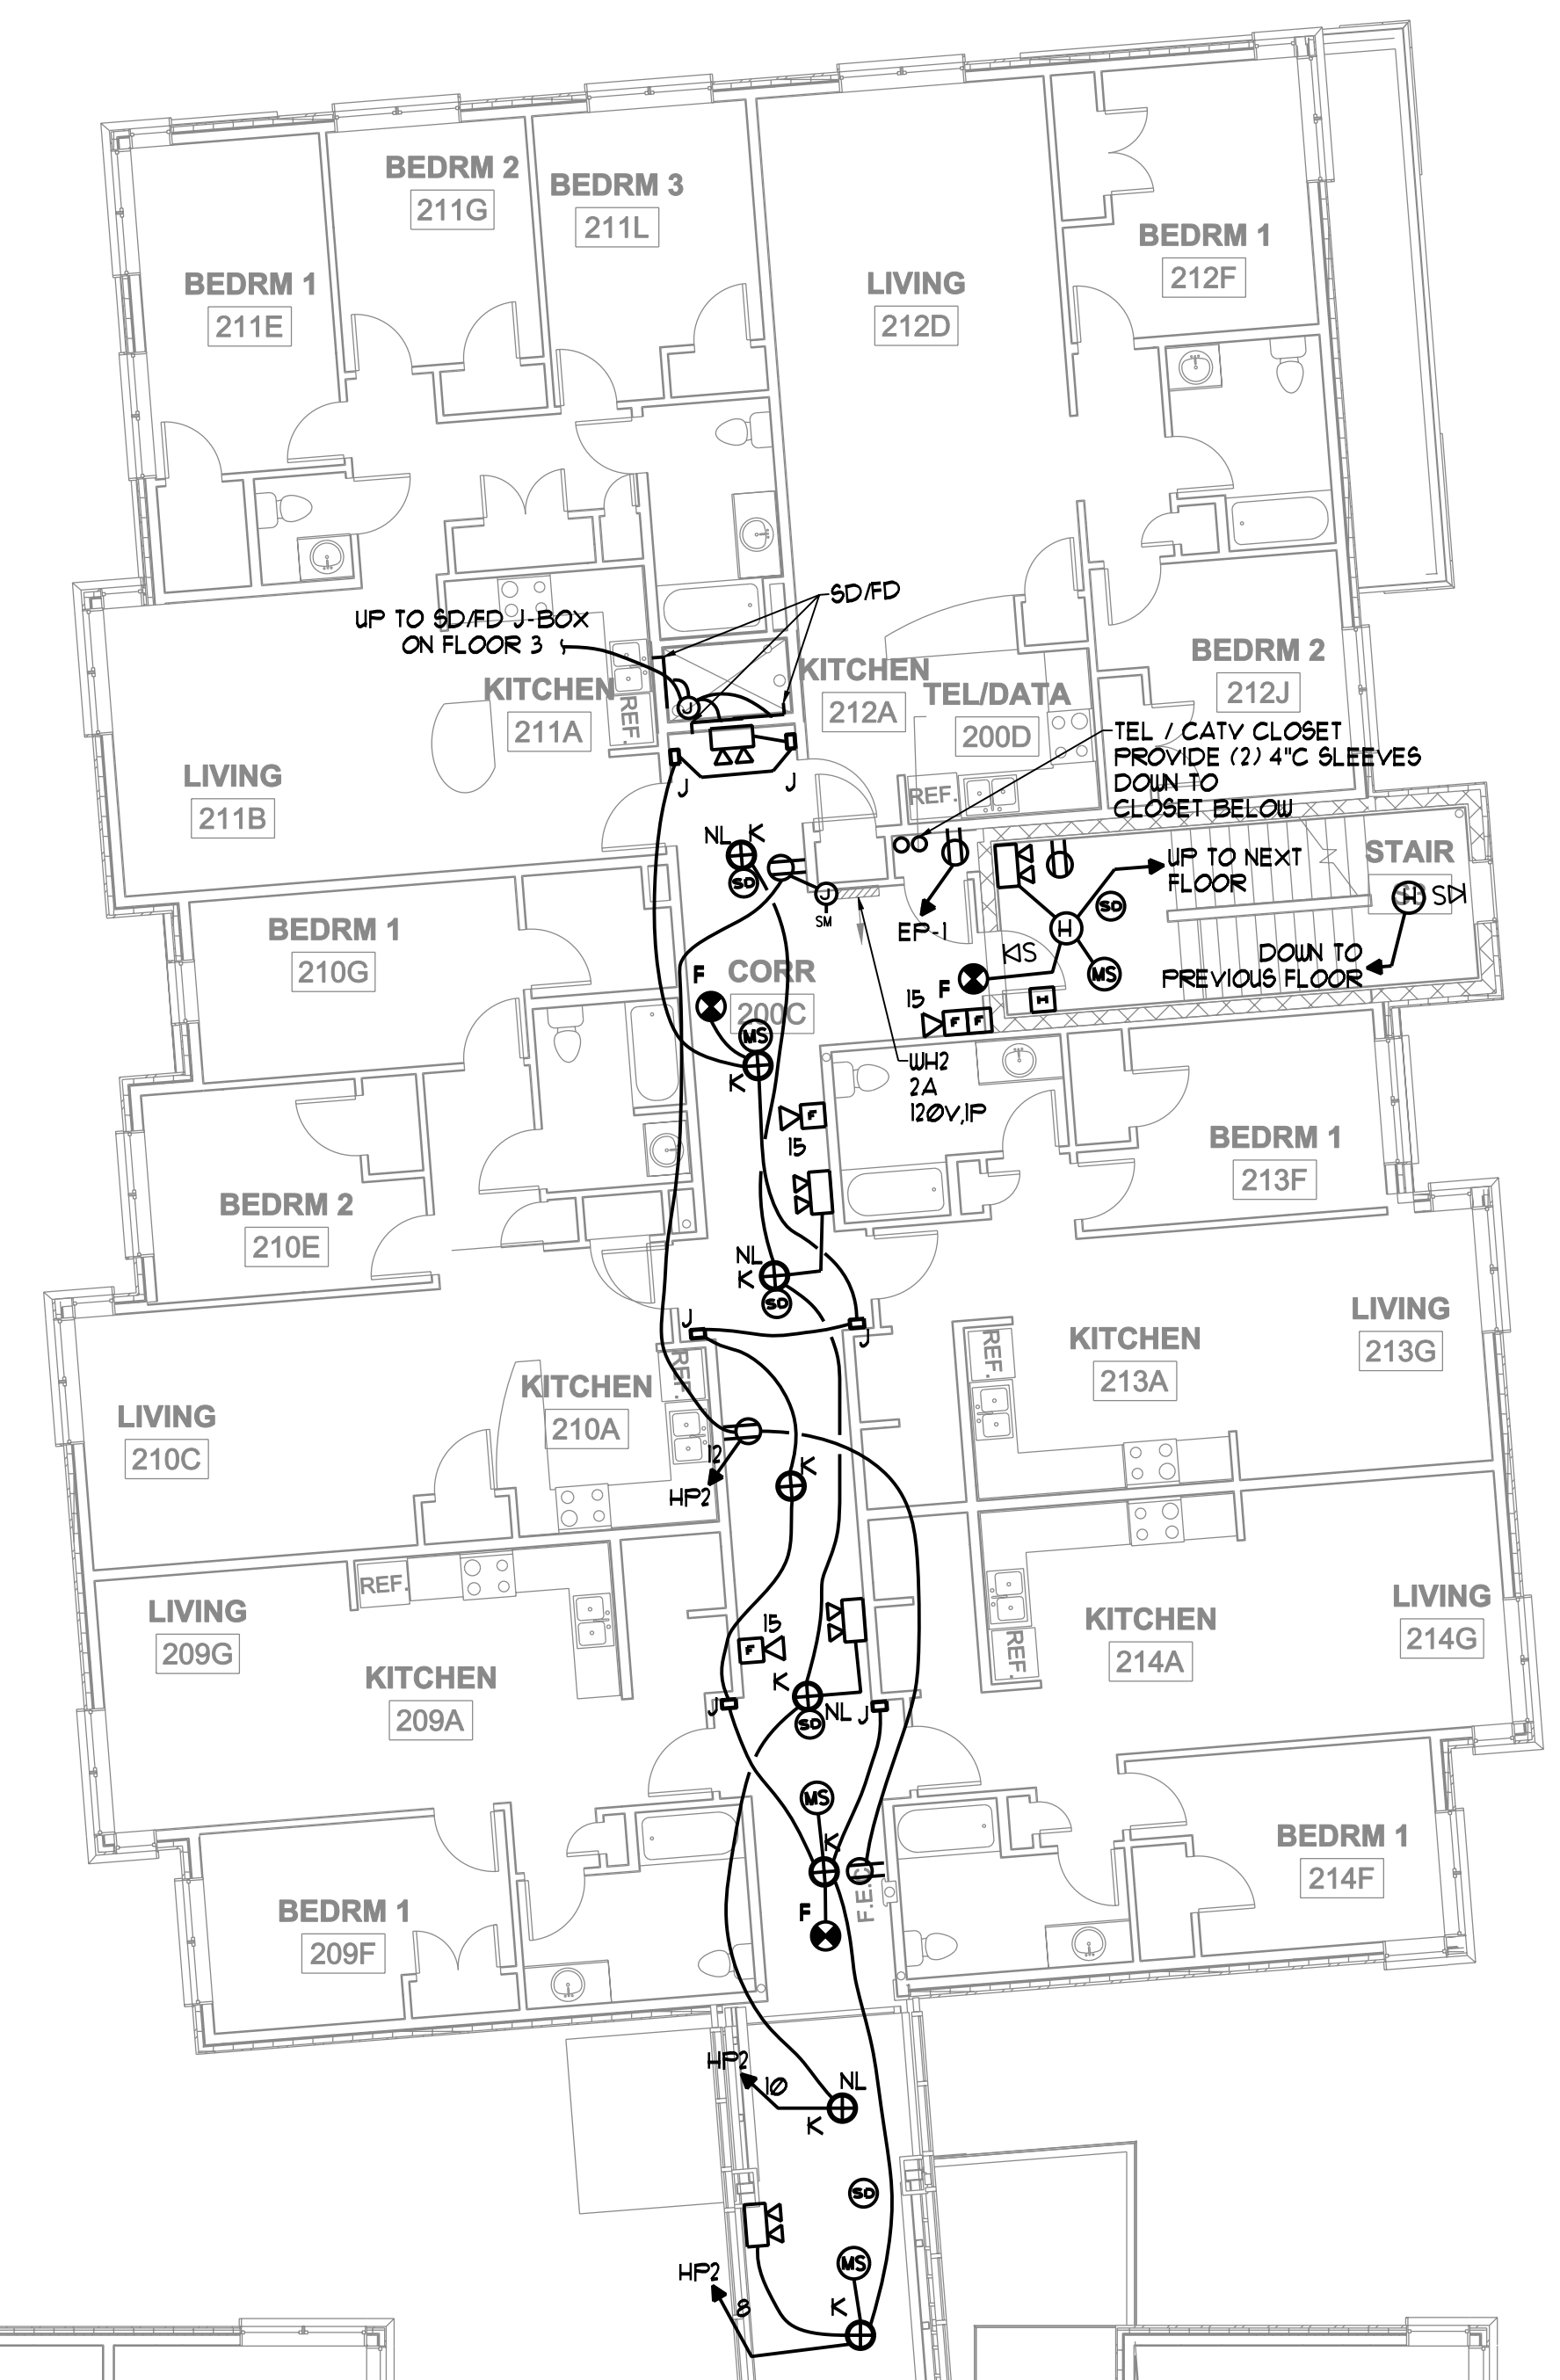

NOTE
SEE NOTE ON DWG E1.1

SECOND FLOOR ELECTRICAL PLAN
SCALE: 1/8" = 1'-0"

