

JOB NO.
10-020

DRWN. CHK.
TWG WSBJR


SCALE:
1/8" = 1'-0"

ISSUE:
August 3, 2011
For Bid

TITLE
THIRD FLOOR
ELECTRICAL
PLAN


SHEET

E1.4

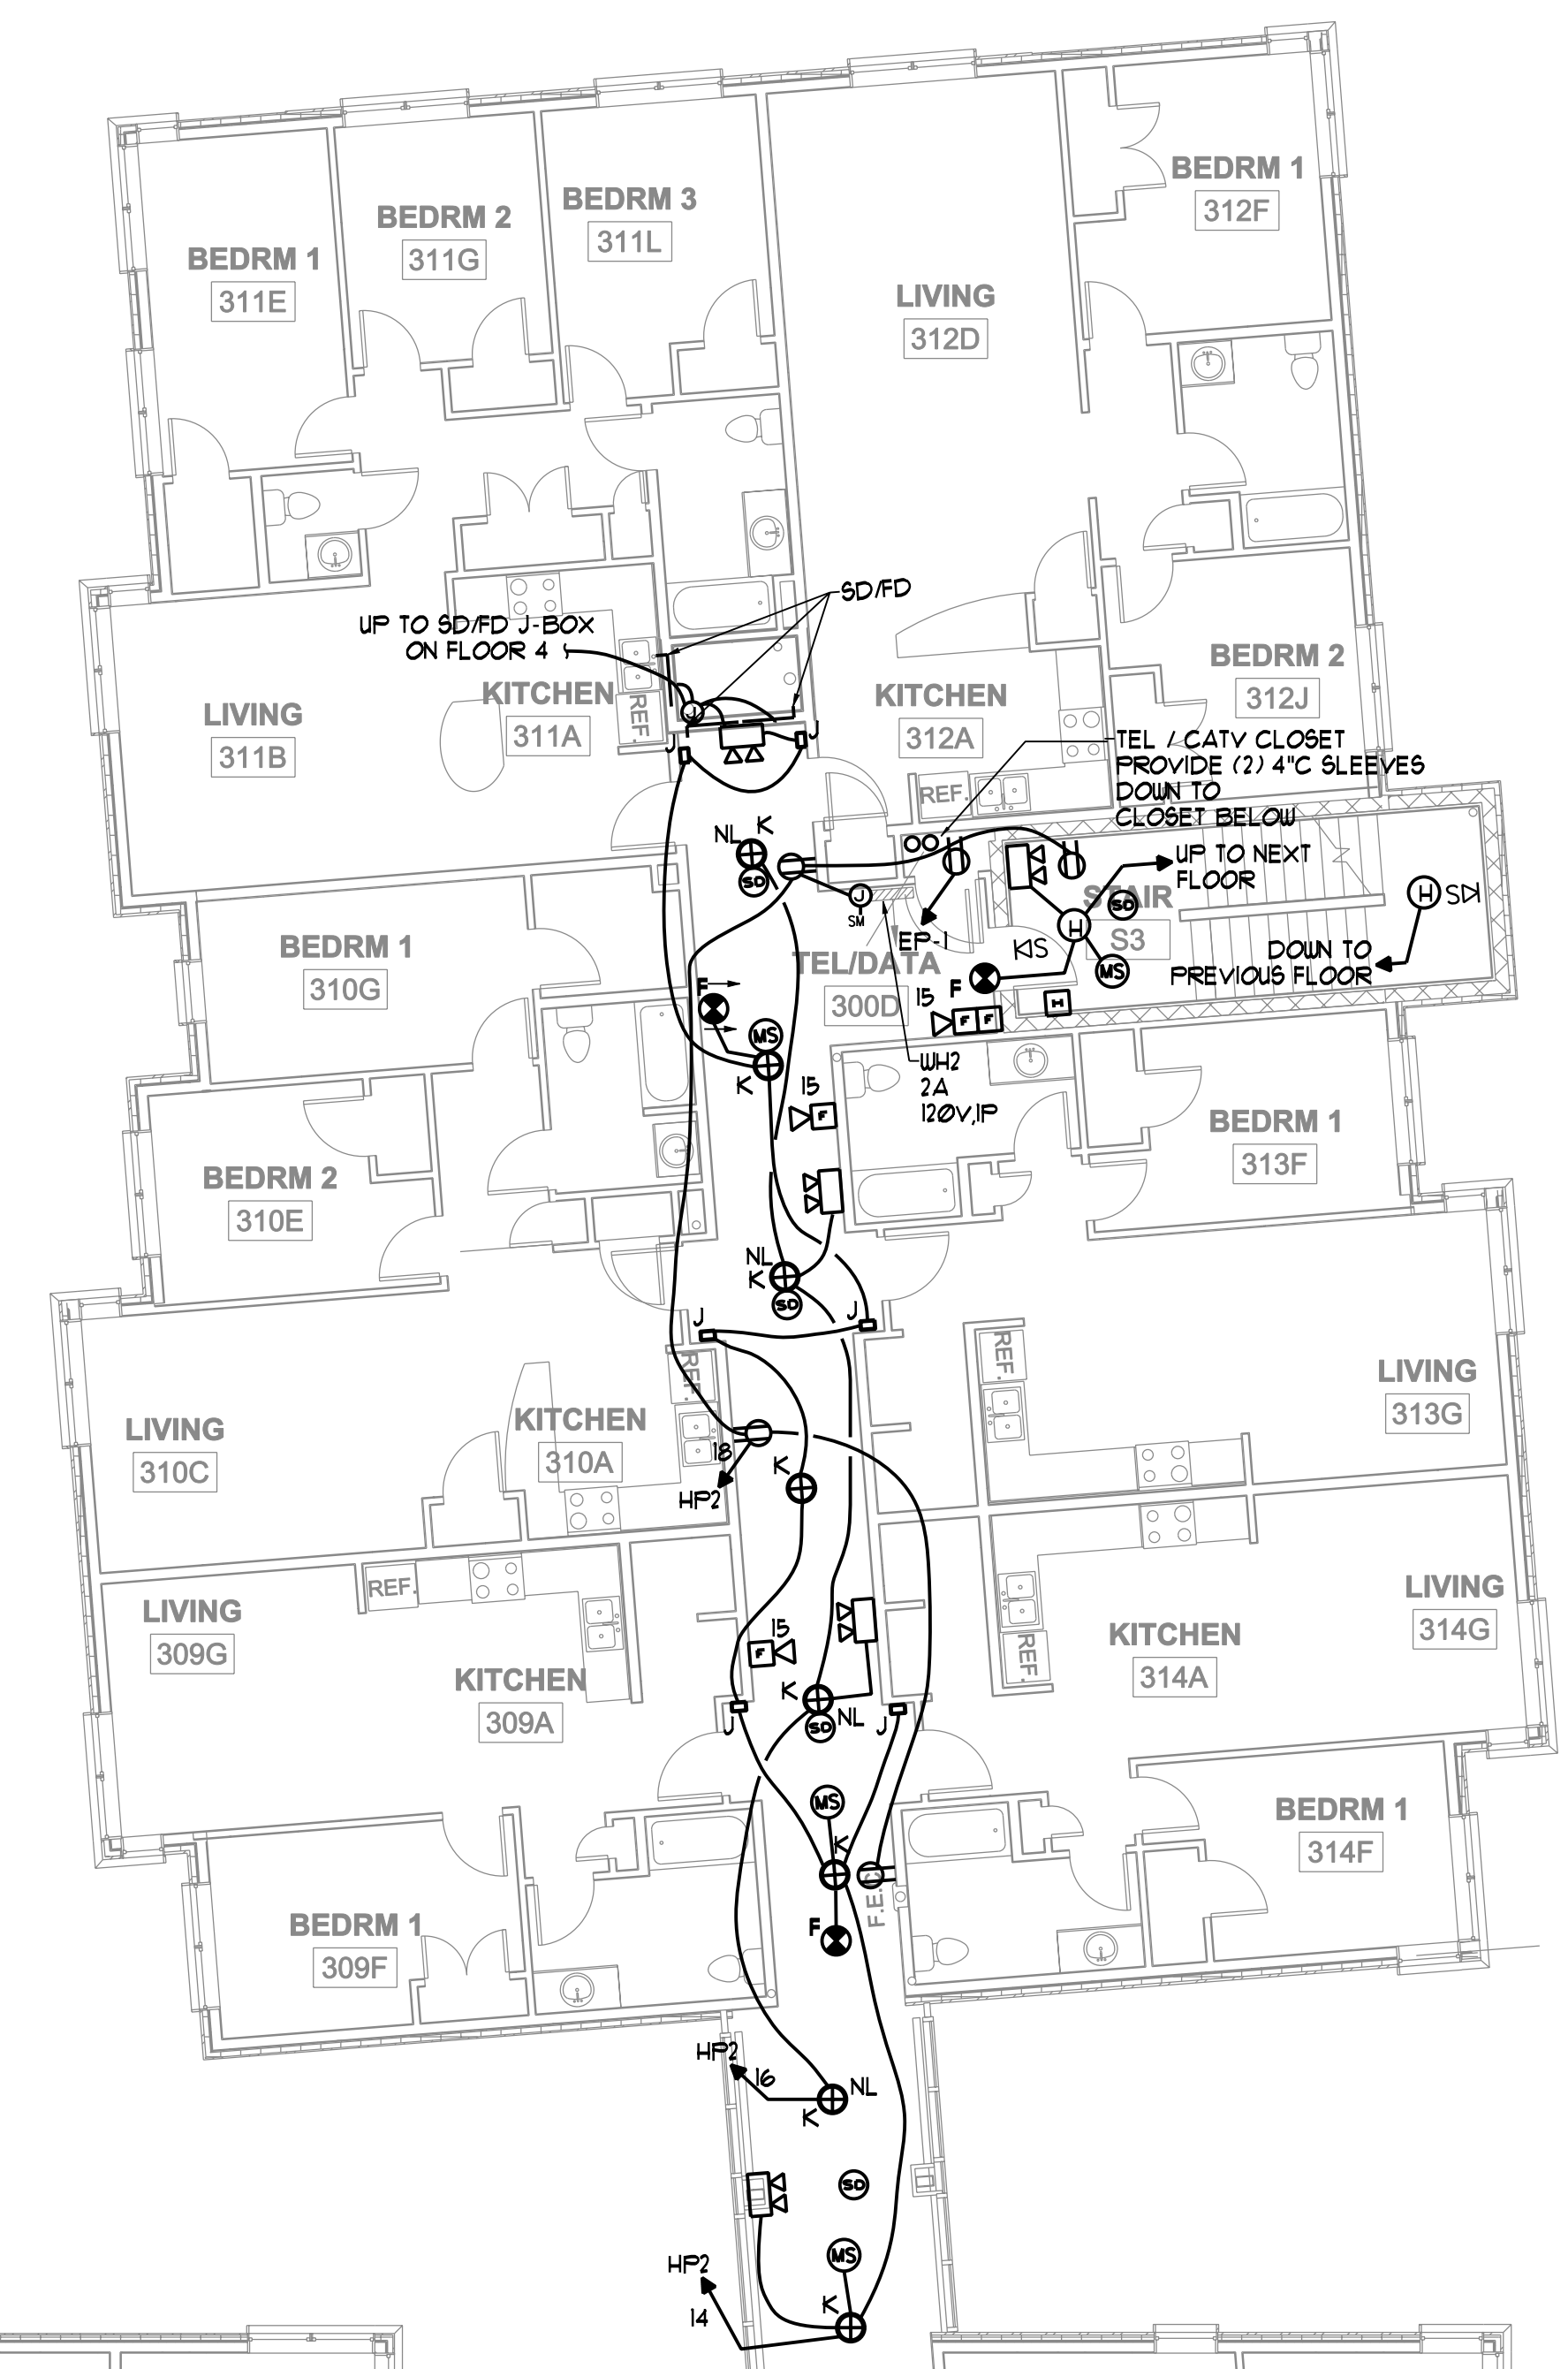

NOTE
SEE NOTE ON DWG E1.1

THIRD FLOOR ELECTRICAL PLAN
SCALE: 1/8" = 1'-0"

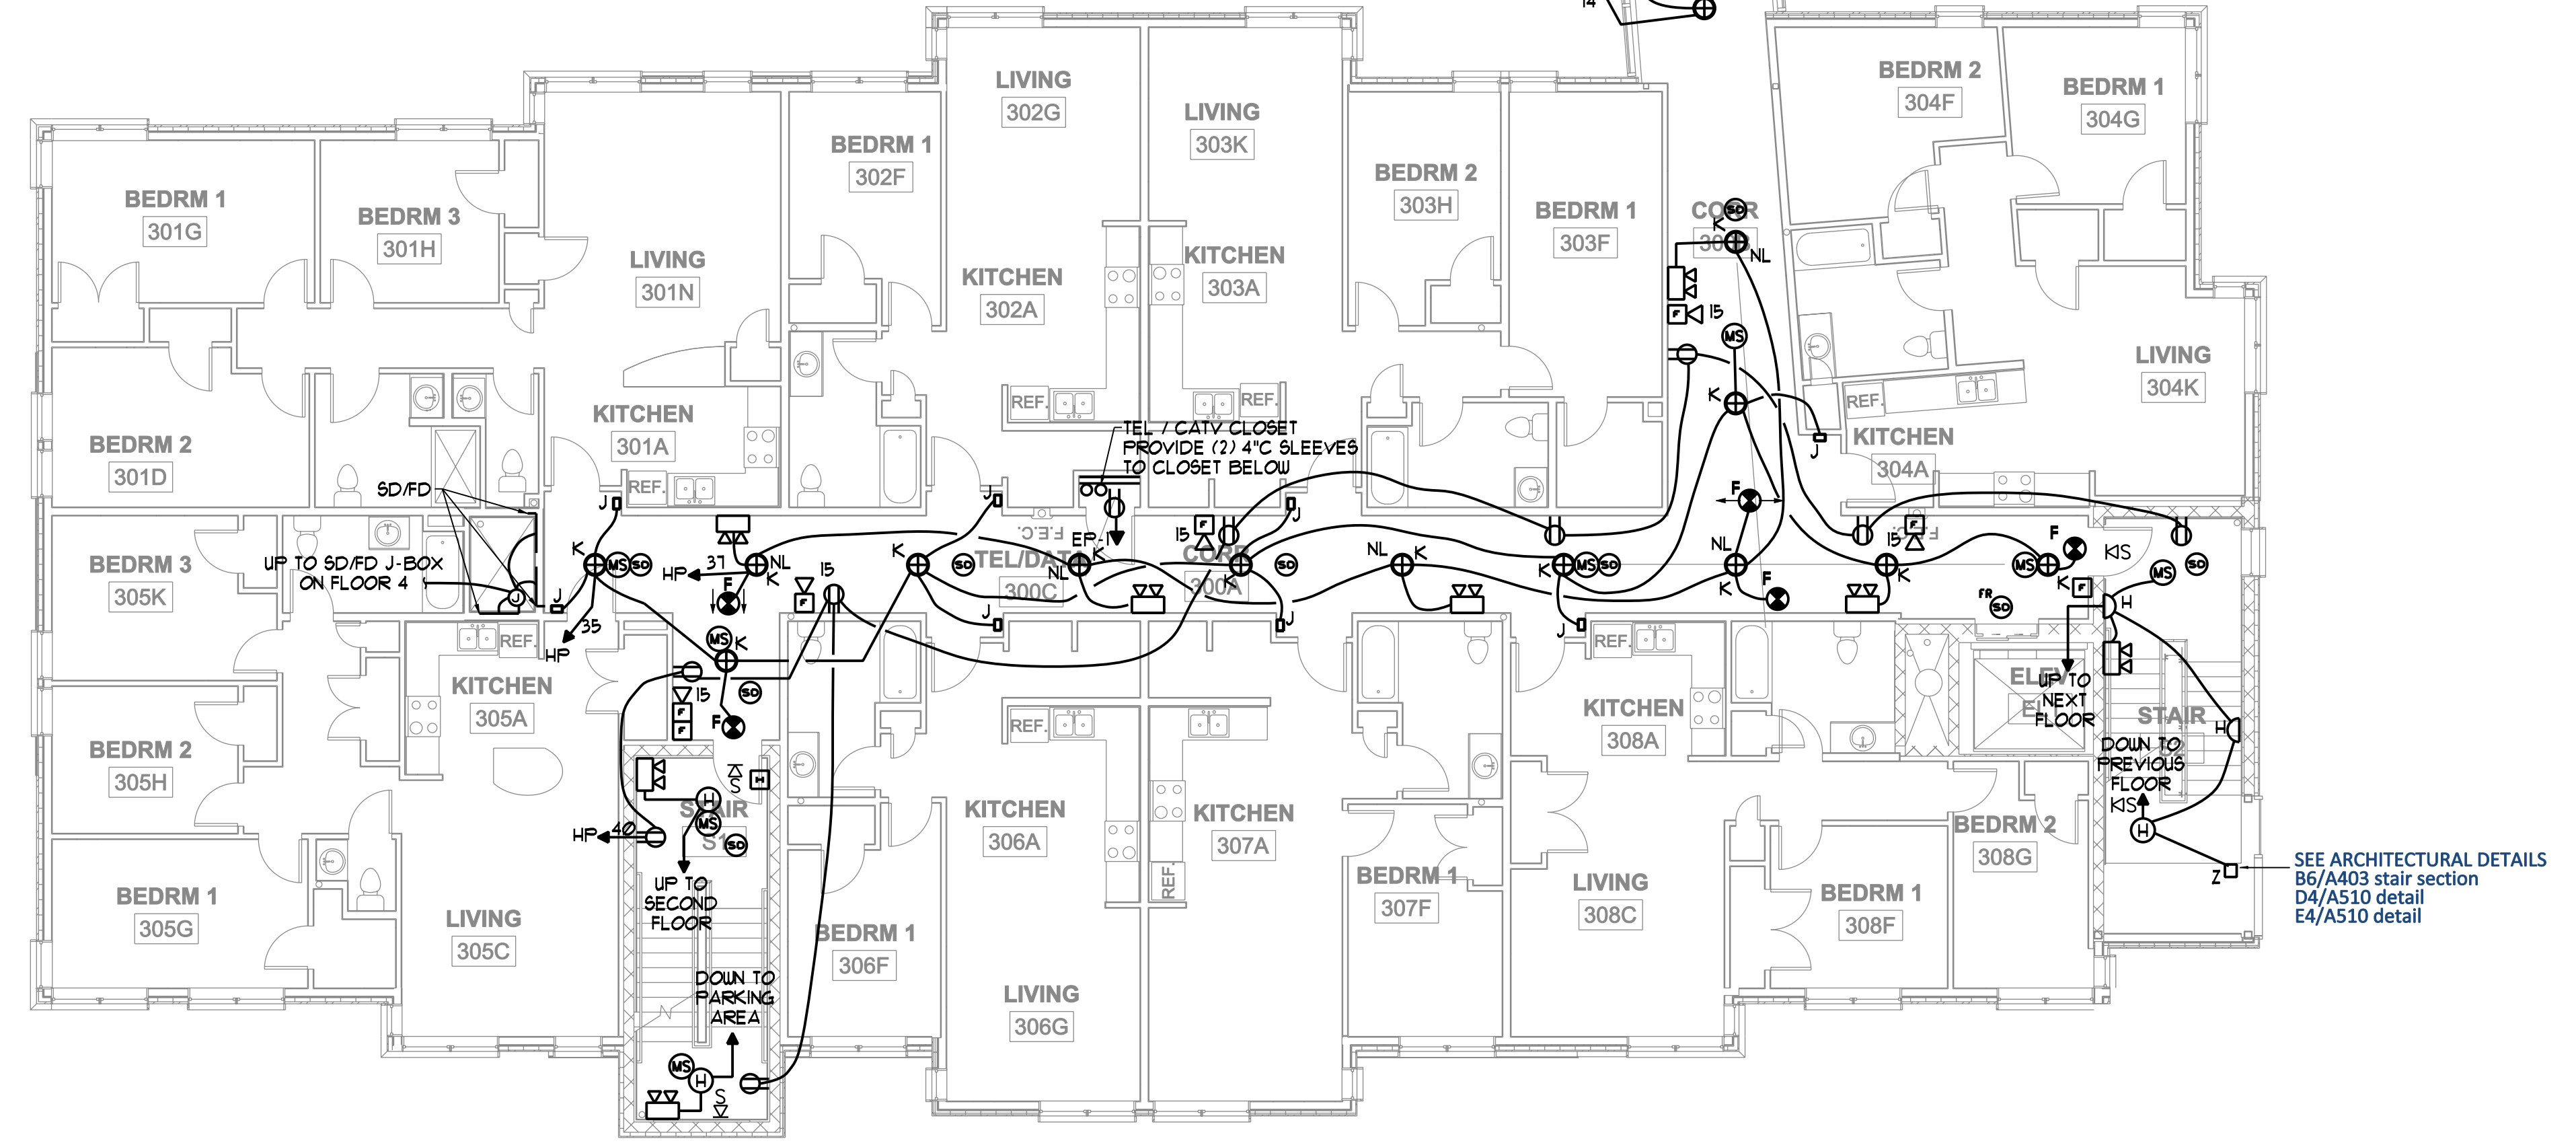

SEE ARCHITECTURAL DETAILS
B1/A403 stair section
D4/A510 detail
E4/A510 detail

