



NOTE:
 ① APARTMENT SINGLE STATION DETECTORS WIRE TO LOCAL 120 VAC. WIRE SINGLE STATION (SS) SMOKE DETECTORS TOGETHER IN TANDEM WITHIN EACH APARTMENT.
 ② APARTMENT SINGLE STATION CO DETECTORS WIRE TO LOCAL 120VAC SOURCE. WIRE SINGLE STATION (SS) CO DETECTORS TOGETHER IN TANDEM WITHIN EACH APARTMENT.

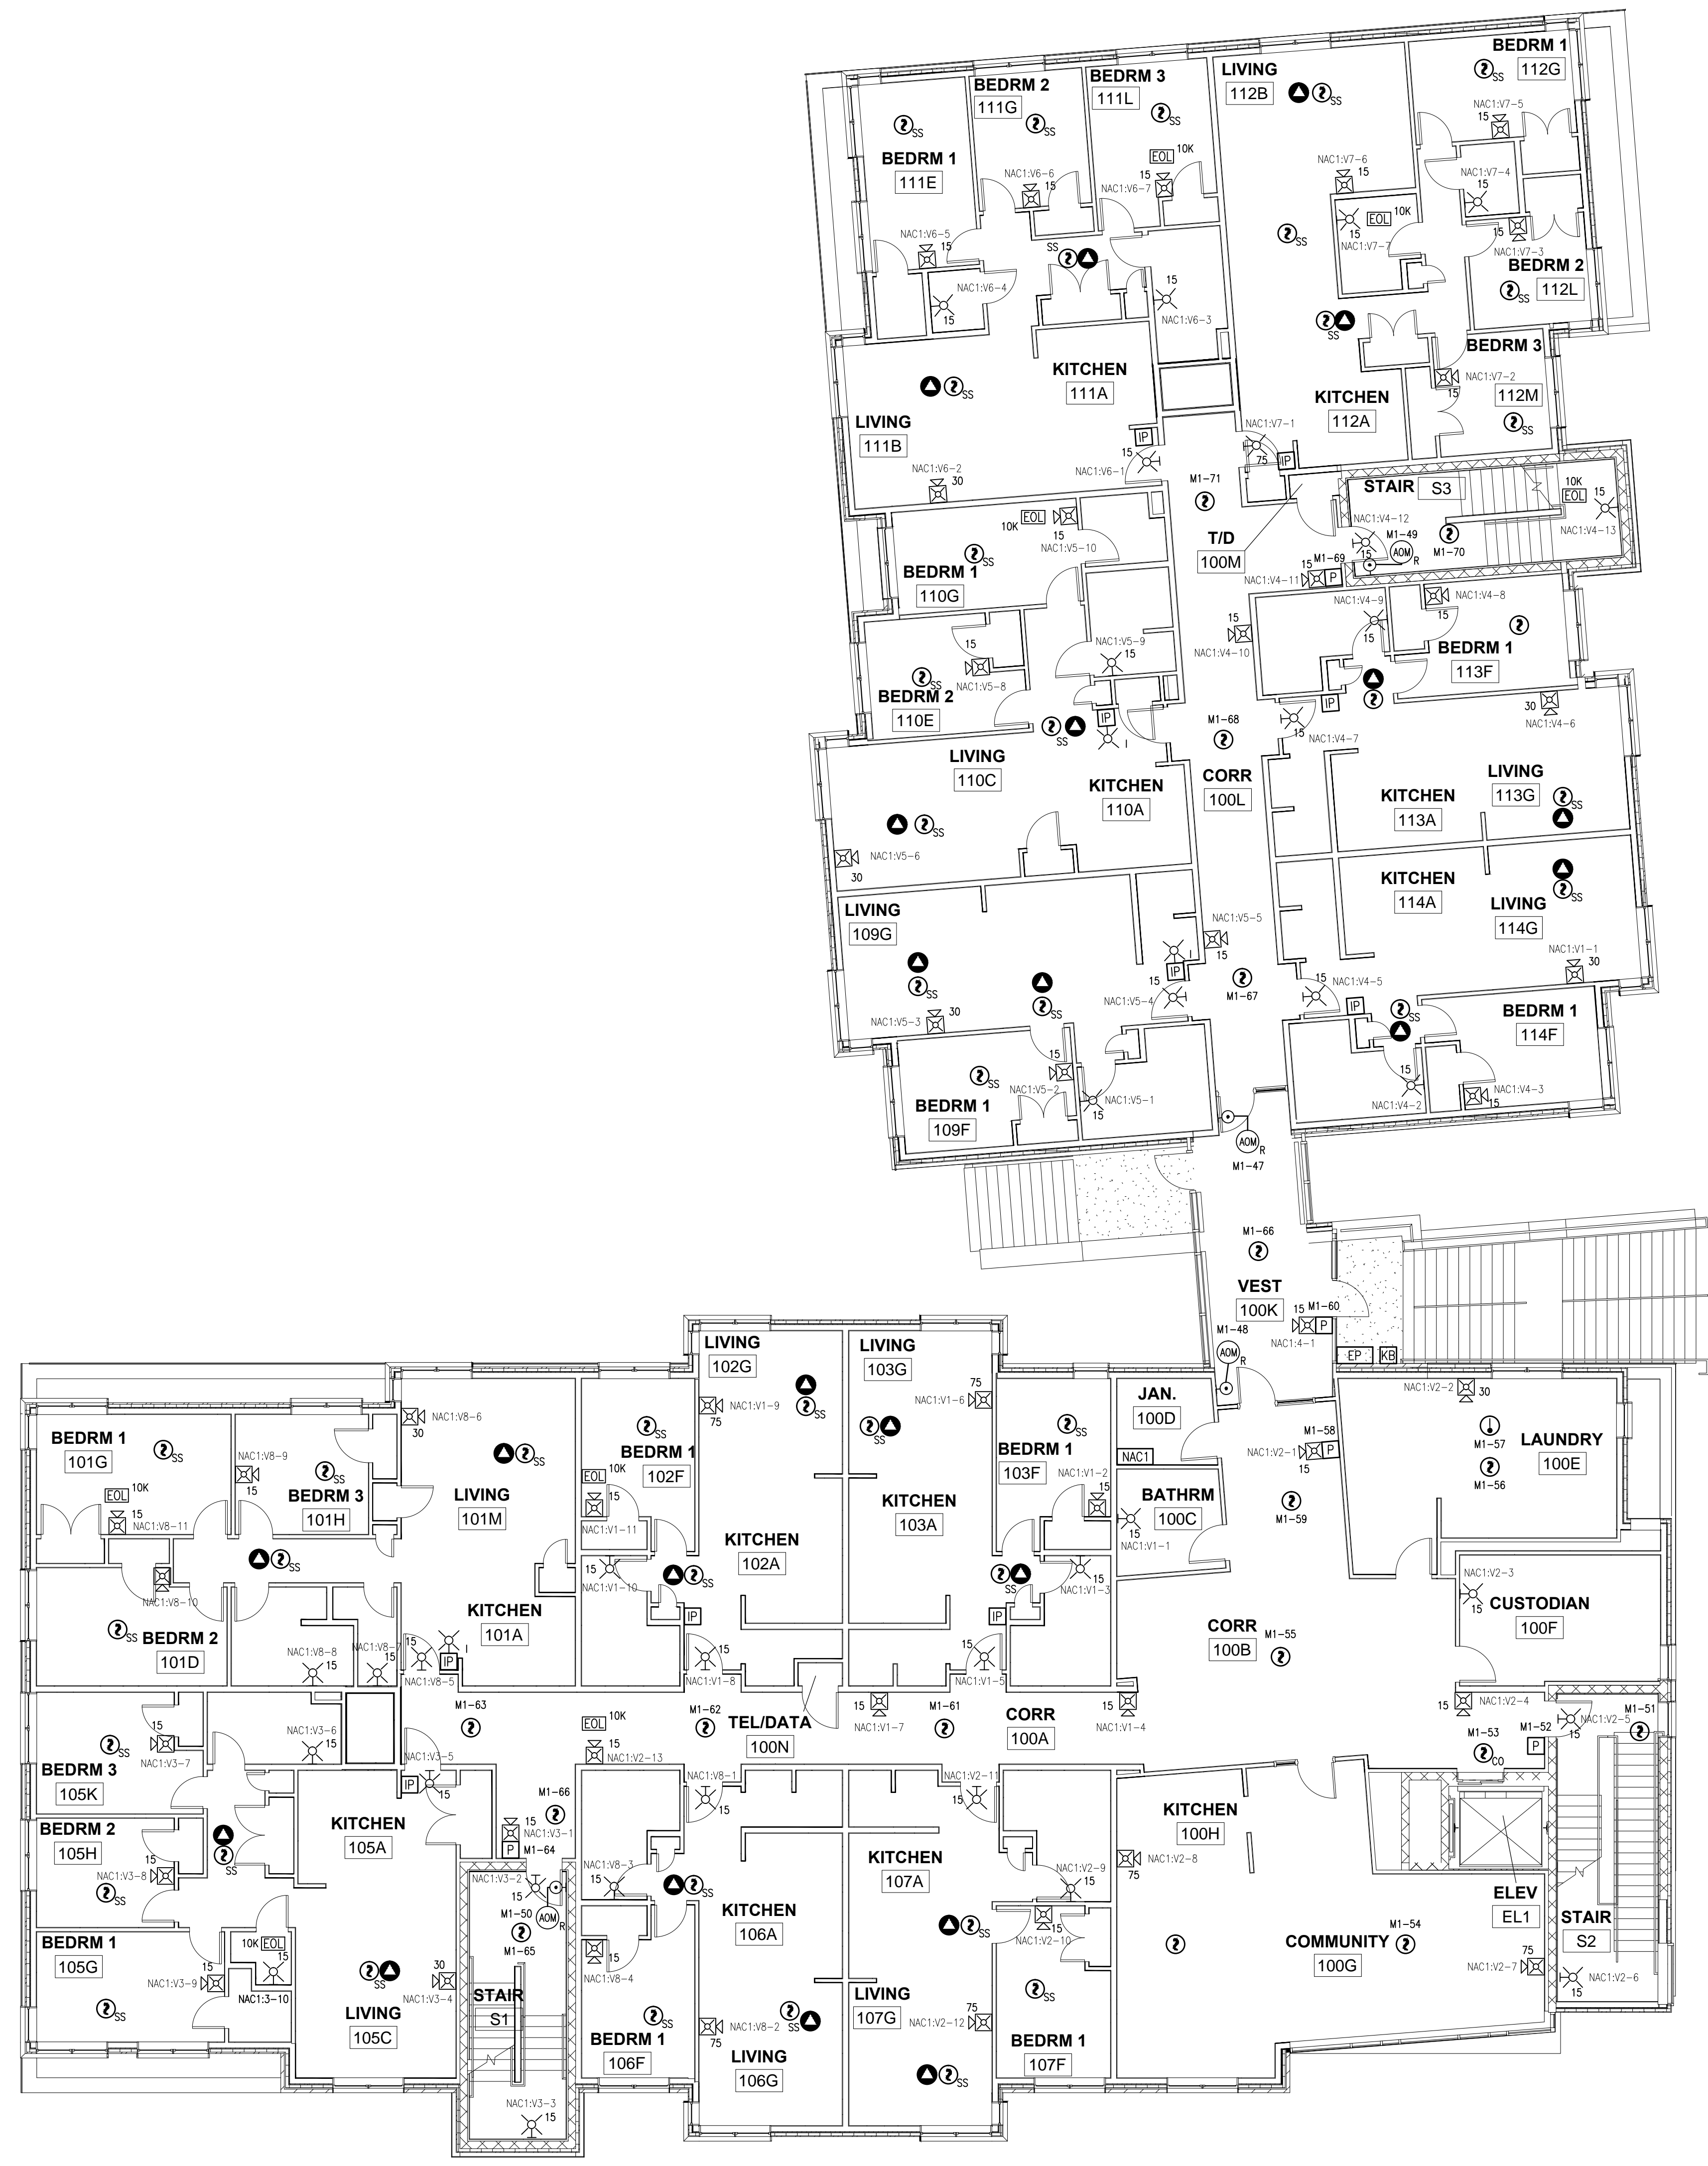

FIRST FLOOR PLAN

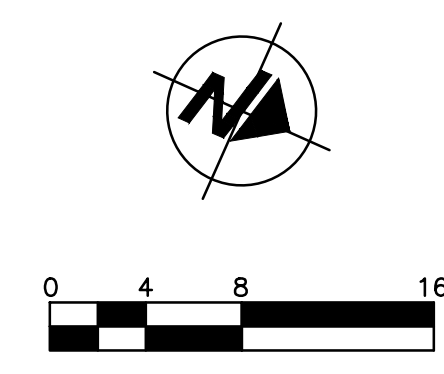

SimplexGrinnell BE SAFE. A Tyco International Company	
20 THOMAS DRIVE WESTBROOK, ME 04092 SALES: 207-842-6440 SERVICE: 207-842-6440 FAX: 207-842-6439	
NO.	DATE
REVISION DESCRIPTION	BY
FIRE ALARM & APARTMENT INTERCOM SYSTEM FIRST FLOOR PLAN PEARL PLACE II 184 PEARL STREET PORTLAND, MAINE	
DRAWN BY: J. STEPHENS	DATE: 1/13/11
CHECKED BY: KALAFARSKI	DATE: 1/24/12
PROJECT NUMBER: 147419994	
SHEET TITLE: FIRE ALARM/INTER SYSTEM FIRST FLOOR PLAN	
SHEET NUMBER: FA-102	