

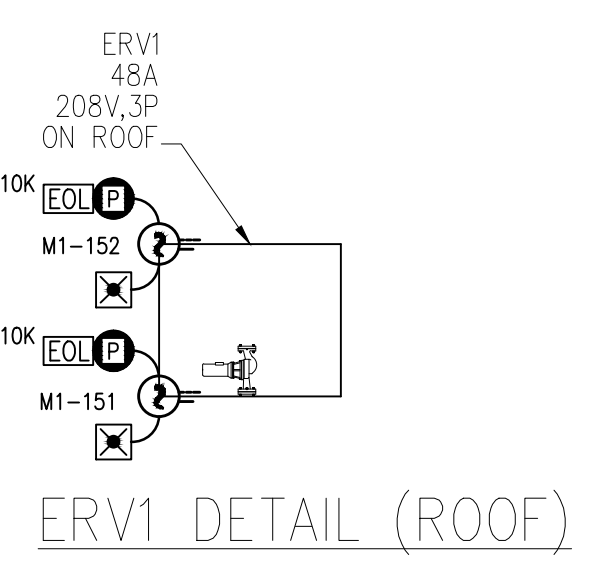
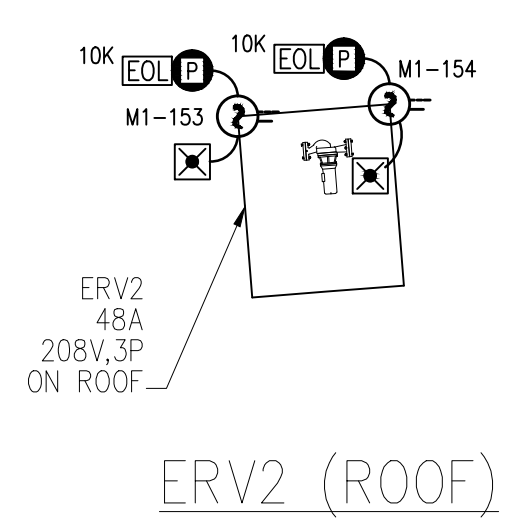


LAST PRINTED: 1/24/2012 11:58:55 AM LAST SAVED BY: JSTEPHENS FILE PATH: P:\2011\147\Perit Place \Ccd\FA-105.dwg

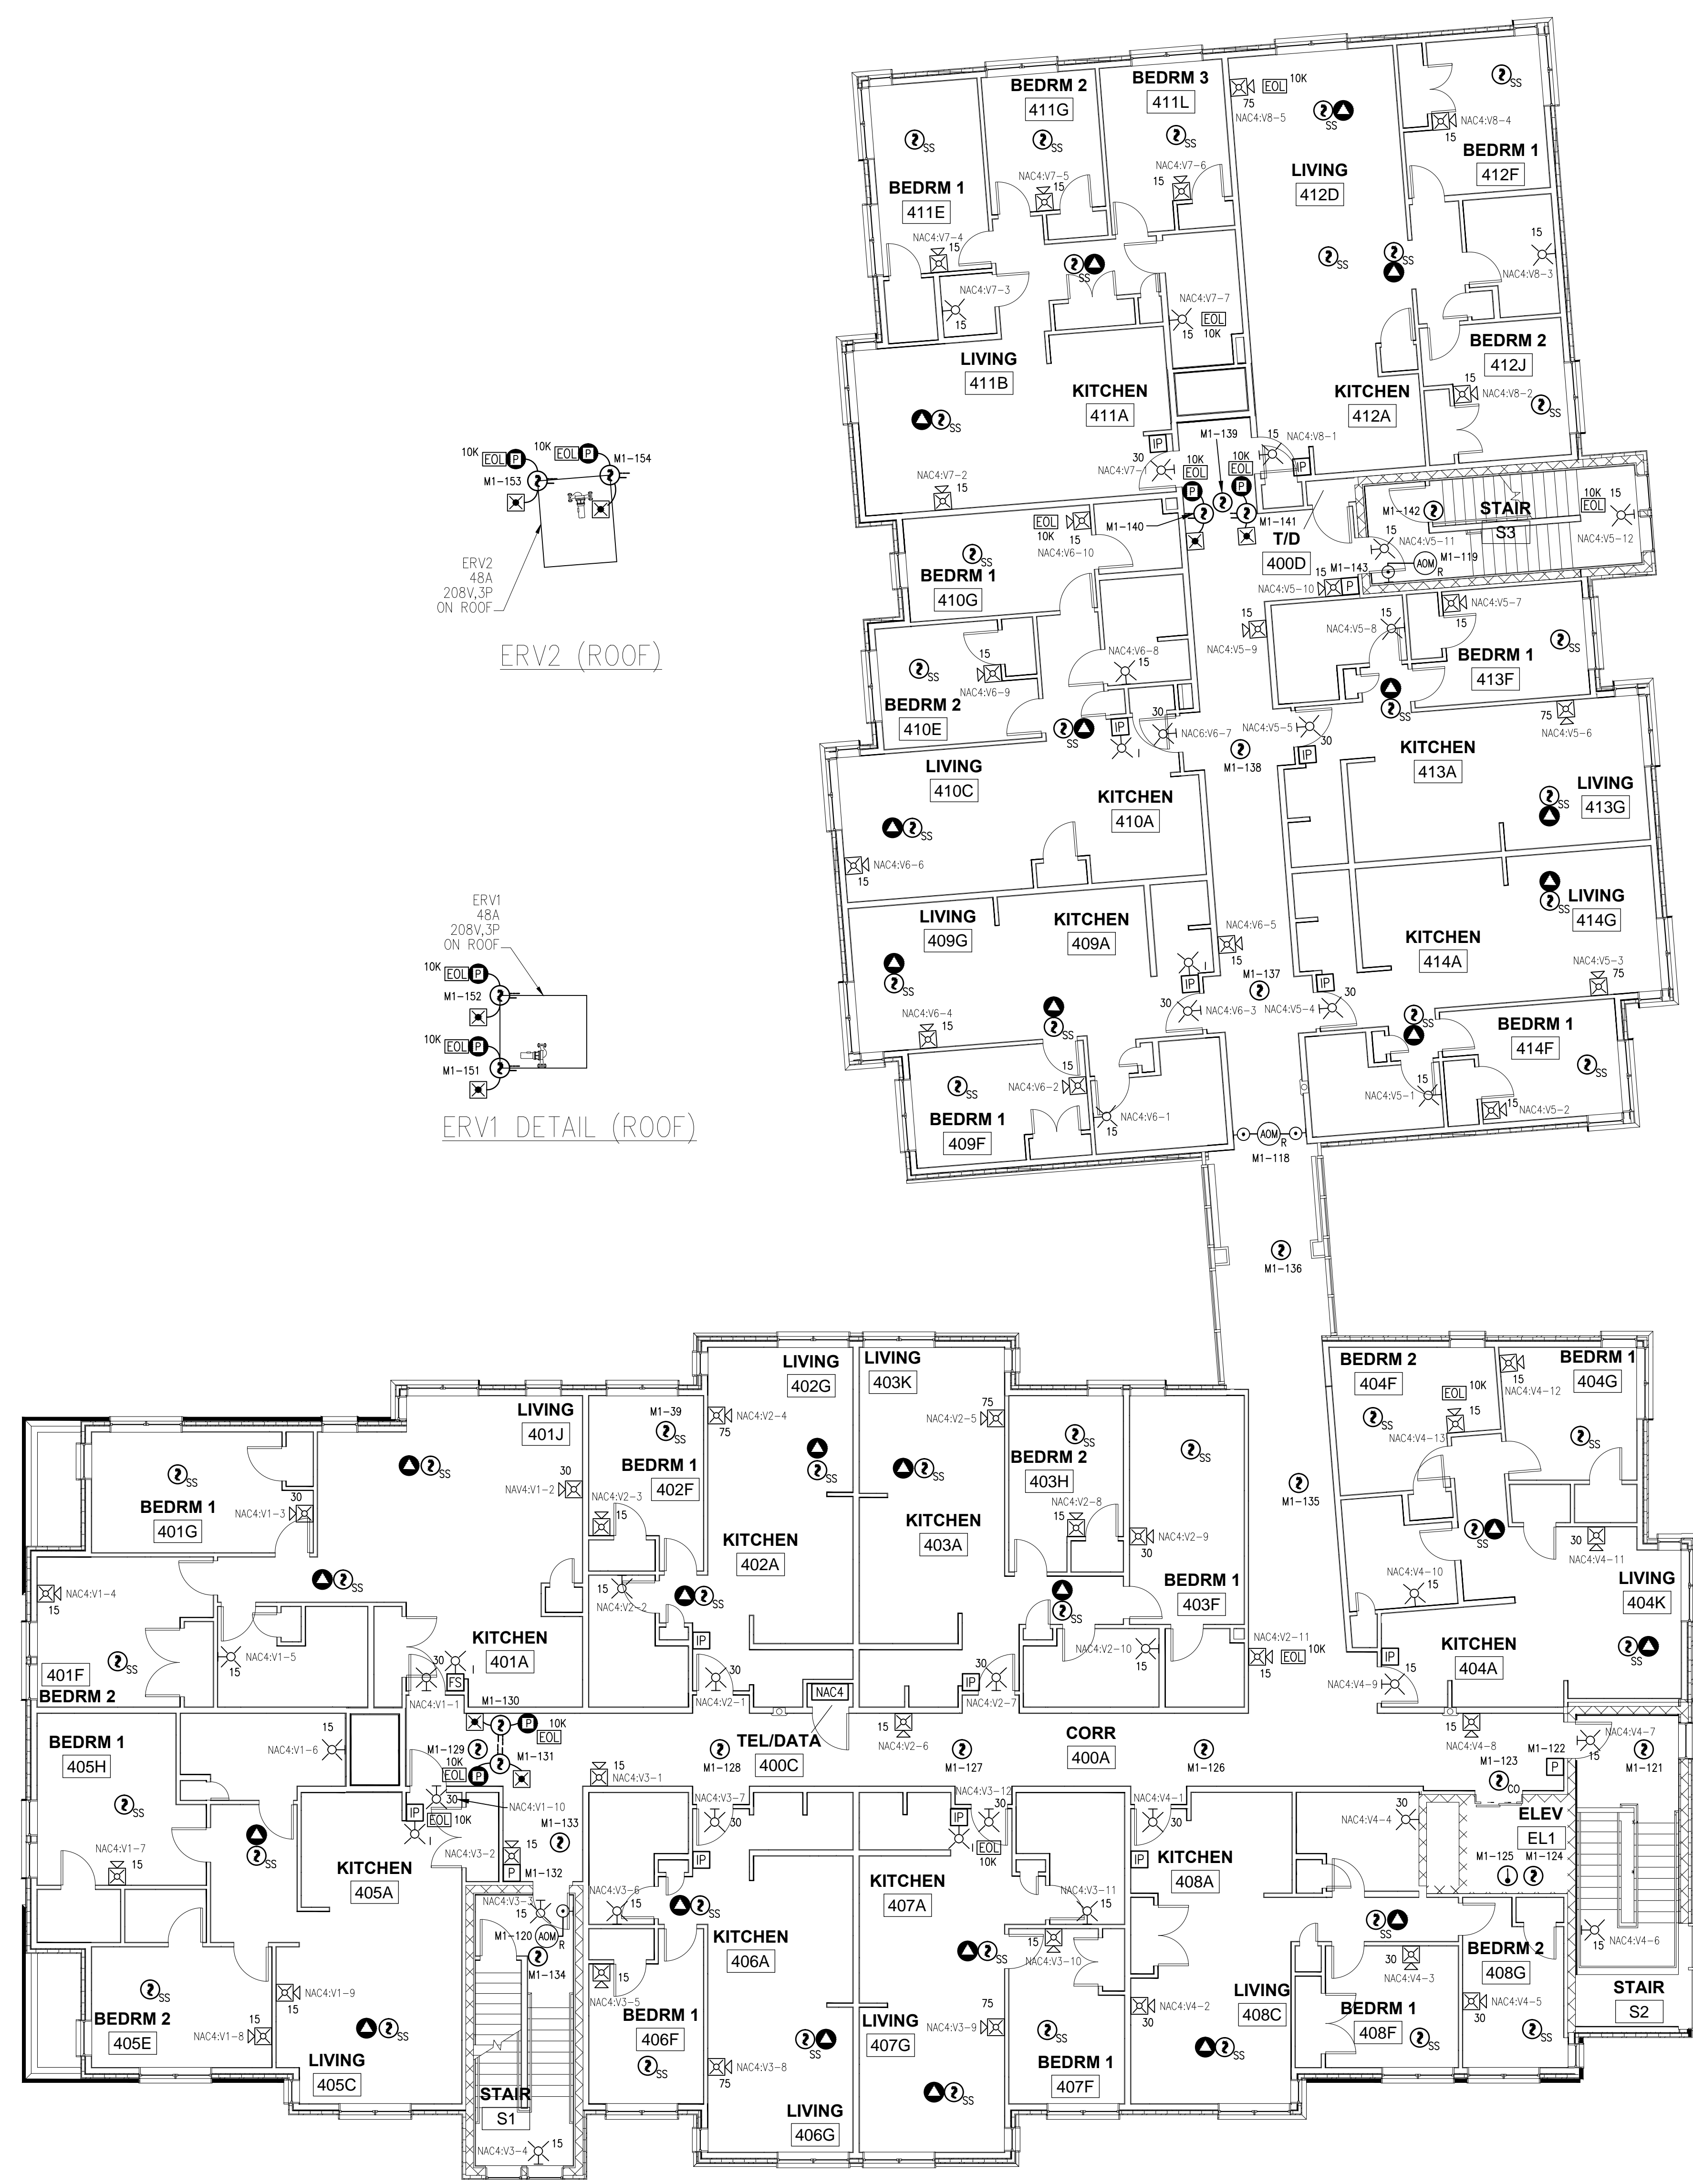

FOURTH FLOOR PLAN

NOTE:
 ① APARTMENT SINGLE STATION DETECTORS WIRE TO LOCAL 120 VAC. WIRE SINGLE STATION (SS) SMOKE DETECTORS TOGETHER IN TANDEM WITHIN EACH APARTMENT.
 ② APARTMENT SINGLE STATION CO DETECTORS WIRE TO LOCAL 120VAC SOURCE. WIRE SINGLE STATION (SS) CO DETECTORS TOGETHER IN TANDEM WITHIN EACH APARTMENT.

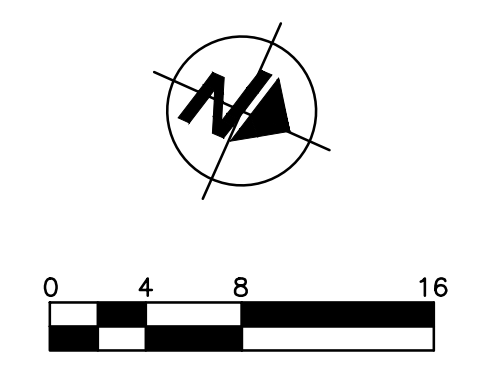

<p>SimplexGrinnell BE SAFE. A Tyco International Company</p> <p>20 THOMAS DRIVE WESTBROOK, ME 04092 SALES: 207-842-6440 SERVICE: 207-842-6440 FAX: 207-842-6439</p>		
NO.	DATE	REVISION DESCRIPTION
FIRE ALARM & APARTMENT INTERCOM SYSTEM FOURTH FLOOR PLAN PEARL PLACE II 184 PEARL STREET PORTLAND, MAINE		
DRAWN BY:	DATE:	
J. STEPHENS	1/13/11	
CHECKED BY:	DATE:	
KALAFARSKI	1/24/12	
PROJECT NUMBER:	147419994	
SHEET TITLE:	FIRE ALARM/INTER SYSTEM FOURTH FLOOR PLAN	
SHEET NUMBER:	FA-105	