




FIRE ALARM PLAN – BASEMENT PLAN
SCALE: 1/8"=1'-0"

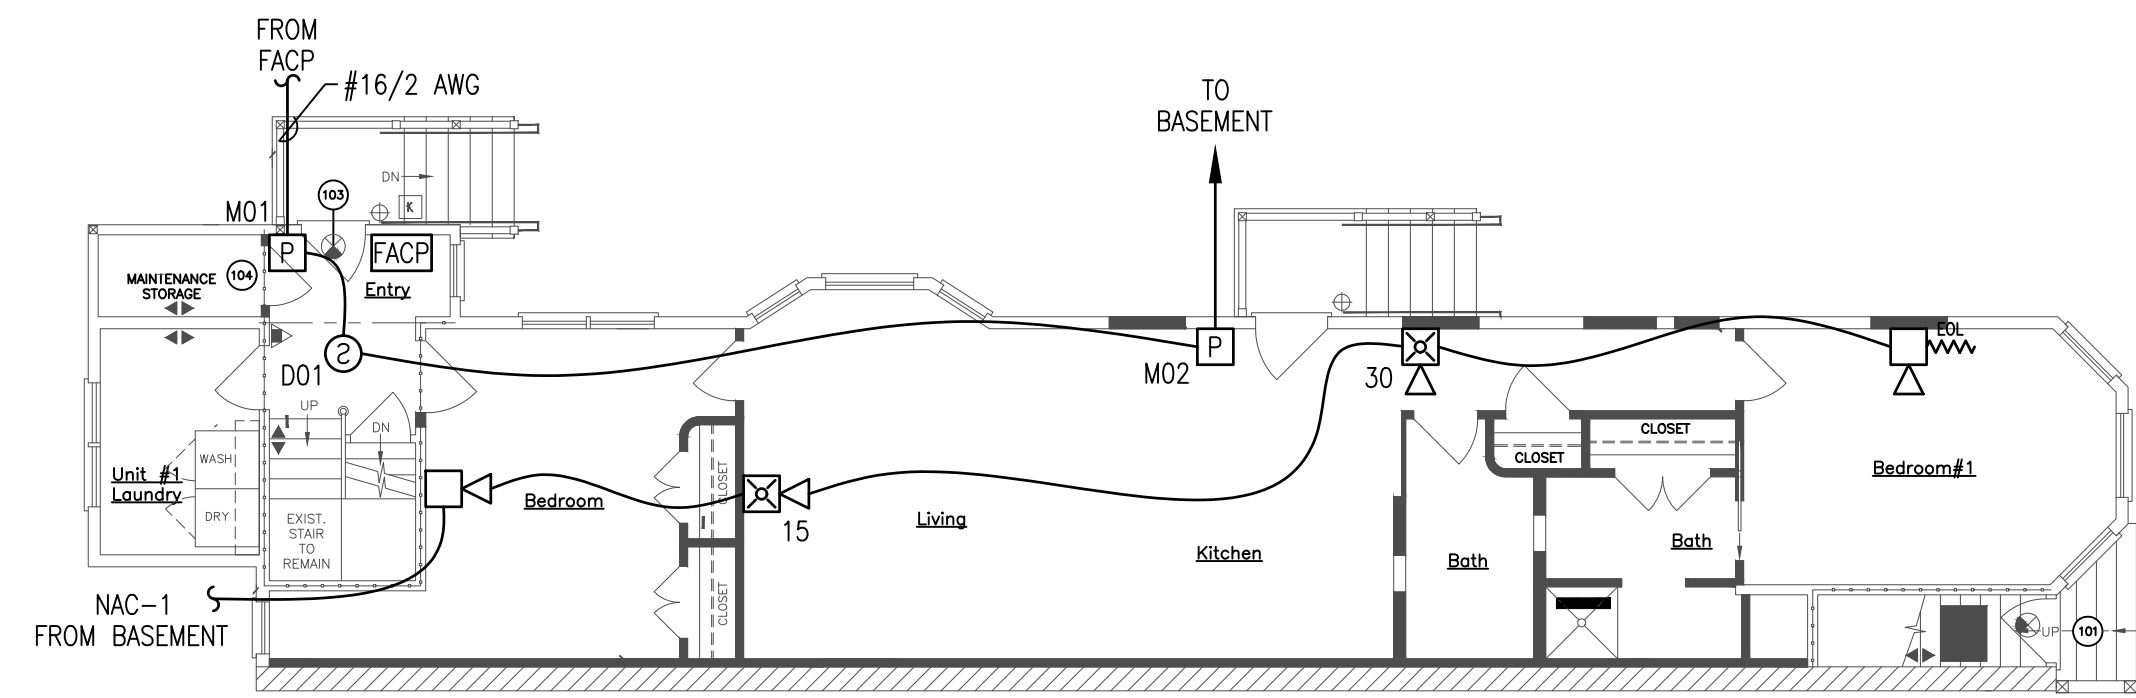

FIRE ALARM PLAN – FIRST FLOOR – UNIT 1
SCALE: 1/8"=1'-0"

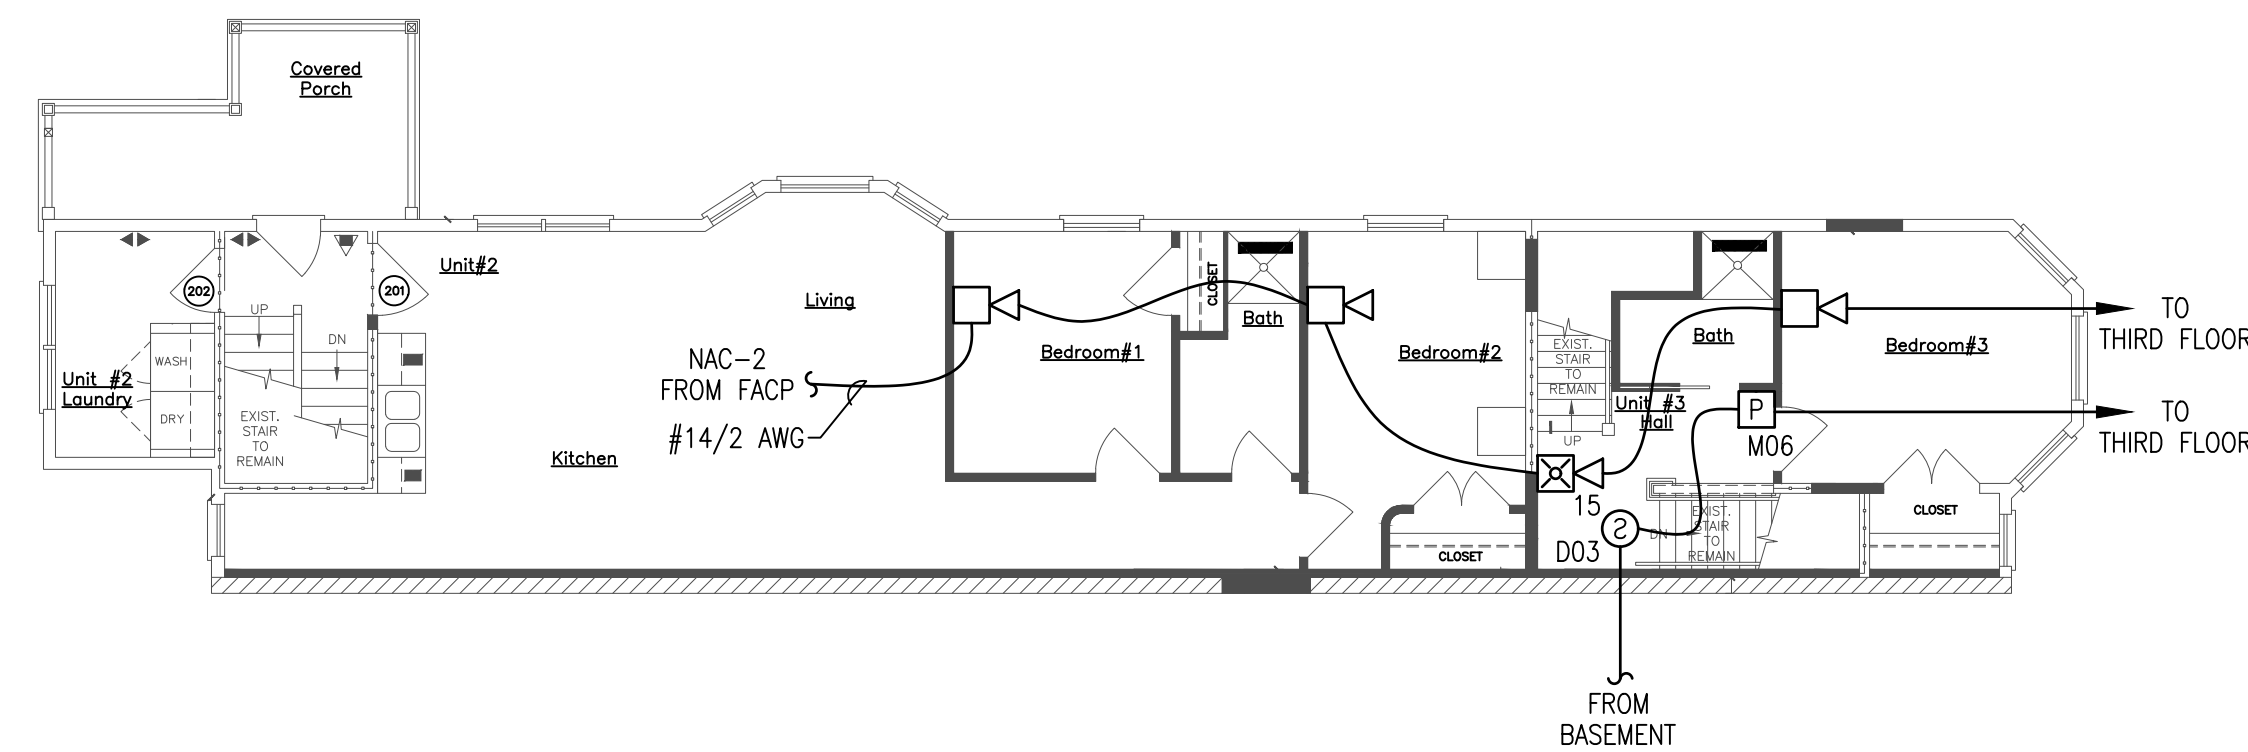

FIRE ALARM PLAN – SECOND FLOOR – UNIT 2 & 3
SCALE: 1/8"=1'-0"

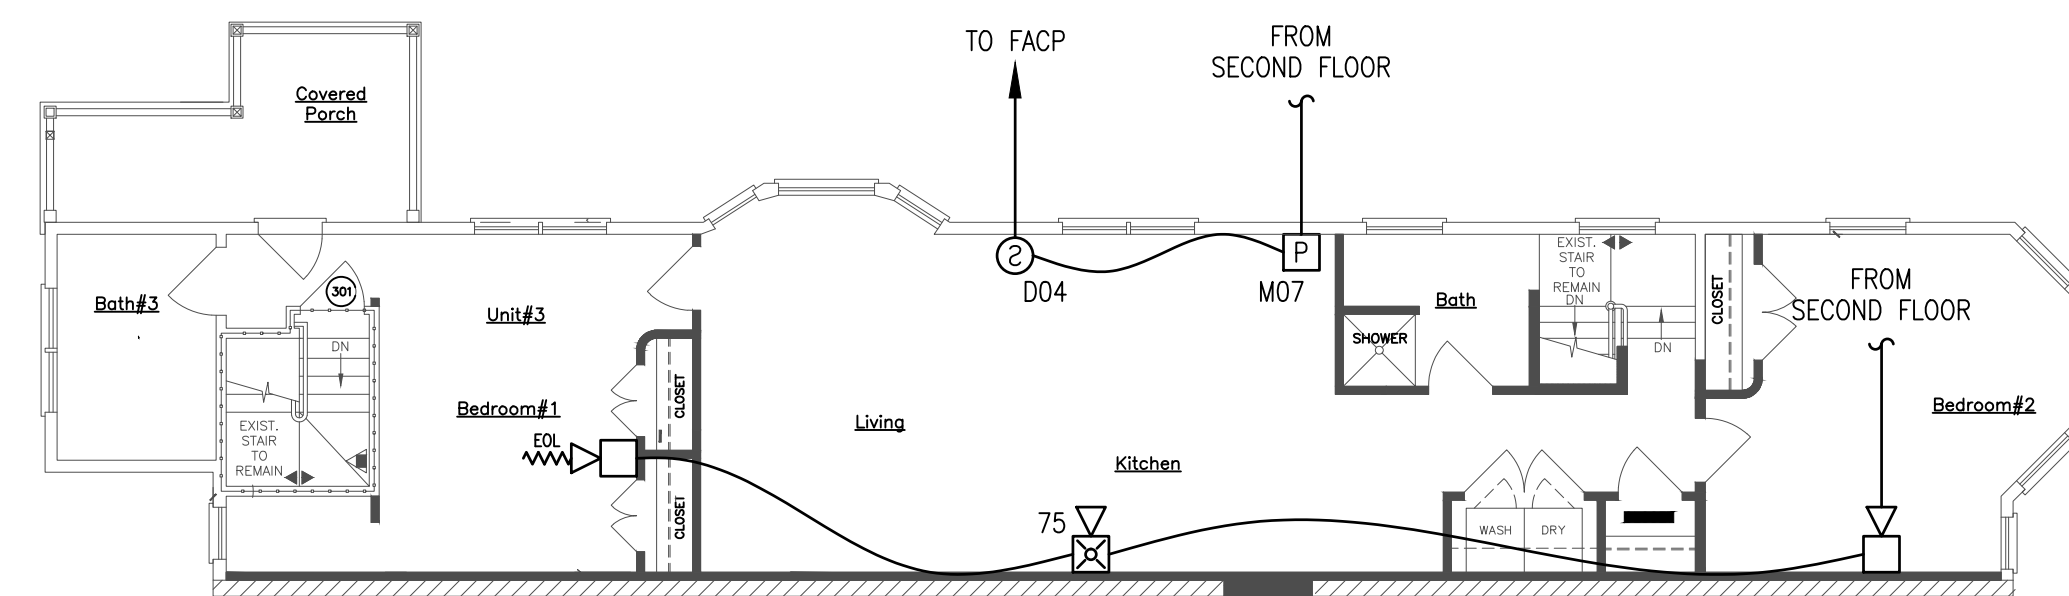

FIRE ALARM PLAN – THIRD FLOOR – UNIT 3
SCALE: 1/8"=1'-0"

REVISION	DESCRIPTION	DATE
0	ISSUED FOR REVIEW & APPROVAL	7/18/2016

SEACOAST SECURITY

4 Summer Street • Freeport, Maine 04032
Office: (207) 706-3369 • Fax: (207) 865-0852

**50 WILMOT STREET, L.L.C.
477 CONGRESS STREET
PORTLAND, MAINE
FIRE ALARM PLAN**

DRAWN	CLI UNICAD JOB #16496
CHECKED	BRADY B. HAWIS NICET III 138751
DATE	7/15/2016
REVISION	0
SCALE	1/8"=1'-0"

Shop drawings created by:
5794 W. 4600 St.
Hosier, UT 84315
Office: 801.965.0410

www.unicad.net

