



GENERAL NOTES:


- SCOPE OF WORK: THIS PROJECT SHALL INCLUDE INSTALLATION OF ADDRESSABLE PANEL WITH WIRELESS RADIO, A REMOTE ANNUNCIATOR AS INDICATED, SMOKE DETECTORS AS INDICATED, MINI MONITOR MODULES TO MONITOR DEVICES AS INDICATED, NOTIFICATION DEVICES AS INDICATED.
- THESE DRAWINGS ARE DIAGRAMMATIC. REFER TO THE ARCHITECTURAL DRAWINGS FOR EXACT DIMENSIONS.
- INSTALLATION SHALL COMPLY WITH NEC, NFPA 72 AND ALL OTHER APPLICABLE CODES AS REQUIRED BY THE LOCAL AUTHORITY HAVING JURISDICTION.
- WIRING DEPICTED ON THESE PLANS IS SCHEMATIC - ACTUAL WIRE LOCATIONS MAY DIFFER FROM THESE PLANS. WIRING SHALL BE PERFORMED AS ACTUAL BUILDING CONSTRUCTION CONDITIONS ALLOW AND TO MINIMIZE PENETRATIONS THROUGH AREA SEPARATION WALLS AND FIRE WALLS. THE USE OF A RACEWAY IS PERMITTED AS LONG AS NO 110V OR HIGHER VOLTAGE CABLES ARE IN THE SAME RACEWAY.
- FIRE RATINGS SHALL BE MAINTAINED FOR ALL PENETRATIONS THROUGH FIRE-RATED CONSTRUCTION.
- POWER FOR ALL FIRE ALARM PANELS AND FIRE ALARM POWER SUPPLIES MUST BE PROVIDED BY A DEDICATED AC BRANCH CIRCUIT. THE LOCATION OF THE BRANCH CIRCUIT BREAKER SHALL BE PERMANENTLY IDENTIFIED AT THE CONTROL UNIT AND SHALL HAVE A RED MARKING IN ACCORDANCE WITH NFPA 72.
- POWER-LIMITED AND NONPOWER-LIMITED CIRCUIT WIRING MUST REMAIN SEPARATED IN CABINET. ALL POWER-LIMITED CIRCUIT WIRING MUST REMAIN AT LEAST 0.25" AWAY FROM ANY NONPOWER-LIMITED CIRCUIT WIRING. FURTHERMORE, ALL POWER-LIMITED AND NONPOWER-LIMITED CIRCUIT WIRING MUST ENTER AND EXIT THE CABINET THROUGH DIFFERENT KNOCK OUTS AND/OR SEPARATE CONDUITS.
- WHEN UTILIZING CLASS "A" CIRCUITS, SEPARATE OUTGOING AND RETURN CONDUCTORS OF CLASS "A" CIRCUITS BY A MINIMUM OF 12" WHERE RUN VERTICALLY AND 48" WHERE RUN HORIZONTALLY.
- WHEN UTILIZING SHIELDED CABLE, TIE SHIELDS THROUGH AND INSULATE AT EACH JUNCTION BOX. INSULATE AND TAPE BACK AT END.
- ALL FIRE ALARM CABLING SHALL BE ACCEPTABLE TO THE FIRE ALARM EQUIPMENT MANUFACTURER FOR THE INTENDED PURPOSE.
- SMOKE DETECTORS SHALL NOT BE INSTALLED UNTIL AFTER CONSTRUCTION CLEAN-UP IS COMPLETED AND FINAL.
- LOCATE SMOKE DETECTORS A MINIMUM OF THREE (3) FEET FROM MECHANICAL DIFFUSERS. WALL-MOUNTED SMOKE DETECTORS SHALL BE LOCATED A MINIMUM OF 4" AND A MAXIMUM OF 12" FROM CEILING.
- PROVIDE SYNCHRONIZATION OF ALL VISUAL NOTIFICATION APPLIANCE CIRCUITS. PROVIDE ALL REQUIRED SYNC MODULES. PROVIDE A MULTI-SYNC MODE SLAVE CONNECTION BETWEEN ALL SYNC MODULES.
- VERIFY ALL FIELD SELECTABLE AUDIBILITY SETTINGS OF NOTIFICATION APPLIANCES WITH FIRE ALARM CONTRACTOR.
- UPON COMPLETION OF THE FIRE ALARM SYSTEM INSTALLATION AND PROGRAMMING, THE INSTALLING CONTRACTOR SHALL PERFORM FINAL TESTING OF THE ENTIRE SYSTEM, PER ALL APPLICABLE CODES, AND SHALL COORDINATE AND PERFORM A FINAL FIRE ALARM SYSTEM INSPECTION.
- PROVIDE OFF-SITE MONITORING AS REQUIRED BY THE INTERNATIONAL FIRE CODE, SECTION 907.6.5 AND THE LOCAL AUTHORITY HAVING JURISDICTION.
- INSTALLING CONTRACTOR SHALL, PHYSICALLY, LABEL ALL INITIATING DEVICES AND NOTIFICATION APPLIANCE CIRCUIT END OF LINE (WHEN WIRING CLASS "B"). THESE LABELS SHALL BE IN PLACE PRIOR TO START-UP AND TESTING.

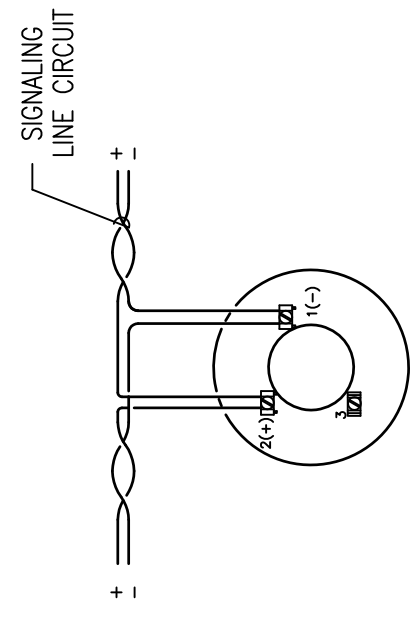


ADDRESSABLE SMOKE DETECTOR WIRING DETAIL
SCHEMATIC: NO SCALE

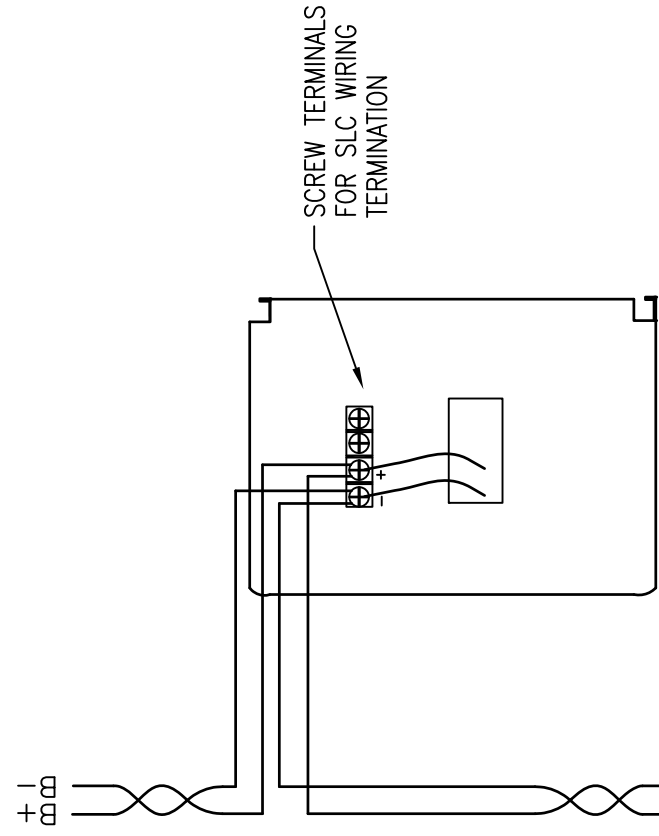


MANUAL PULL STATION WIRING DETAIL
SCHEMATIC: NO SCALE

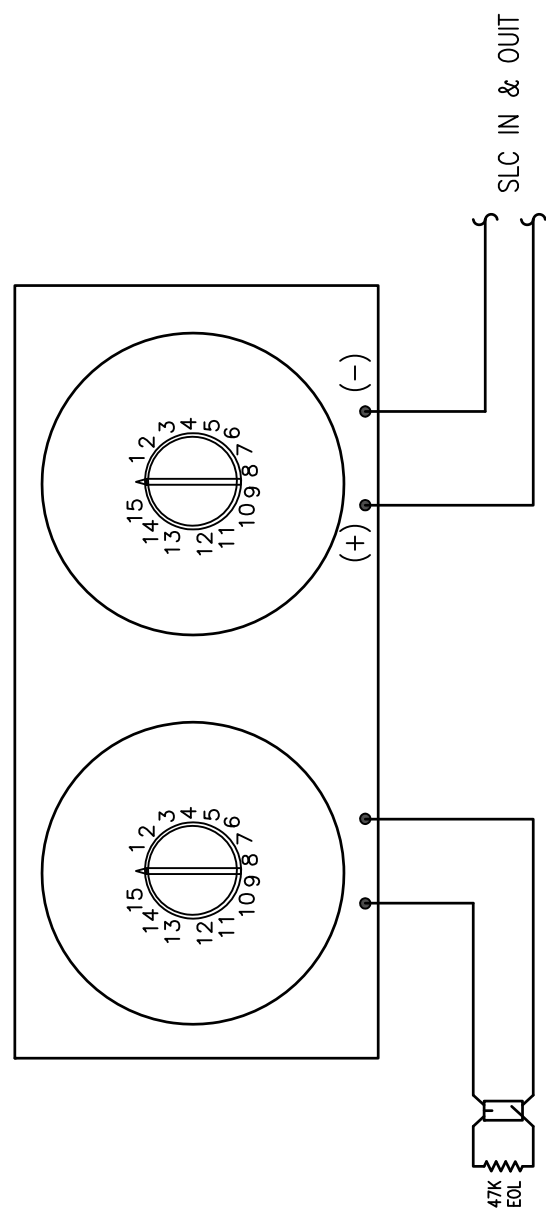

MINI MONITOR MODULE WIRING DETAIL
SCHEMATIC: NO SCALE

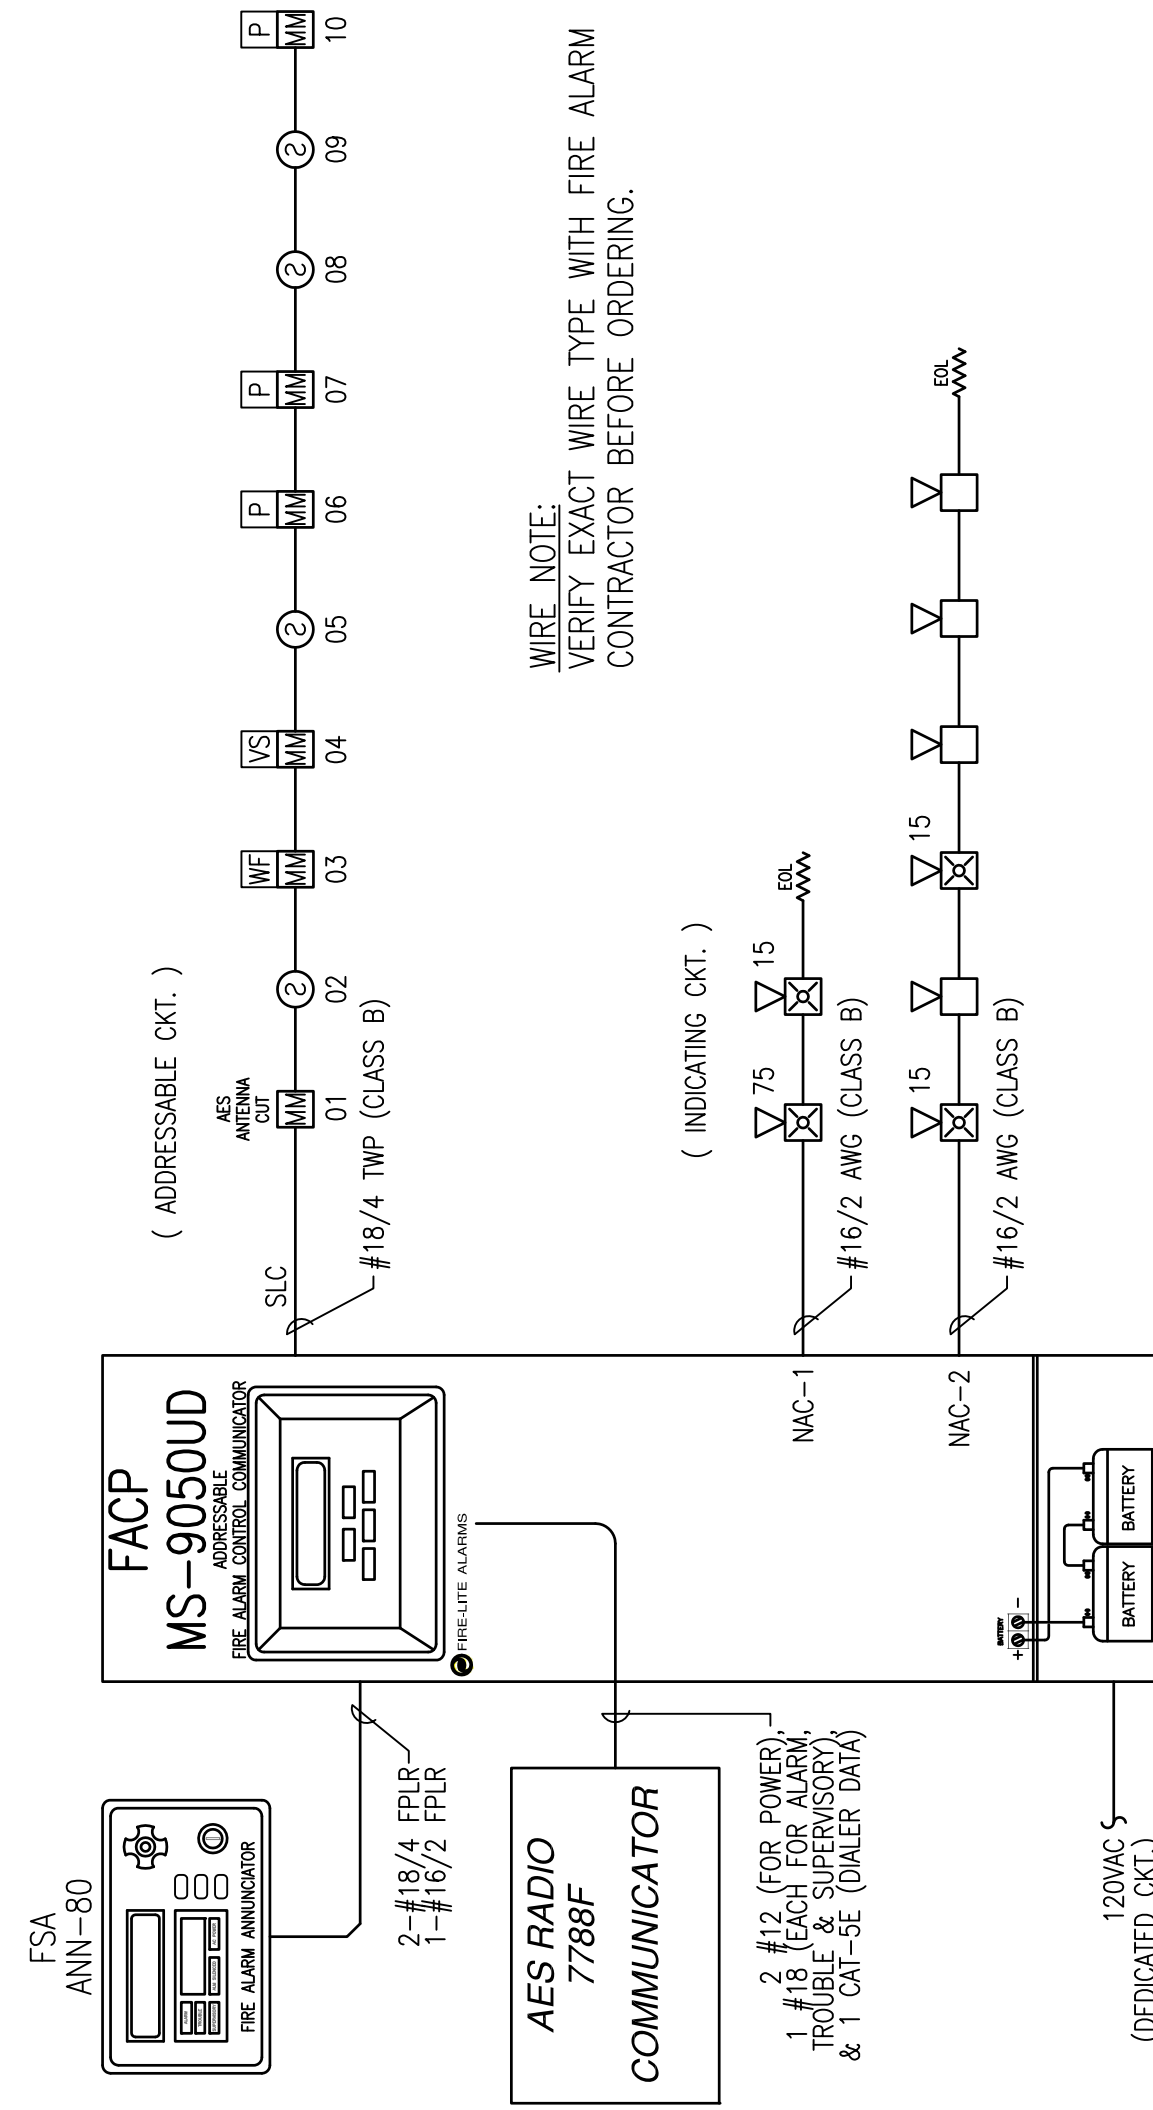

FIRE ALARM RISER DIAGRAM
SCHEMATIC: NO SCALE

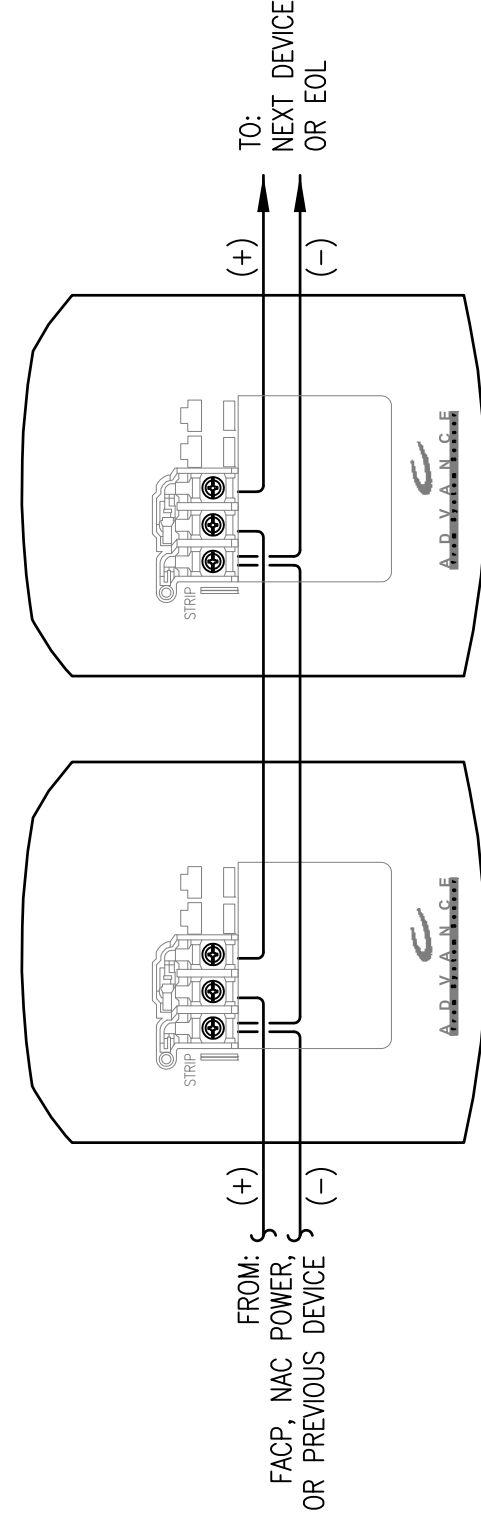

TYPICAL 2 WIRE STROBE WIRING DETAIL
SCHEMATIC: NO SCALE

FIRE ALARM SYMBOL LEGEND
NOTE: ALL SYMBOLS MAY NOT BE USED ON THIS PROJECT

SYMBOL	DESCRIPTION	MOUNTING
FACP	FIRE ALARM CONTROL PANEL	WALL-TOP @ 66"
FPS	FIRE ALARM POWER SUPPLY	FIELD VERIFY
FSA	FIRE SYSTEM ANNUNCIATOR	WALL-TOP @ 66"
FSD	FIRE/SMOKE DAMPER	BY OTHERS
⊙	SMOKE DETECTOR	CEILING
⊙-D	DUCT SMOKE DETECTOR	BY OTHERS
⊙	HEAT DETECTOR	CEILING
⊙M	ADDRESSABLE CONTROL MODULE	FIELD VERIFY
⊙M	ADDRESSABLE MINI MONITOR MODULE	FIELD VERIFY
P	MANUAL PULL STATION	WALL @ 48"
⊙R	CONTROL RELAY (MULTI-VOLTAGE)	FIELD VERIFY
⊙M	ADDRESSABLE RELAY MODULE	FIELD VERIFY
⊙	MAGNETIC DOOR HOLDER	FIELD VERIFY
⊙	WATER FLOW SWITCH	BY OTHERS
⊙S	VALVE SUPERVISORY SWITCH	BY OTHERS
⊙	BELL	FIELD VERIFY
⊙	CEILING MOUNT STROBE	FIELD VERIFY
⊙	CEILING MOUNT HORN / STROBE	FIELD VERIFY
⊙	CEILING MOUNT SPEAKER / STROBE	FIELD VERIFY
⊙	CEILING MOUNT SPEAKER	FIELD VERIFY
⊙	HORN	WALL @ 10'-0"
⊙	HORN / STROBE	WALL 80"-96"
⊙	SPEAKER / STROBE	WALL 80"-96"
⊙	SPEAKER	WALL @ 90"
⊙	STROBE	WALL 80"-96"
ABBREVIATION	DESCRIPTION	
E	EXISTING	
G	WITH GUARD	
P	PENDENT MOUNT	
R	RESIDENTIAL (110V)	
S	SOUNDER BASE	
WP	WEATHER PROOF	
EOL	END OF LINE RESISTOR	
EOLR	END OF LINE RELAY	
AWG	AMERICAN WIRE GAUGE	
TWP	TWISTED PAIR	
TWSP	TWISTED SHIELDED PAIR	
FPLP	FIRE POWER LIMITED PLENUM	
FPLR	FIRE POWER LIMITED RISER	
NAC	NOTIFICATION APPLIANCE CIRCUIT	
SIC	SIGNALING LINE CIRCUIT	

APPLICABLE CODES:

MAINE UNIFORM ENERGY & BUILDING CODE
 PORTLAND CITY CODE, CHAPTER 10, FIRE PREVENTION & PROTECTION
 NFPA 1, FIRE CODE, & NFPA 101, LIFE SAFETY CODE

OPERATIONS MATRIX

	FIRE ALARM INPUT	SMOKE DETECTORS	PULL STATIONS	WATERFLOW SWITCHES	VALVE TAMPER SWITCHES	FIRE ALARM AC POWER FAIL	FIRE ALARM LOW BATTERY	OPEN CIRCUIT	GROUND FAULT	NAC SHORT CIRCUIT	LOSS OF AC TO BUILDING
ACTIVATE ALARM INDICATOR	●	●	●	●	●	●	●	●	●	●	●
ACTIVATE SUPERVISORY INDICATOR	●	●	●	●	●	●	●	●	●	●	●
ACTIVATE AUDIBLE SUPERVISORY SIGNAL	●	●	●	●	●	●	●	●	●	●	●
ACTIVATE TROUBLE INDICATOR	●	●	●	●	●	●	●	●	●	●	●
ACTIVATE AUDIBLE TROUBLE INDICATOR	●	●	●	●	●	●	●	●	●	●	●
TRANSMIT SUPERVISORY SIGNAL	●	●	●	●	●	●	●	●	●	●	●
TRANSMIT TROUBLE SIGNAL	●	●	●	●	●	●	●	●	●	●	●
ACTIVATE NOTIFICATION APPLIANCES	●	●	●	●	●	●	●	●	●	●	●

REVISION	DESCRIPTION	DATE
0	ISSUED FOR REVIEW & APPROVAL	8/15/2017

SEACOAST SECURITY
 4 Summer Street • Freeport, Maine 04032
 Office: (207) 706-3369 • Fax: (207) 865-0852

52 WILMOT STREET
PORTLAND, MAINE 04101
DETAILS, LEGEND, MATRIX, NOTES

DRAWN	JPB UNICAD JOB #17544
CHECKED	WAYNE B. HAWES NCET # 90496
DATE	8/15/2017
REVISION	0
SCALE	1/4"=1'-0"

UNICAD Inc.
 Fire Alarm Design & Drafting Services
 578 W. 400th St.
 Portland, ME 04106
 Phone: 801.865.6410
 www.unicad.net

FA-1