

REVISION	DESCRIPTION	DATE
0	ISSUED FOR REVIEW & APPROVAL	8/15/2017





SEACOAST SECURITY
 4 Summer Street • Freeport, Maine 04032
 Office: (207) 706-3369 • Fax: (207) 865-0852

52 WILMOT STREET
PORTLAND, MAINE 04101
FIRST FLOOR FIRE ALARM PLAN

DRAWN	JPB UNICAD JOB #17544
CHECKED	WAYNE B. HAWES NCET # 90496
DATE	8/15/2017
REVISION	0
SCALE	1/4"=1'-0"

FA-3

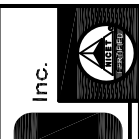
 www.unicad.net
 Fire Alarm Design & Drafting Services

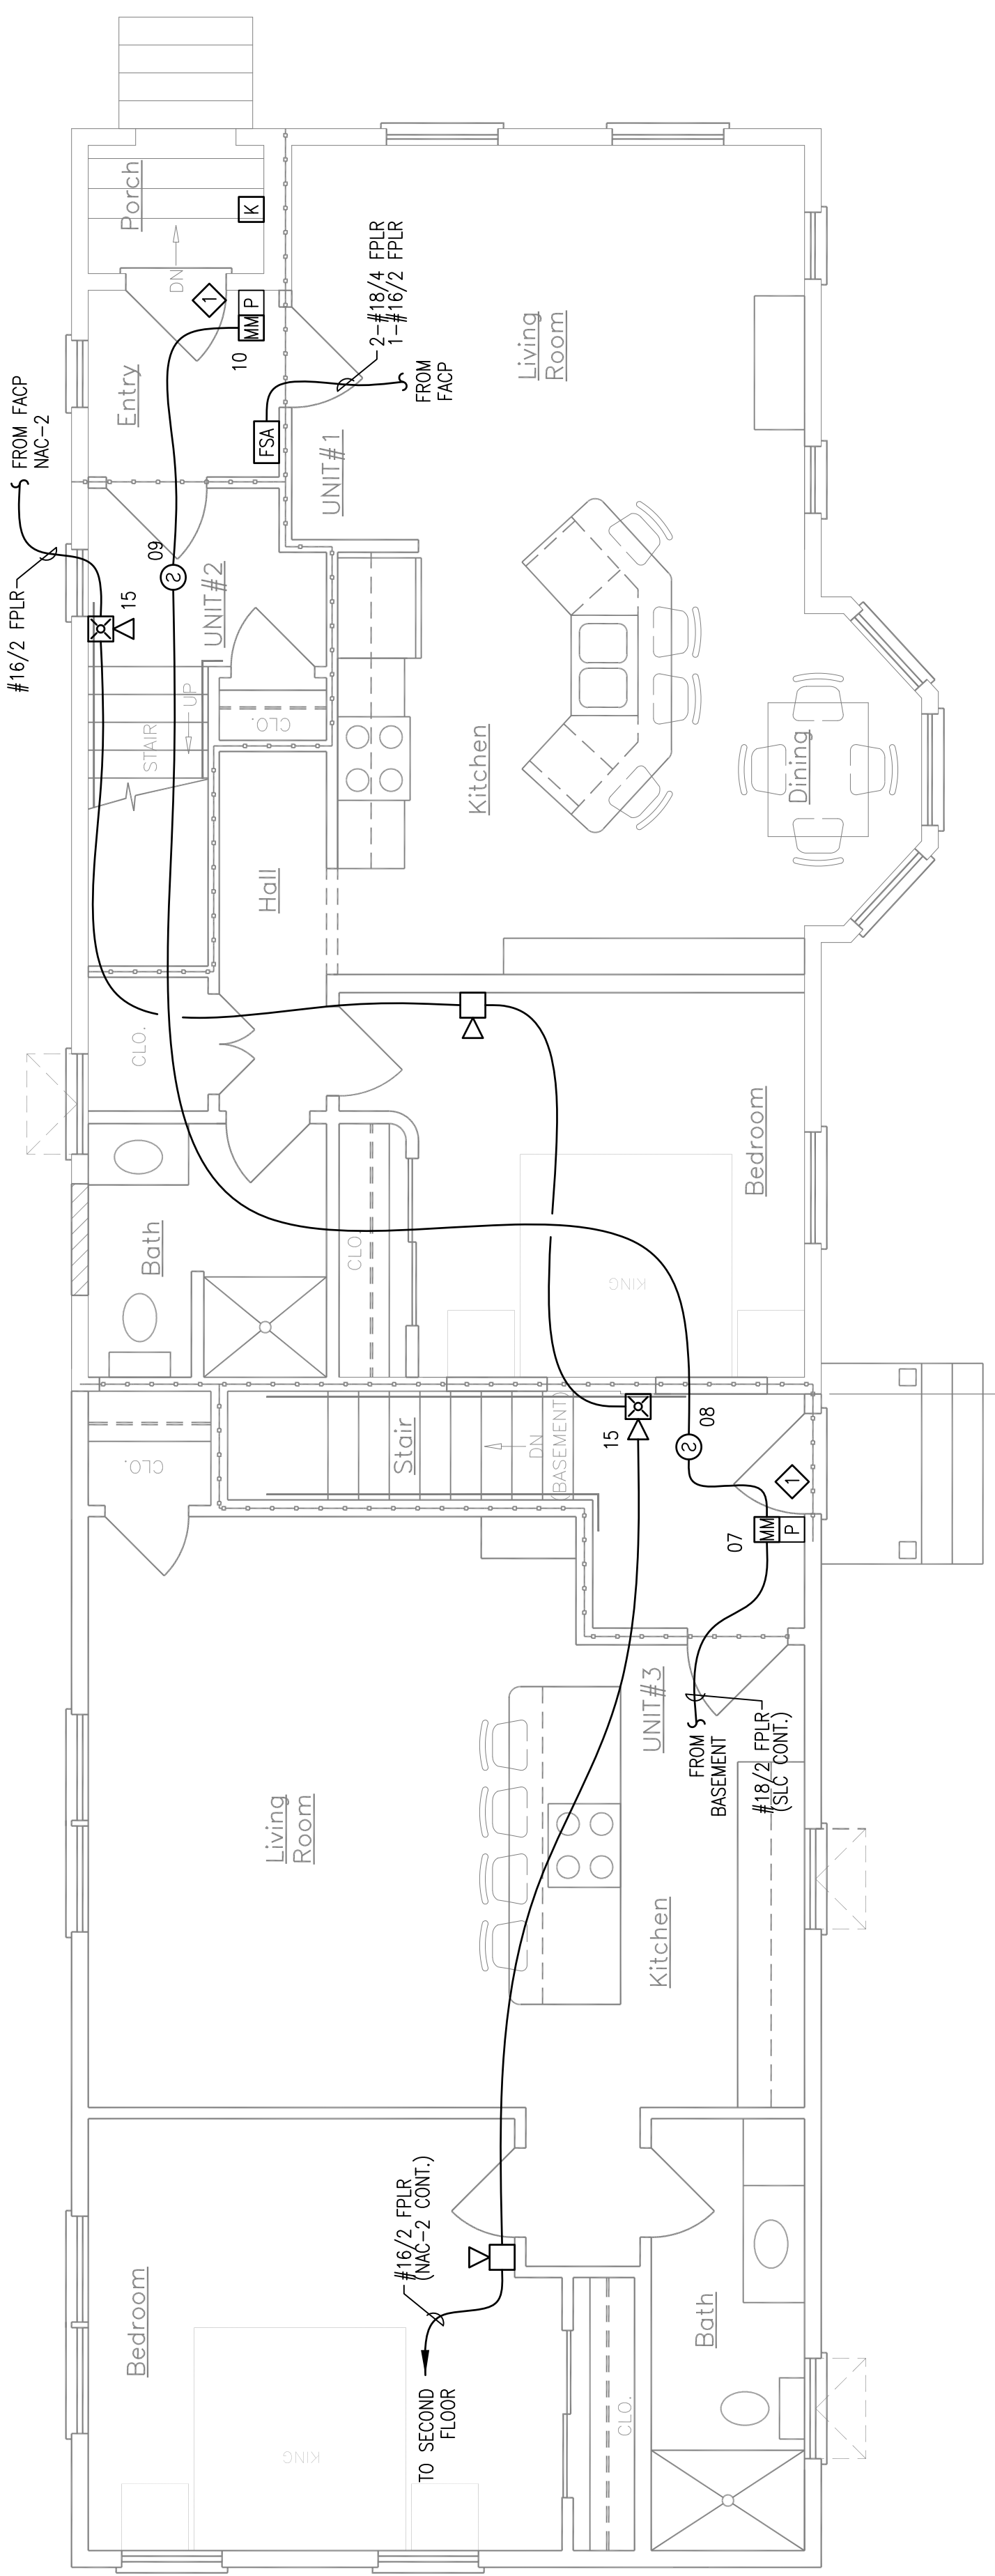


 
SHEET NOTES:

- ◇ ADDRESSABLE MONITOR MODULE PROVIDED TO MONITOR THE CONVENTIONAL PULL STATIONS. INSTALLING CONTRACTOR SHALL FIELD VERIFY EXACT MOUNTING, CIRCUITING AND PROGRAMMING REQUIREMENTS. FIELD VERIFY EXACT QUANTITY AND LOCATION(S).

RESERVED FOR CITY STAMP

WILMOT STREET



FIRST FLOOR FIRE ALARM PLAN
 SCALE: 1/4"=1'-0"


← RECONSTRUCTED EXISTING →