

REVISION	DESCRIPTION	DATE
0	ISSUED FOR REVIEW & APPROVAL	8/15/2017

RESERVED FOR CITY STAMP



SEACOAST SECURITY

 4 Summer Street • Freeport, Maine 04032

 Office: (207) 706-3369 • Fax: (207) 865-0852


52 WILMOT STREET


PORTLAND, MAINE 04101

SECOND FLOOR FIRE ALARM PLAN

DRAWN	JPB UNICAD JOB #17544
CHECKED	WAYNE B. HAWES NCET # 90496
DATE	8/15/2017
REVISION	0
SCALE	1/4"=1'-0"


FA-4

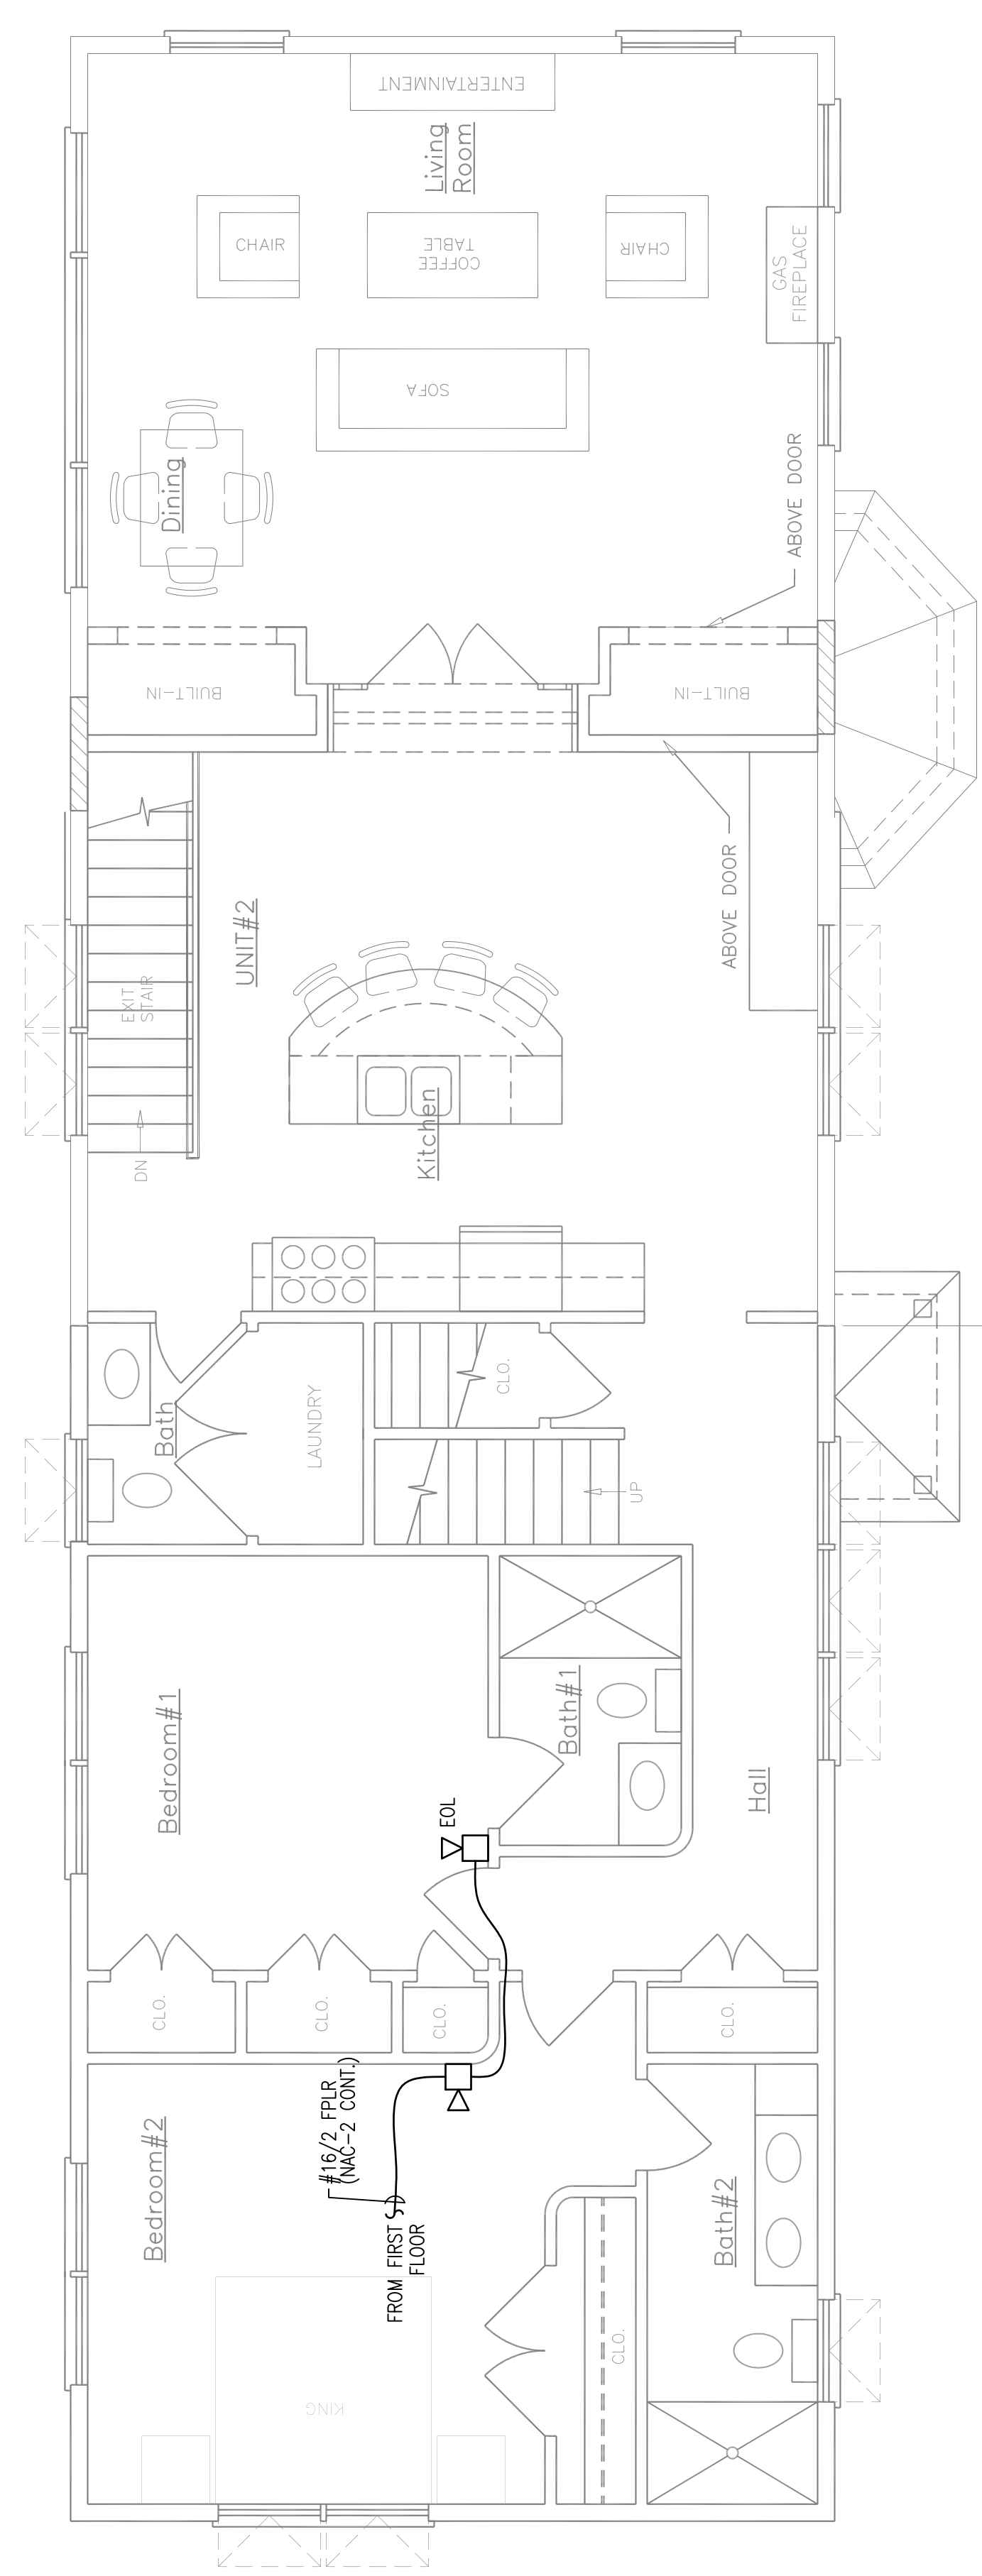



SECOND FLOOR FIRE ALARM PLAN

 SCALE: 1/4"=1'-0"

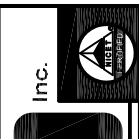

UNICAD Inc.

 100 Main Street
 Portland, ME 04101
 Phone: 801.865.6410
 www.unicad.net

Fire Alarm Design & Drafting Services