

REVISION	DESCRIPTION	DATE
0	ISSUED FOR REVIEW & APPROVAL	8/15/2017



SEACOAST SECURITY


 4 Summer Street • Freeport, Maine 04032


 Office: (207) 706-3369 • Fax: (207) 865-0852

52 WILMOT STREET
PORTLAND, MAINE 04101
LOFT FIRE ALARM PLAN


DRAWN	JPB UNICAD JOB #17544
CHECKED	WAYNE B. HAWES NCET # 90496
DATE	8/15/2017
REVISION	0
SCALE	1/4"=1'-0"

FA-5

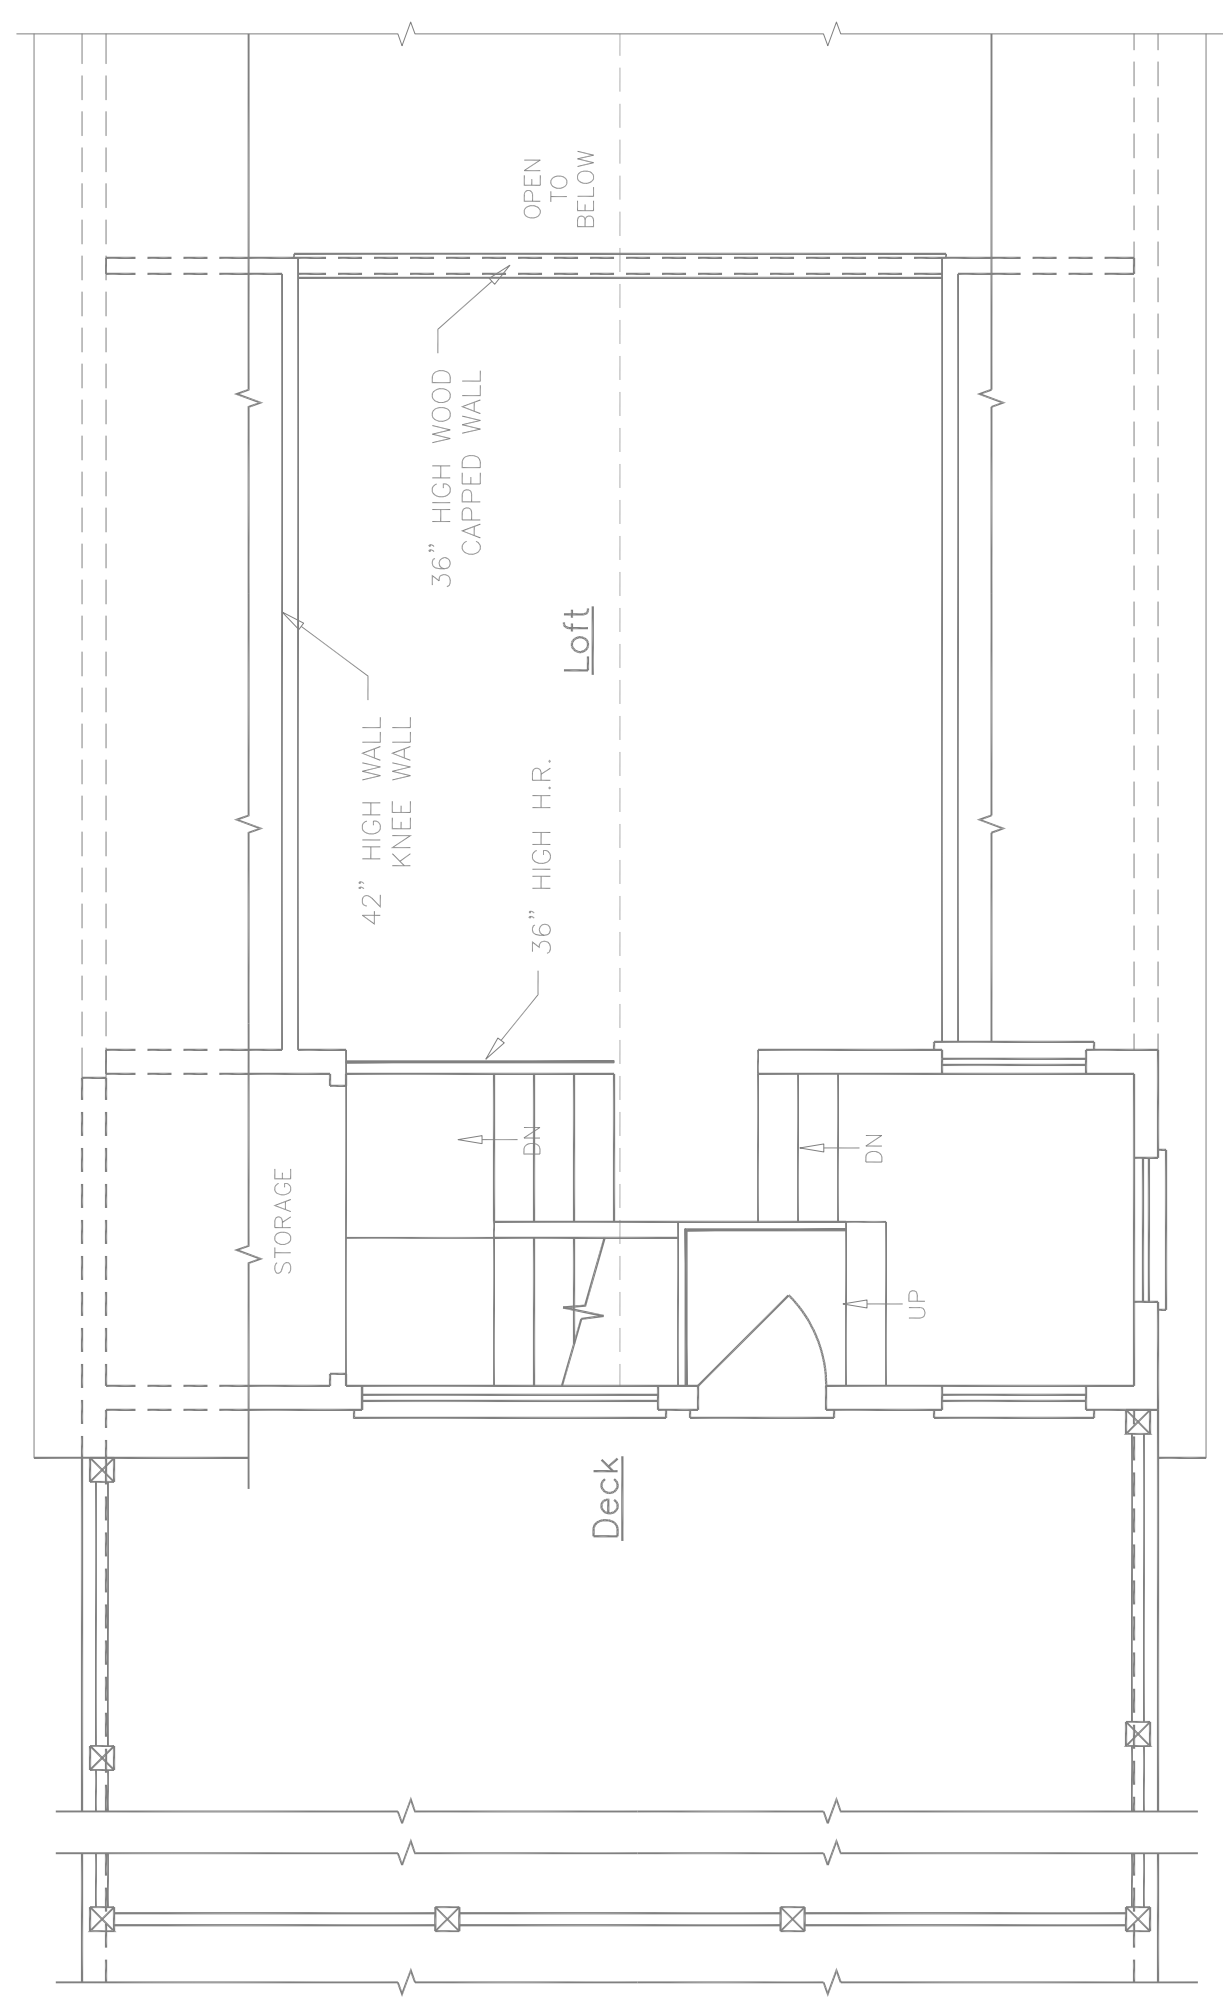


LOFT FIRE ALARM PLAN
 SCALE: 1/4"=1'-0"

RESERVED FOR CITY STAMP

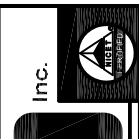

UNICAD Inc.
100 Main Street
 Portland, ME 04101
 Phone: 603.865.6410
 www.unicad.net

 Fire Alarm Design & Drafting Services