

REVISION	DESCRIPTION	DATE
0	ISSUED FOR REVIEW & APPROVAL	11/10/2016

SEACOAST SECURITY  
 4 Summer Street • Freeport, Maine 04032  
 Office: (207) 706-3369 • Fax: (207) 865-0852


**15 UNIT APARTMENT BUILDING**  
**48 WILMOT STREET**  
**PORTLAND, MAINE 04101**  
**FIRST FLOOR FIRE ALARM PLAN**

DRAWN	JPB UNICAD JOB #16883
CHECKED	WAYNE B. HAWES NCET # 90496
DATE	11/10/2016
REVISION	0
SCALE	1/4"=1'-0"

**FA-3**

**UNICAD** Inc.  
 Fire Alarm Design & Drafting Services  
 579A W. 40th St.  
 Portland, ME 04102  
 Phone: 603.865.6410  
 www.unicad.net

RESERVED FOR CITY STAMP

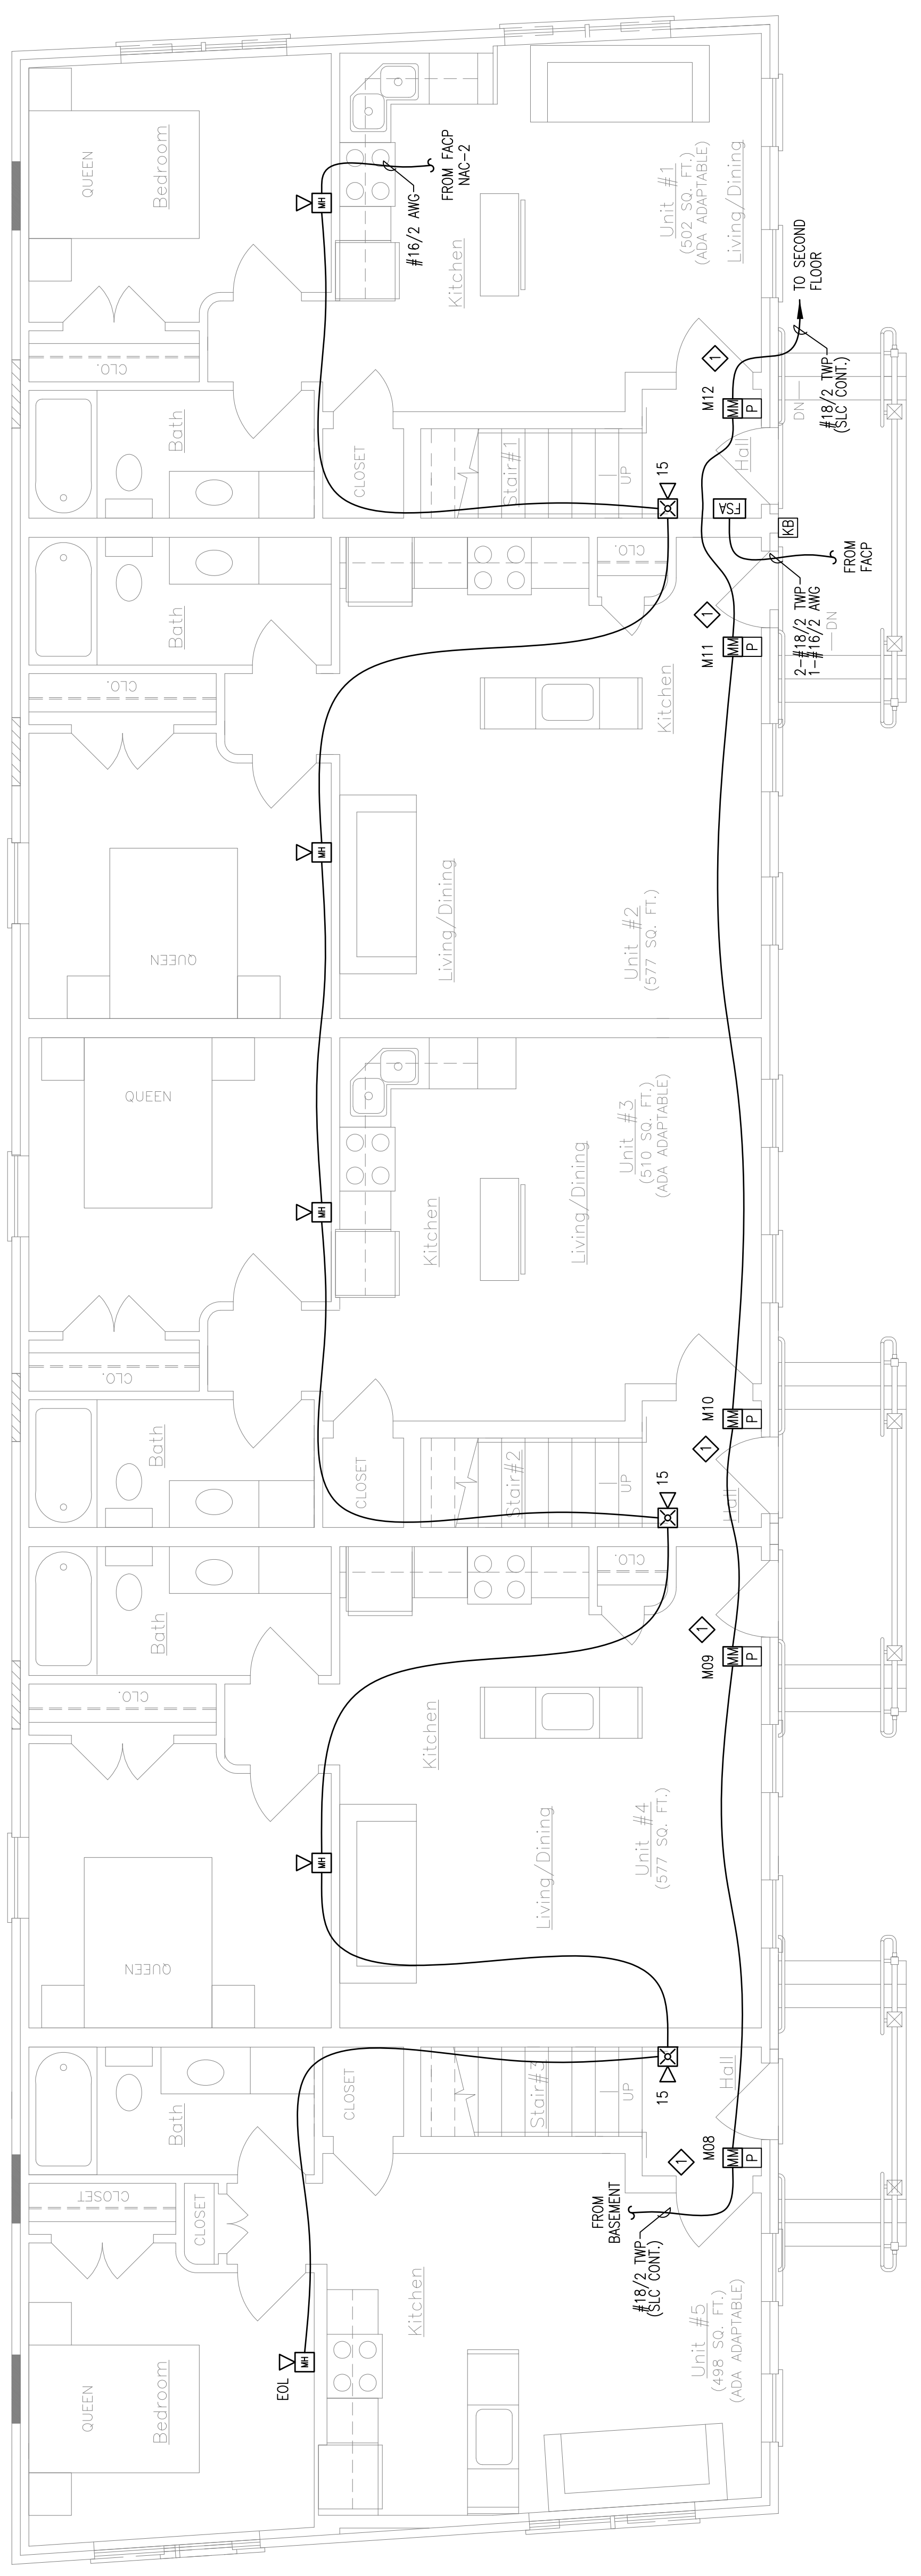

**FIRST FLOOR FIRE ALARM PLAN**  
 SCALE: 1/8"=1'-0"

**SHEET NOTES:**

- ◊ ADDRESSABLE MONITOR MODULE PROVIDED TO MONITOR THE CONVENTIONAL PULL STATION. INSTALLING CONTRACTOR SHALL FIELD VERIFY EXACT MOUNTING, CIRCUITING AND PROGRAMMING REQUIREMENTS. FIELD VERIFY EXACT QUANTITY AND LOCATION(S).