

REVISION	DESCRIPTION	DATE
0	ISSUED FOR REVIEW & APPROVAL	11/10/2016



SEACOAST SECURITY

4 Summer Street • Freeport, Maine 04032
 Office: (207) 706-3369 • Fax: (207) 865-0852


15 UNIT APARTMENT BUILDING
48 WILMOT STREET
PORTLAND, MAINE 04101
SECOND FLOOR FIRE ALARM PLAN

DRAWN	JPB UNICAD JOB #16883
CHECKED	WAYNE B. HAWES NCET # 90496
DATE	11/10/2016
REVISION	0
SCALE	1/4"=1'-0"

FA-4

UNICAD

Fire Alarm Design & Drafting Services
 www.unicad.net
 579A W. 40th St.
 Portland, ME 04107
 Office: 601.865.6410

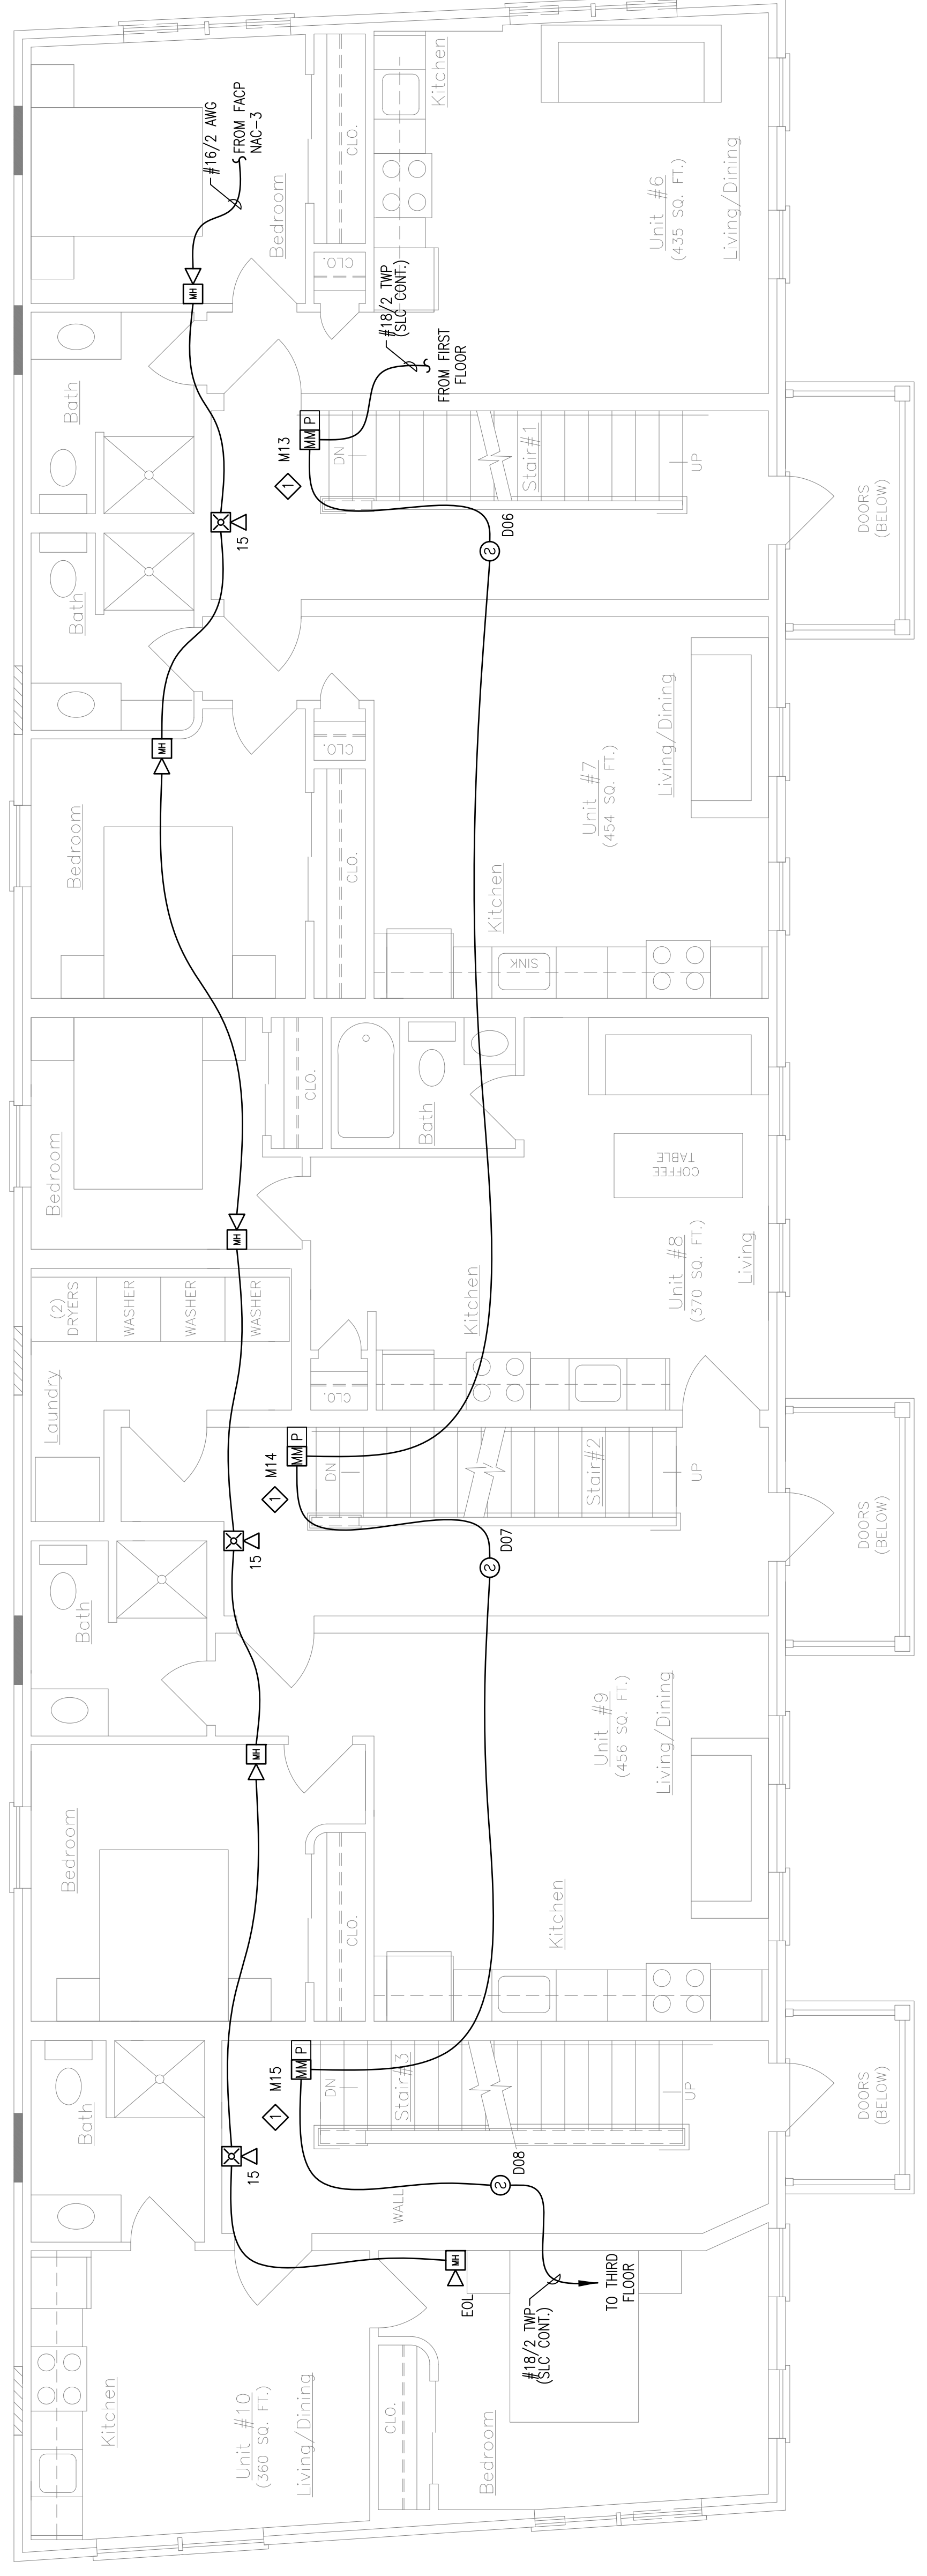

PLAN NORTH
SECOND FLOOR FIRE ALARM PLAN
 SCALE: 1/8"=1'-0"

SHEET NOTES:

- ◊ ADDRESSABLE MONITOR MODULE PROVIDED TO MONITOR THE CONVENTIONAL PULL STATION. INSTALLING CONTRACTOR SHALL FIELD VERIFY EXACT MOUNTING, CIRCUITING, AND PROGRAMMING REQUIREMENTS. FIELD VERIFY EXACT QUANTITY AND LOCATION(S).

RESERVED FOR CITY STAMP

WILMOT STREET