


REVISION	DESCRIPTION	DATE
0	ISSUED FOR REVIEW & APPROVAL	11/10/2016




SEACOAST SECURITY
 4 Summer Street • Freeport, Maine 04032
 Office: (207) 706-3369 • Fax: (207) 865-0852


15 UNIT APARTMENT BUILDING
48 WILMOT STREET
PORTLAND, MAINE 04101
THIRD FLOOR FIRE ALARM PLAN

DRAWN	JPB	UNICAD JOB #16883
CHECKED	WAYNE B. HAWES	NCET # 90496
DATE	11/10/2016	
REVISION	0	
SCALE	1/4"=1'-0"	

FA-5

RESERVED FOR CITY STAMP

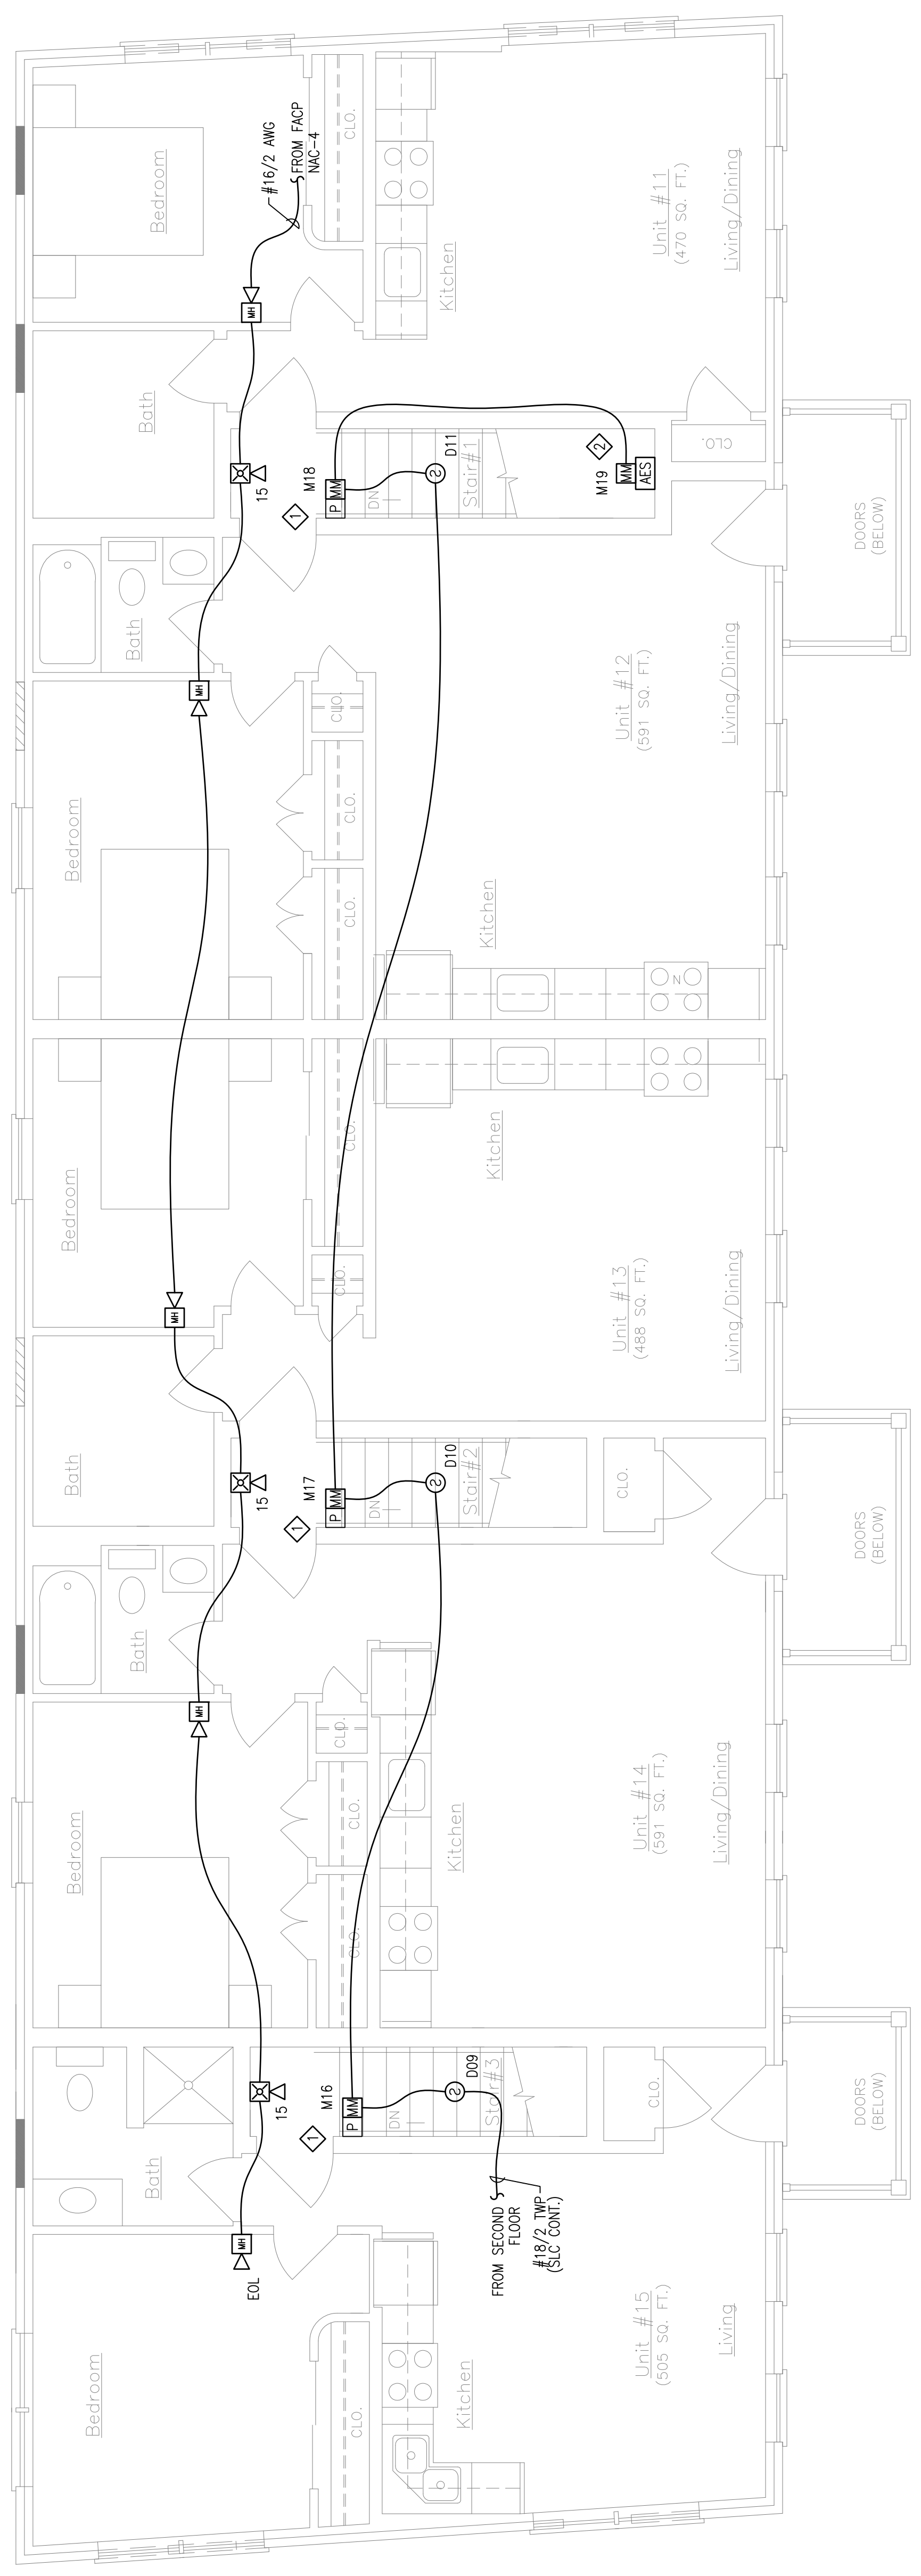


THIRD FLOOR FIRE ALARM PLAN
 SCALE: 1/8"=1'-0"

SHEET NOTES:

- ◇ ADDRESSABLE MONITOR MODULE PROVIDED TO MONITOR THE CONVENTIONAL PULL STATION. INSTALLING CONTRACTOR SHALL FIELD VERIFY EXACT MOUNTING, CIRCUITING AND PROGRAMMING REQUIREMENTS. FIELD VERIFY EXACT QUANTITY AND LOCATION(S).
- ◇ FIELD VERIFY EXACT LOCATION FOR AES RADIO.