


REVISION	DESCRIPTION	DATE
0	ISSUED FOR REVIEW & APPROVAL	3/20/2016

4 Summer Street • Freeport, Maine 04032  
 Office: (207) 706-3369 • Fax: (207) 865-0852




SEACOAST  
SECURITY

**223 CUMBERLAND AVENUE**  
**477 CONGRESS STREET**  
**PORTLAND, MAINE 04101**  
**FIRE ALARM PLAN - 1ST & 2ND FLOOR**


DRAWN	JS	UNICAD JOB #16171
CHECKED	WAYNE B. HAWES	NCET IV 90496
DATE	3/18/2016	
REVISION	0	
SCALE	1/4"=1'-0"	

**FA-2**

**UNICAD** Inc.  
 574 W. 40TH ST.  
 PORTLAND, ME 04102  
 OFFICE: 831.583.5410  
 www.unicad.net  
 Fire Alarm Design & Drafting Services

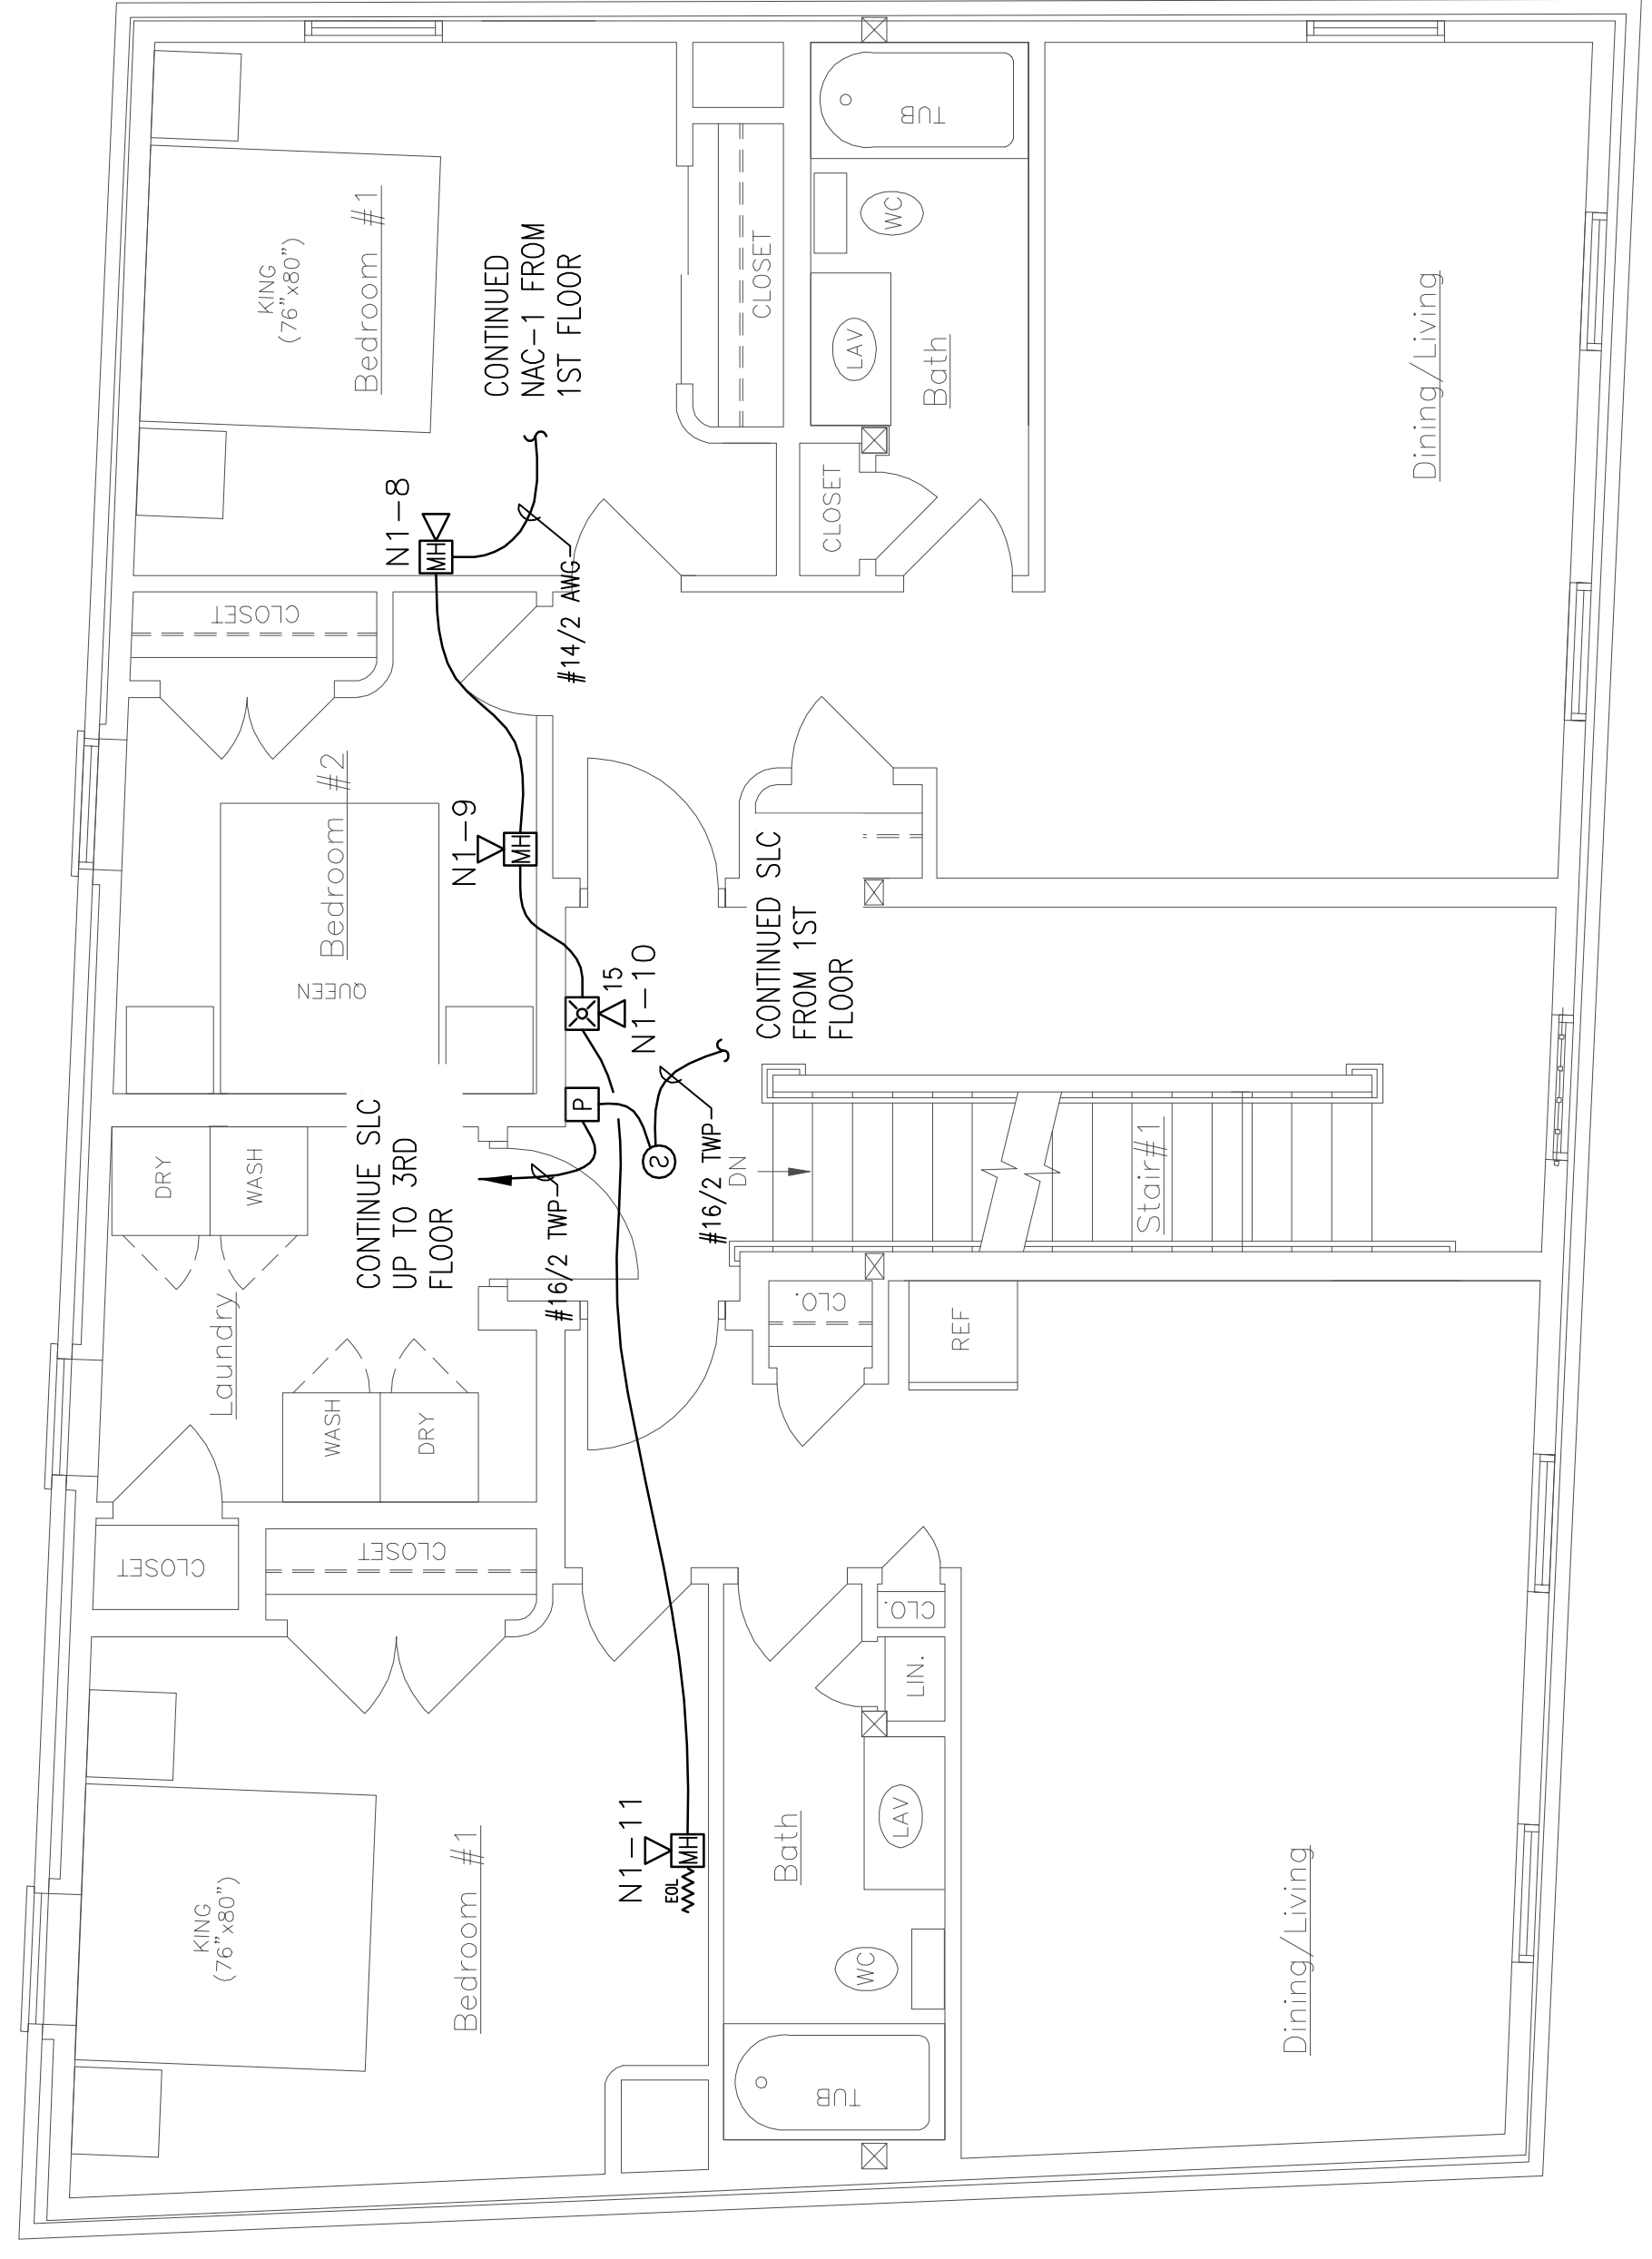

**2ND FLOOR**  
**FIRE ALARM PLAN**  
 SCALE: 1/4"=1'-0"

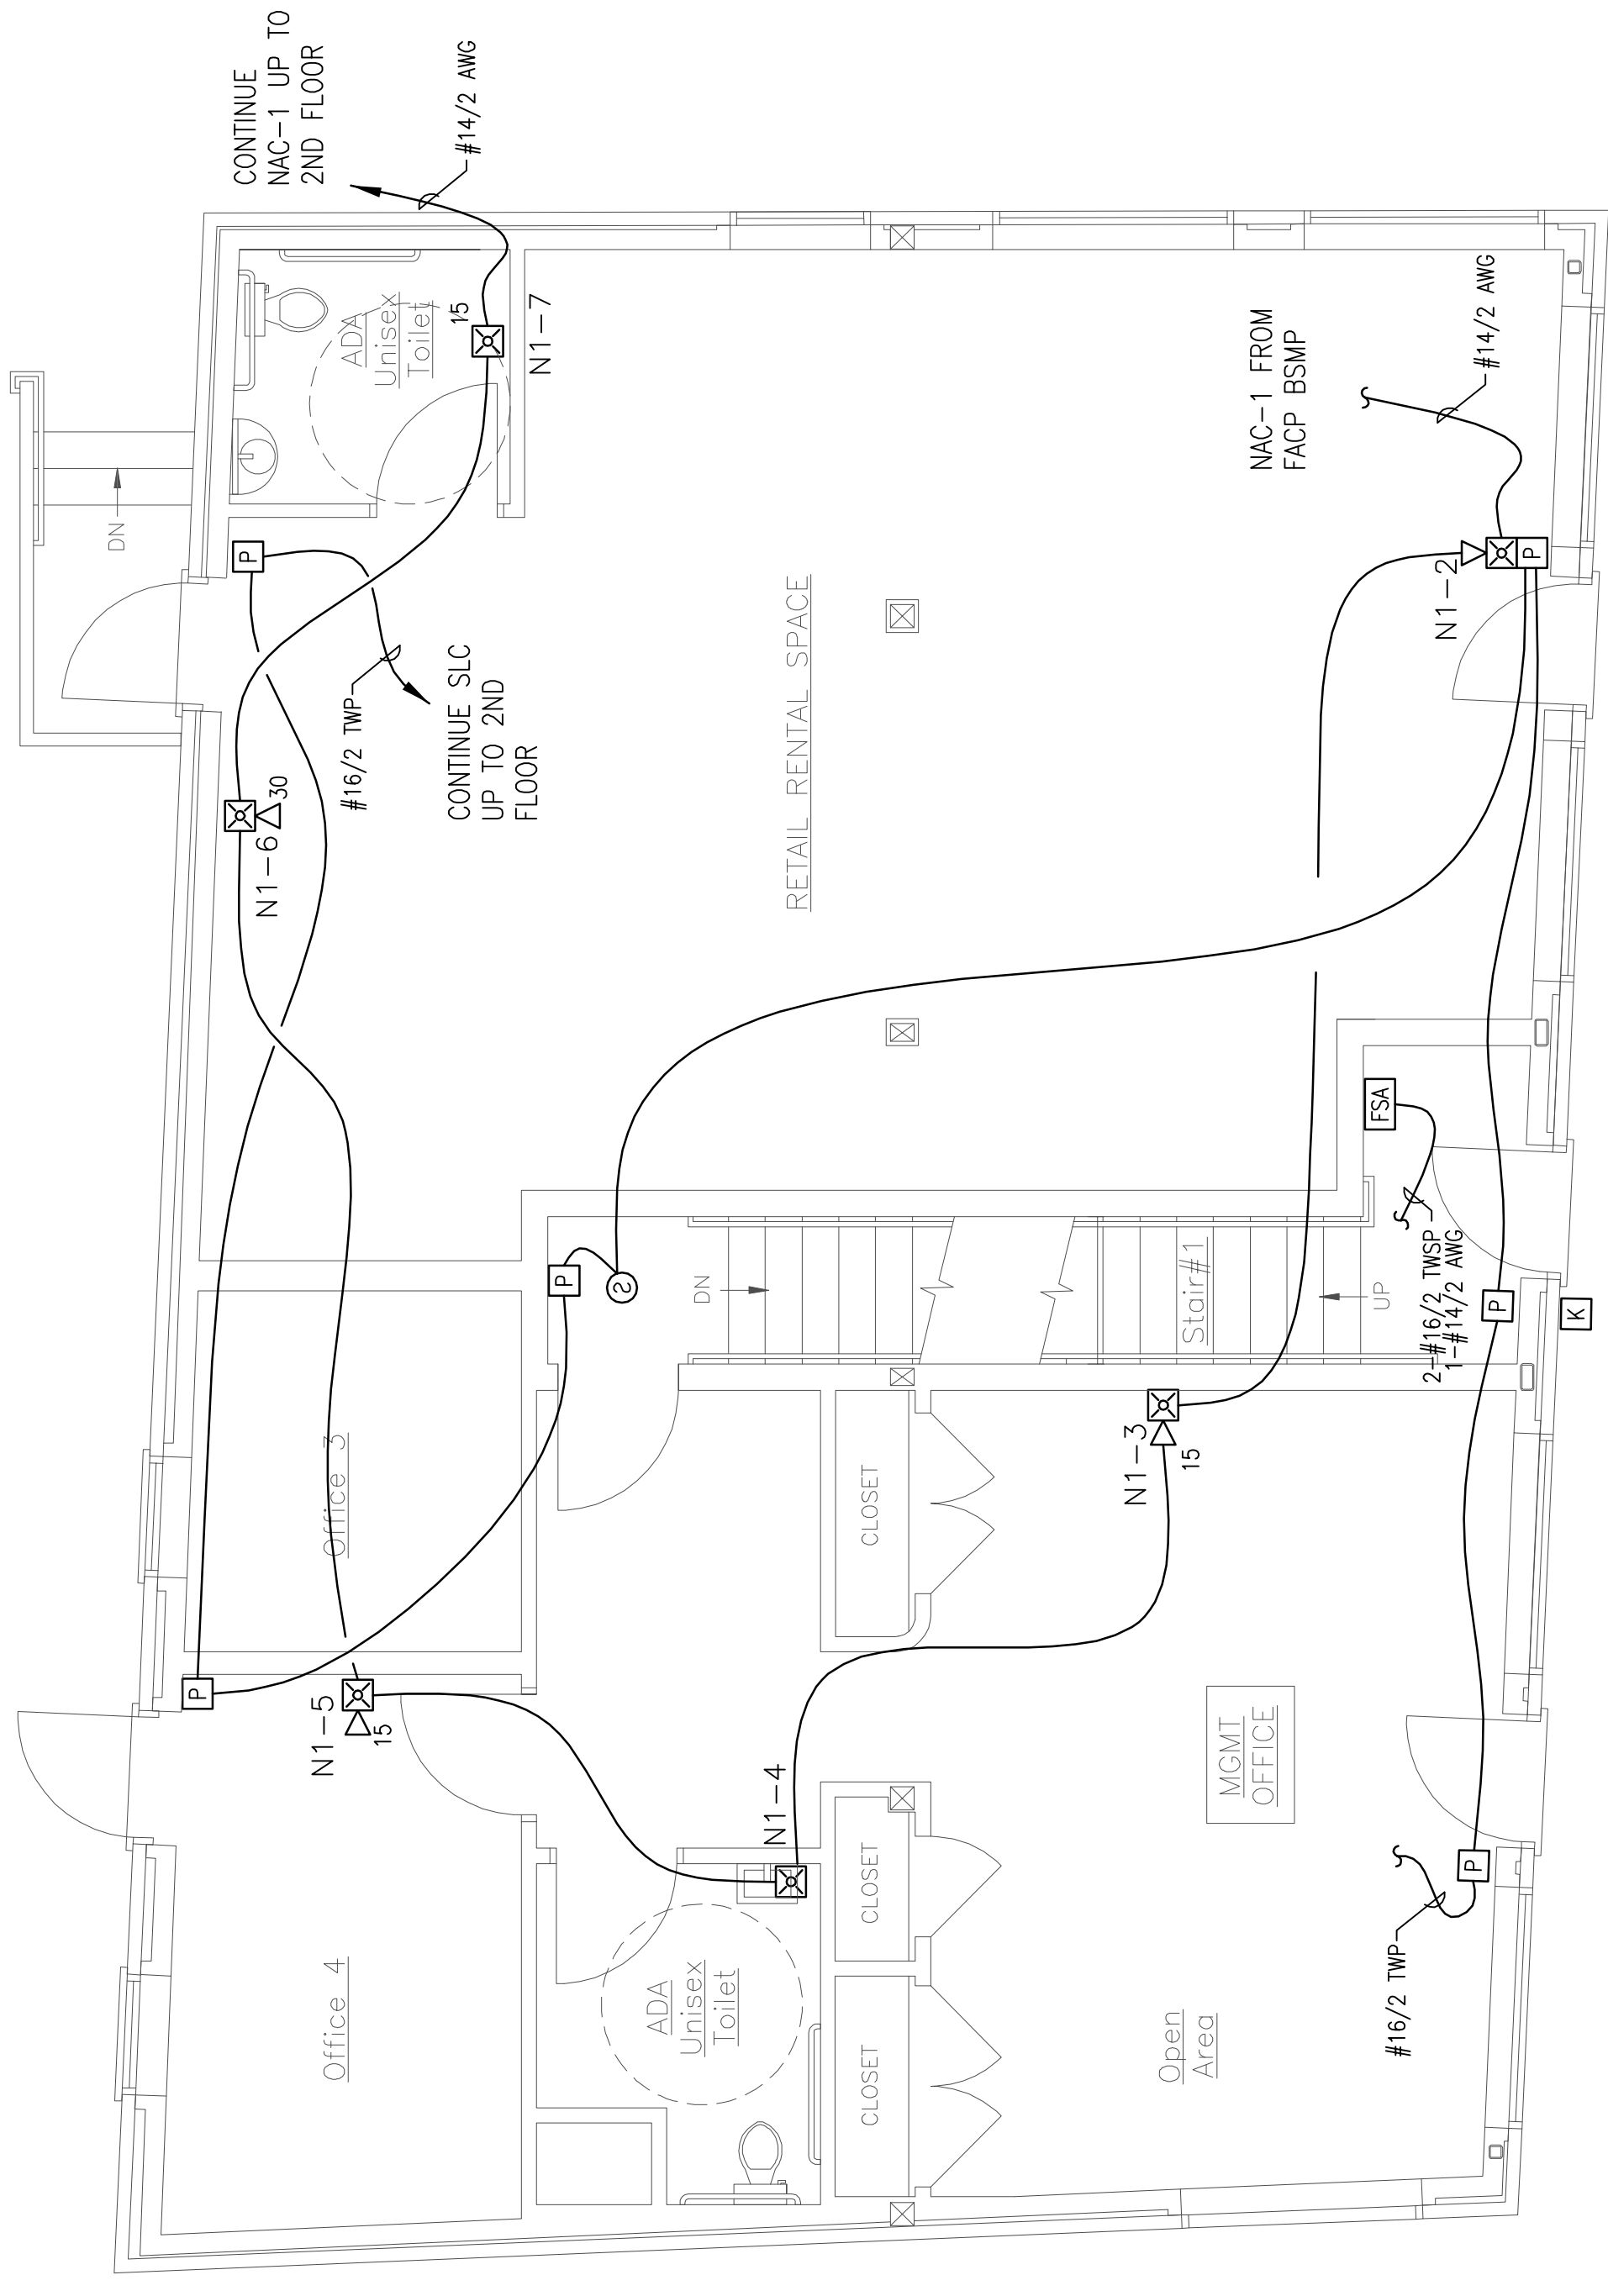

**1ST FLOOR**  
**FIRE ALARM PLAN**  
 SCALE: 1/4"=1'-0"

