


REVISION	DESCRIPTION	DATE
0	ISSUED FOR REVIEW & APPROVAL	3/20/2016

4 Summer Street • Freeport, Maine 04032
Office: (207) 706-3369 • Fax: (207) 865-0852




SEACOAST
SECURITY

**223 CUMBERLAND AVENUE
477 CONGRESS STREET
PORTLAND, MAINE 04101
FIRE ALARM PLAN - 3RD & 4TH FLOOR**


DRAWN	JS	UNICAD JOB #16171
CHECKED	WAYNE B. HAWES	NCET IV 90496
DATE	3/18/2016	
REVISION	0	
SCALE	1/4"=1'-0"	

FA-3

UNICAD
Inc.
1000 Main Street
Freeport, ME 04032
Office: 831.865.0410
www.unicad.net
Fire Alarm Design & Drafting Services

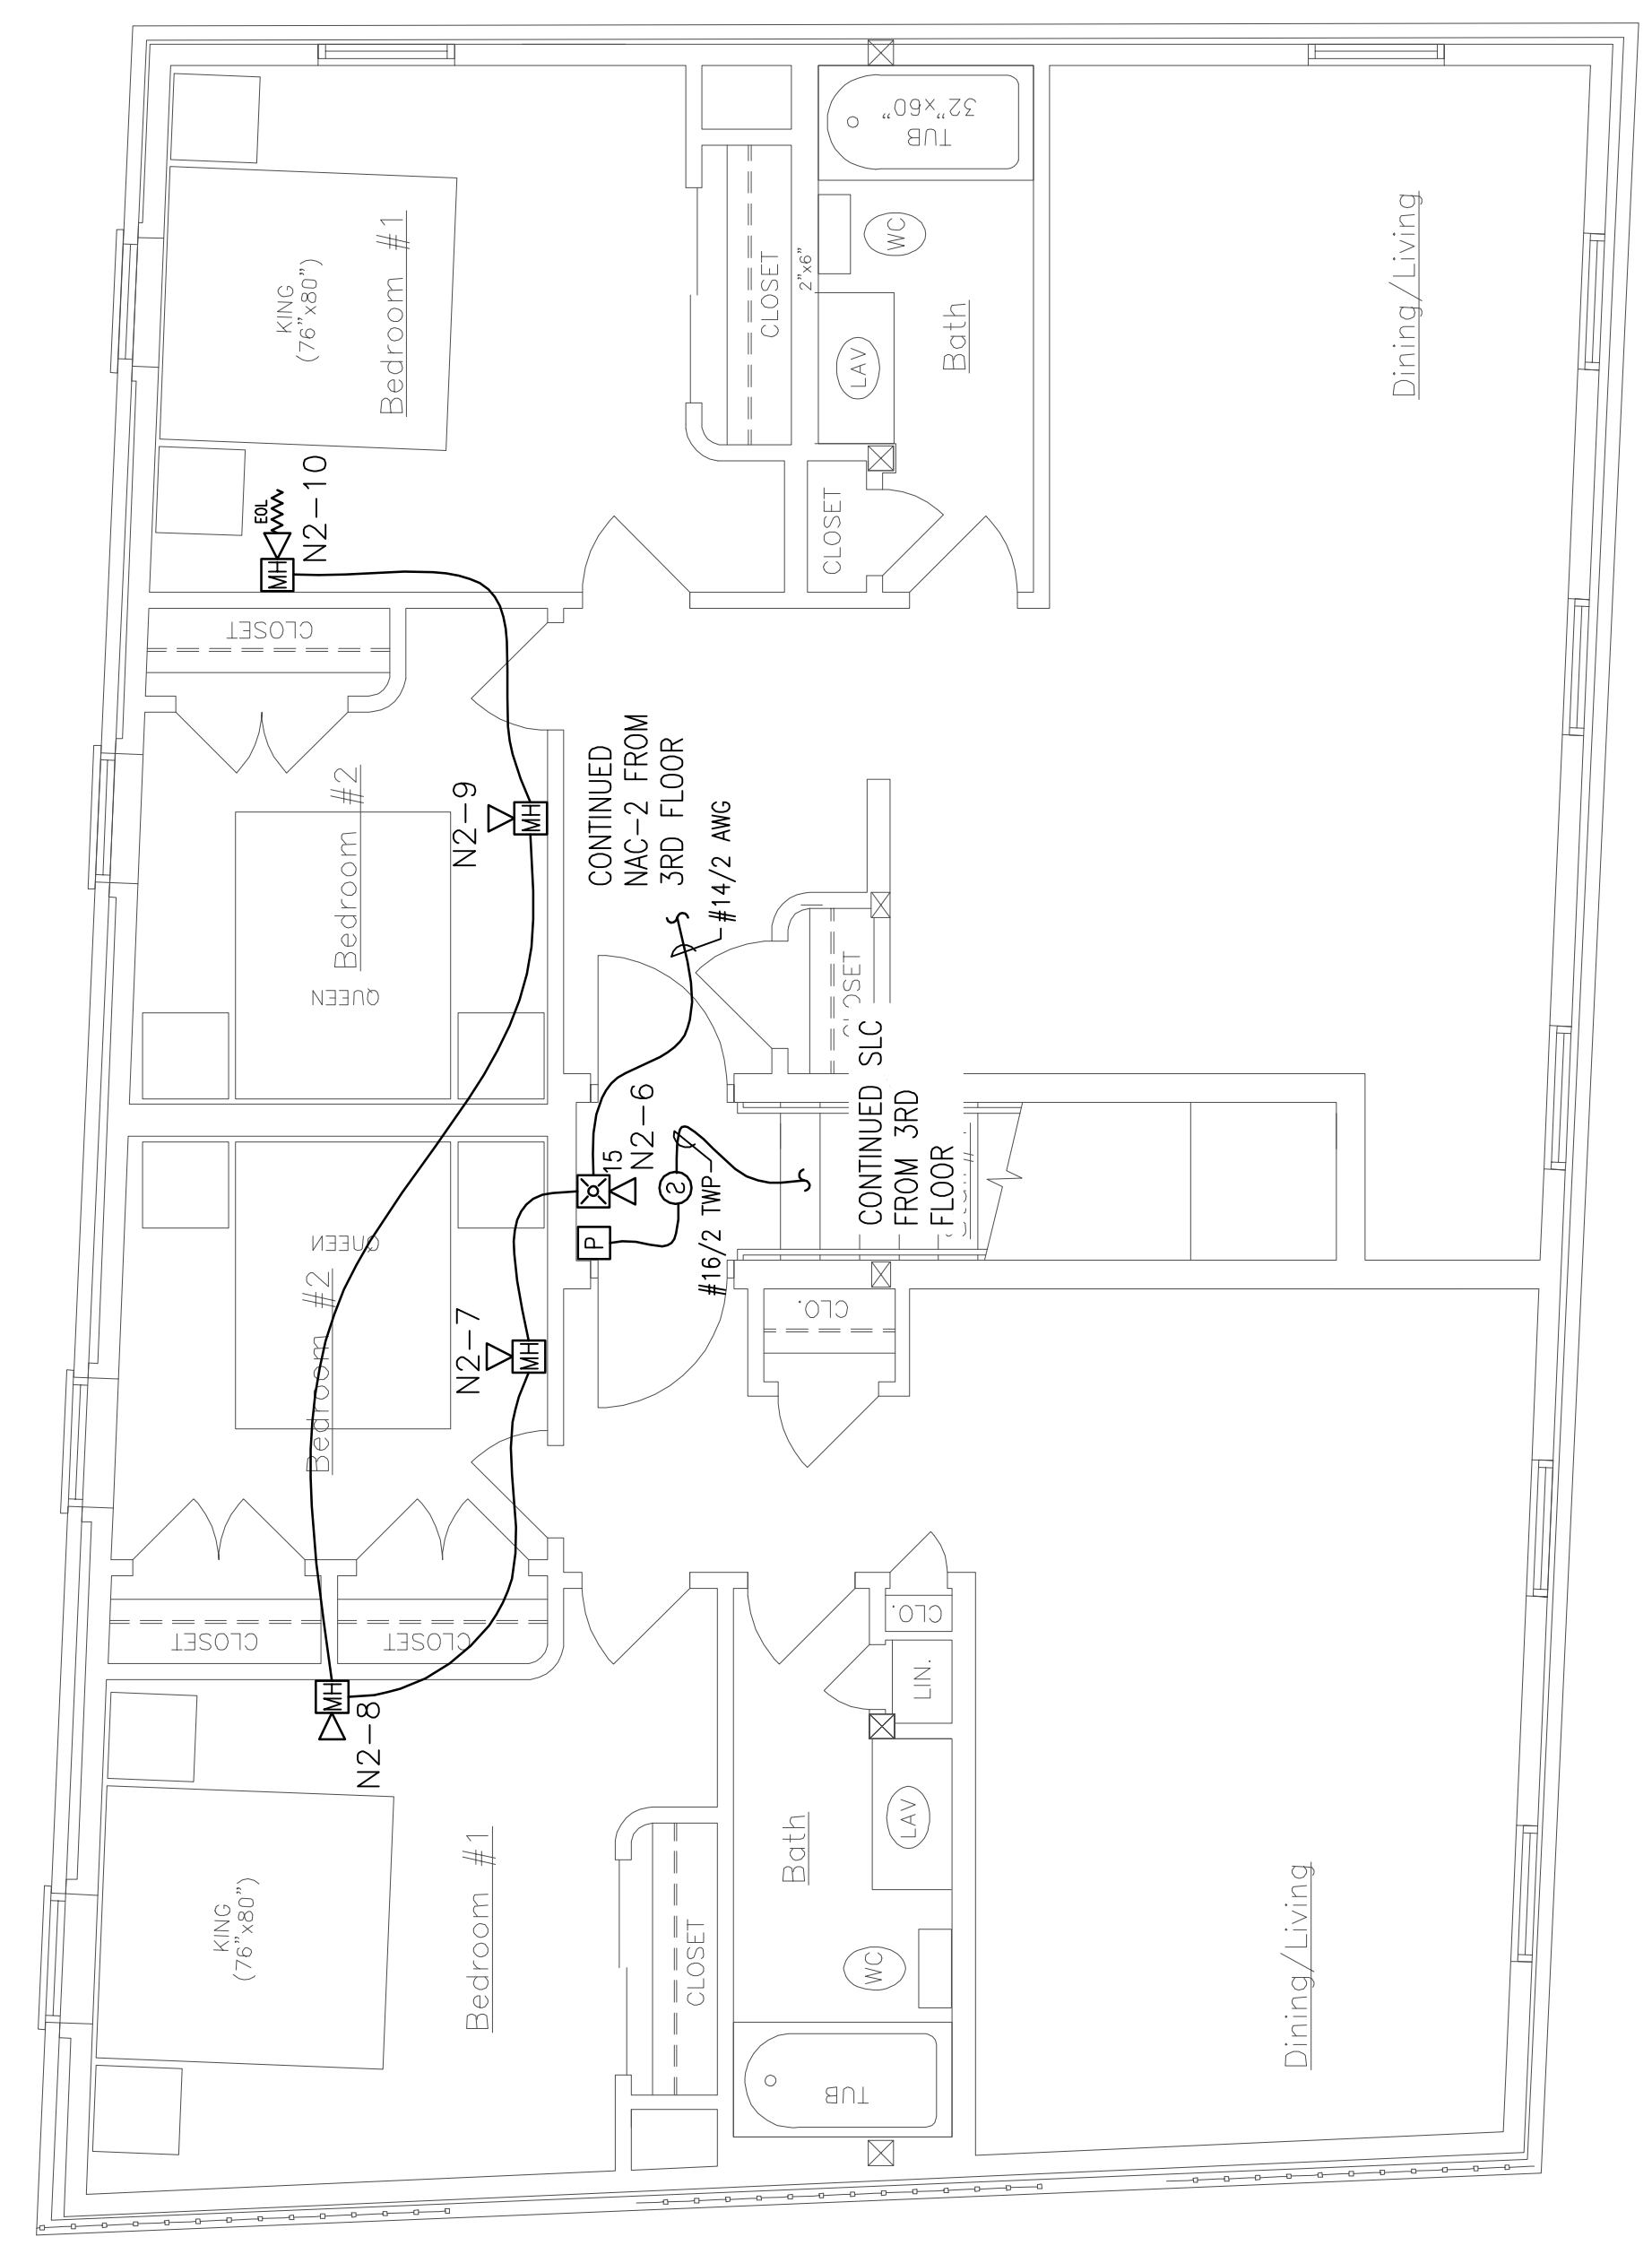

**4TH FLOOR
FIRE ALARM PLAN**
SCALE: 1/4"=1'-0"

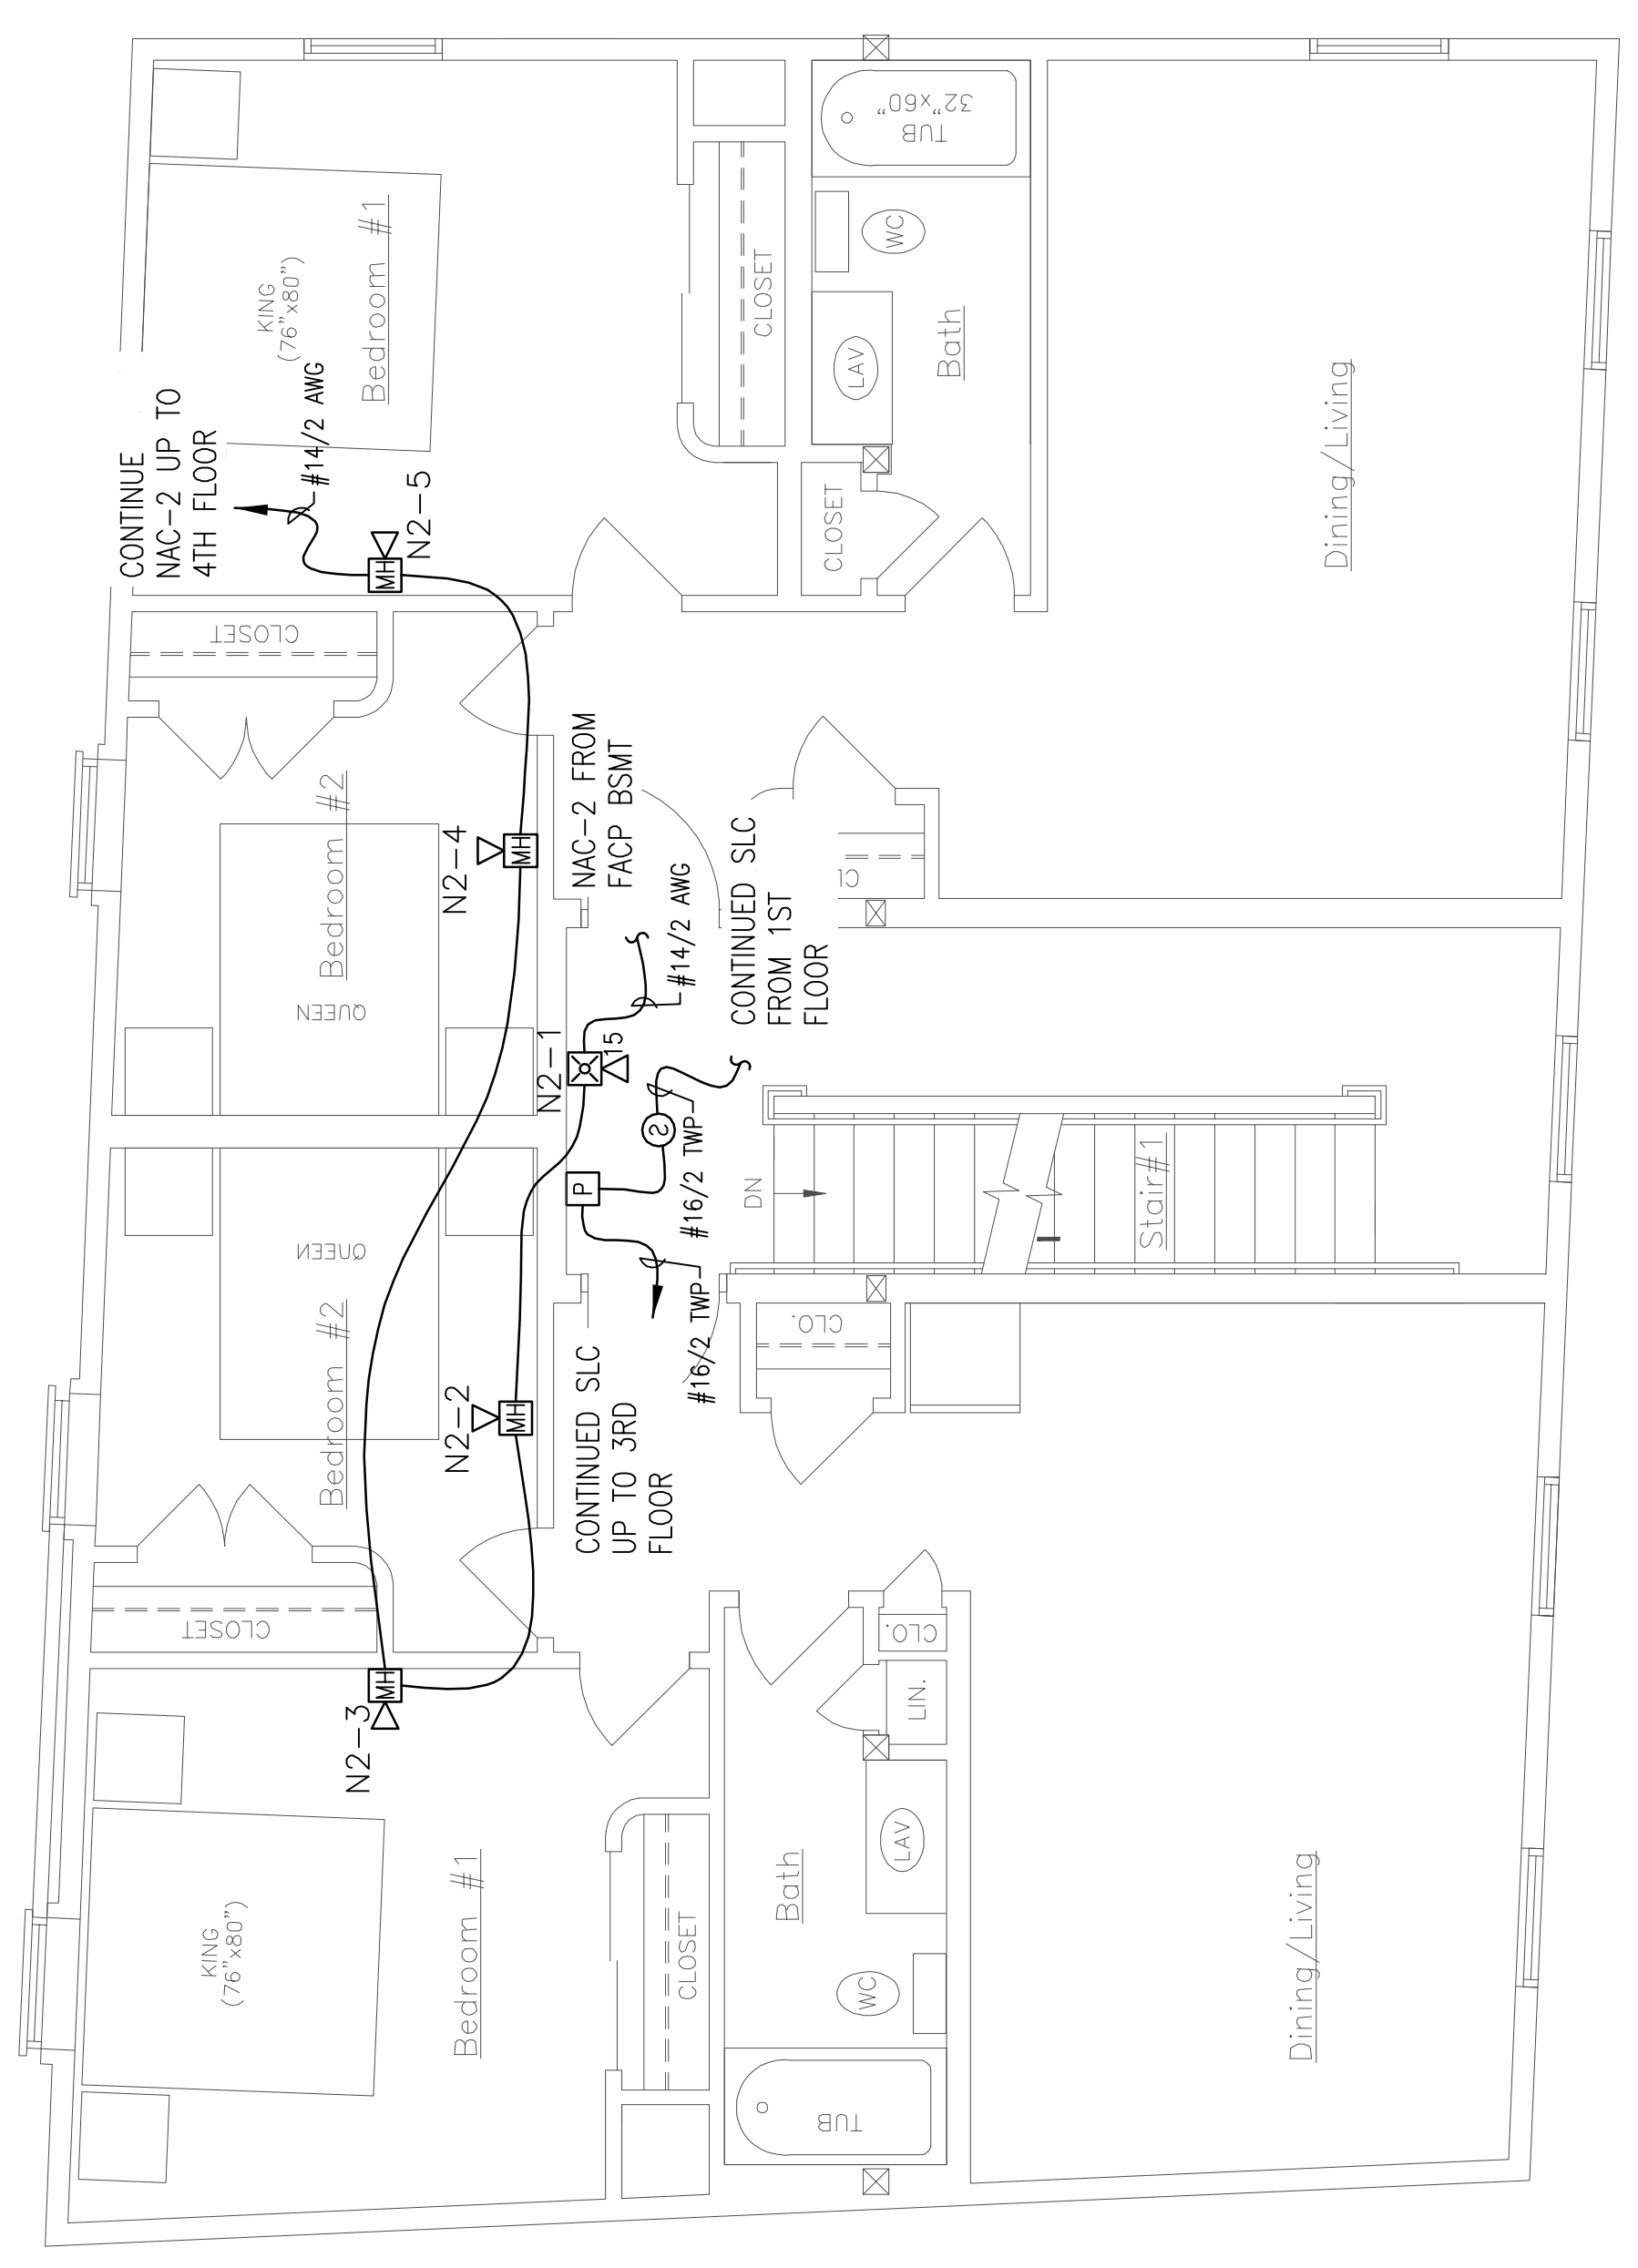

**3RD FLOOR
FIRE ALARM PLAN**
SCALE: 1/4"=1'-0"