


REVISION	DESCRIPTION	DATE
0	ISSUED FOR REVIEW & APPROVAL	5/25/2016

  
**SEACOAST SECURITY**  
 4 Summer Street - Freeport, Maine 04032  
 Office: (207) 706-3369 • Fax: (207) 865-0852


**147 PEARL STREET**  
**PORTLAND, MAINE 04101**  
**BASEMENT FIRE ALARM PLAN**


DRAWN	JPB UNICAD JOB #16370
CHECKED	WAYNE B. HAWES NGEET # 90496
DATE	5/25/2016
REVISION	0
SCALE	1/4"=1'-0"

**FA-2**

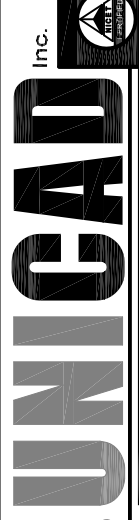  
 www.unicad.net  
 575 W. 400th St.  
 Office: 601.865.6410  
 www.unicad.net Fire Alarm Design & Drafting Services

RESERVED FOR CITY STAMP

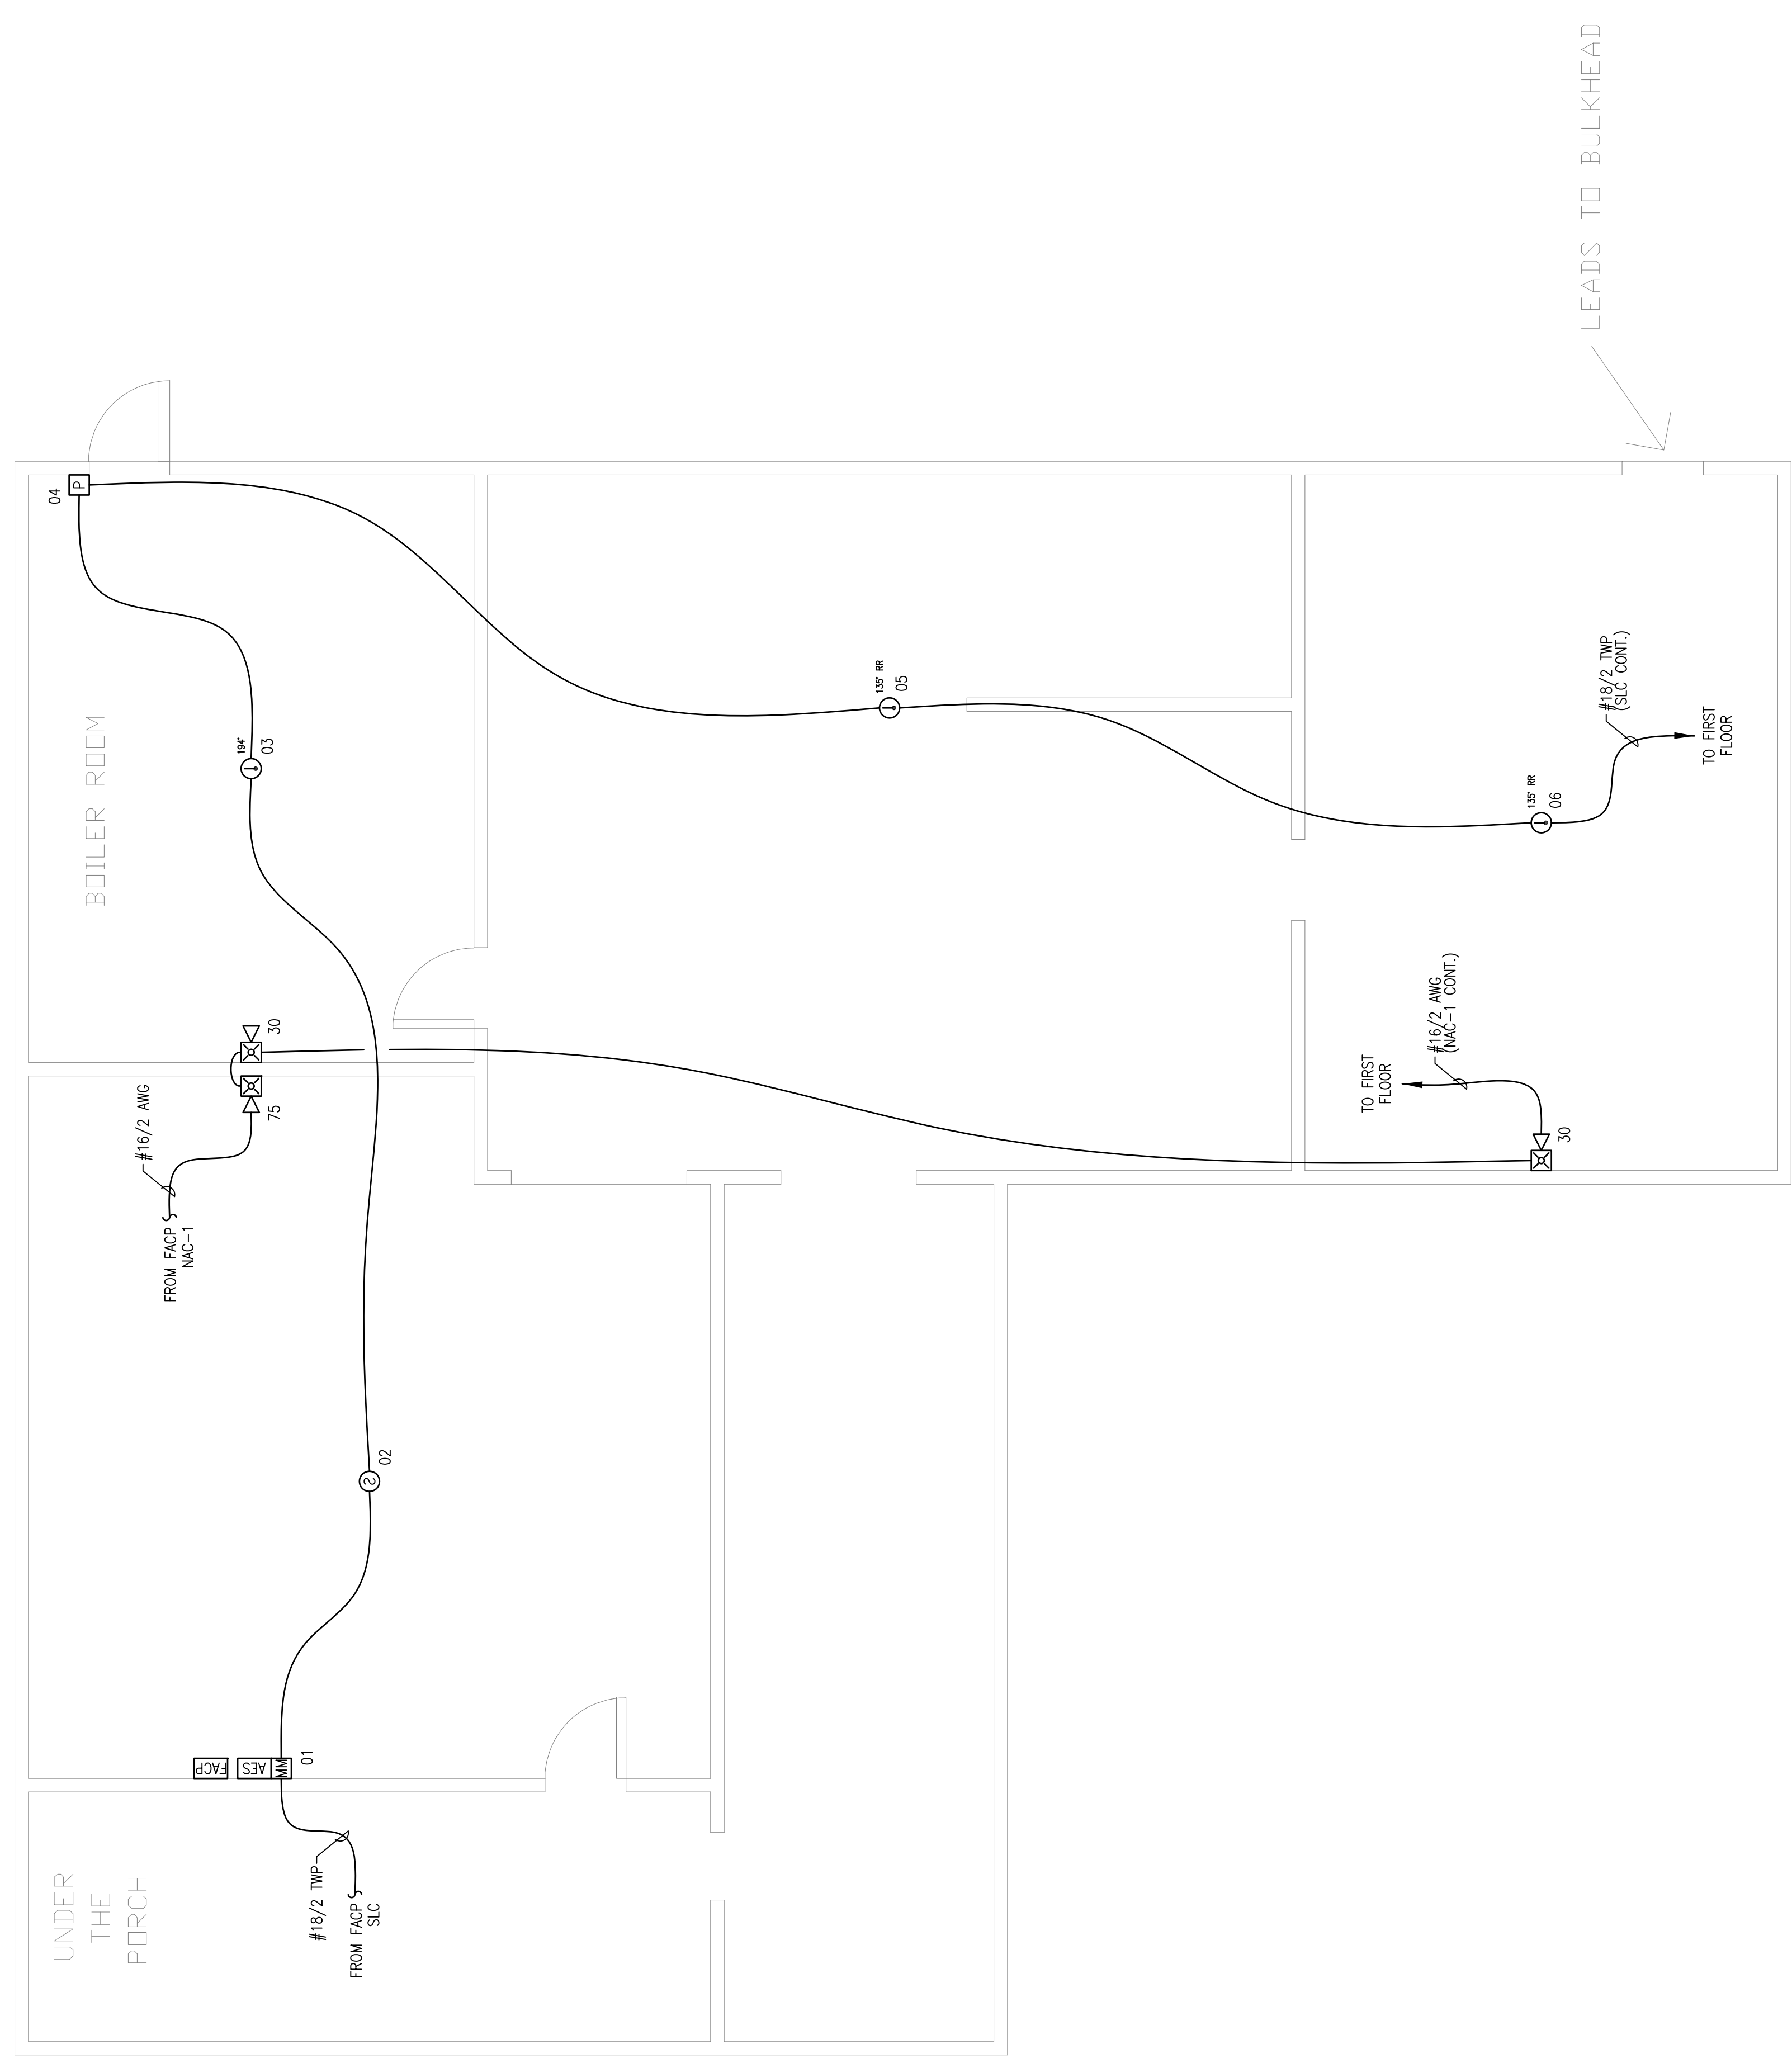

PLAN NORTH  
  
**BASEMENT FIRE ALARM PLAN**  
 SCALE: 1/4"=1'-0"  
