

REVISION	DESCRIPTION	DATE
0	ISSUED FOR REVIEW & APPROVAL	5/25/2016




SEACOAST SECURITY

4 Summer Street • Freeport, Maine 04032
 Office: (207) 706-3369 • Fax: (207) 865-0852

147 PEARL STREET
PORTLAND, MAINE 04101
FIRST FLOOR FIRE ALARM PLAN

DRAWN	JPB UNICAD JOB #16370
CHECKED	WAYNE B. HAWES NCET # 90496
DATE	5/25/2016
REVISION	0
SCALE	1/4"=1'-0"


FA-3

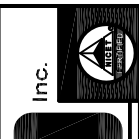

UNICAD Inc.
100 Main Street
 Portland, ME 04101
 Phone: 603.865.6410
 www.unicad.net

 Fire Alarm Design & Drafting Services

RESERVED FOR CITY STAMP

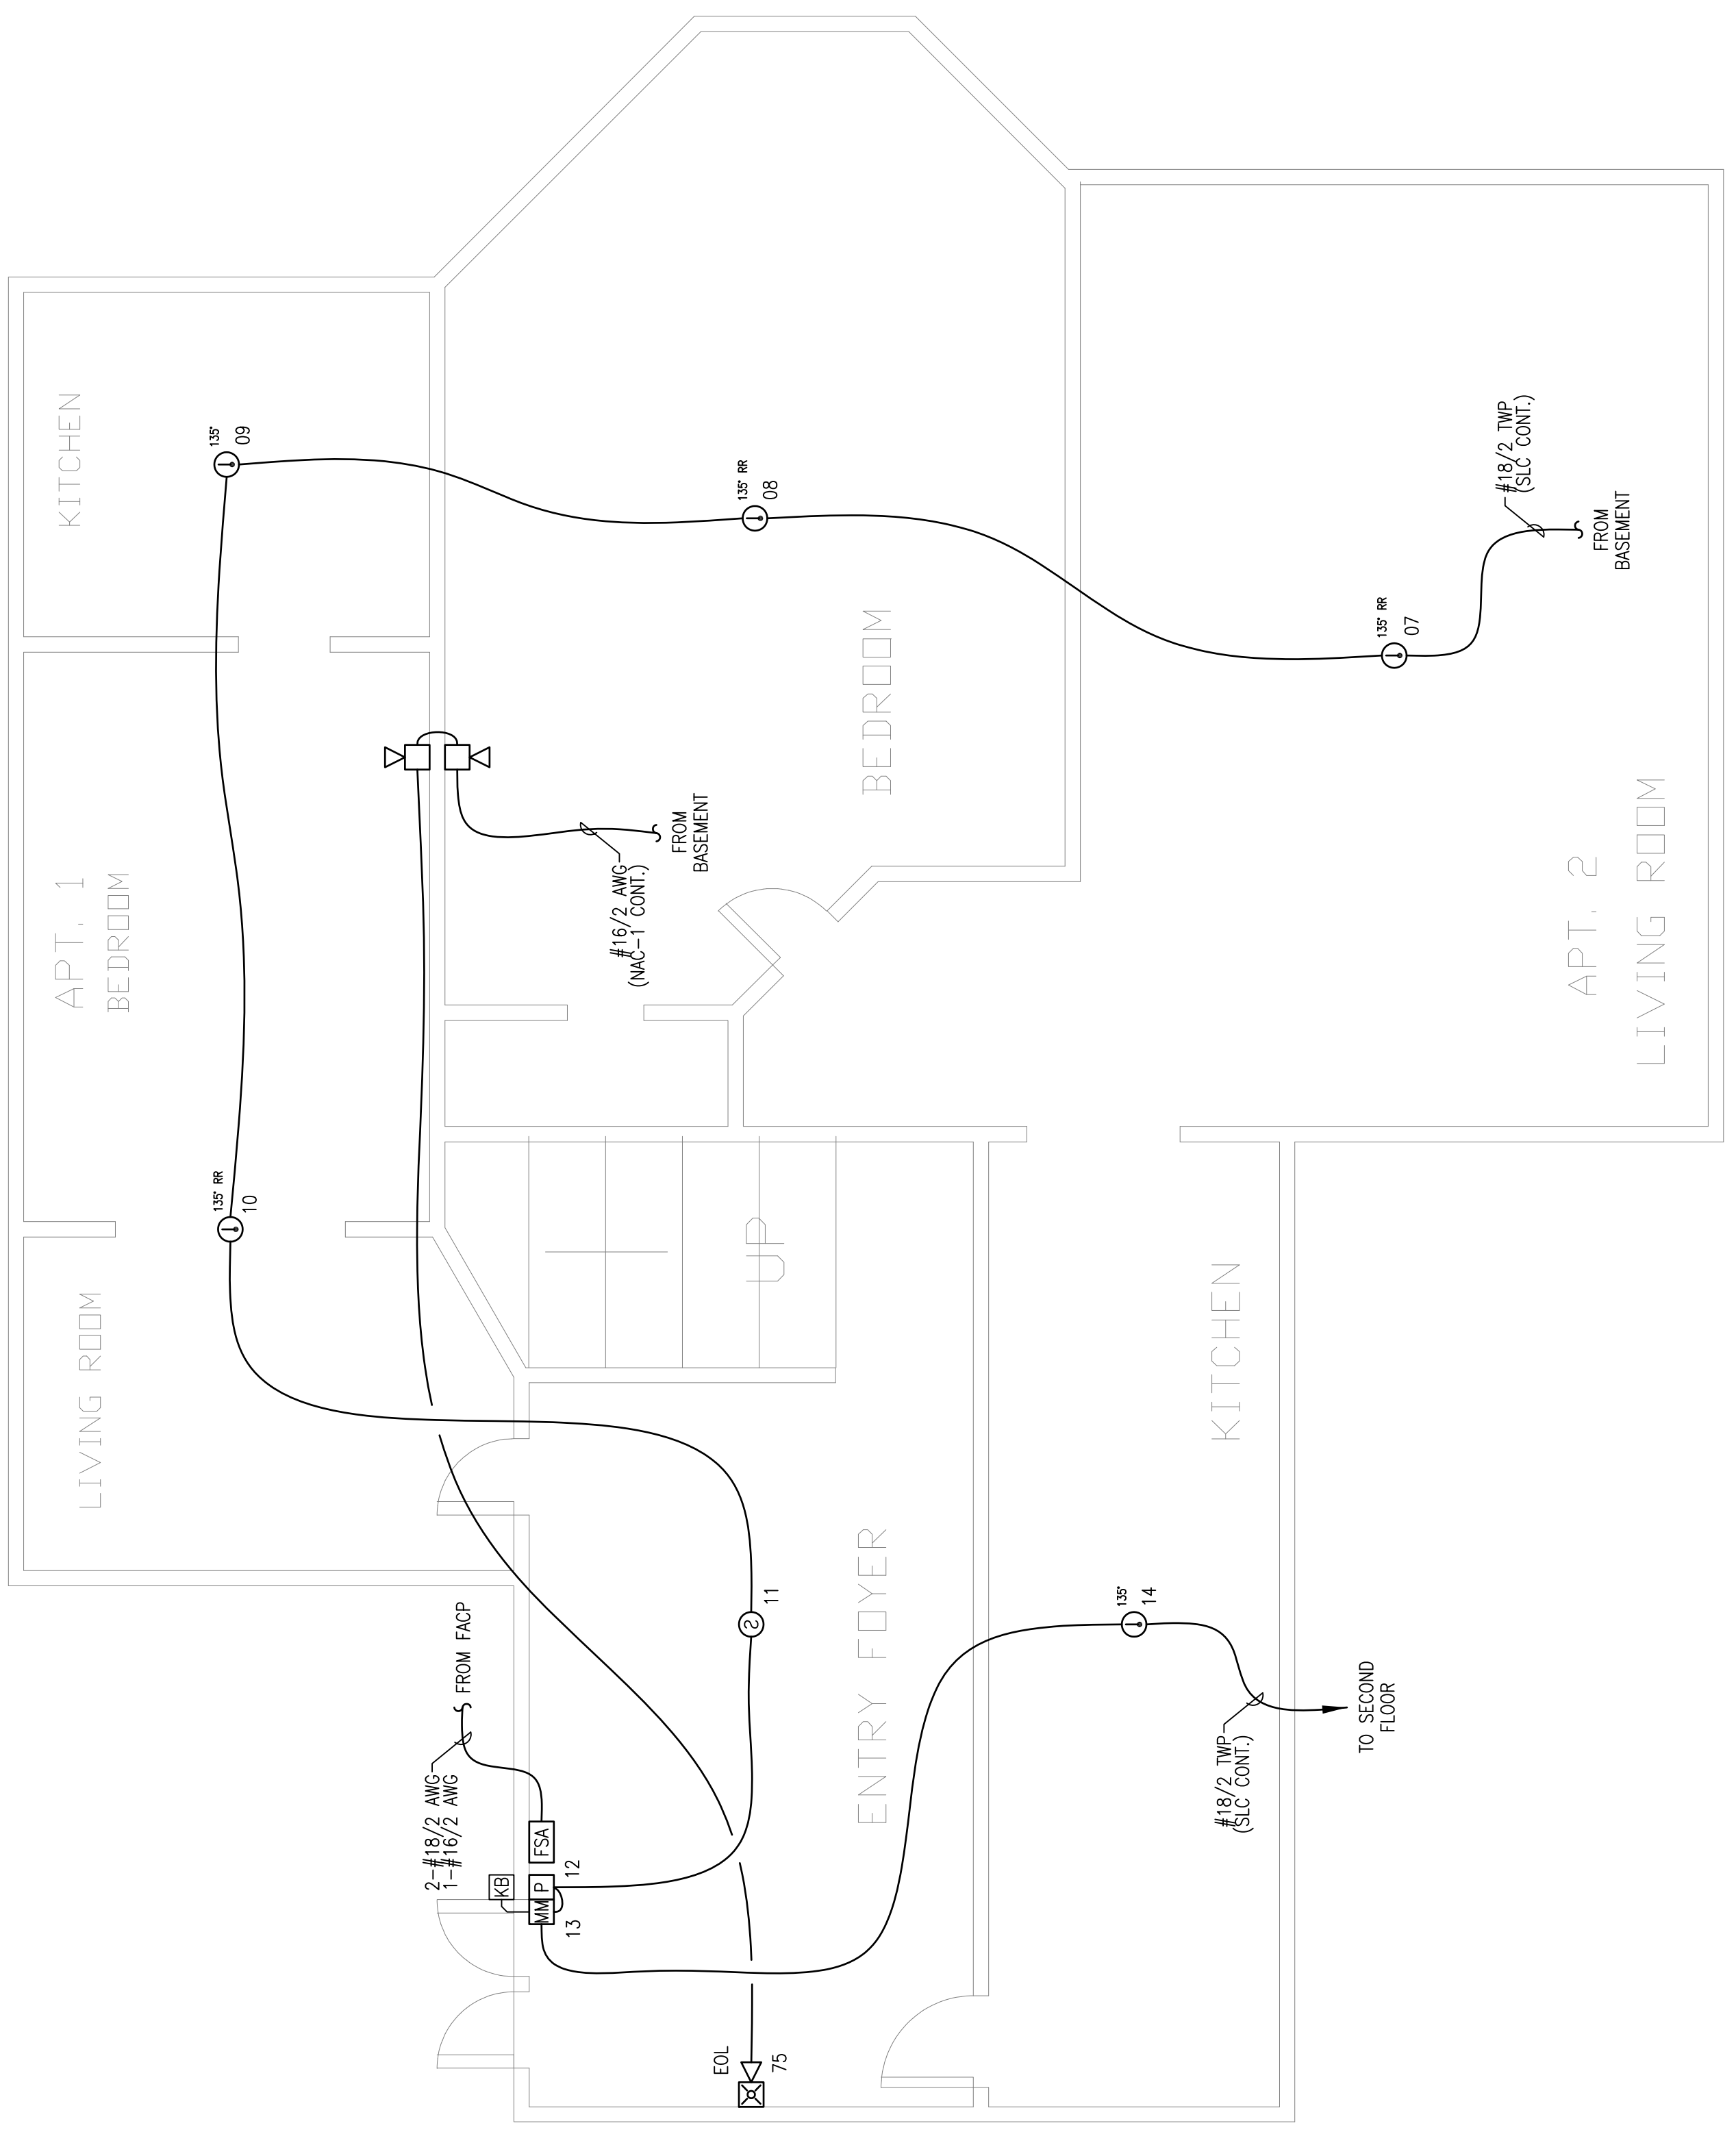

PLAN NORTH 

FIRST FLOOR FIRE ALARM PLAN
 SCALE: 1/4"=1'-0"