


REVISION	DESCRIPTION	DATE
0	ISSUED FOR REVIEW & APPROVAL	5/25/2016


SEACOAST SECURITY
 4 Summer Street • Freeport, Maine 04032
 Office: (207) 706-3369 • Fax: (207) 865-0852


147 PEARL STREET
PORTLAND, MAINE 04101
SECOND FLOOR FIRE ALARM PLAN


DRAWN	JPB UNICAD JOB #16370
CHECKED	WAYNE B. HAWES NCEET # 90496
DATE	5/25/2016
REVISION	0
SCALE	1/4"=1'-0"

FA-4

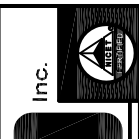
UNICAD
 Fire Alarm Design & Drafting Services
 www.unicad.net
 578 W. 40th St.
 Portland, ME 04102
 Office: 601.865.6410

RESERVED FOR CITY STAMP

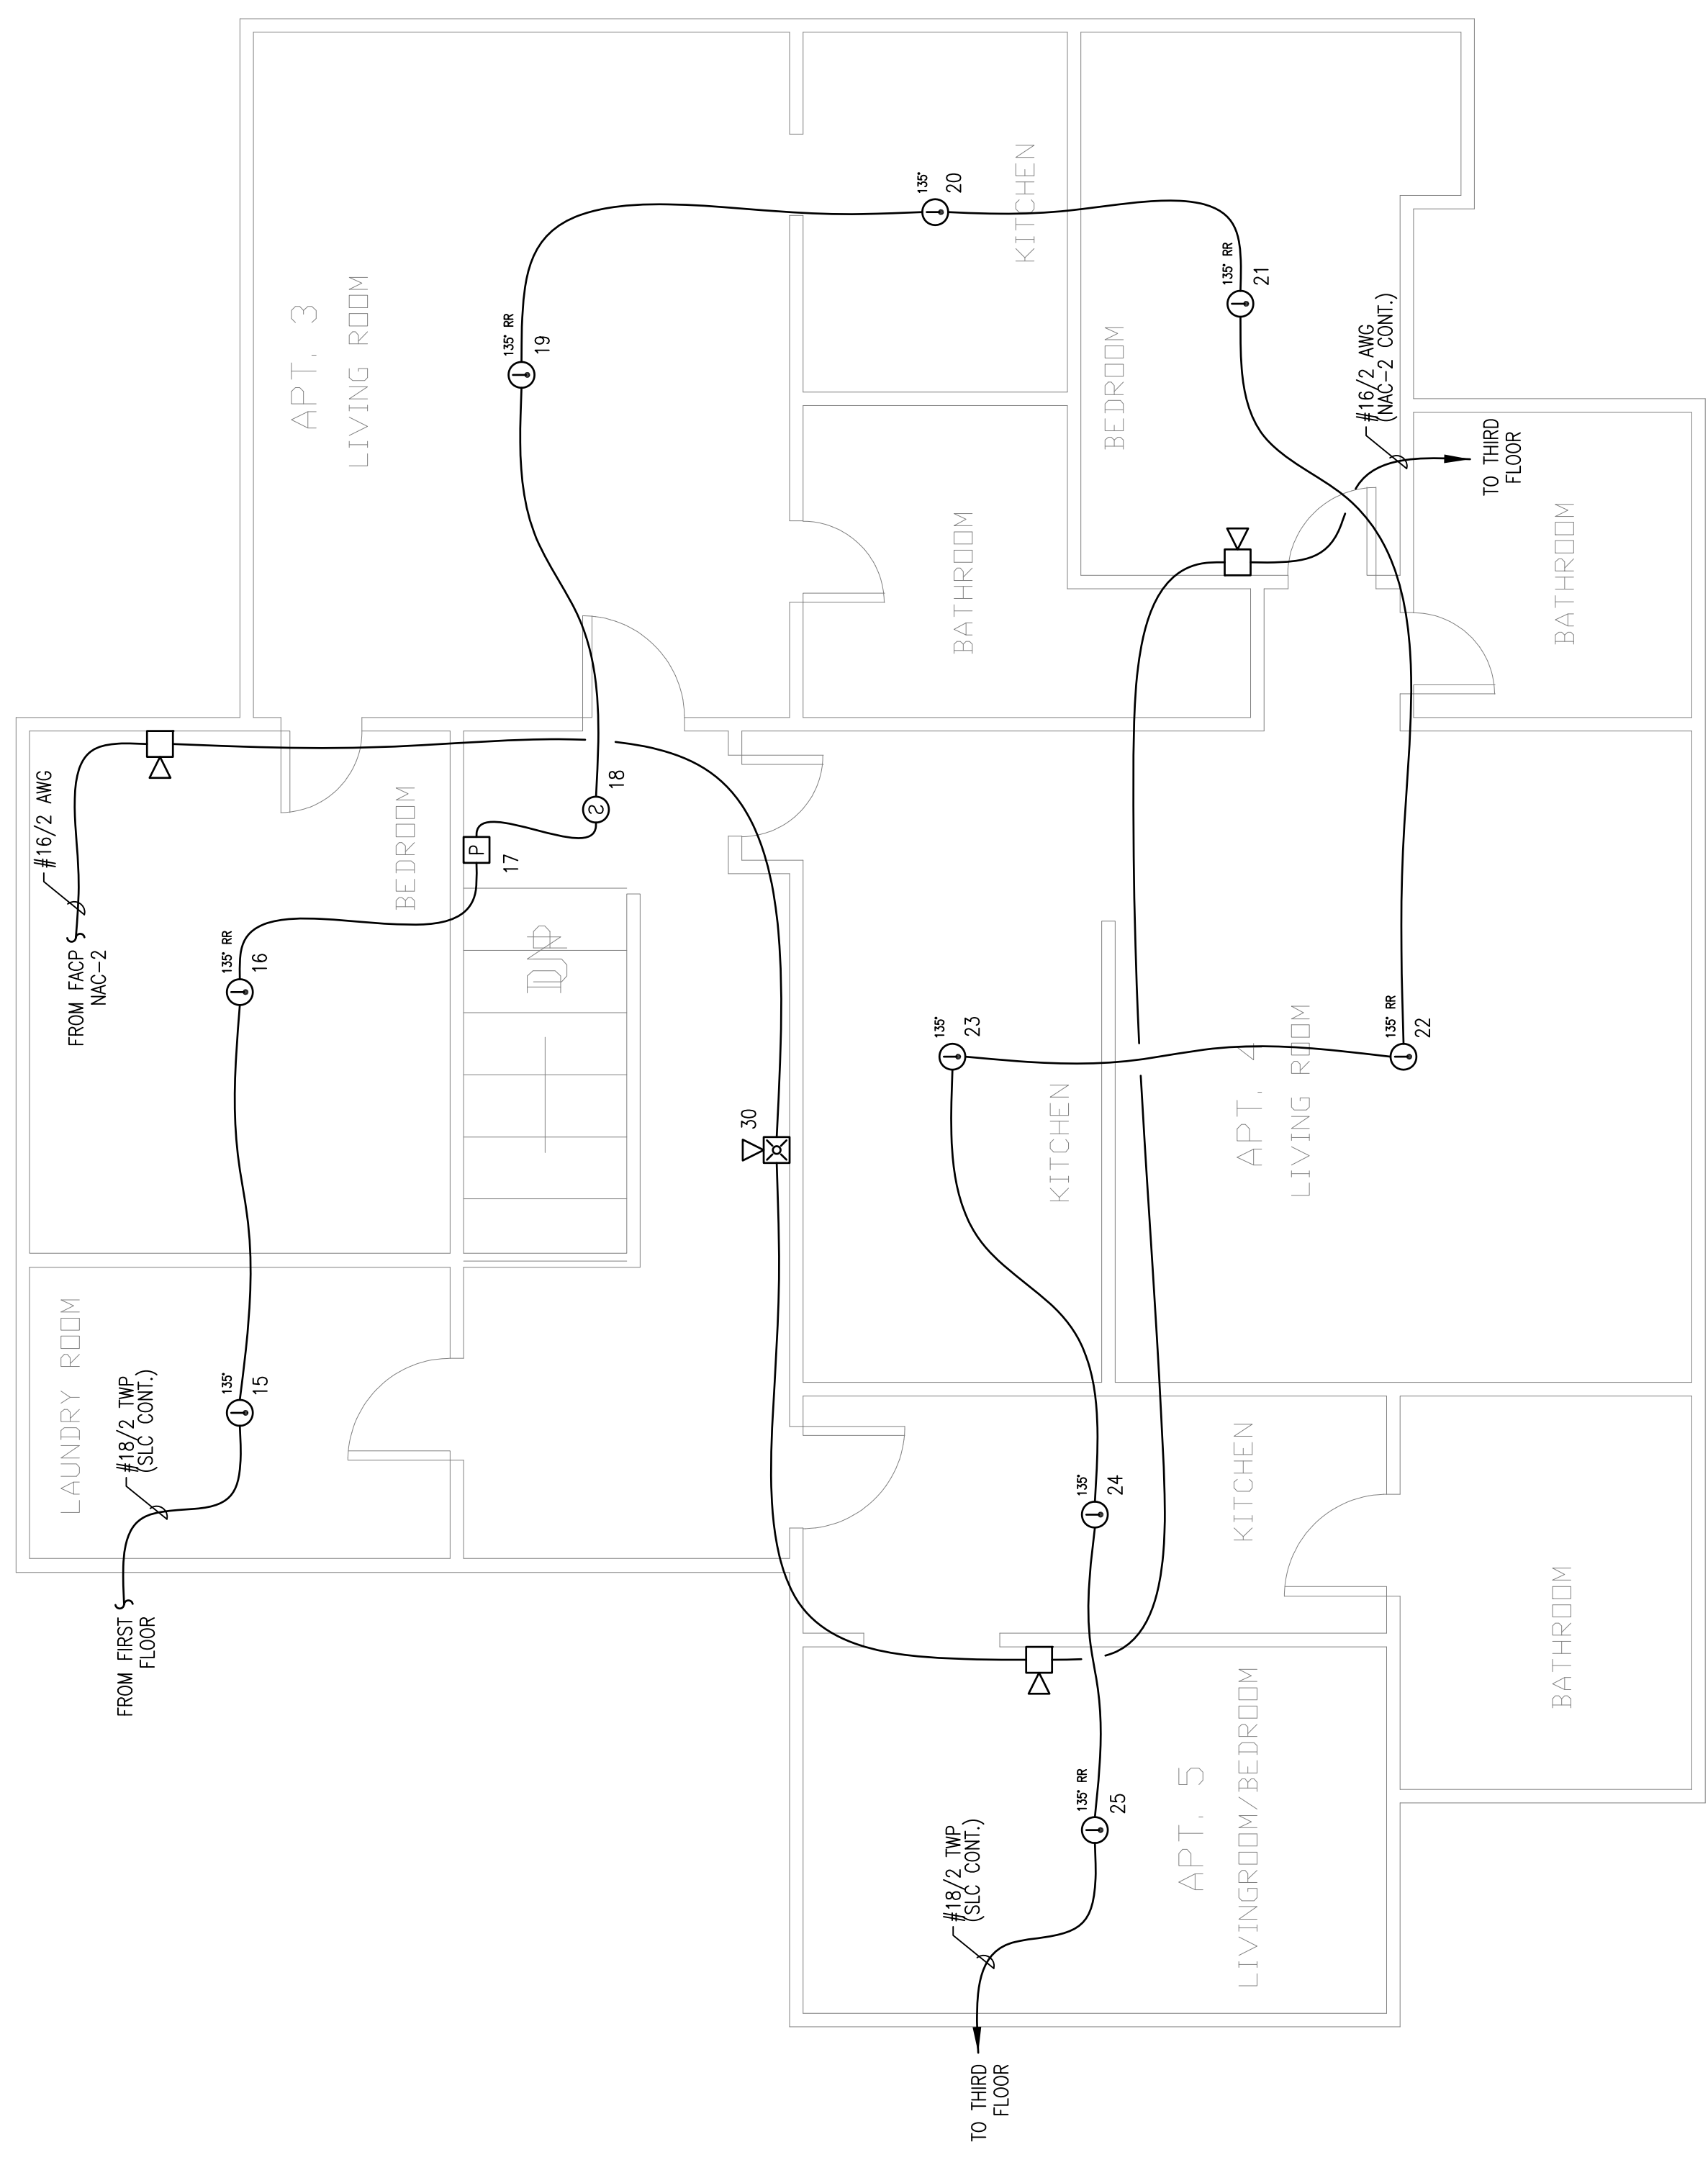

DRAWN WITH  **SECOND FLOOR FIRE ALARM PLAN**
 SCALE: 1/4"=1'-0"