

REVISION	DESCRIPTION	DATE
0	ISSUED FOR REVIEW & APPROVAL	5/25/2016


RESERVED FOR CITY STAMP


  
**SEACOAST SECURITY**  
 4 Summer Street • Freeport, Maine 04032  
 Office: (207) 706-3369 • Fax: (207) 865-0852

**147 PEARL STREET**  
**PORTLAND, MAINE 04101**  
**FOURTH FLOOR FIRE ALARM PLAN**

DRAWN	JPB UNICAD JOB #16370
CHECKED	WAYNE B. HAWES NCEET # 90496
DATE	5/25/2016
REVISION	0
SCALE	1/4"=1'-0"

**FA-6**

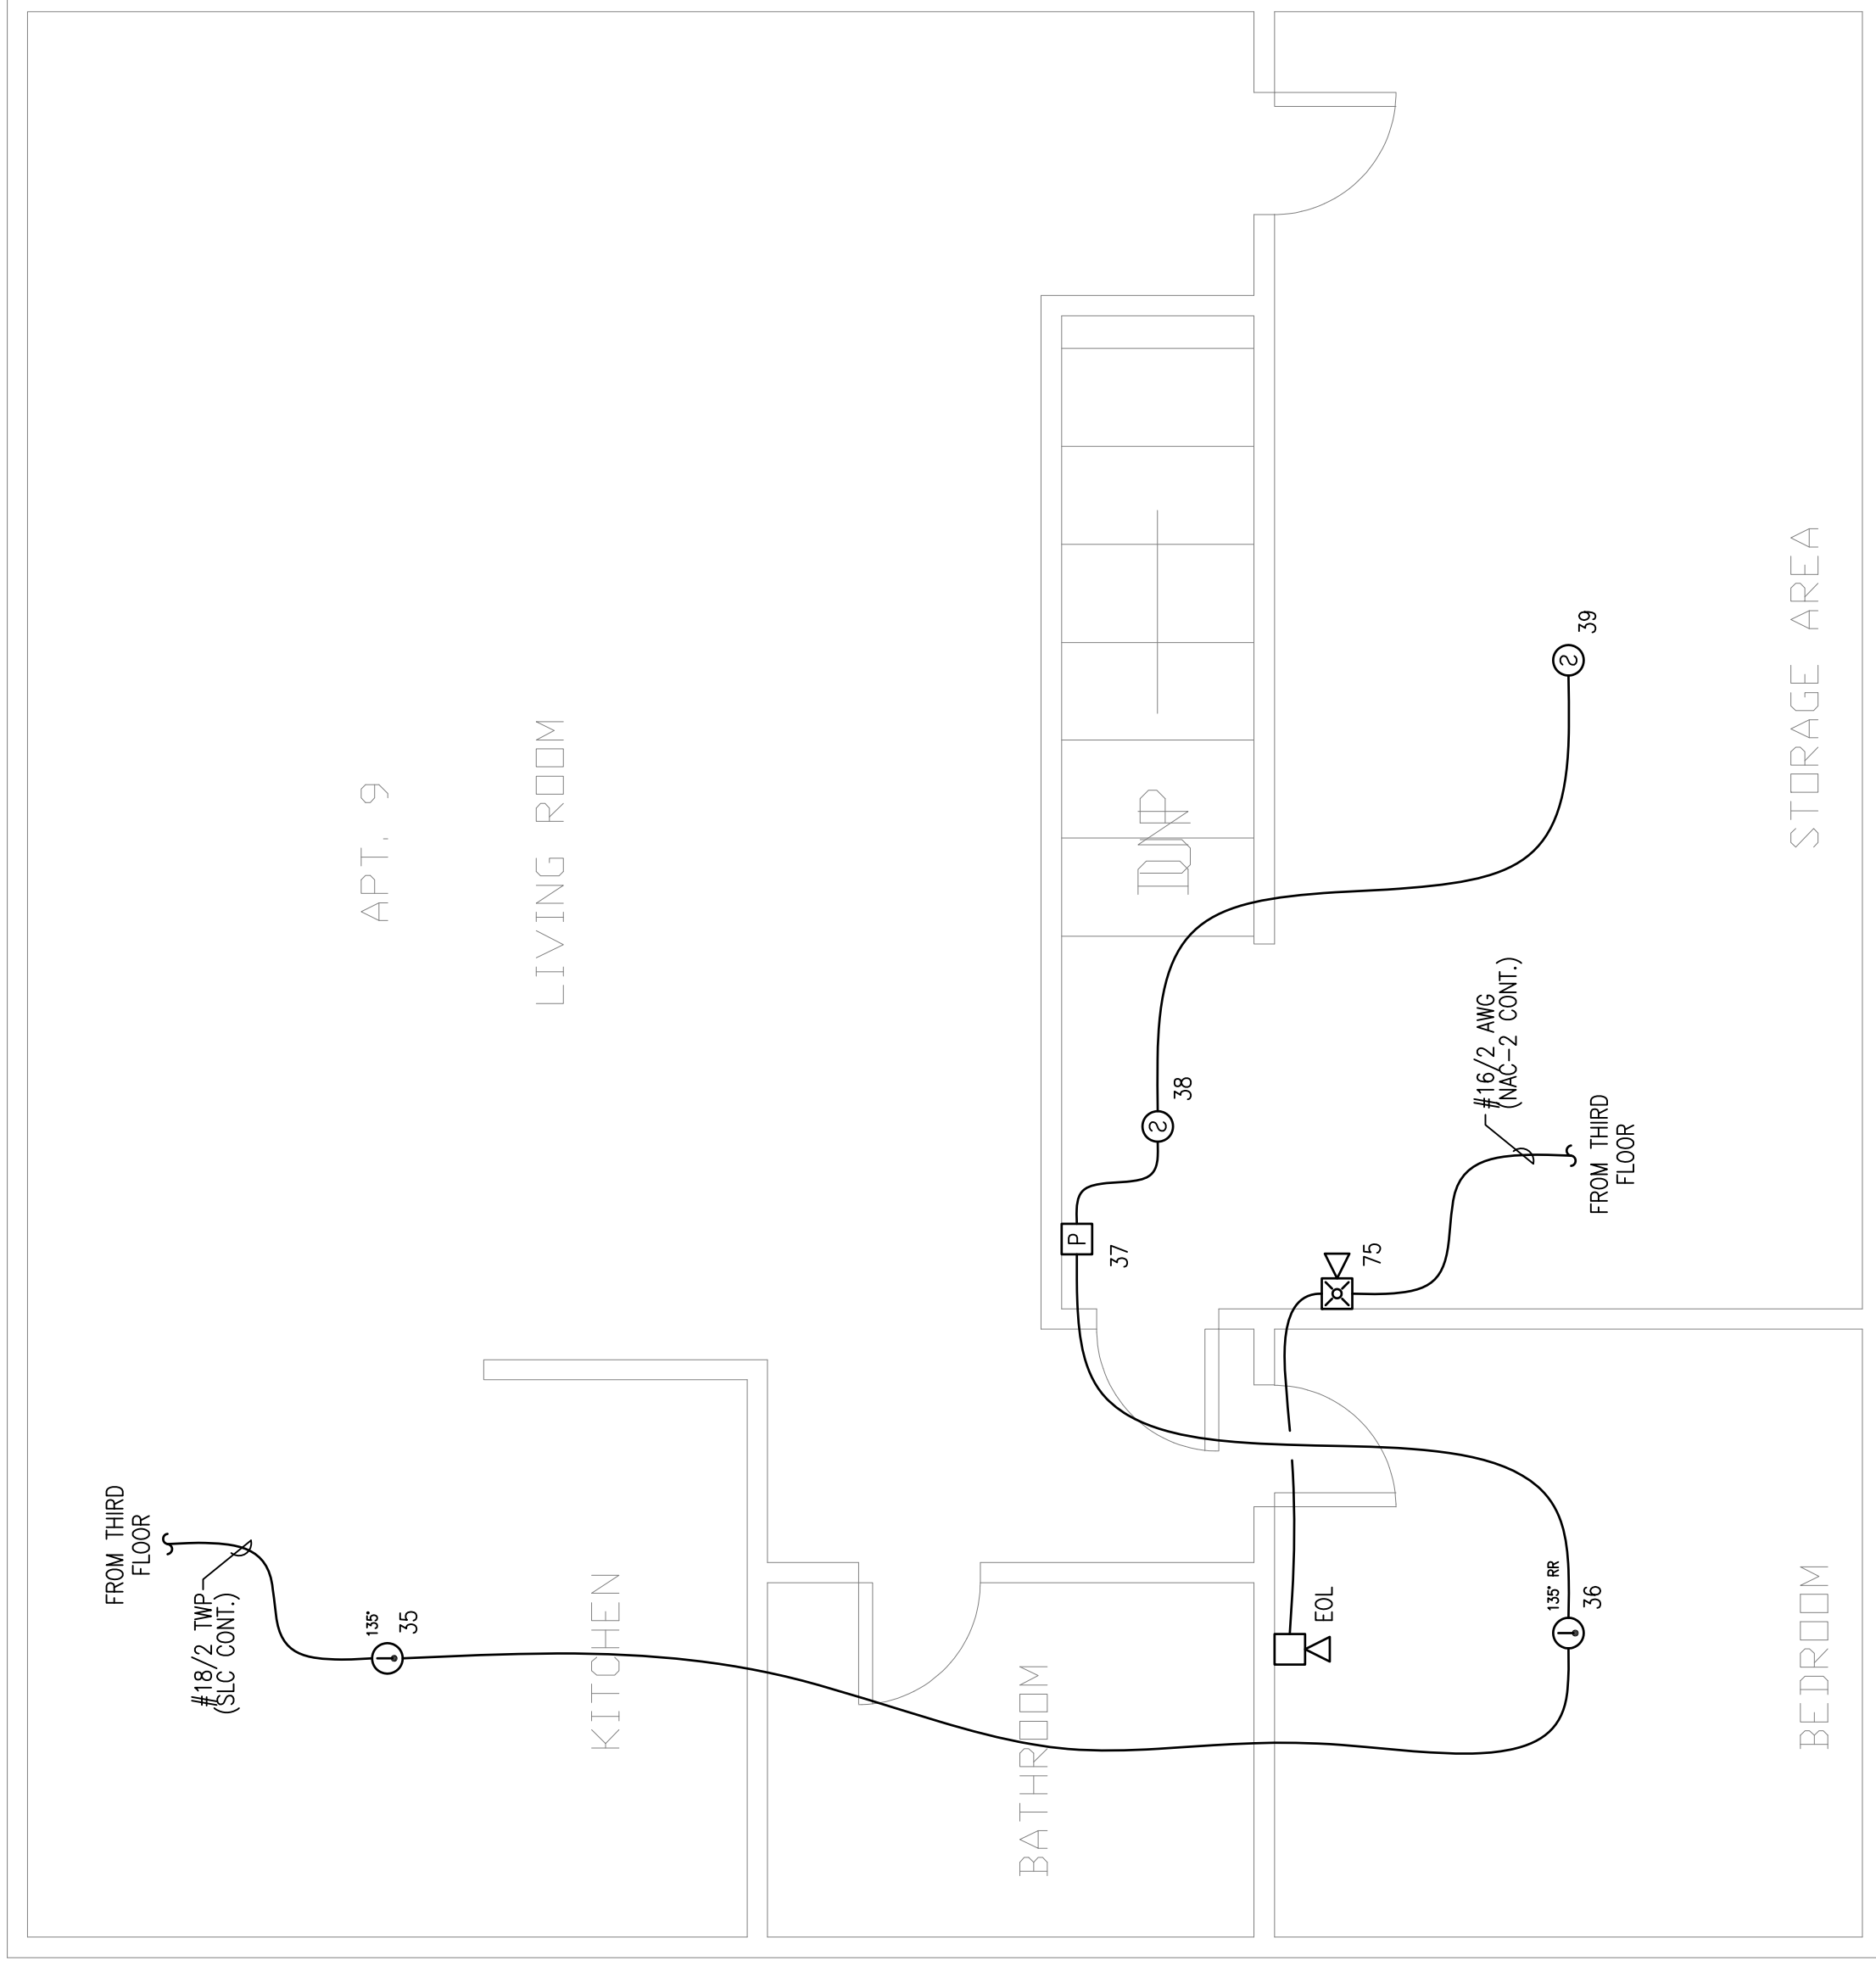

PLAN NORTH  
**FOURTH FLOOR FIRE ALARM PLAN**  
 SCALE: 1/4"=1'-0"