


**ROOF PLAN**

22x34 SCALE: 1/16"=1'-0"  
11x17 SCALE: 1/32"=1'-0"



0 8'-0" 16'-0" 32'-0" 48'-0"

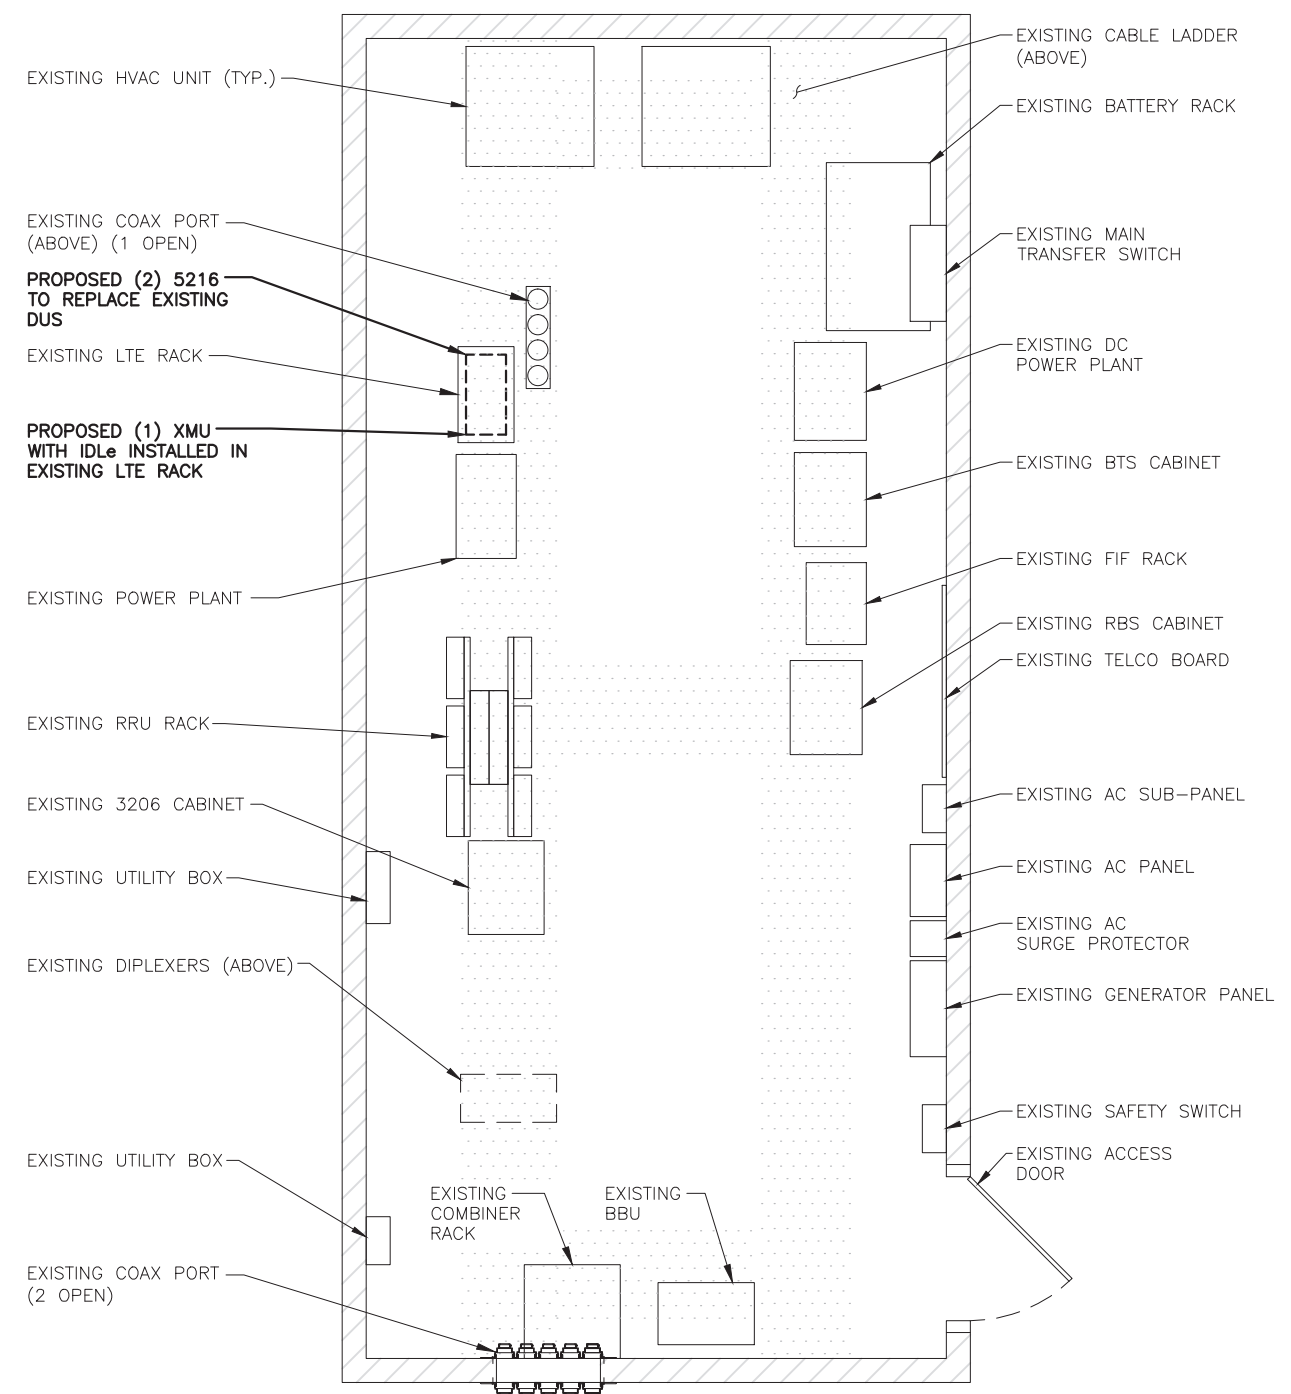

**EQUIPMENT ROOM PLAN**

22x34 SCALE: 1/2"=1'-0"  
11x17 SCALE: 1/4"=1'-0"



0 1'-0" 2'-0" 4'-0" 6'-0"

**HG HUDSON**  
Design Group LLC  
45 BEECHWOOD DRIVE  
NORTH ANDOVER, MA 01845  
TEL: (978) 557-5553  
FAX: (978) 336-5586


**EMPIRE telecom**  
16 ESQUIRE ROAD  
BILLERICA, MA 01862  
TEL: (978) 608-8400

**SITE NUMBER: ME5040**  
**SITE NAME: MUNJOY HILL**  
211 CUMBERLAND AVENUE  
PORTLAND, ME 04101  
CUMBERLAND COUNTY

**at&t**  
550 COCHITUATE ROAD  
FRAMINGHAM, MA 01701

NO.	DATE	REVISIONS	BY	CHK	APP'D
0	11/28/17	ISSUED FOR CONSTRUCTION	CL	JC	CL
1	11/16/17	ISSUED FOR REVIEW	CL	JC	CL

SCALE: AS SHOWN    DESIGNED BY: JC    DRAWN BY: CL

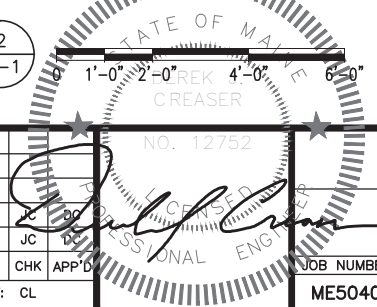

**AT&T**  
**ROOF & EQUIPMENT PLANS**  
**(LTE 6C/FN/2RRH)**  
JOB NUMBER: ME5040  
DRAWING NUMBER: A-1  
REV: 0