

FIRE ALARM TRANSPONDER PANEL



CABINET #1 - EIGHTH FLOOR
ROOM BEHIND ELEVATORS

SCALE: NTS

- BAY 1 TERMINATIONS**
- B 1** FROM FAA IN ENTRY VESTIBULE
 - B 2** TO FACP ON 1ST FLOOR
 - M 1** T1-M2(L1)
 - M 2** T1-M2(L1)
 - M 3** T1-M2(L2)
 - M 4** T1-M2(L2) RETURN
 - M 5** T1-M2(L3)
 - M 6** T1-M2(L3) RETURN
 - M 7** T1-M2(L4)
 - M 8** T1-M2(L4) RETURN
 - S 1** TO FACP ON 1ST FLR
 - S 2** FROM FACP ON 1ST FLR
 - A 1R** T1-A1 RETURN
 - A 1** T1-A1
 - H 1** SOUNDER BASE CKT T1-H1
 - H 1R** SOUNDER BASE CKT T1-H1 RETURN

- BAY 2 TERMINATIONS**
- A 2** T1-A1.2
 - A 2R** T1-A1.2 RETURN
 - A 3** T1-A1.3
 - A 3R** T1-A1.3 RETURN
 - A 4R** T1-A2.1 RETURN
 - A 4** T1-A2.1
 - A 5R** T1-A2.2 RETURN
 - A 5** T1-A2.2
 - H 2** SOUNDER BASE CKT T1-H1
 - H 2R** SOUNDER BASE CKT T1-H1 RETURN


- BAY 3 TERMINATIONS**
- A 6** T1-A2.3
 - A 6R** T1-A2.3 RETURN
 - A 7** T1-A3.1
 - A 7R** T1-A3.1 RETURN
 - A 8R** T1-A3.3 RETURN
 - A 8** T1-A3.3
 - A 9R** T1-A3.2 RETURN
 - A 9** T1-A3.2
 - H 3** SOUNDER BASE CKT T1-H1
 - H 3R** SOUNDER BASE CKT T1-H1 RETURN

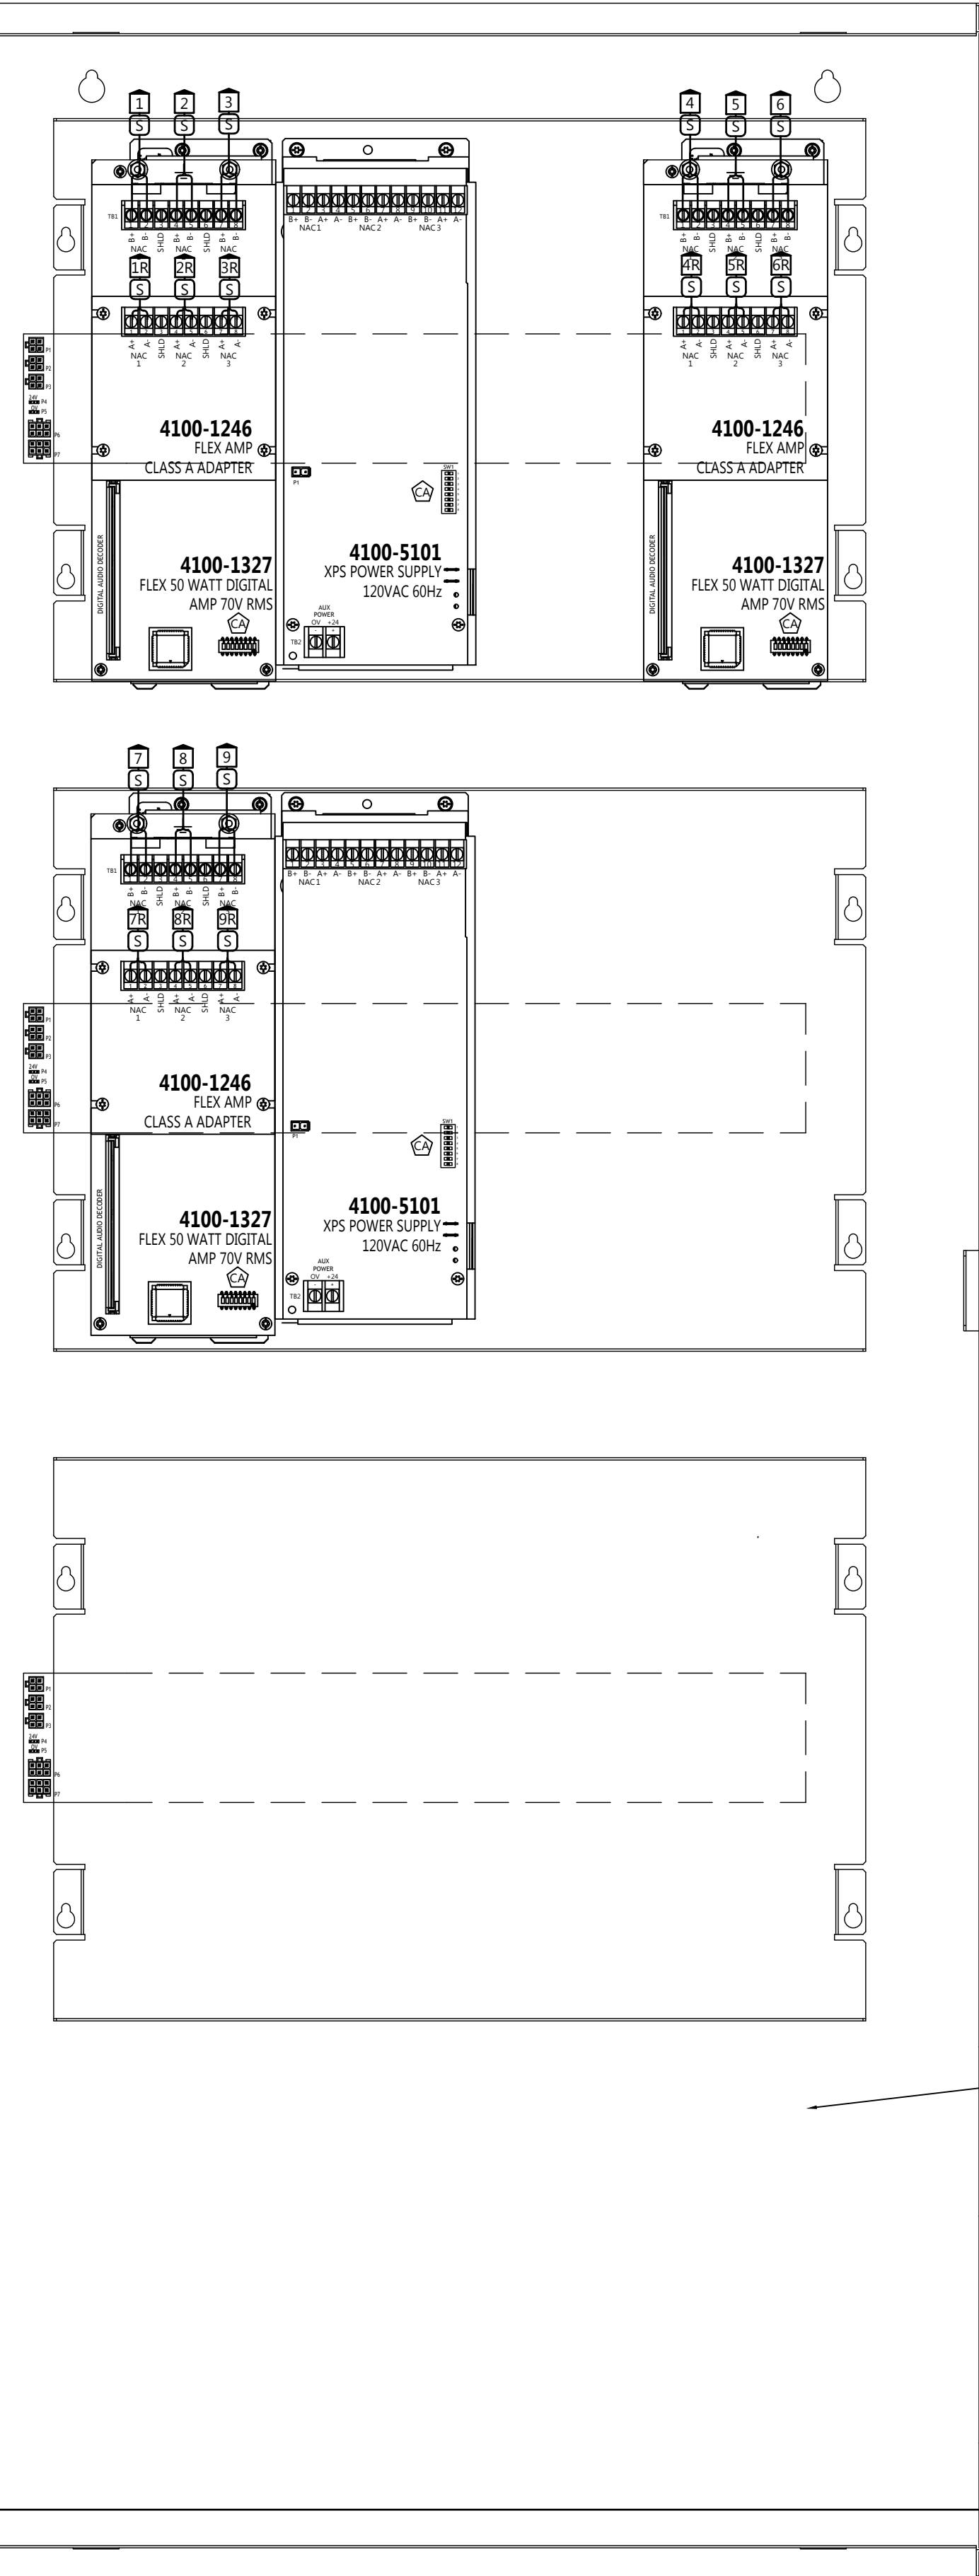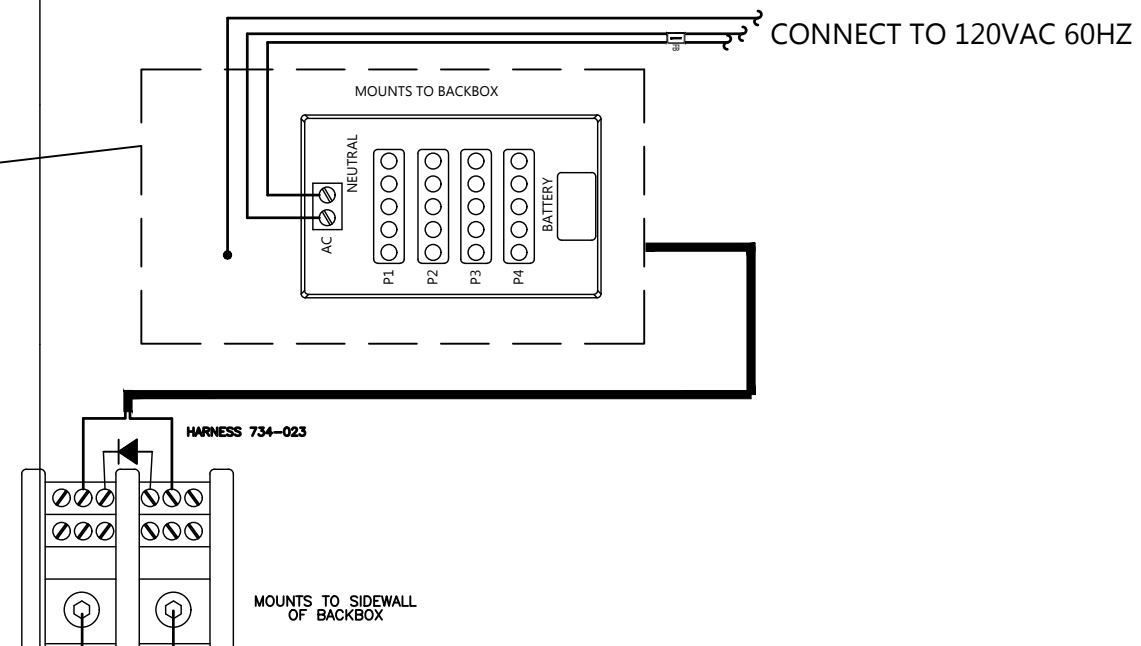

- BAY 1 TERMINATIONS**
- S 1** SPEAKER T1-S1
 - S 2** SPEAKER T1-S2
 - S 3** SPEAKER T1-S3
 - S 3R** SPEAKER T1-S3 RETURN
 - S 4** SPEAKER T1-S4
 - S 4R** SPEAKER T1-S4 RETURN
 - S 5** SPEAKER T1-S5
 - S 5R** SPEAKER T1-S5 RETURN
 - S 6** SPEAKER T1-S6
 - S 6R** SPEAKER T1-S6 RETURN

- BAY 2 TERMINATIONS**
- S 7** SPEAKER T1-S7
 - S 8** SPEAKER T1-S8
 - S 9** SPEAKER T1-S9
 - S 7R** SPEAKER T1-S7 RETURN
 - S 8R** SPEAKER T1-S8 RETURN
 - S 9R** SPEAKER T1-S9 RETURN

- BAY 3 TERMINATIONS**

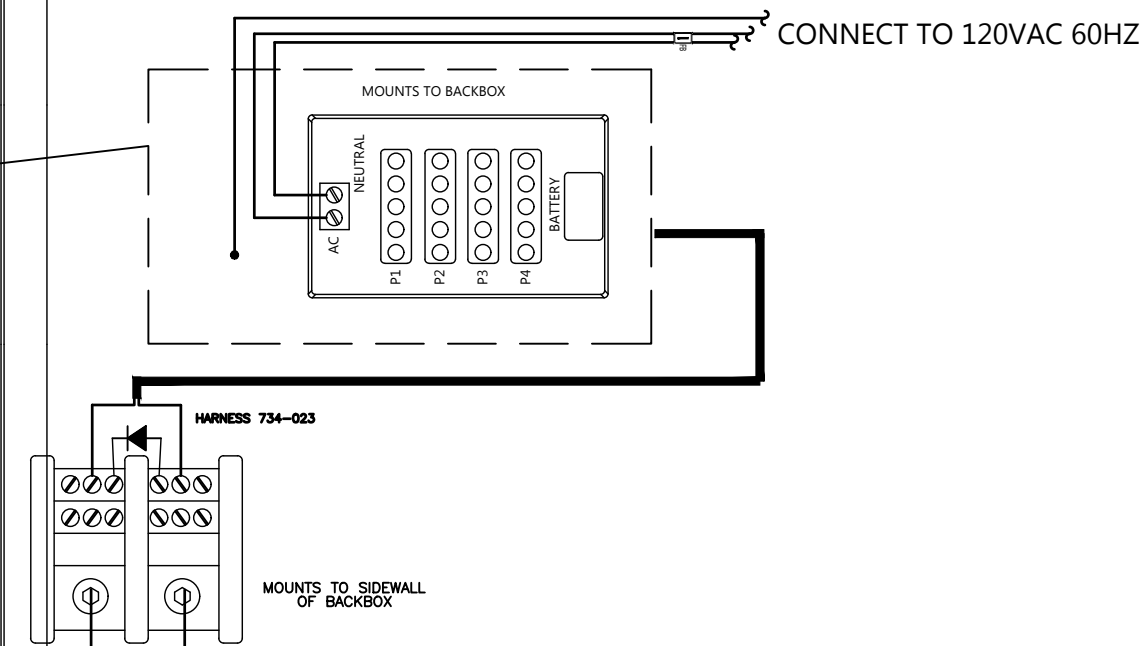

FIRE ALARM TRANSPONDER PANEL

CABINET #2 - EIGHTH FLOOR
ROOM BEHIND ELEVATORS

SCALE: NTS

tyco
SimplexGrinnell

Safer. Smarter. Tyco.™

DISTRICT - 147
WESTBROOK, ME 04092
SERVICE 207-842-6440

PHONE 207-842-6440
FAX 207-842-6439

FRANKLIN TOWERS

FRANKLIN TOWERS
211 CUMBERLAND AVE
PORTLAND, ME 04101

ISSUE LOG	MARK	DATE	CAD	CHK	DESCRIPTION

DRAWN BY: J. DELACRUZ
CHECKED BY: A. ONEAL
ISSUE DATE: 1/19/18
JOB #: 147-604032801
PROJECT #: TYCO SIMPLEXGRINNELL © 2018

SYSTEM: **FIRE ALARM SYSTEM**

SHEET: **TRANSPONDER PANEL DETAIL**

FA-502

IMPORTANT NOTICE TO USER: By accepting this drawing, the user agrees to the terms and conditions of the license. This drawing is provided for the project for which it was prepared and is not to be used for any other project or purpose without the express written consent of Tyco SimplexGrinnell. Tyco SimplexGrinnell makes no warranty, representation or guarantee of the information contained herein and shall not be liable for any errors or omissions. The information may not be sold or transferred to any third party, used in other projects or added to the project for which it was prepared, without the express written consent of Tyco SimplexGrinnell. Tyco SimplexGrinnell reserves the right to modify or discontinue this product without notice. Tyco SimplexGrinnell makes no warranty, representation or guarantee of the information contained herein and shall not be liable for any errors or omissions. The information may not be sold or transferred to any third party, used in other projects or added to the project for which it was prepared, without the express written consent of Tyco SimplexGrinnell. Tyco SimplexGrinnell reserves the right to modify or discontinue this product without notice.