

# POWER PAY OFFICE FIT UP

Winton Scott  
Architects  
5 Milk Street  
Portland, Maine 04101

Wright Ryan  
Construction, Inc.  
10 Danforth Street  
Portland, Maine 04101

Becker Structural  
Engineers, Inc.  
75 York Street  
Portland, Maine 04101

Mechanical  
Systems  
Engineers  
10 Royal River Center  
Yarmouth, Maine 04096



Bartlett Design  
942 Washington Ave.  
Bath, Maine 04530

Fore Solutions  
386 Fore Street  
Portland, Maine 04101

## SECOND FLOOR HEATING PIPING PLAN

# M12

Incorporates all revisions and changes  
up to and including October 09, 2009  
Scale: 3/32" = 1'-0" Date: 03.20.09  
M.S.E. Proj. 0931

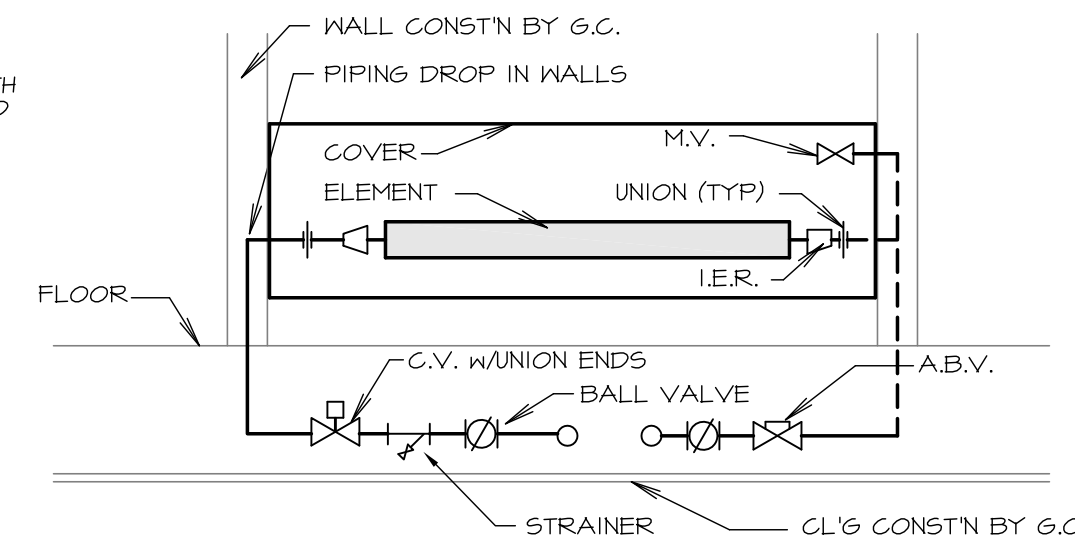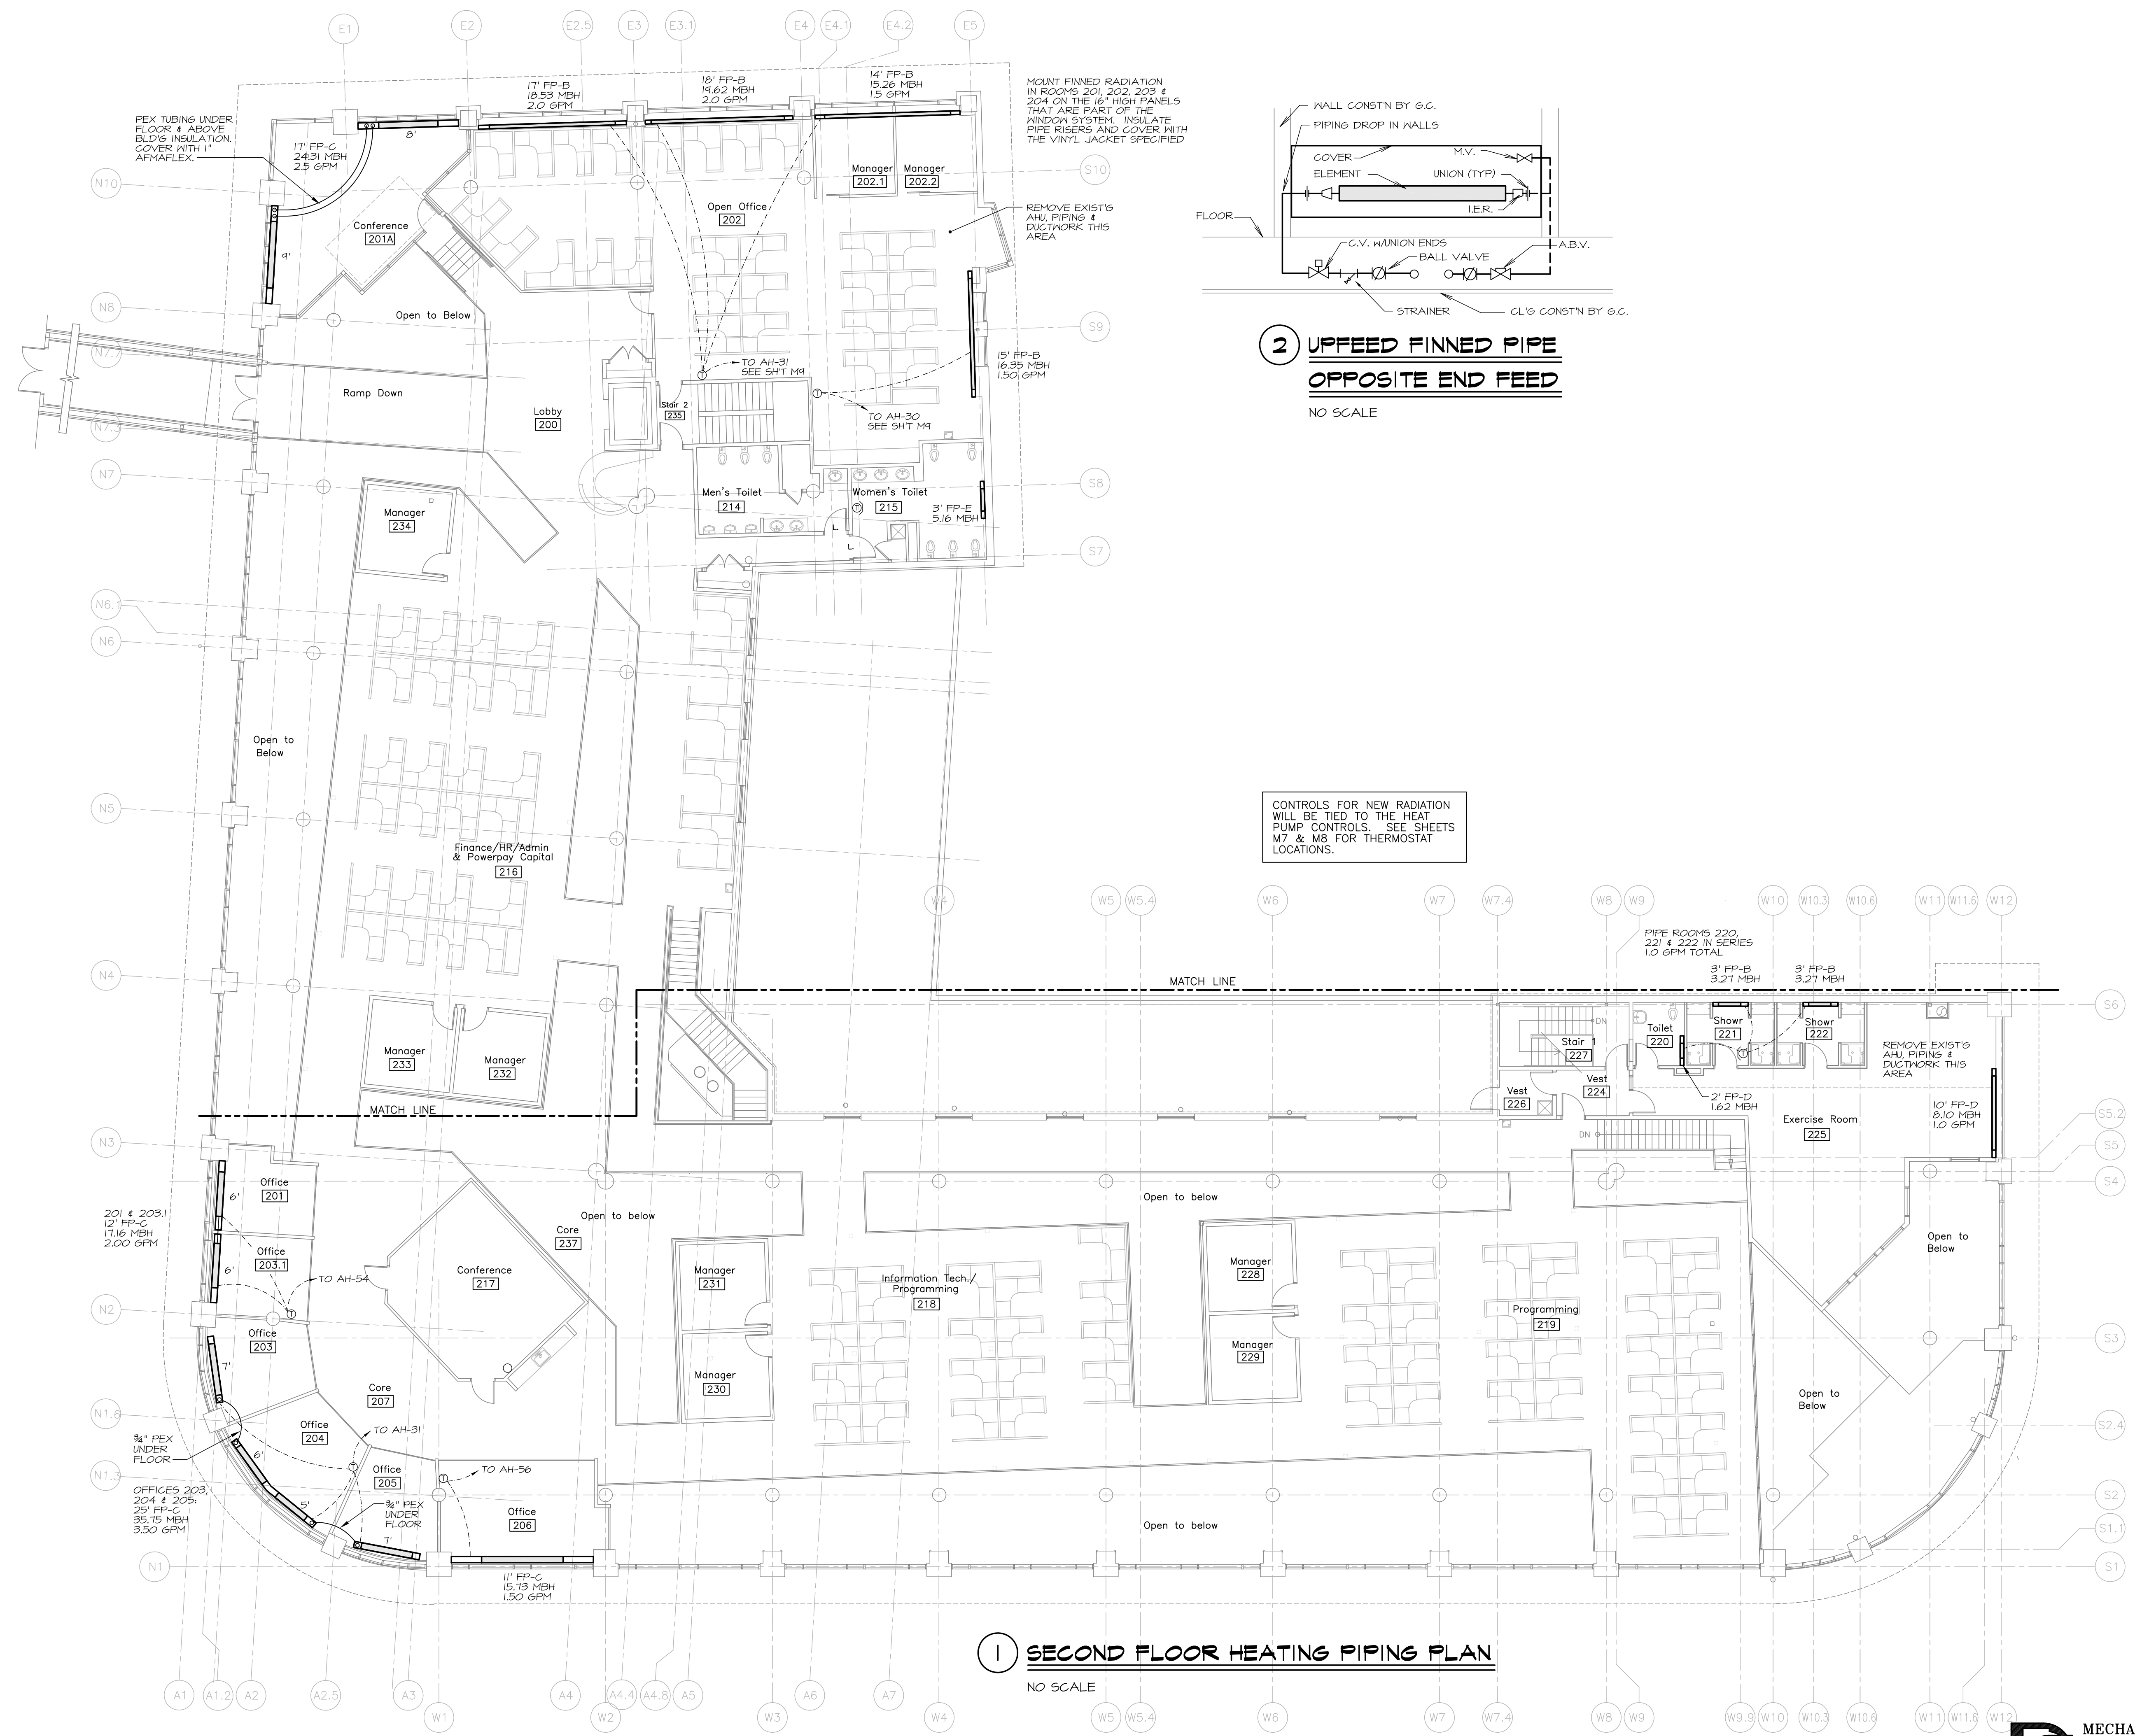

**2 UPFEED FINNED PIPE  
OPPOSITE END FEED**  
NO SCALE

CONTROLS FOR NEW RADIATION  
WILL BE TIED TO THE HEAT  
PUMP CONTROLS. SEE SHEETS  
M7 & M8 FOR THERMOSTAT  
LOCATIONS.

**1 SECOND FLOOR HEATING PIPING PLAN**  
NO SCALE



**MECHANICAL SYSTEMS ENGINEERS**  
ROYAL RIVER CENTER, UNIT #10  
10 FOREST FALLS DRIVE  
YARMOUTH, MAINE 04096  
VOICE: (207) 846-1441  
FAX: (207) 846-1443  
mechsyst@maine.net  
© COPYRIGHT 2009