

# POWER PAY OFFICE FIT UP

Winton Scott  
Architects  
5 Milk Street  
Portland, Maine 04101

Wright Ryan  
Construction, Inc.  
10 Danforth Street  
Portland, Maine 04101

Becker Structural  
Engineers, Inc.  
75 York Street  
Portland, Maine 04101

Mechanical  
Systems  
Engineers  
10 Royal River Center  
Yarmouth, Maine 04096


Bartlett Design  
942 Washington Ave.  
Bath, Maine 04530

Fore Solutions  
386 Fore Street  
Portland, Maine 04101

## MEZZANINE NORTH REFRIGERANT PIPING PLAN

# M9


Incorporates all revisions and changes  
up to and including October 09, 2009  
Scale: 1/8" = 1'-0" Date: 03.20.09  
M.S.E. Proj: 0931

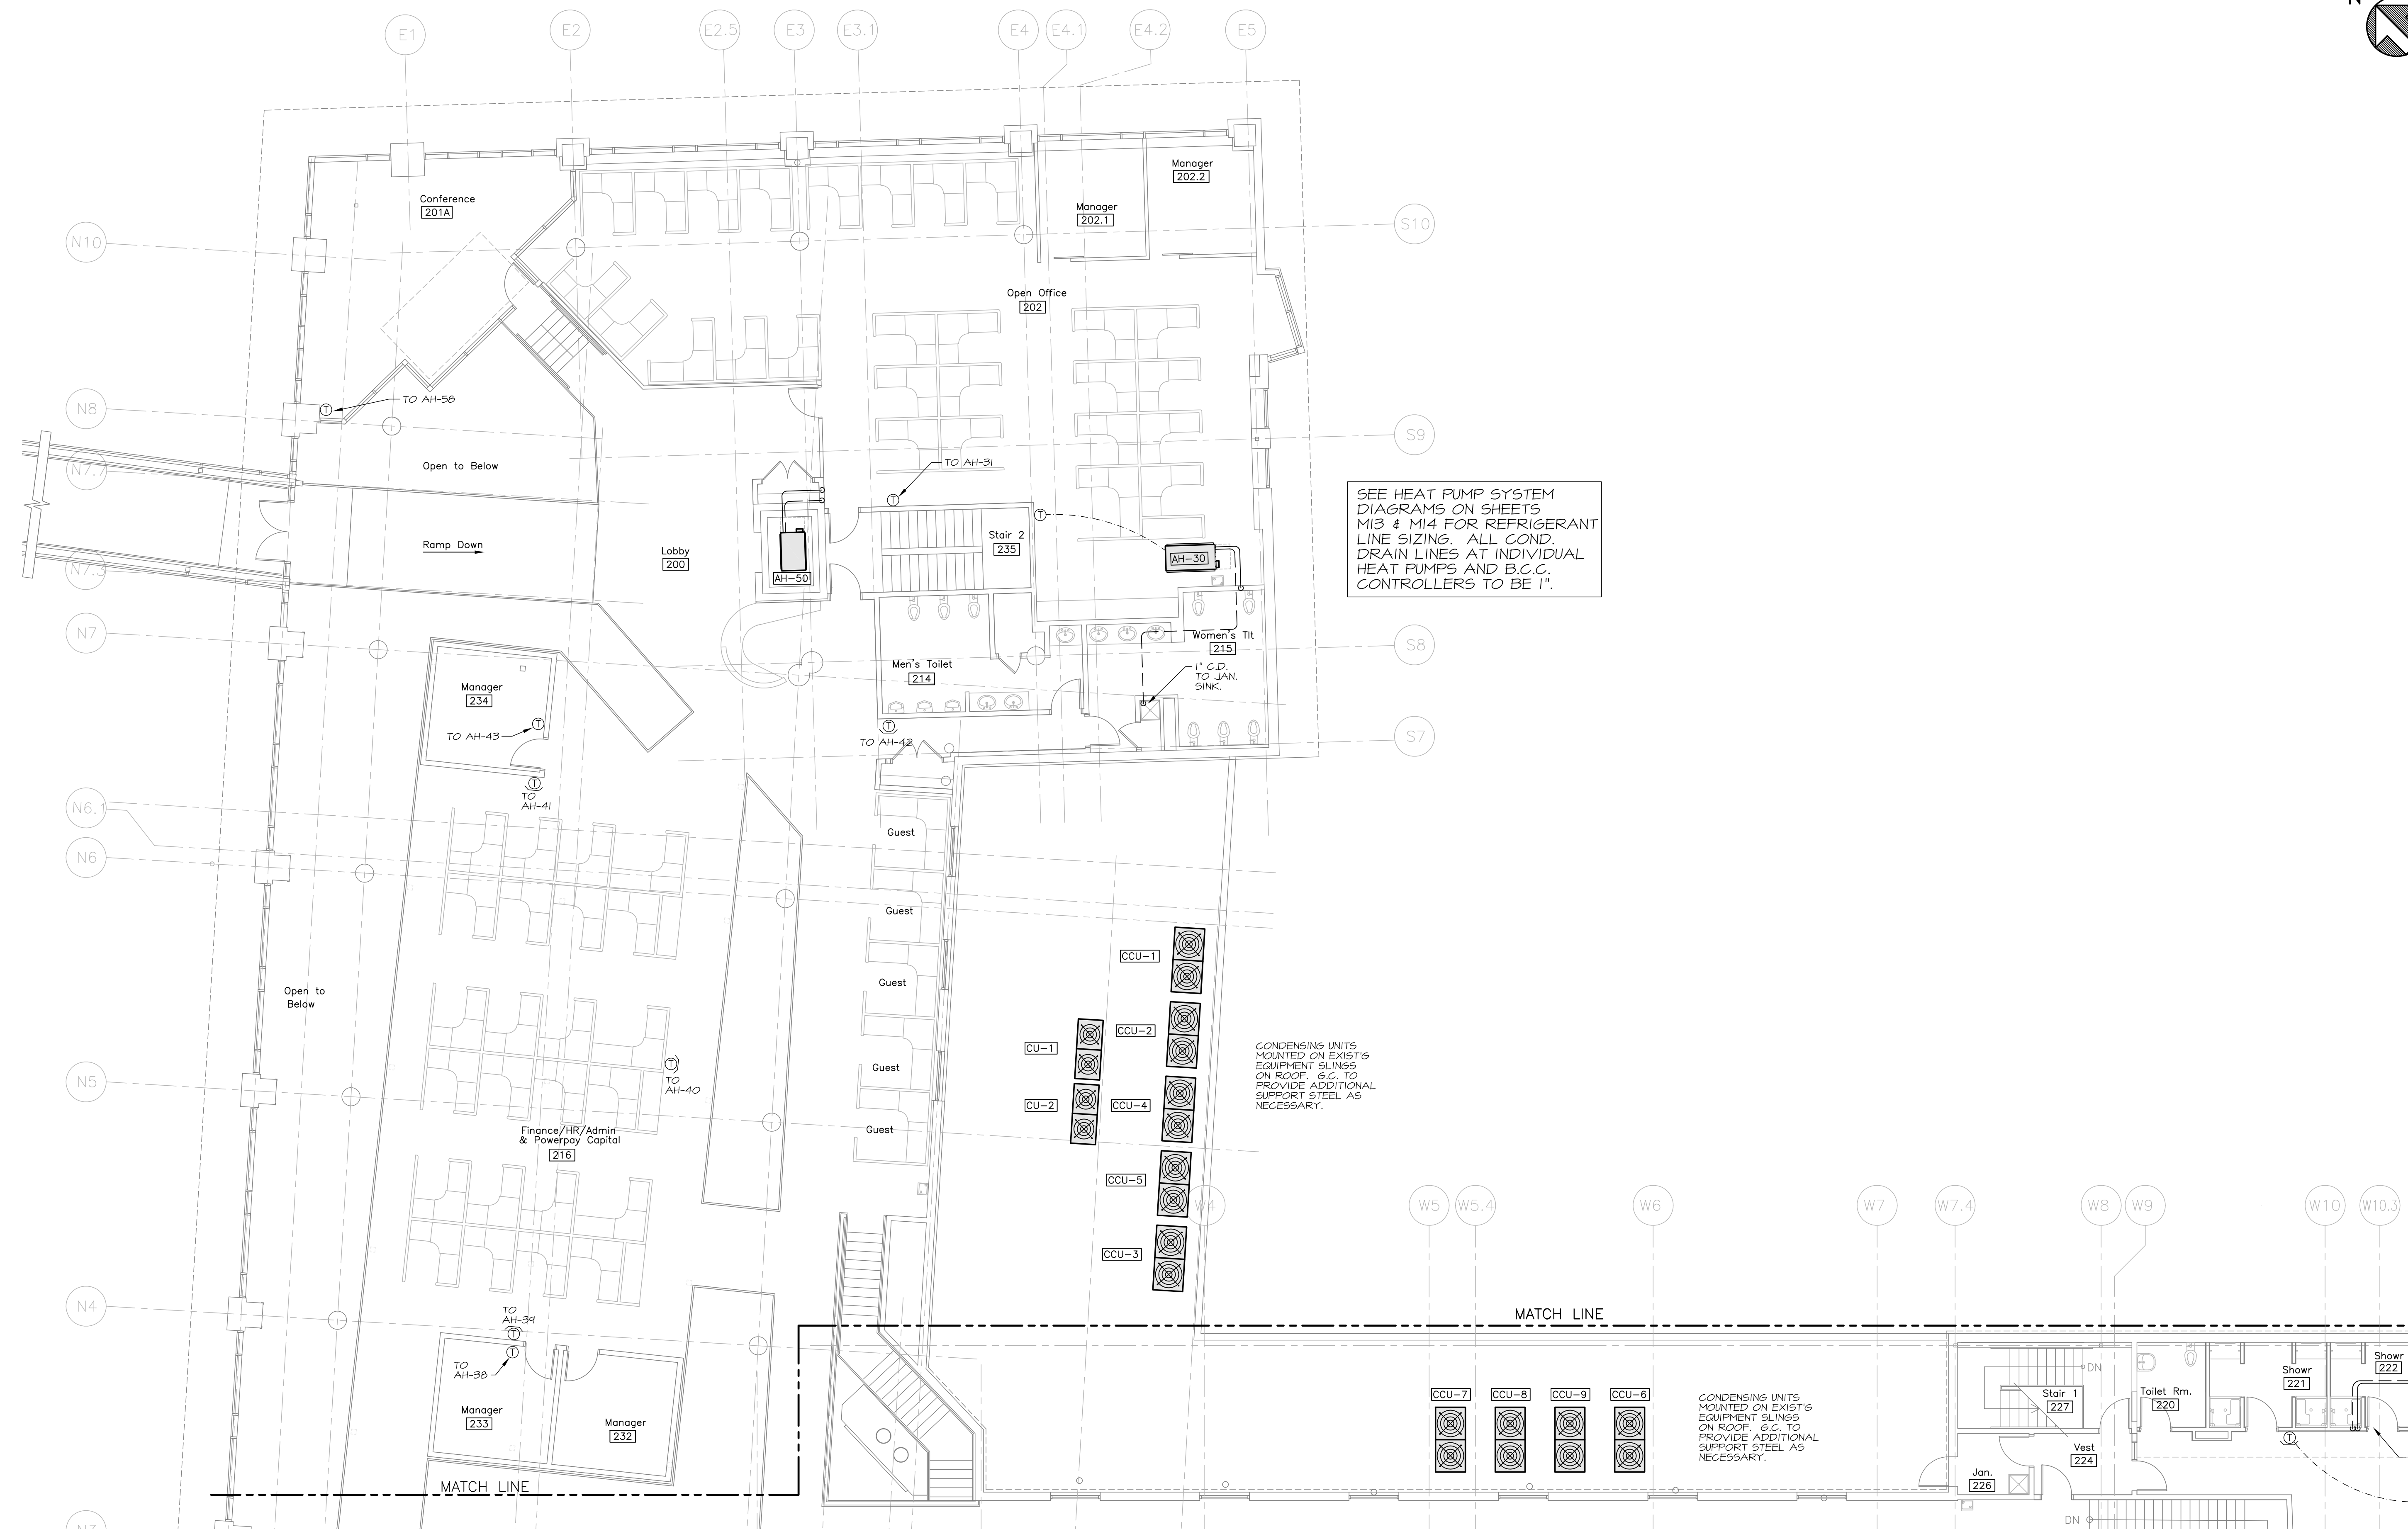

SEE HEAT PUMP SYSTEM  
DIAGRAMS ON SHEETS  
M13 & M14 FOR REFRIGERANT  
LINE SIZING. ALL COND.  
DRAIN LINES AT INDIVIDUAL  
HEAT PUMPS AND B.C.C.  
CONTROLLERS TO BE 1\".

CONDENSING UNITS  
MOUNTED ON EXIST'G  
EQUIPMENT SLINGS  
ON ROOF. S.C. TO  
PROVIDE ADDITIONAL  
SUPPORT STEEL AS  
NECESSARY.

CONDENSING UNITS  
MOUNTED ON EXIST'G  
EQUIPMENT SLINGS  
ON ROOF. S.C. TO  
PROVIDE ADDITIONAL  
SUPPORT STEEL AS  
NECESSARY.

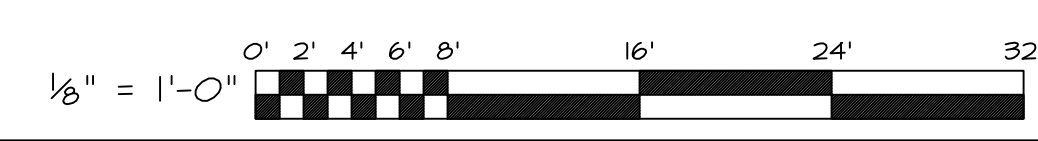

**MECHANICAL SYSTEMS ENGINEERS**  
ROYAL RIVER CENTER, UNIT #10  
10 FOREST FALLS DRIVE  
YARMOUTH, MAINE 04096  
VOICE: (207) 846-1441  
FAX: (207) 846-1443  
mechsyst@maine.me  
© COPYRIGHT 2009

October 09, 2009 - 8:41 am  
\\Meerfas\Projects\0931 Power Pay\Drawings\0931\_M7-M10.dwg