

**POWERPAY
OFFICE FIT UP**

Winton Scott
Architects
5 Milk Street
Portland, ME 04101

Wright Ryan
Construction, Inc.
10 Danforth Street
Portland, ME 04101

Becker Structural
Engineers, Inc.
75 York Street
Portland, Maine 04101

Mechanical
Systems
Engineers
10 Royal River Center
Yarmouth, Maine 04096


Bartlett Design
942 Washington Ave.
Bath, Maine 04530

Fore Solutions
386 Fore Street
Portland, Maine 04101


**BUILDING SECTION
& SKYLIGHT
DETAILS**

A2.2


Scale: As Noted Date: 3.20.09

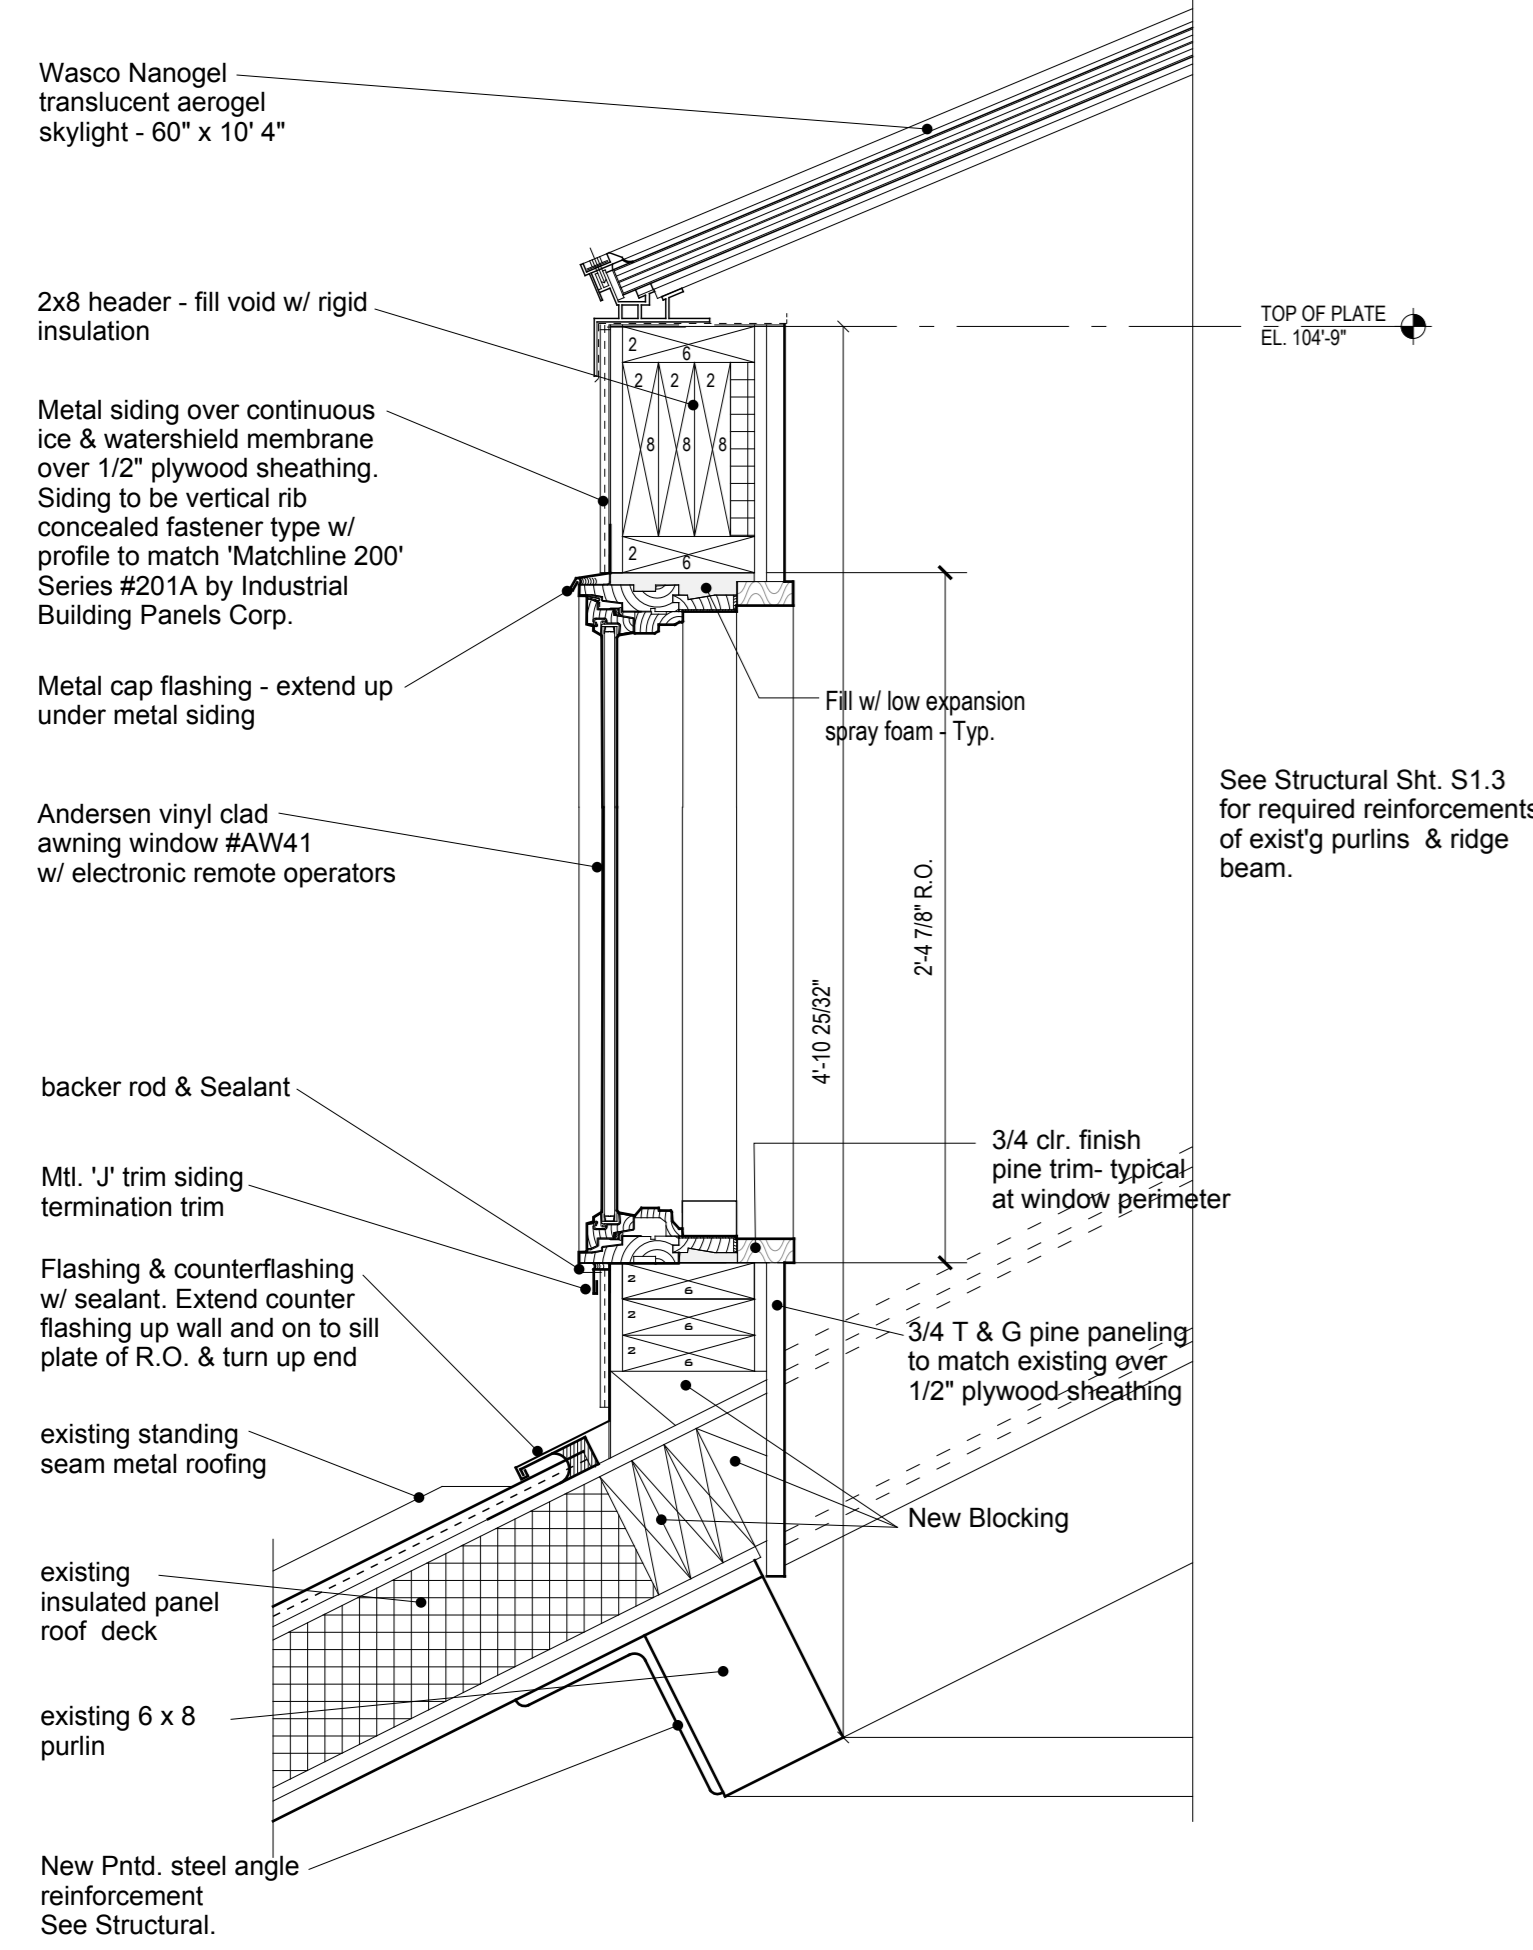


5 Skylight Curb Detail
1/2"=1'-0"

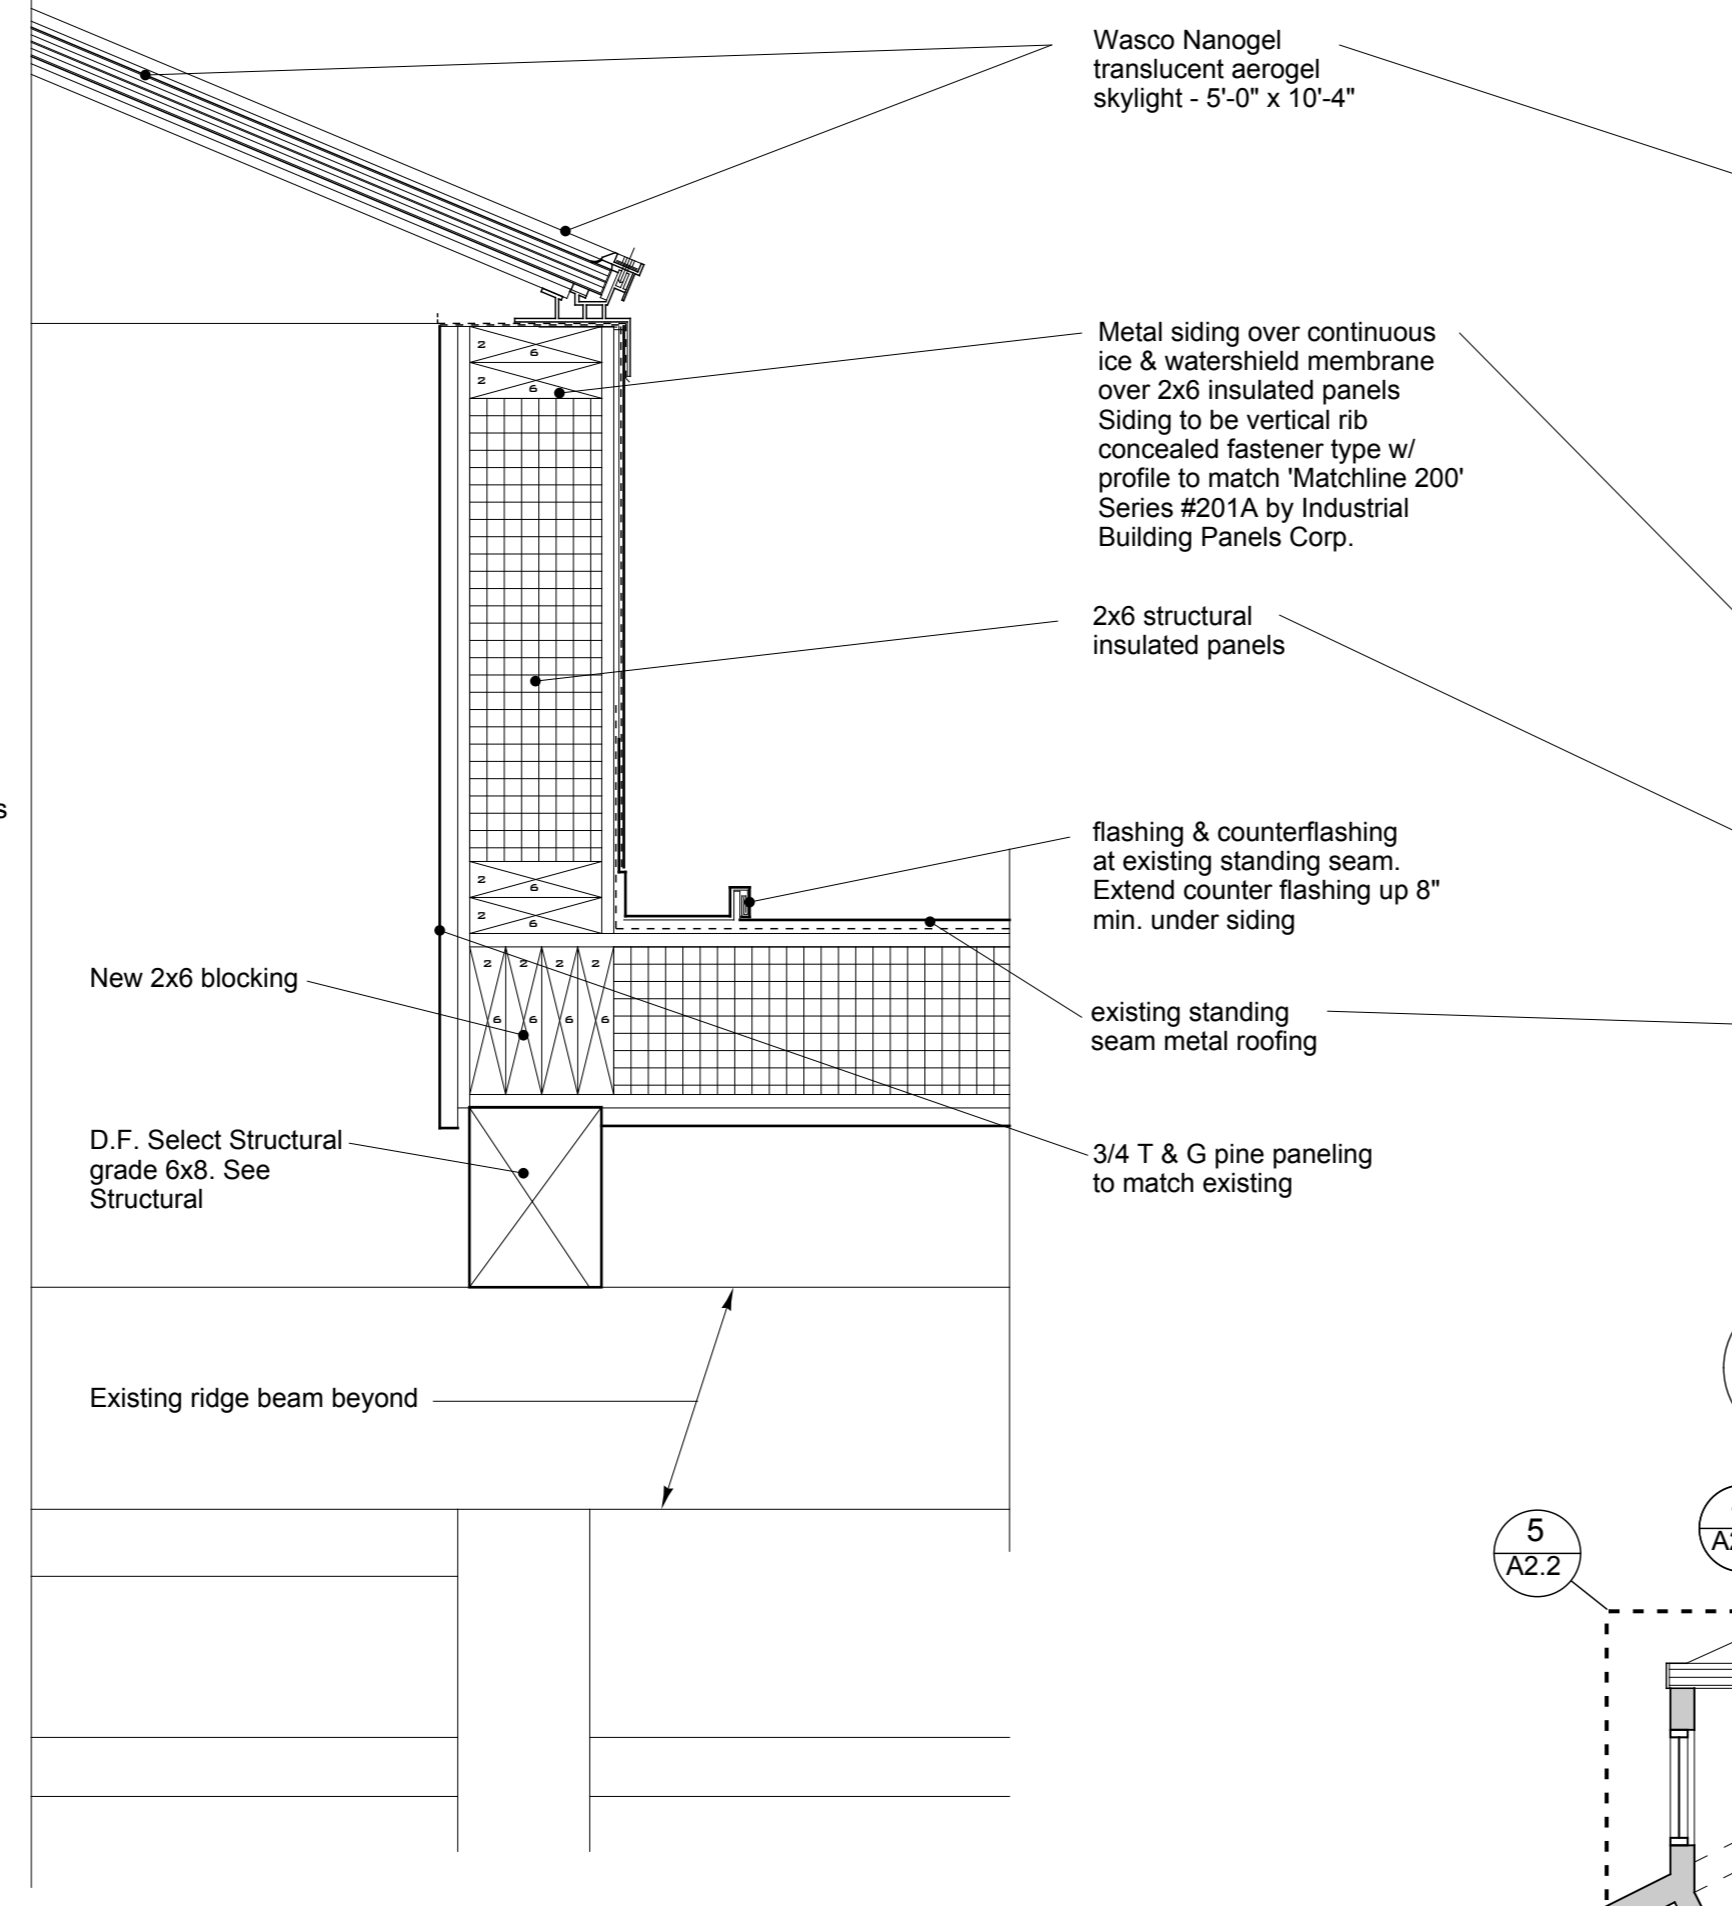


3 Skylight Curb Detail
1/2" Full Size

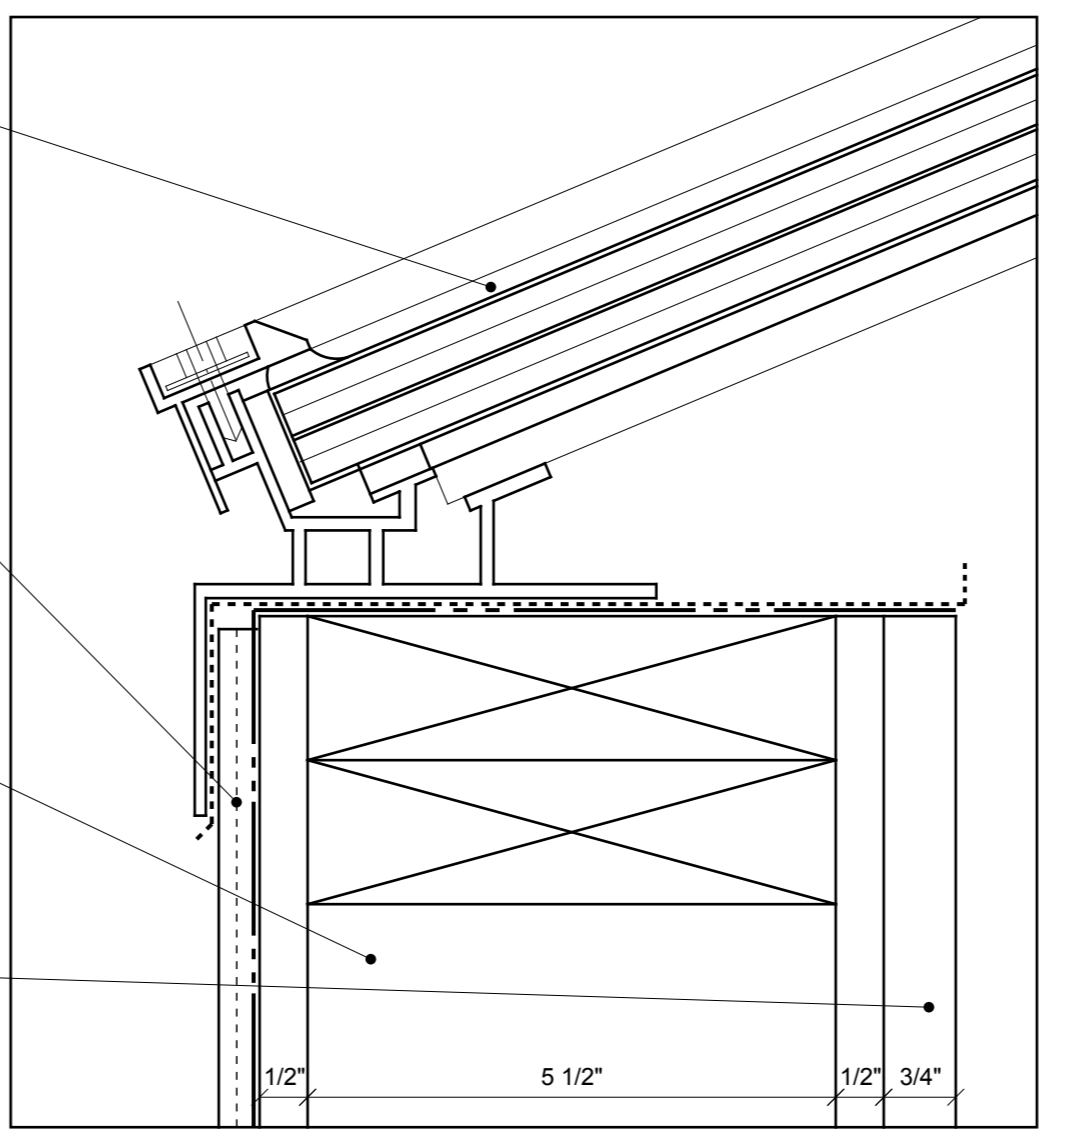

2 Skylight Ridge Detail
1/2" Full Size

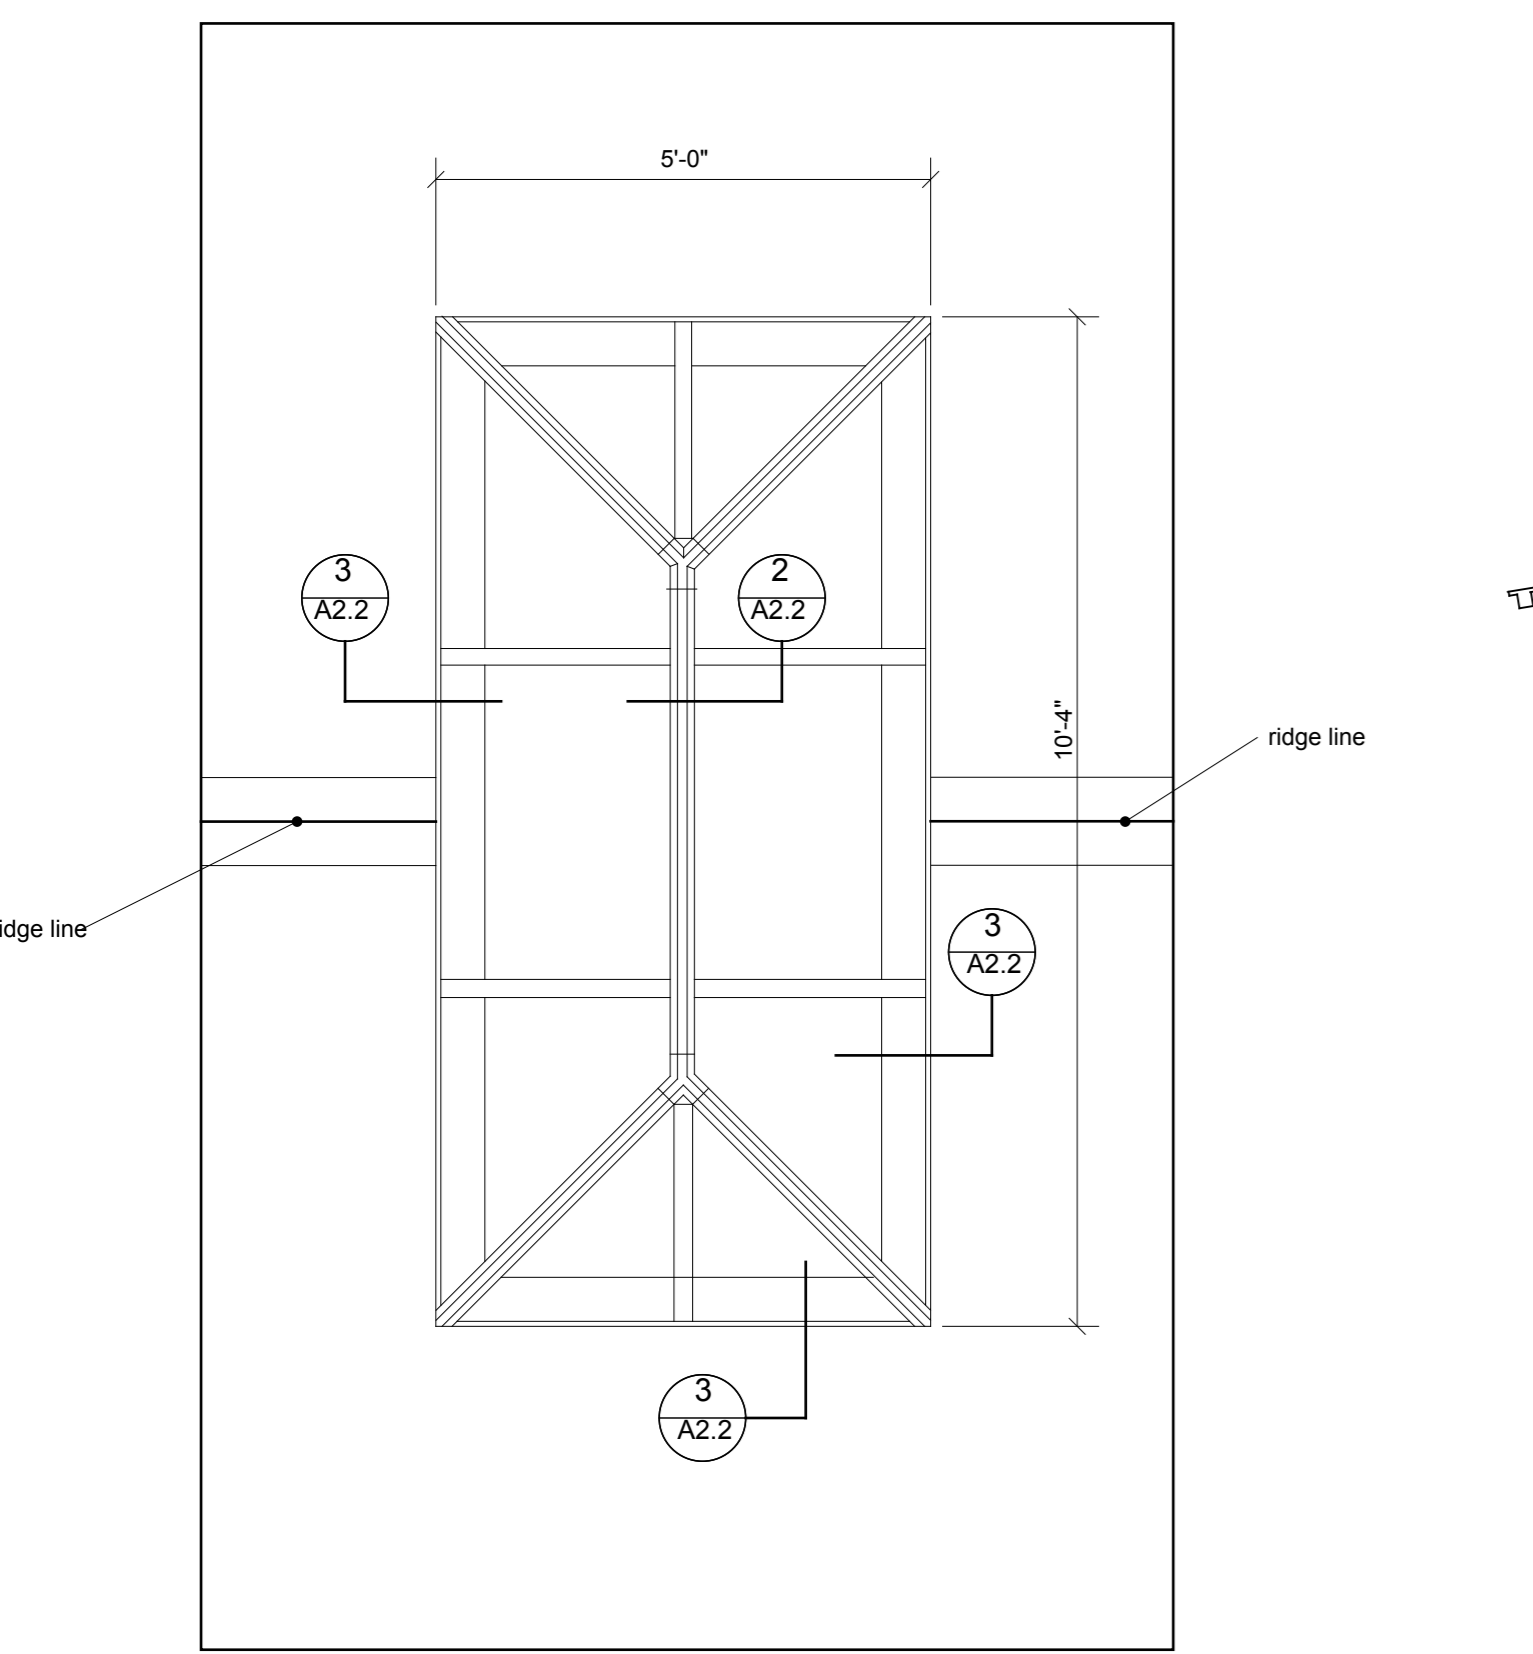

6 Skylight Roof Plan
1/2"=1'-0"

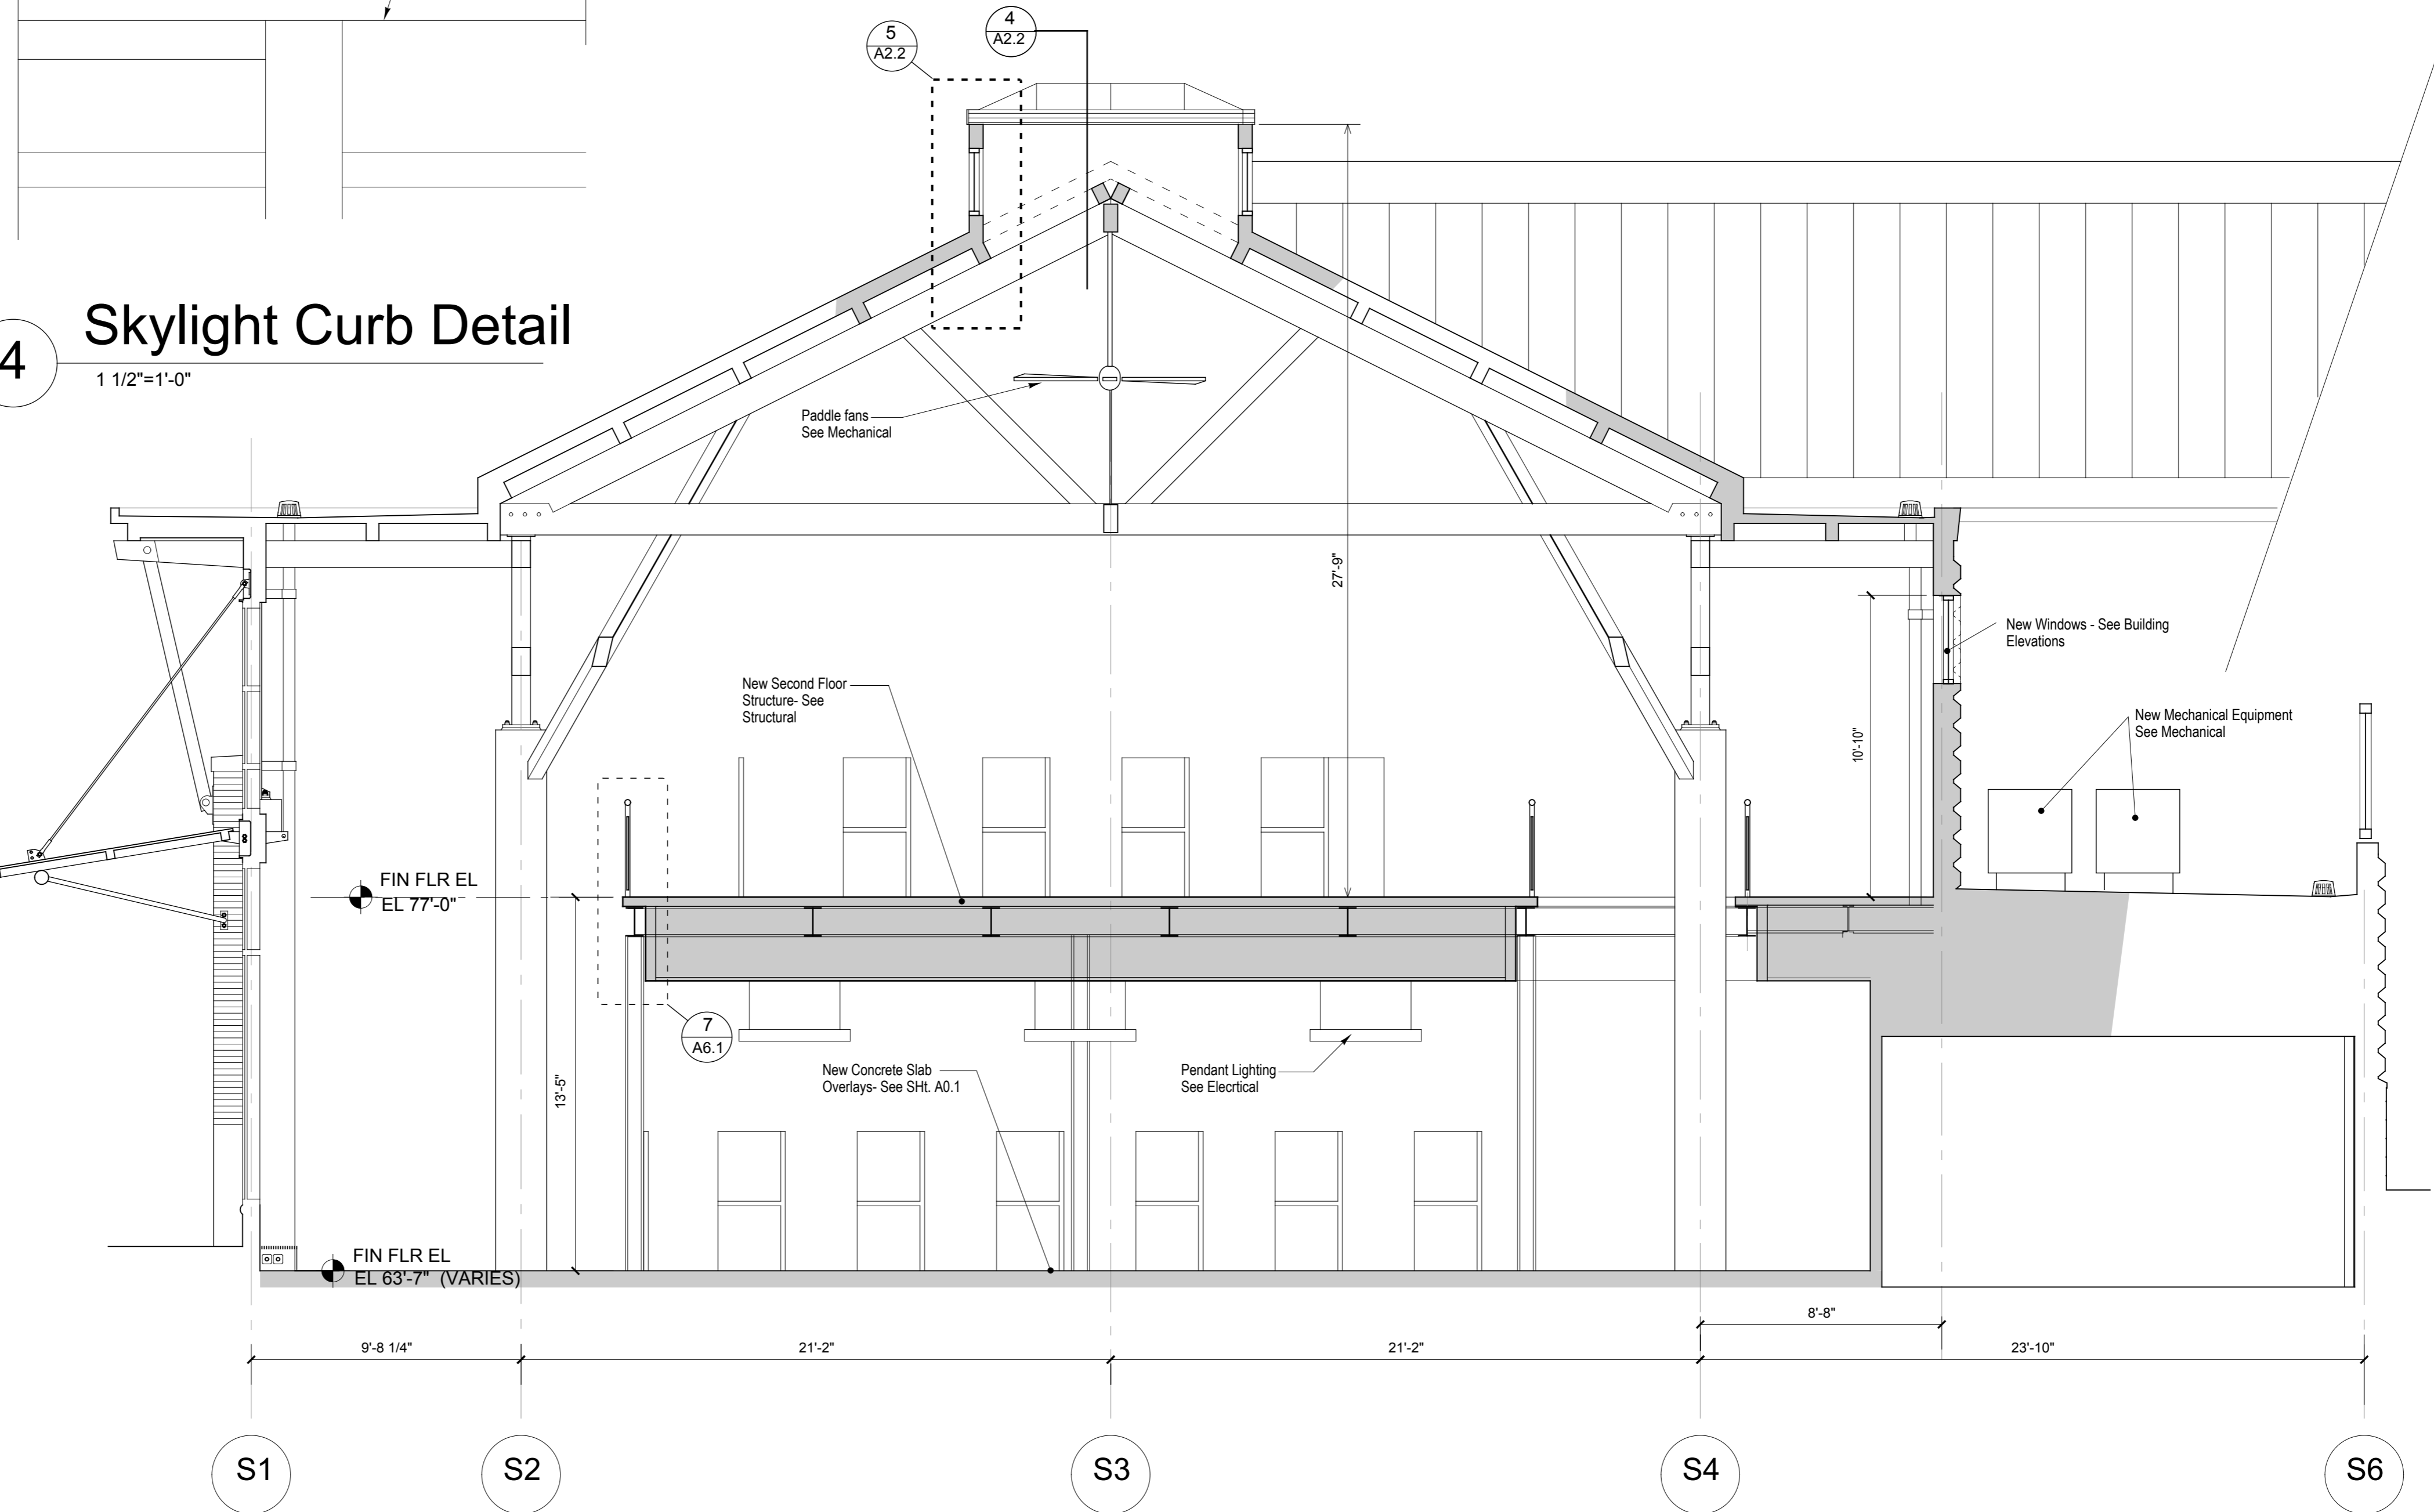

1 Building Section thru Skylight
1/4"=1'-0"