



POWER PAY OFFICE FIT UP

Winton Scott
Architects
5 Milk Street
Portland, Maine 04101

Wright Ryan
Construction, Inc.
10 Danforth Street
Portland, Maine 04101

Becker Structural
Engineers, Inc.
75 York Street
Portland, Maine 04101

Mechanical
Systems
Engineers
10 Royal River Center
Yarmouth, Maine 04096

Bartlett Design
942 Washington Ave.
Bath, Maine 04530



Fore Solutions
386 Fore Street
Portland, Maine 04101

MEZZANINE NORTH MECHANICAL DUCTWORK PLAN


M3

MECHANICAL SYSTEMS ENGINEERS
ROYAL RIVER CENTER, UNIT #10
10 FOREST FALLS DRIVE
YARMOUTH, MAINE 04096
VOICE: (207) 846-1441
FAX: (207) 846-1443
mechsyst@maine.rr.com
© COPYRIGHT 2009

Scale: 1/8" = 1'-0" Date: 03.20.09
M.S.E. Proj. 0837

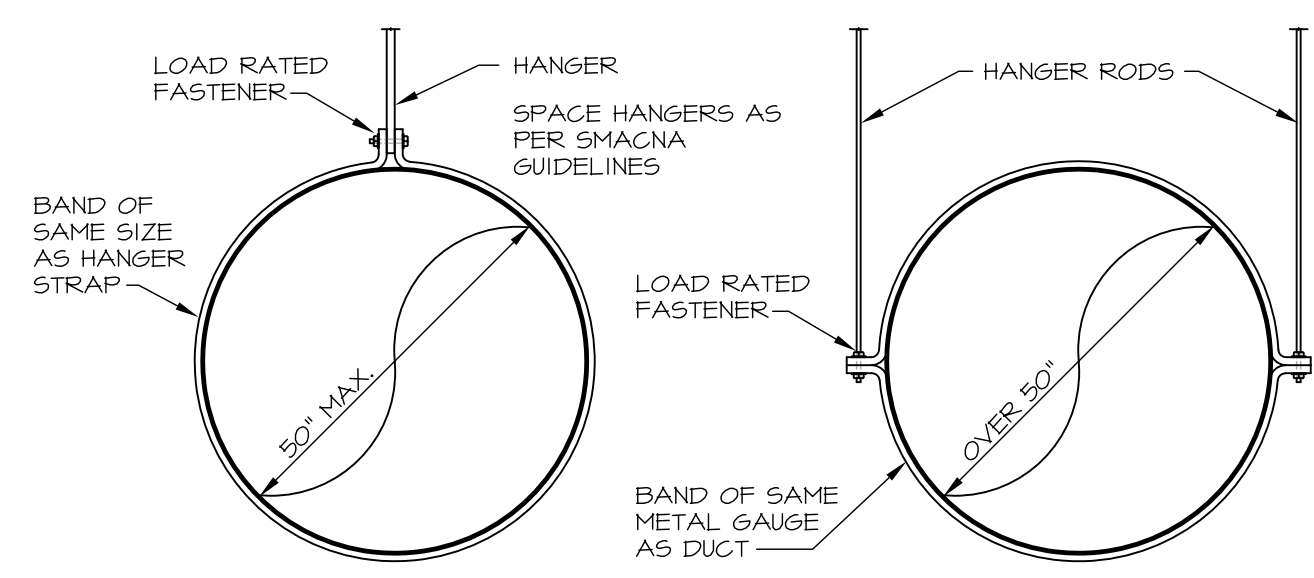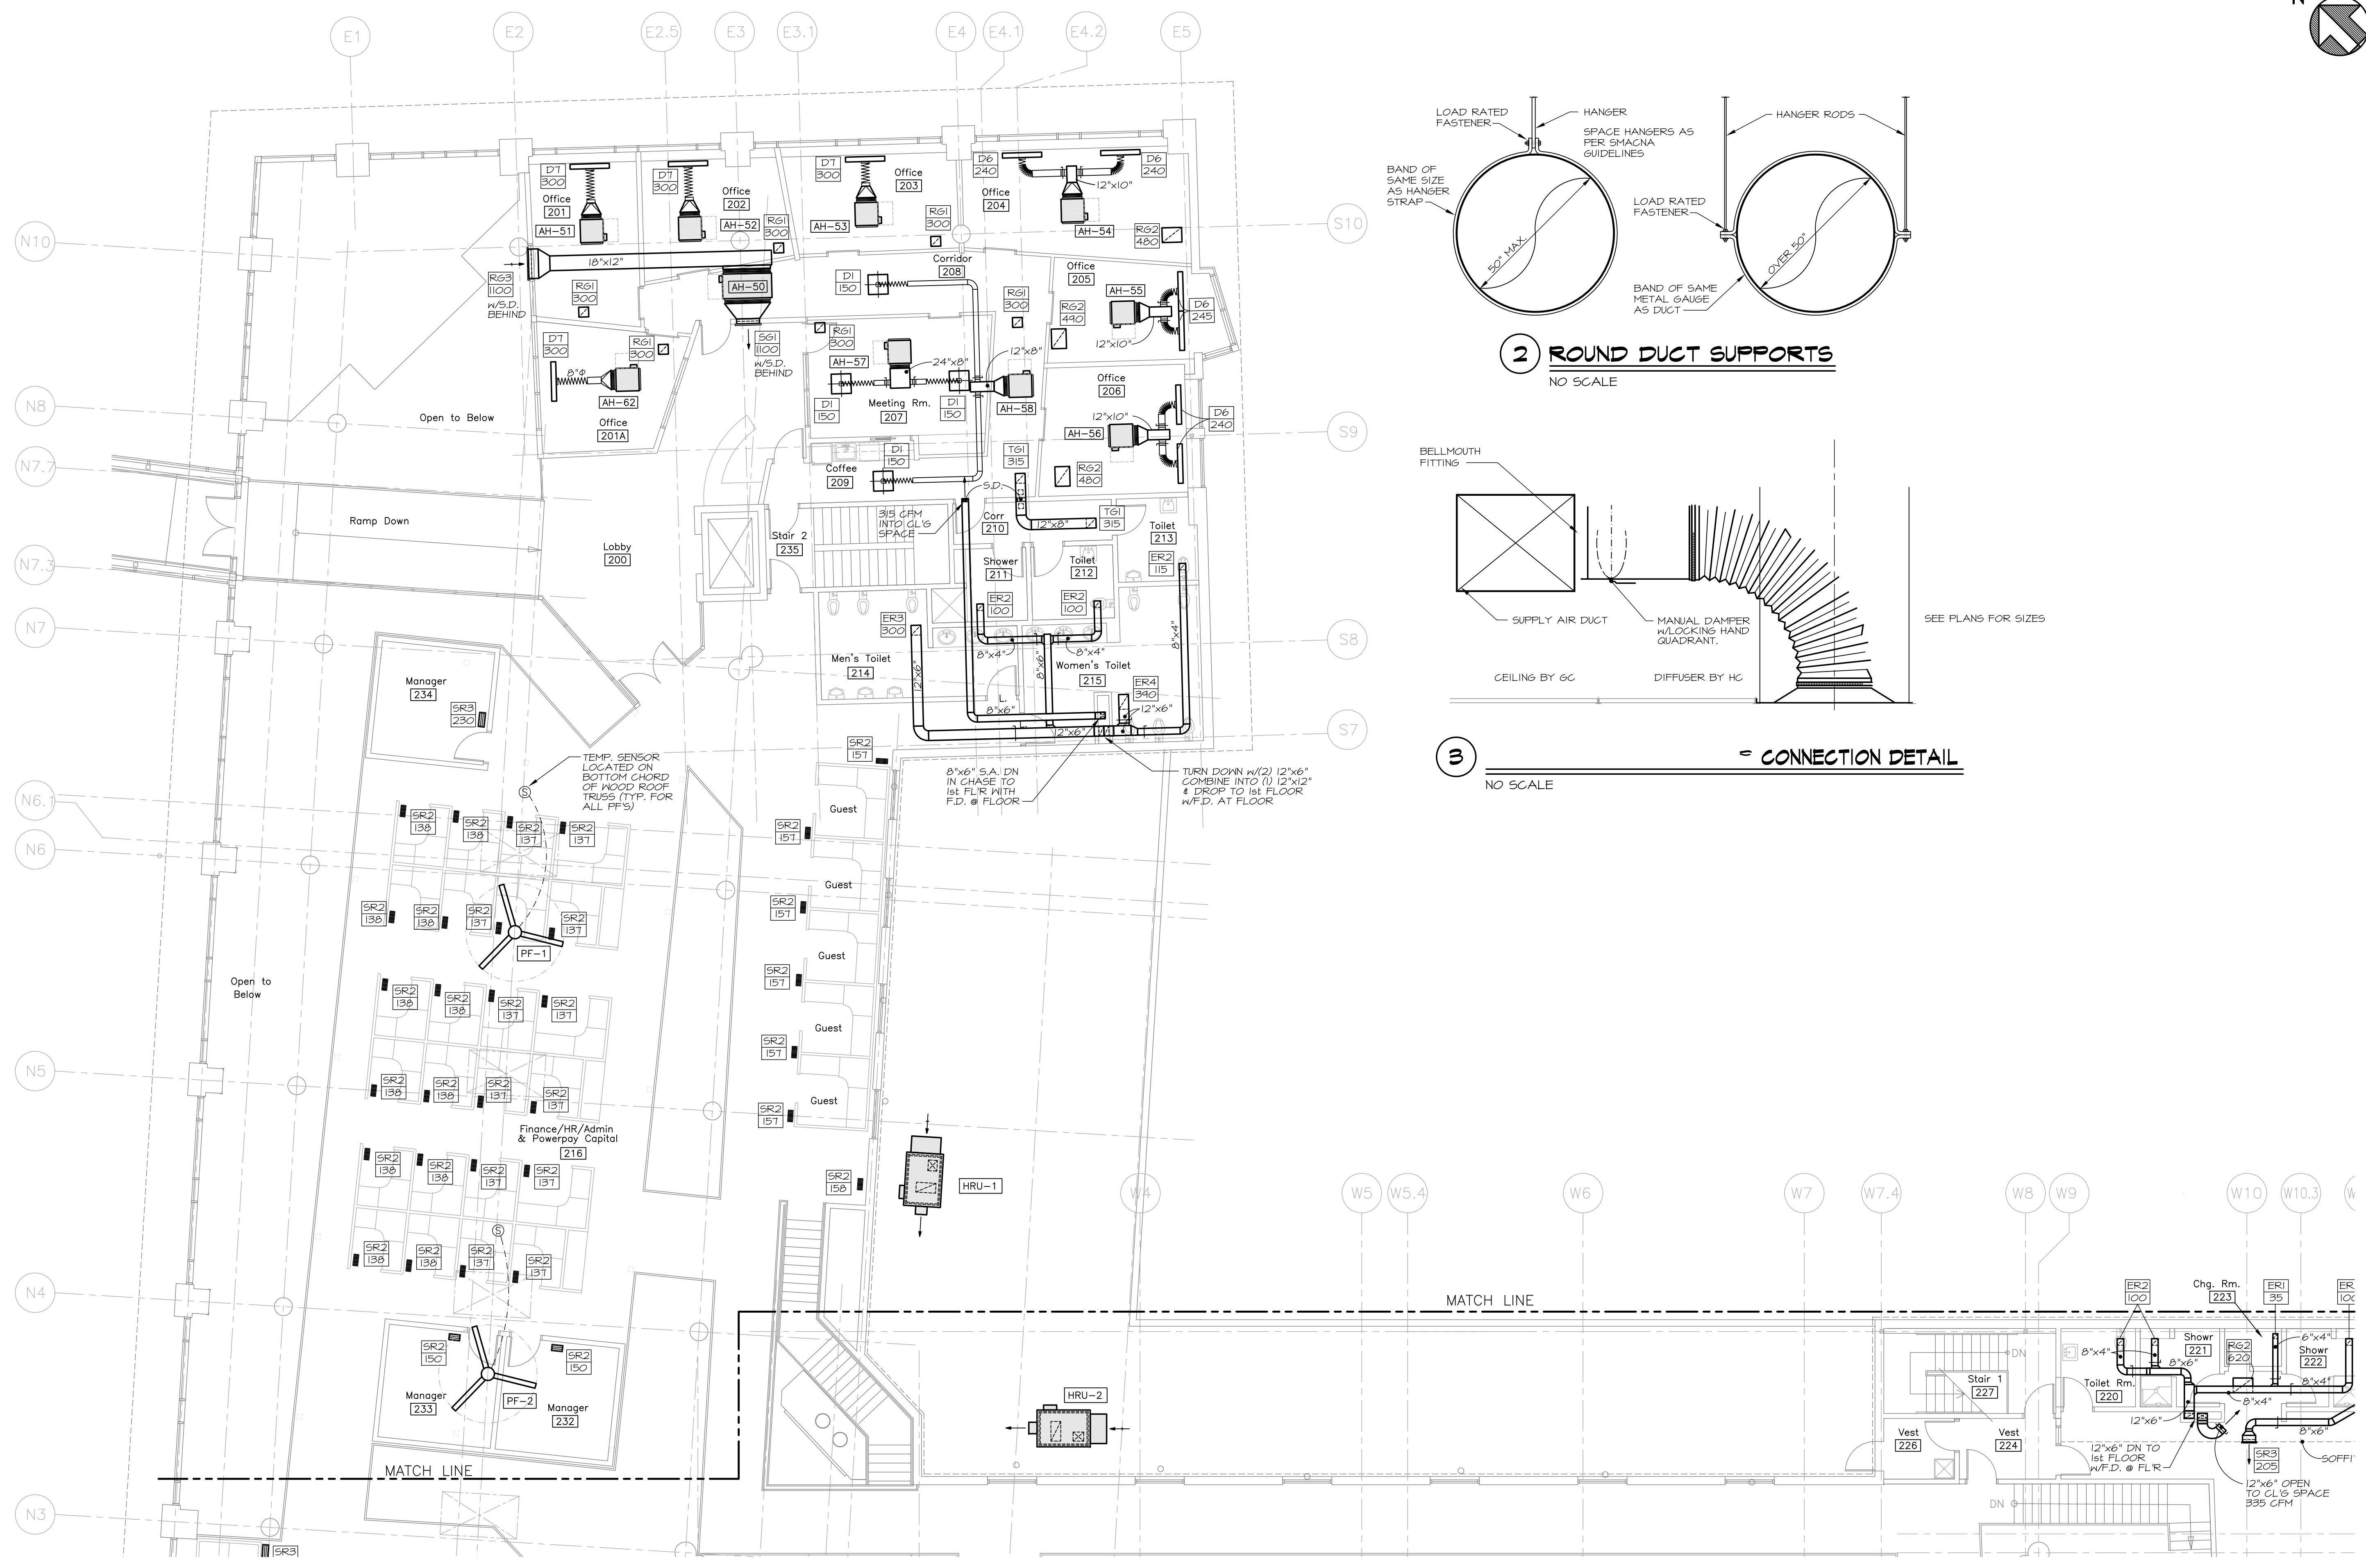

2 ROUND DUCT SUPPORTS
NO SCALE

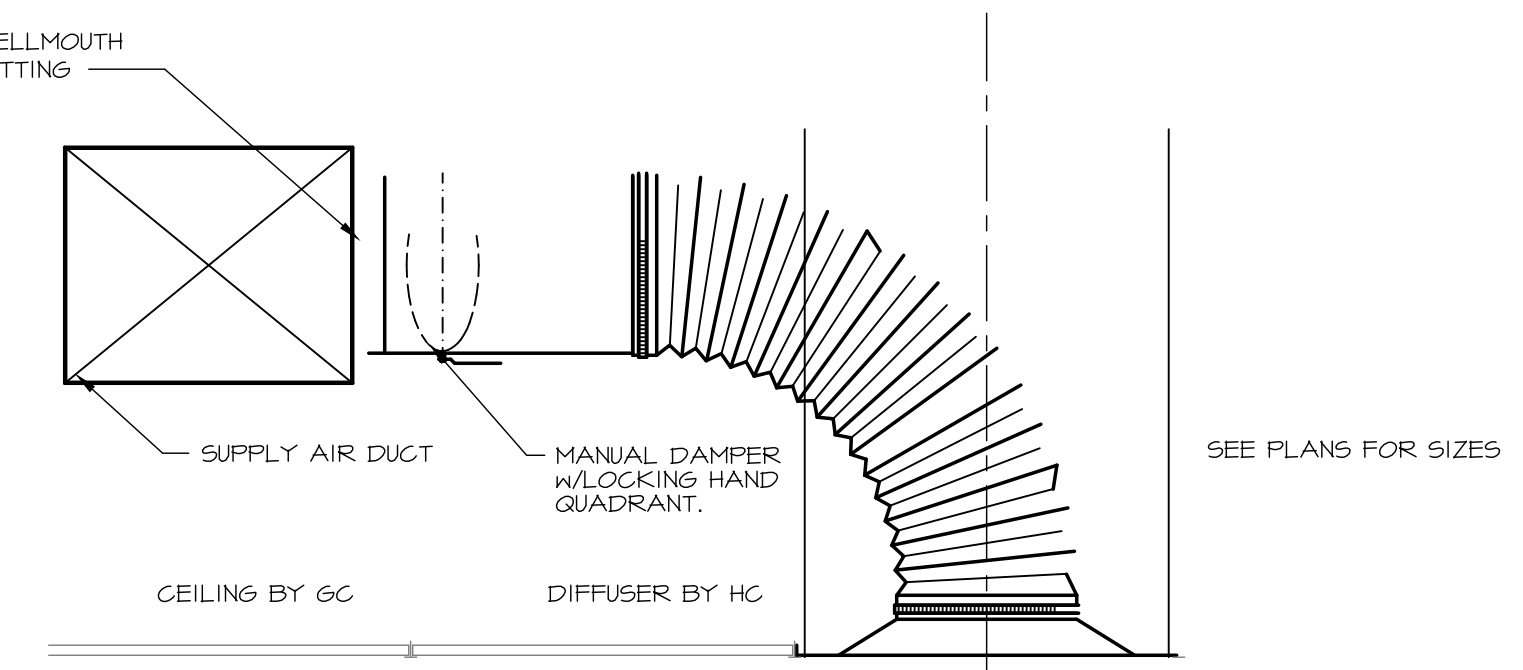

3 CONNECTION DETAIL
NO SCALE

1 MEZZANINE NORTH MECHANICAL DUCTWORK
SCALE: 1/8" = 1'-0"



March 25, 2009 - 7:50 am
\\Mainframe\Projects\0837 Power Pay\Drawings\0837 M1-M4.dwg