


**ENLARGED PART PLAN
 (PRIMARILY ALT #1 PLUMBING)**
 SCALE: 3/8" = 1'-0"

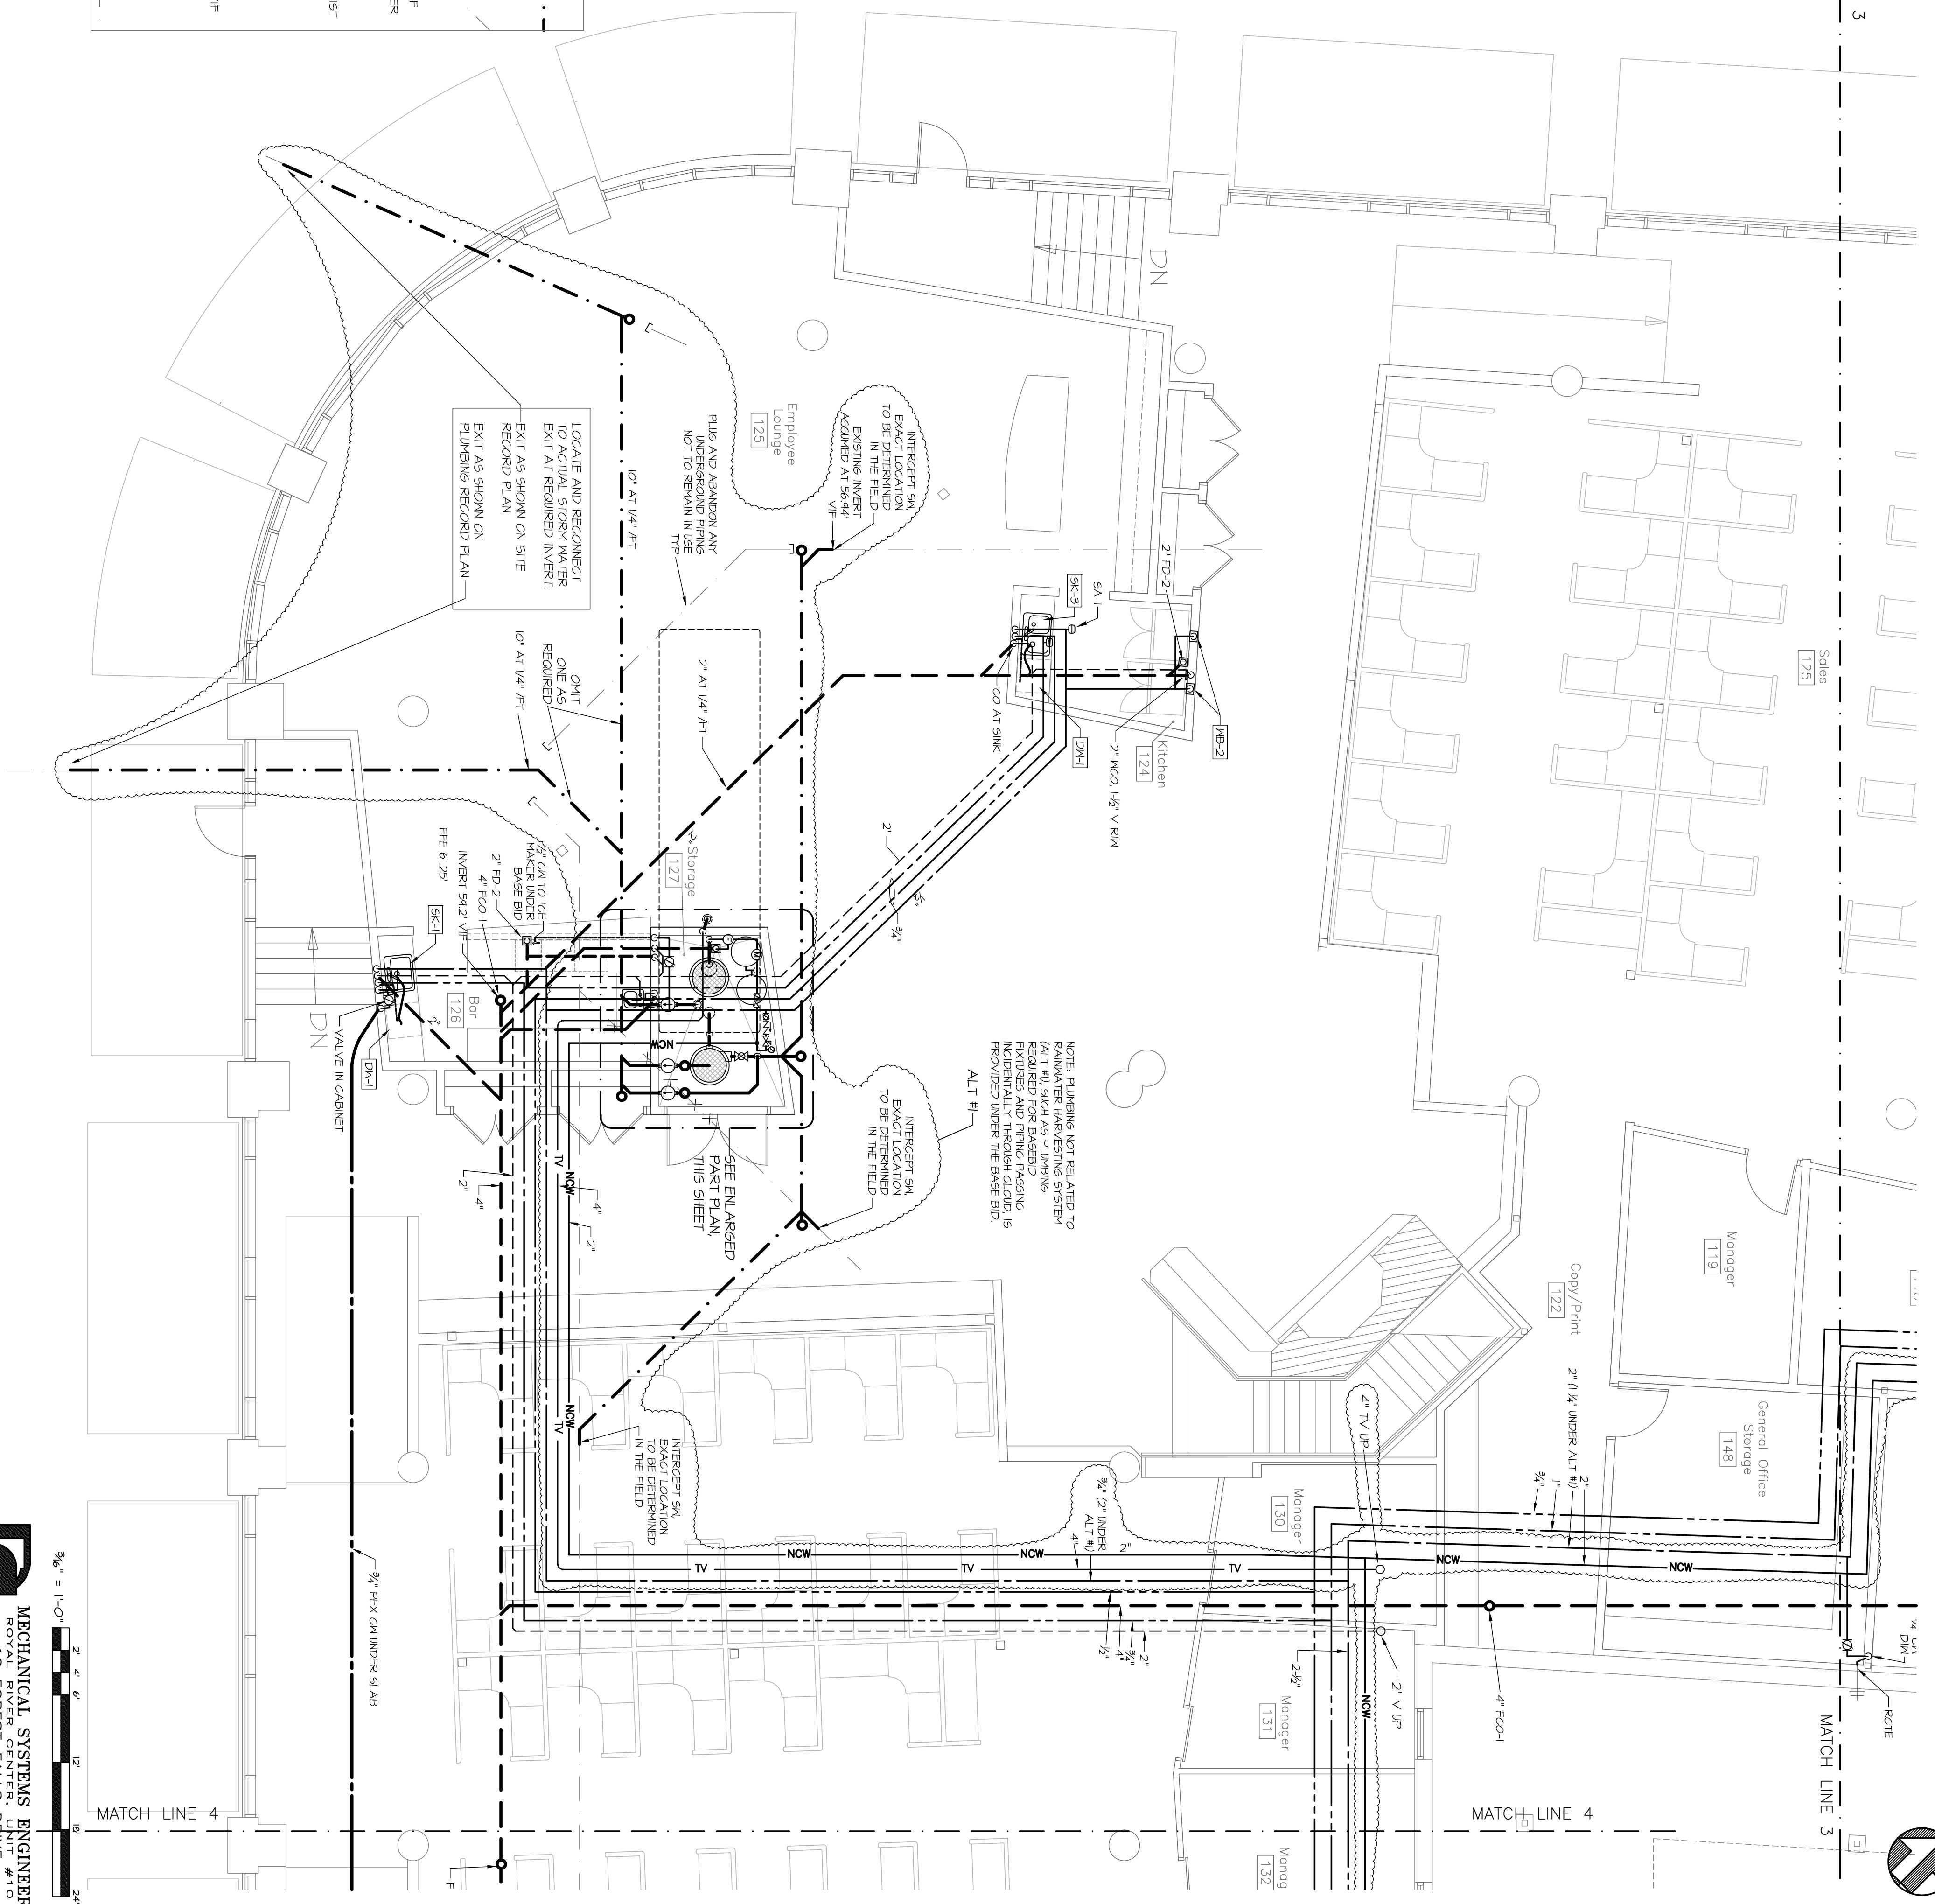


MATCH LINE 3

MATCH LINE 3

MATCH LINE 4

MATCH LINE 4

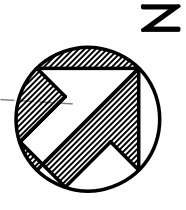

MECHANICAL SYSTEMS ENGINEERS
 10 FOREST FALLS DRIVE
 YARMOUTH, MAINE 04096
 FAX: (207) 546-1443
 mech@msengr.com
 ©MSME 2009

**FIRST FLOOR
 PLUMBING PLAN**

P2

Fore Solutions
 386 Fore Street
 Portland, Maine 04101

Bartlett Design
 942 Washington Ave.
 Bath, Maine 04530

**Mechanical
 Systems
 Engineers**
 10 Royal River Center
 Yarmouth, Maine 04096

**Becker Structural
 Engineers, Inc.**
 75 York Street
 Portland, Maine 04101

**Wright Ryan
 Construction, Inc.**
 10 Danforth Street
 Portland, Maine 04101

**Winton Scott
 Architects**
 5 Milk Street
 Portland, Maine 04101

POWER PAY OFFICE FIT UP

