

OWNER SUPPLIED BOTTLELESS WATER COOLER AT THIS LOCATION. PROVIDE COLD DOMESTIC WATER CONNECTION. NO DRAIN REQUIRED.




OWNER SUPPLIED COFFEE MAKER AT THIS LOCATION. PROVIDE COLD DOMESTIC WATER CONNECTION. NO DRAIN REQUIRED.



PROVIDE COLD DOMESTIC WATER CONNECTION. FOR ICE MAKER APPLIANCE AT THIS LOCATION.

**POWER PAY
OFFICE FIT-UP**

**WINTON SCOTT
ARCHITECTS, PA**
5 Milk Street
Portland, Maine 04101
207 774 4811

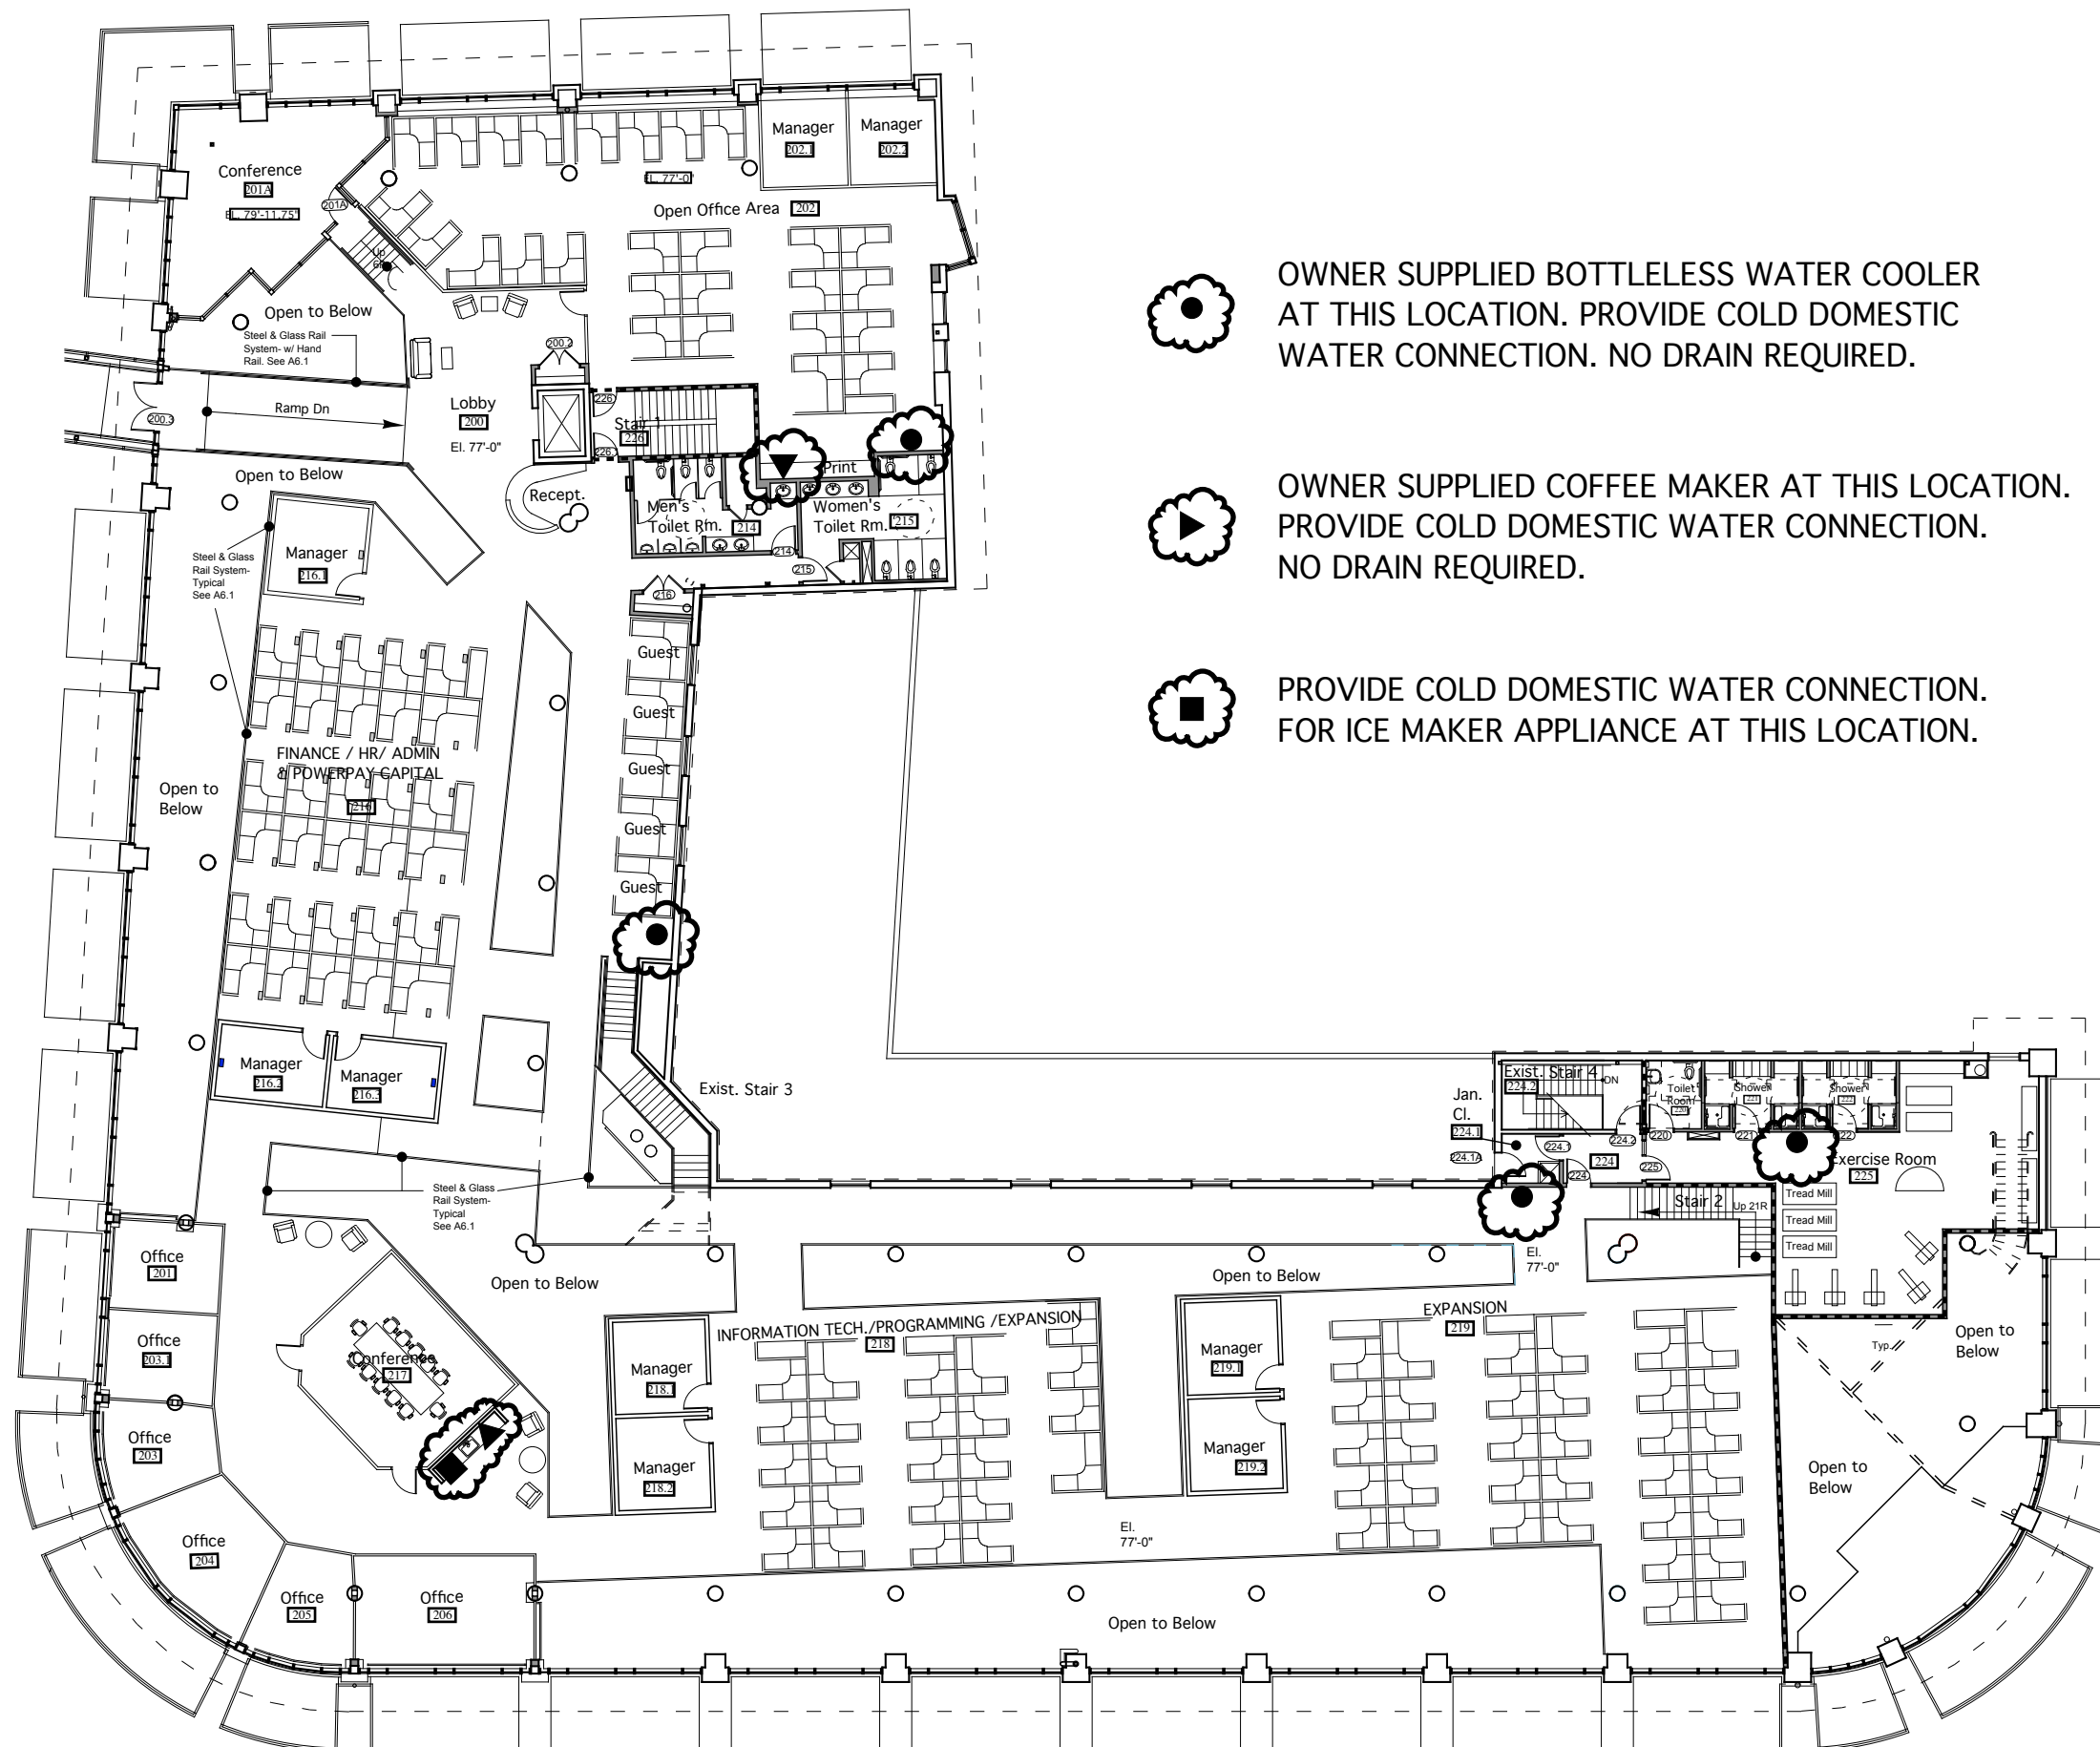

OWNER SUPPLIED BOTTLELESS WATER COOLER AT THIS LOCATION. PROVIDE COLD DOMESTIC WATER CONNECTION. NO DRAIN REQUIRED.



OWNER SUPPLIED COFFEE MAKER AT THIS LOCATION. PROVIDE COLD DOMESTIC WATER CONNECTION. NO DRAIN REQUIRED.




PROVIDE COLD DOMESTIC WATER CONNECTION. FOR ICE MAKER APPLIANCE AT THIS LOCATION.

SECOND FLOOR PLAN


POWER PAY OFFICE FIT-UP

WINTON SCOTT ARCHITECTS, PA
 5 Milk Street
 Portland, Maine 04101
 207 774 4811

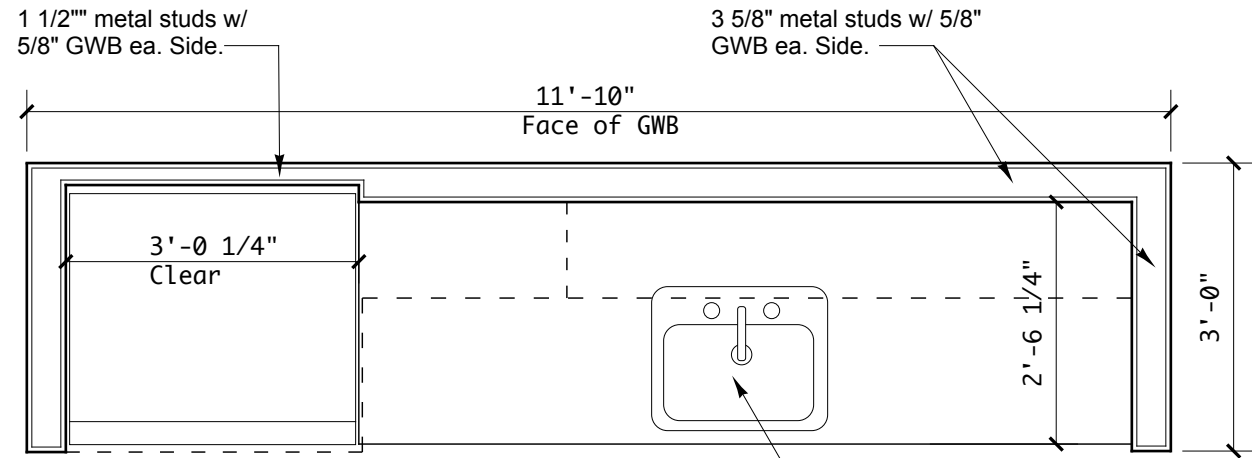


Elkay # LR-2522-4 S.S. Sink. NOTE THIS IS A CHANGE FROM PREVIOUSLY ISSUED PLUMBING DRAWINGS

4 EXECUTIVE COFFEE AREA PLAN
SCALE: 1/2" = 1'-0"

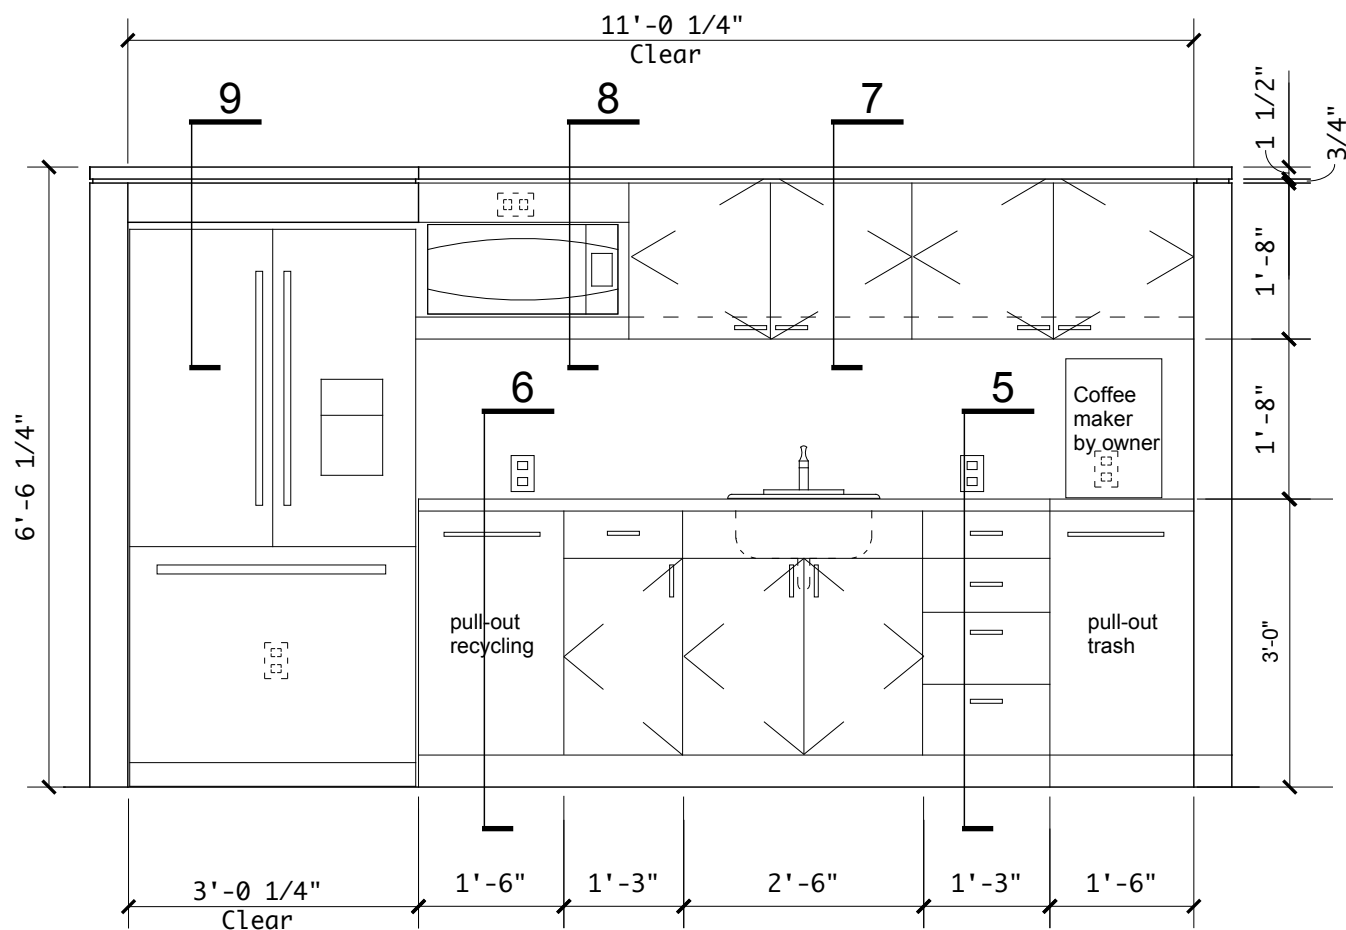



3 EXECUTIVE COFFEE AREA ELEVATION
SCALE: 1/2" = 1'-0"

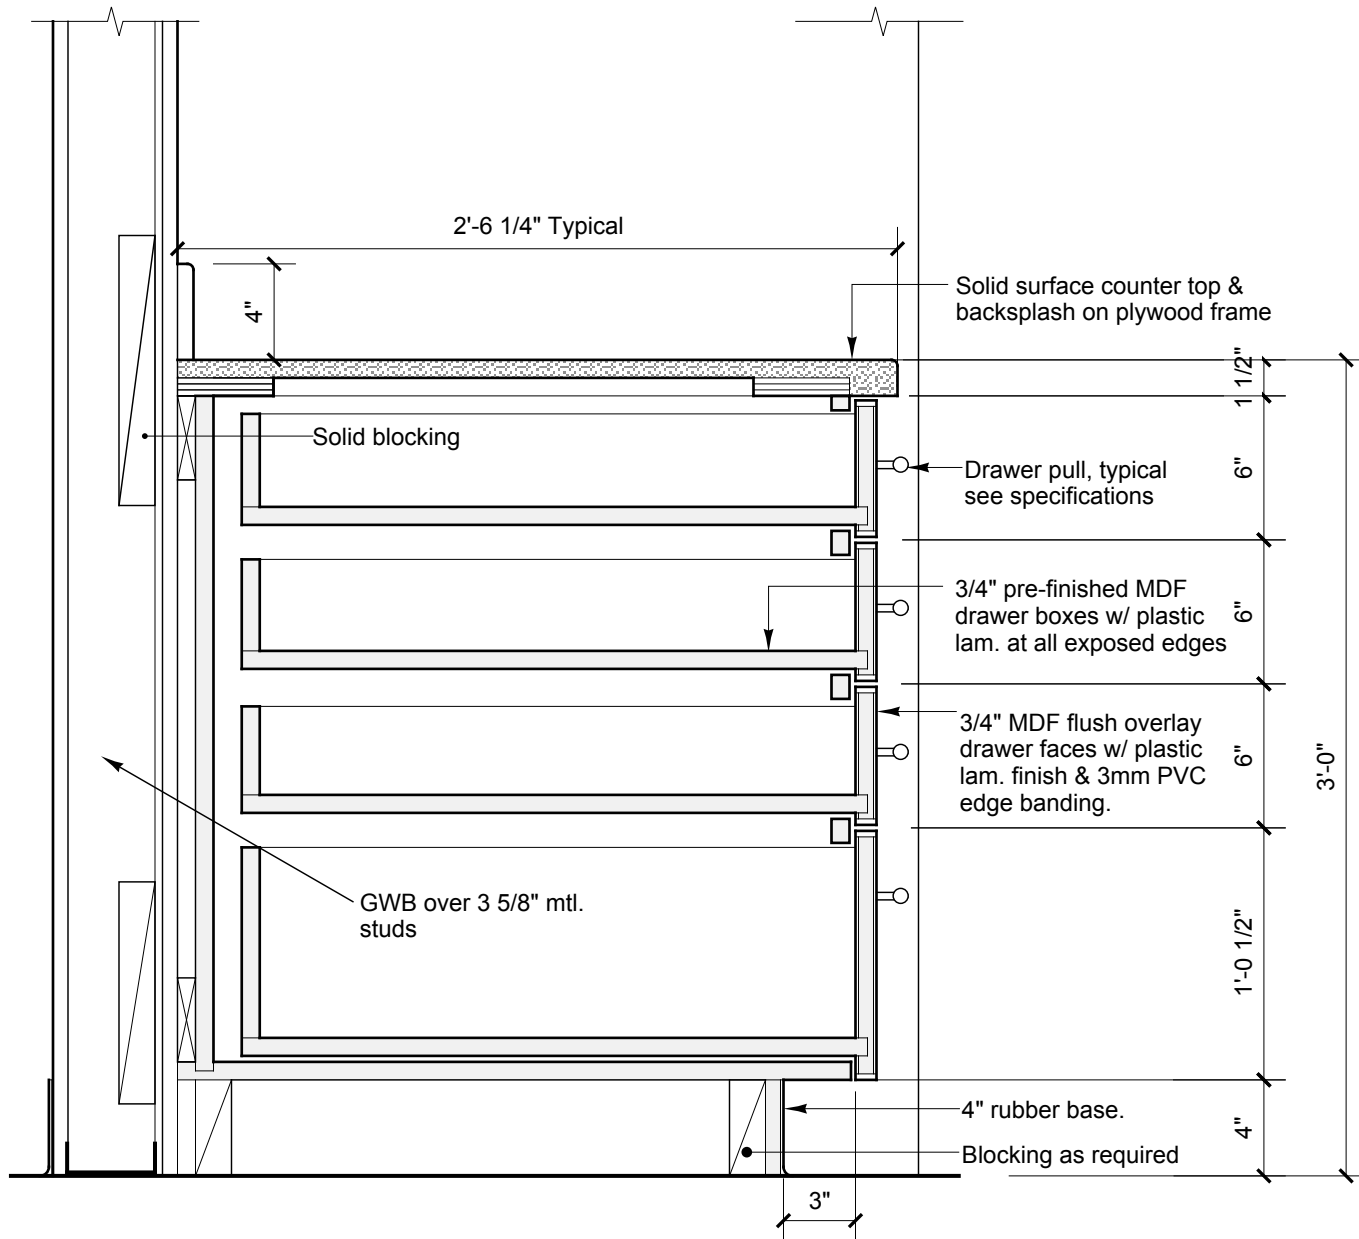

5 EXECUTIVE COFFEE AREA
SCALE: 1 1/2" = 1'-0"


POWER PAY OFFICE FIT-UP

WINTON SCOTT ARCHITECTS, PA
5 Milk Street
Portland, Maine 04101
207 774 4811

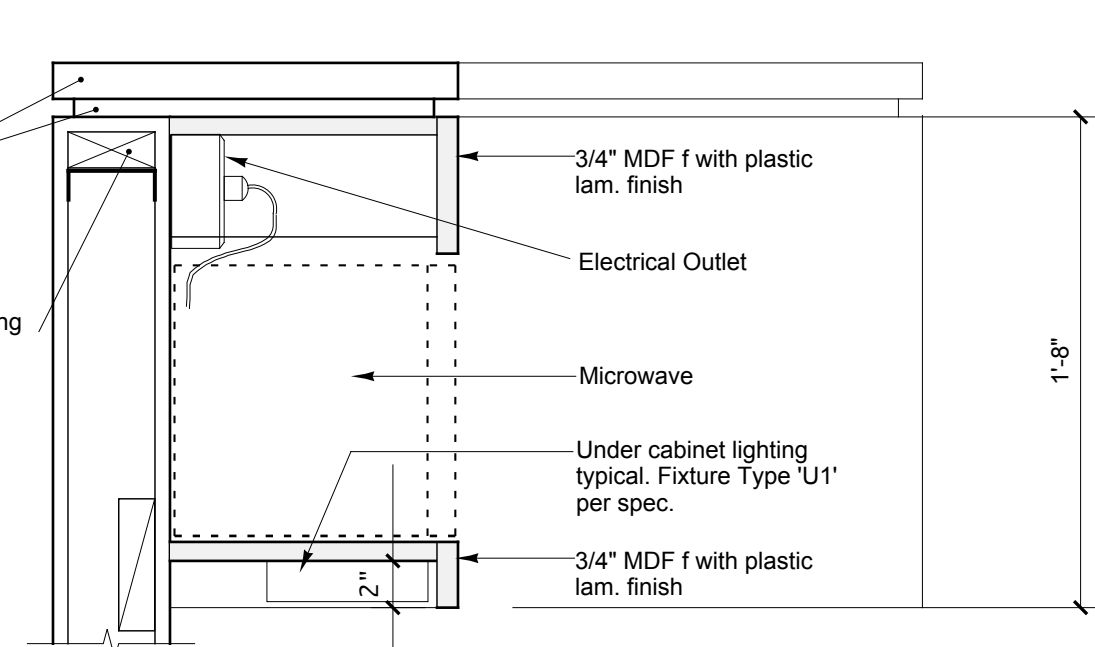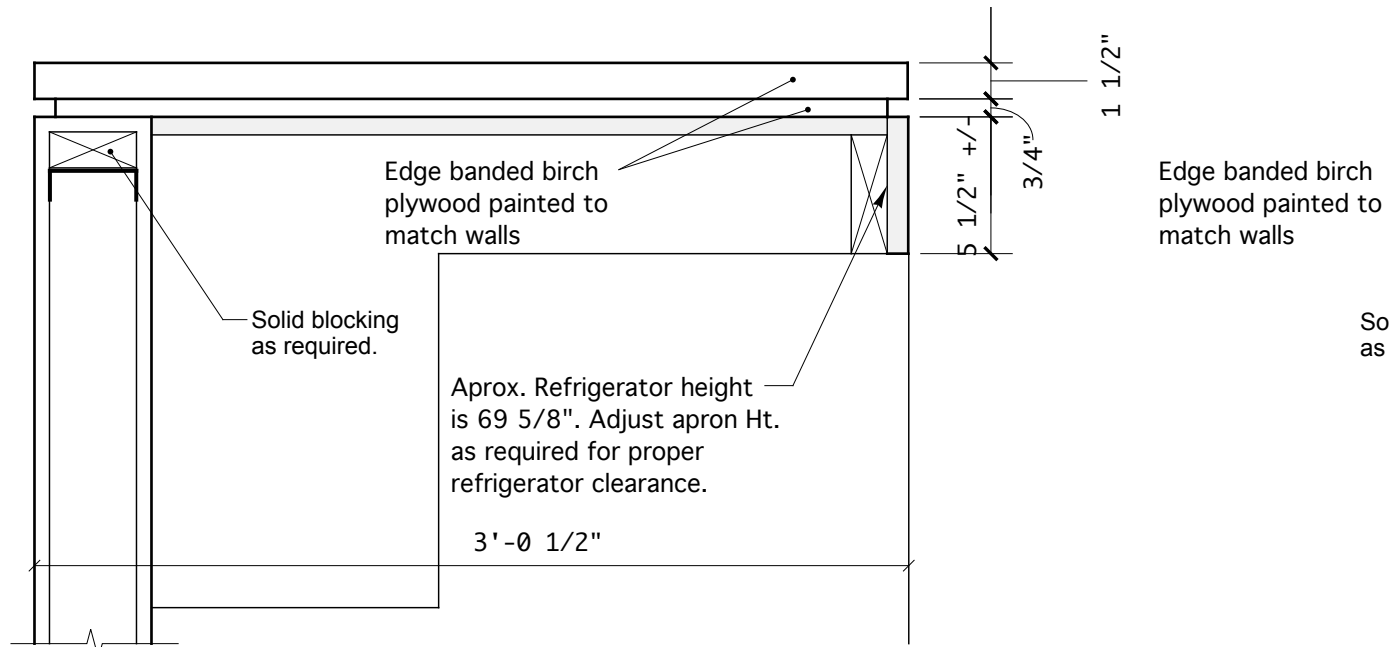


9 SECTION DETAIL AT REFRIGERATOR
SCALE: 1 1/2" = 1'-0"

8 SECTION DETAIL AT MICROWAVE
SCALE: 1 1/2" = 1'-0"

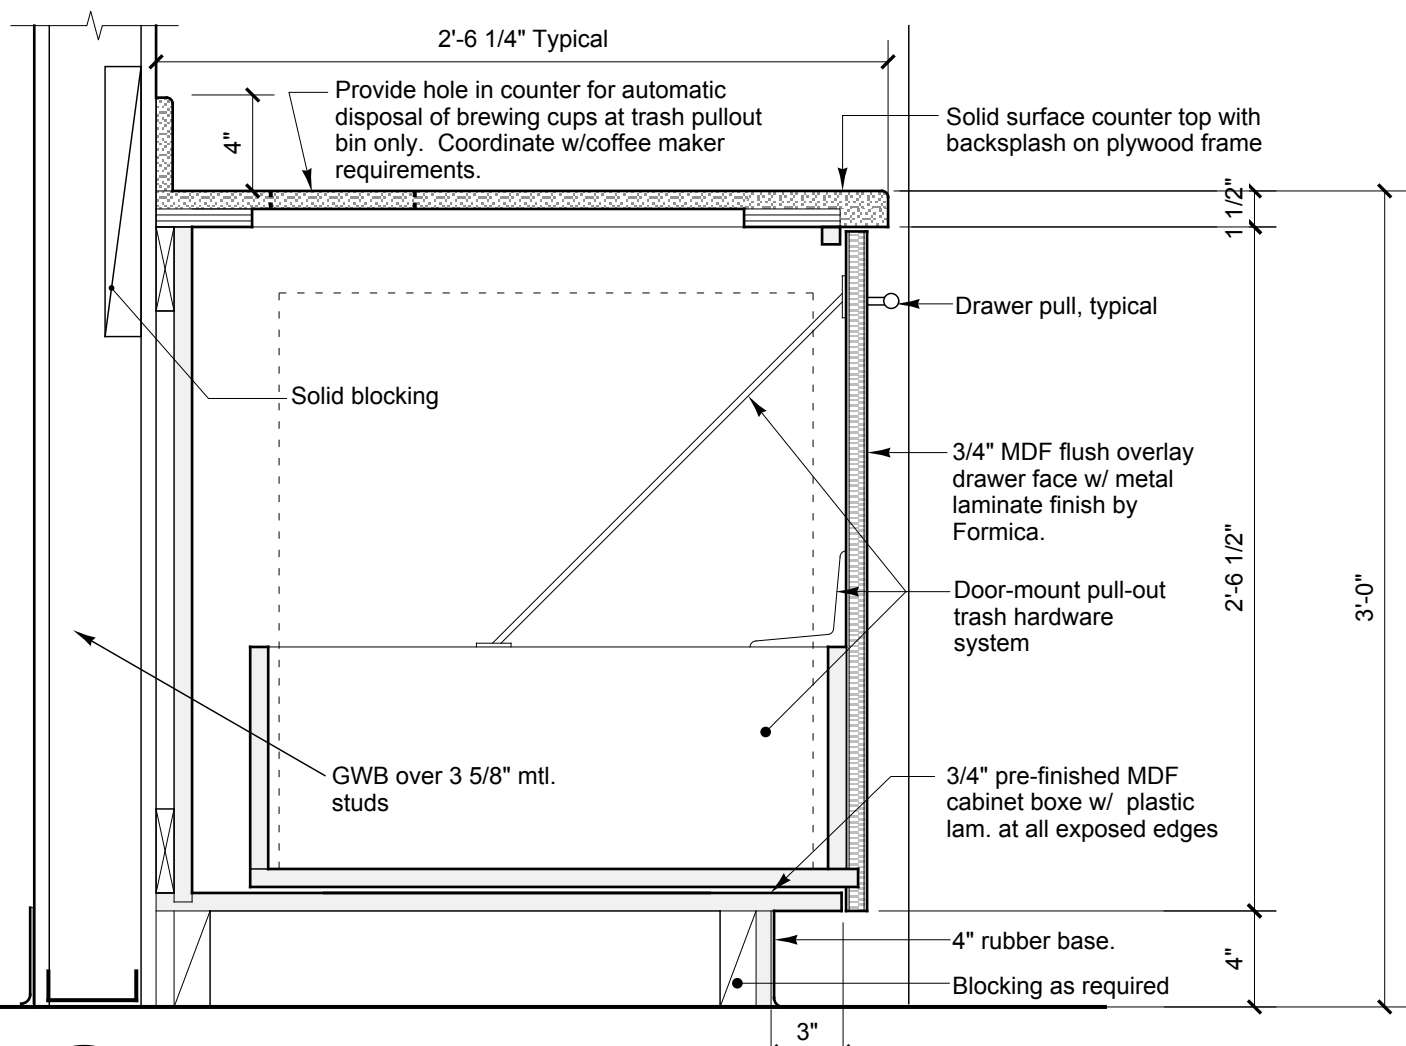

6 SECTION DETAIL AT PULL-OUT CABINET
SCALE: 1 1/2" = 1'-0"

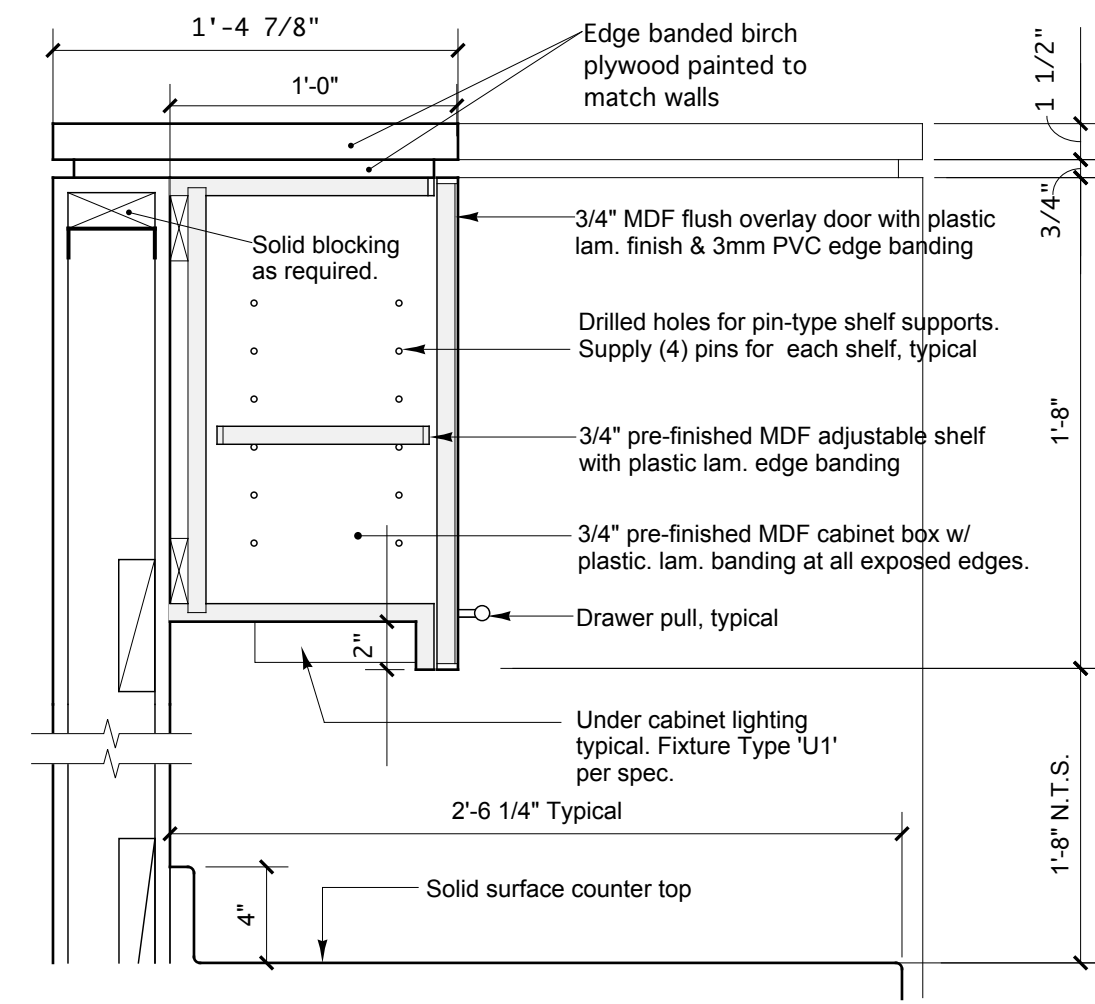

7 SECTION DETAIL AT UPPER CABINET
SCALE: 1 1/2" = 1'-0"

POWER PAY OFFICE FIT-UP

WINTON SCOTT ARCHITECTS, PA
5 Milk Street
Portland, Maine 04101
207 774 4811