



- KEYED NOTES:**
- 18x12E DUCT UP, FOR CONTINUATION SEE SHEET MP-102.
  - 12x18 OA INTAKE DUCT UP, FOR CONTINUATION SEE SHEET MP-102.
  - LOCATE MOD AS CLOSE TO EXTERIOR AS FEASIBLE.
  - COORDINATE LOCATION OF THERMOSTAT. DO NOT LOCATE NEAR COMPUTERS OR OTHER HEAT-PRODUCING EQUIPMENT.
  - OFFSET DUCT W/45° ELBOWS; RISE BETWEEN BEAMS TO AVOID DUCTS.
  - (2)GRILLES OVER/UNDER; SURFACE MOUNT TIGHT TO CEILING.
  - (1)GRILLE; SURFACE MOUNT TIGHT TO CEILING.
  - CHASE SHALL BE SEALED TIGHT TO CREATE A RETURN PLENUM.
  - DIFFUSERS PROVIDED FOR AESTHETICS ONLY. OPEN TO PLENUM.
  - ALTERNATE No.2. SEE SHEET A127.
  - GRILLE SHALL BE 20'-0" WIDE. PROVIDE INACTIVE SECTIONS BETWEEN OUTLETS.
  - SERVICE (E)FD'S AS SPECIFIED.
  - PROVIDE FDS W/ACCESS DOORS AT FLOOR PENETRATIONS.

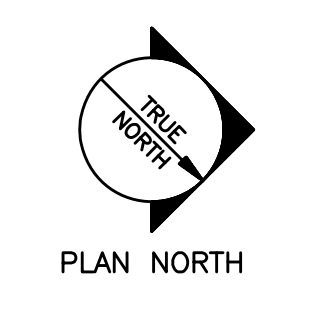

C1 MECHANICAL PLAN ~ MAIN LEVEL  
1/8" = 1'-0"

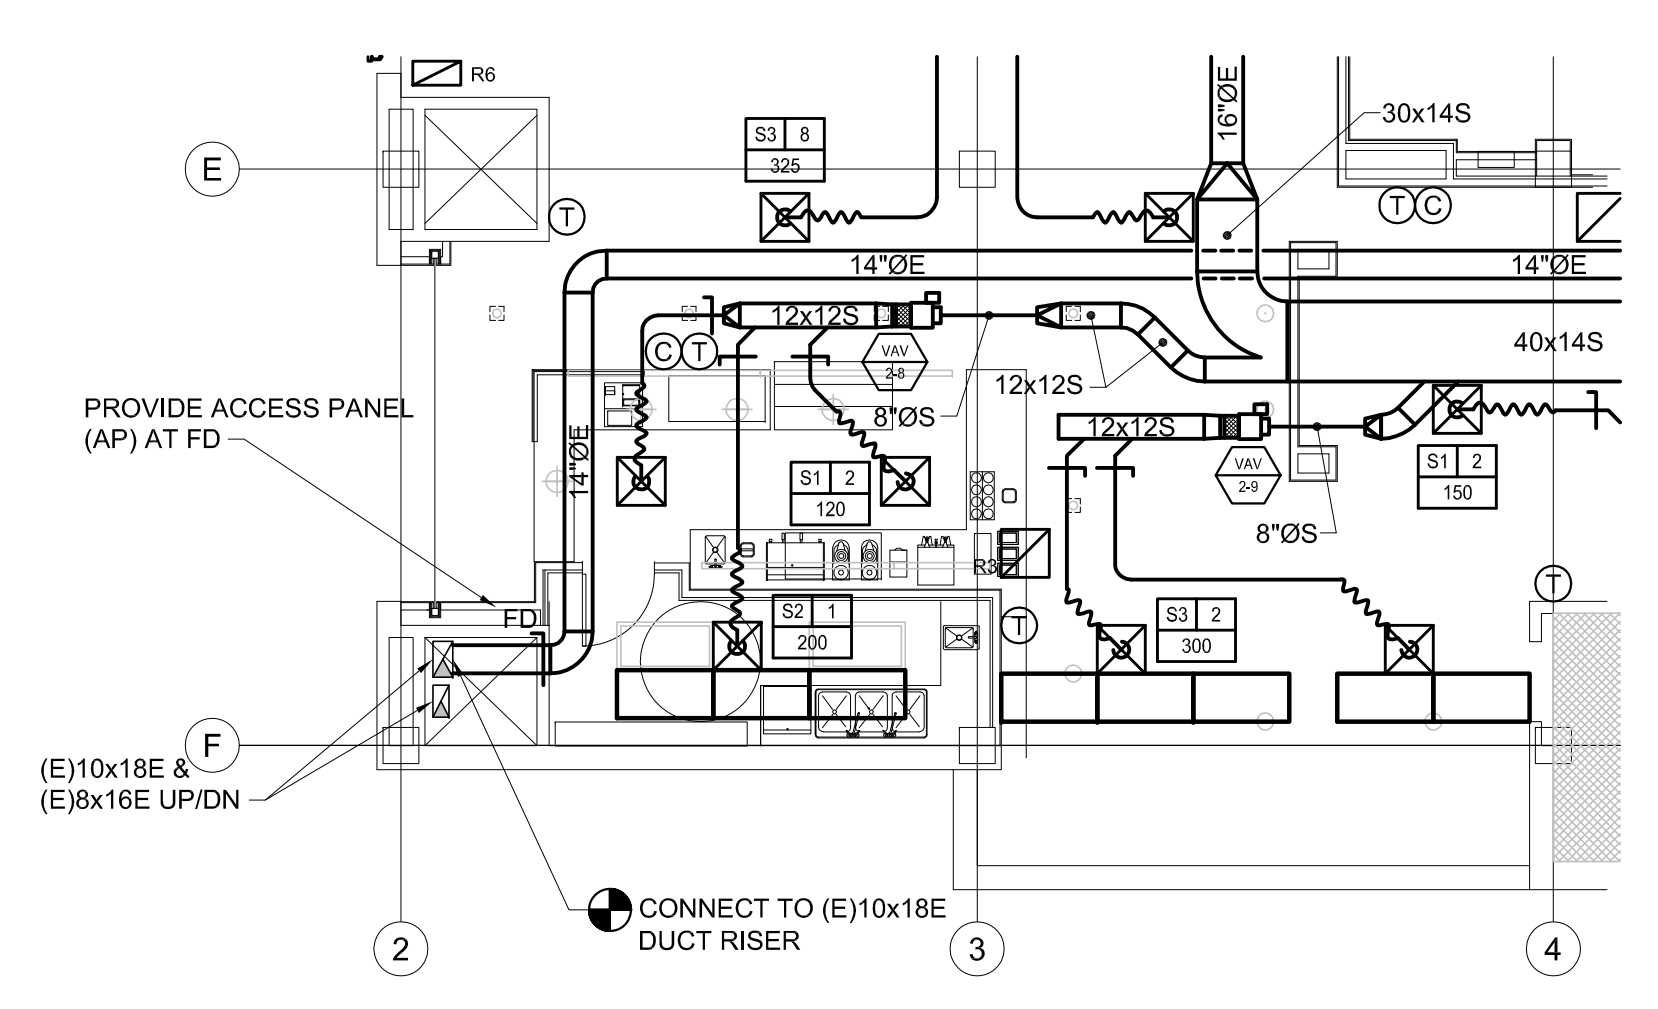

A1 MECHANICAL PART PLAN ~ MAIN LEVEL - ALTERNATE No. 1  
1/8" = 1'-0"

	PROJECT <b>Portland Public Library Renovation</b>
	PORTLAND, ME
<p>THIS DRAWING IS THE PROPERTY OF SCOTT SIMONS ARCHITECTS AND IS NOT TO BE COPIED OR REPRODUCED IN PART OR WHOLE.</p>	TITLE <b>MECHANICAL PLAN ~ MAIN LEVEL</b>
	STATUS: <b>Issued for Bidding</b>
	DATE: 02-13-2009
	SCALE: As Noted
	PROJECT NO. 2008-0030
	DRAWN BY: REW
DWG NO. <b>MH-101</b>	

**Allied Engineering**  
Structural Mechanical Electrical Commissioning

160 Veranda Street  
Portland, Maine 04103  
T: 307.221.2208  
F: 307.221.2266  
Web: www.allied-eng.com

Allied Project No: 08040    Cad File: 08040M.DWG    Checked By: IAM

K:\Project\2008\08040 - Portland Public Library - Phase 1\03 Drawing Files\08040.dwg    Feb 13, 2009 - 12:55pm